


FINISH SCHEDULE LEGEND			
A	CARPET	H	2X2 ACOUSTIC PANEL BLACK
B	VINYL TILE	I	2X2 ACOUSTIC PANEL WHITE
C	RESILIENT BASE	J	CONCRETE
D	CERAMIC TILE	K	1 X 4 PAINTED WOOD
E	PAINTED GYP WALLBOARD	L	PAINTED CONCR. SLAB
F	PAINTED CONCRETE BLOCK	M	CATHEDRAL
G	CERAMIC BASE	N	WOOD

ROOM FINISH SCHEDULE									
NO.	ROOM	FLOOR	BASE	WALLS				CEILING*	
				N	E	S	W	FINISH	HEIGHT
101	OFFICE	A	C	E	E	E	E	H	12'
102	REST ROOM	B	C	E	E	E	E	I	8'
103	MECH. ROOM	B	C	E	E	E	E	I	8'

PLUMBING FIXTURE SCHEDULE			
FIXTURE	LOCATION	MAKE	MODEL

CEILING DETAIL SCHEDULE			
ITEM	TYPE	COLOR/ SIZE	REMARKS/ LOCATION
CEILING TILE	REVEALED EDGE	SEE FINISH SCHEDULE	PURLINS
INSULATION	R-11	3"	

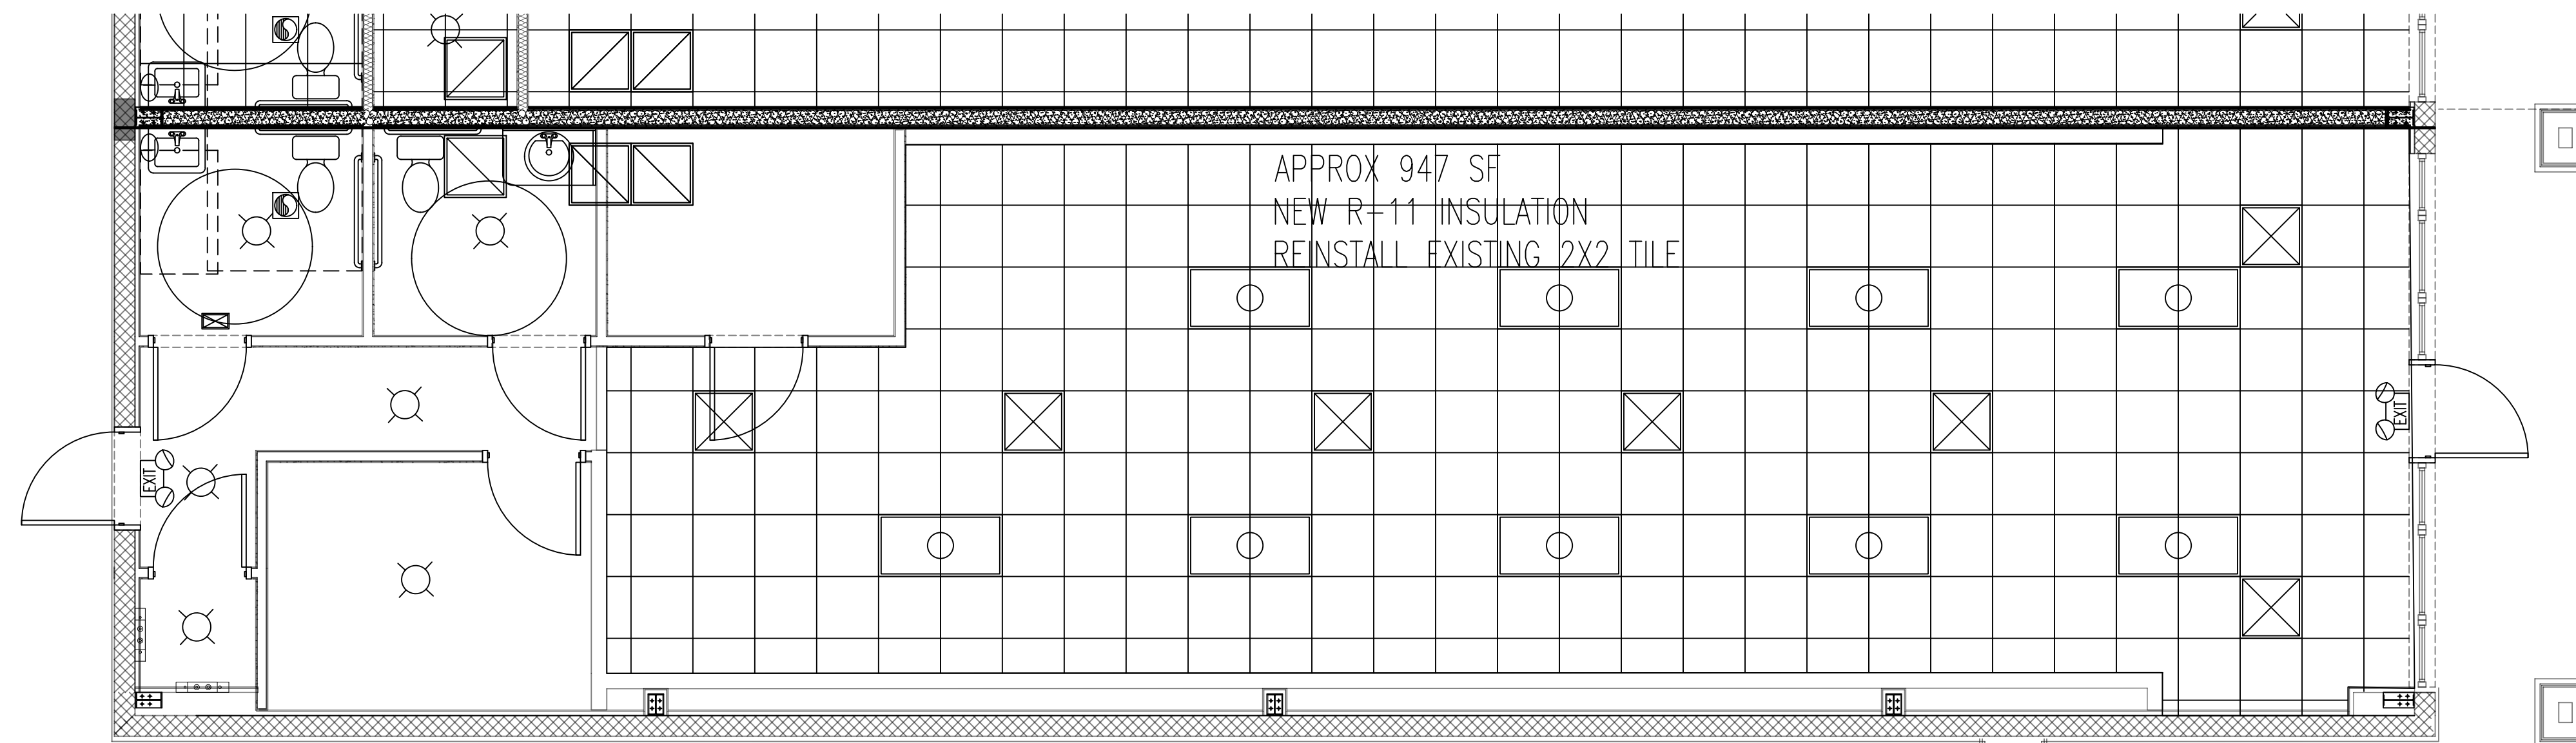

REFLECTIVE CEILING PLAN
 Scale: 1/4" = 1'-0"

DATE	BY	REVISION

RANMAR DEVELOPMENT, INC.
 12645 RACE TRACK ROAD
 TAMPA, FLORIDA 33626
 (813) 854-4486

DATE SIGNED: _____

SCALE: 1/4" = 1'-0"
 DATE: 05/28/26
 DRWN BY: JS
 CHKD BY:
 PROJ. NO.: 555

REFLECTED CEILING PLAN
 ONE STOP SUITE 7
 3784 TAMPA ROAD, SUITE 7
 OLDSMAR, FLORIDA 34677

SHEET
A4