


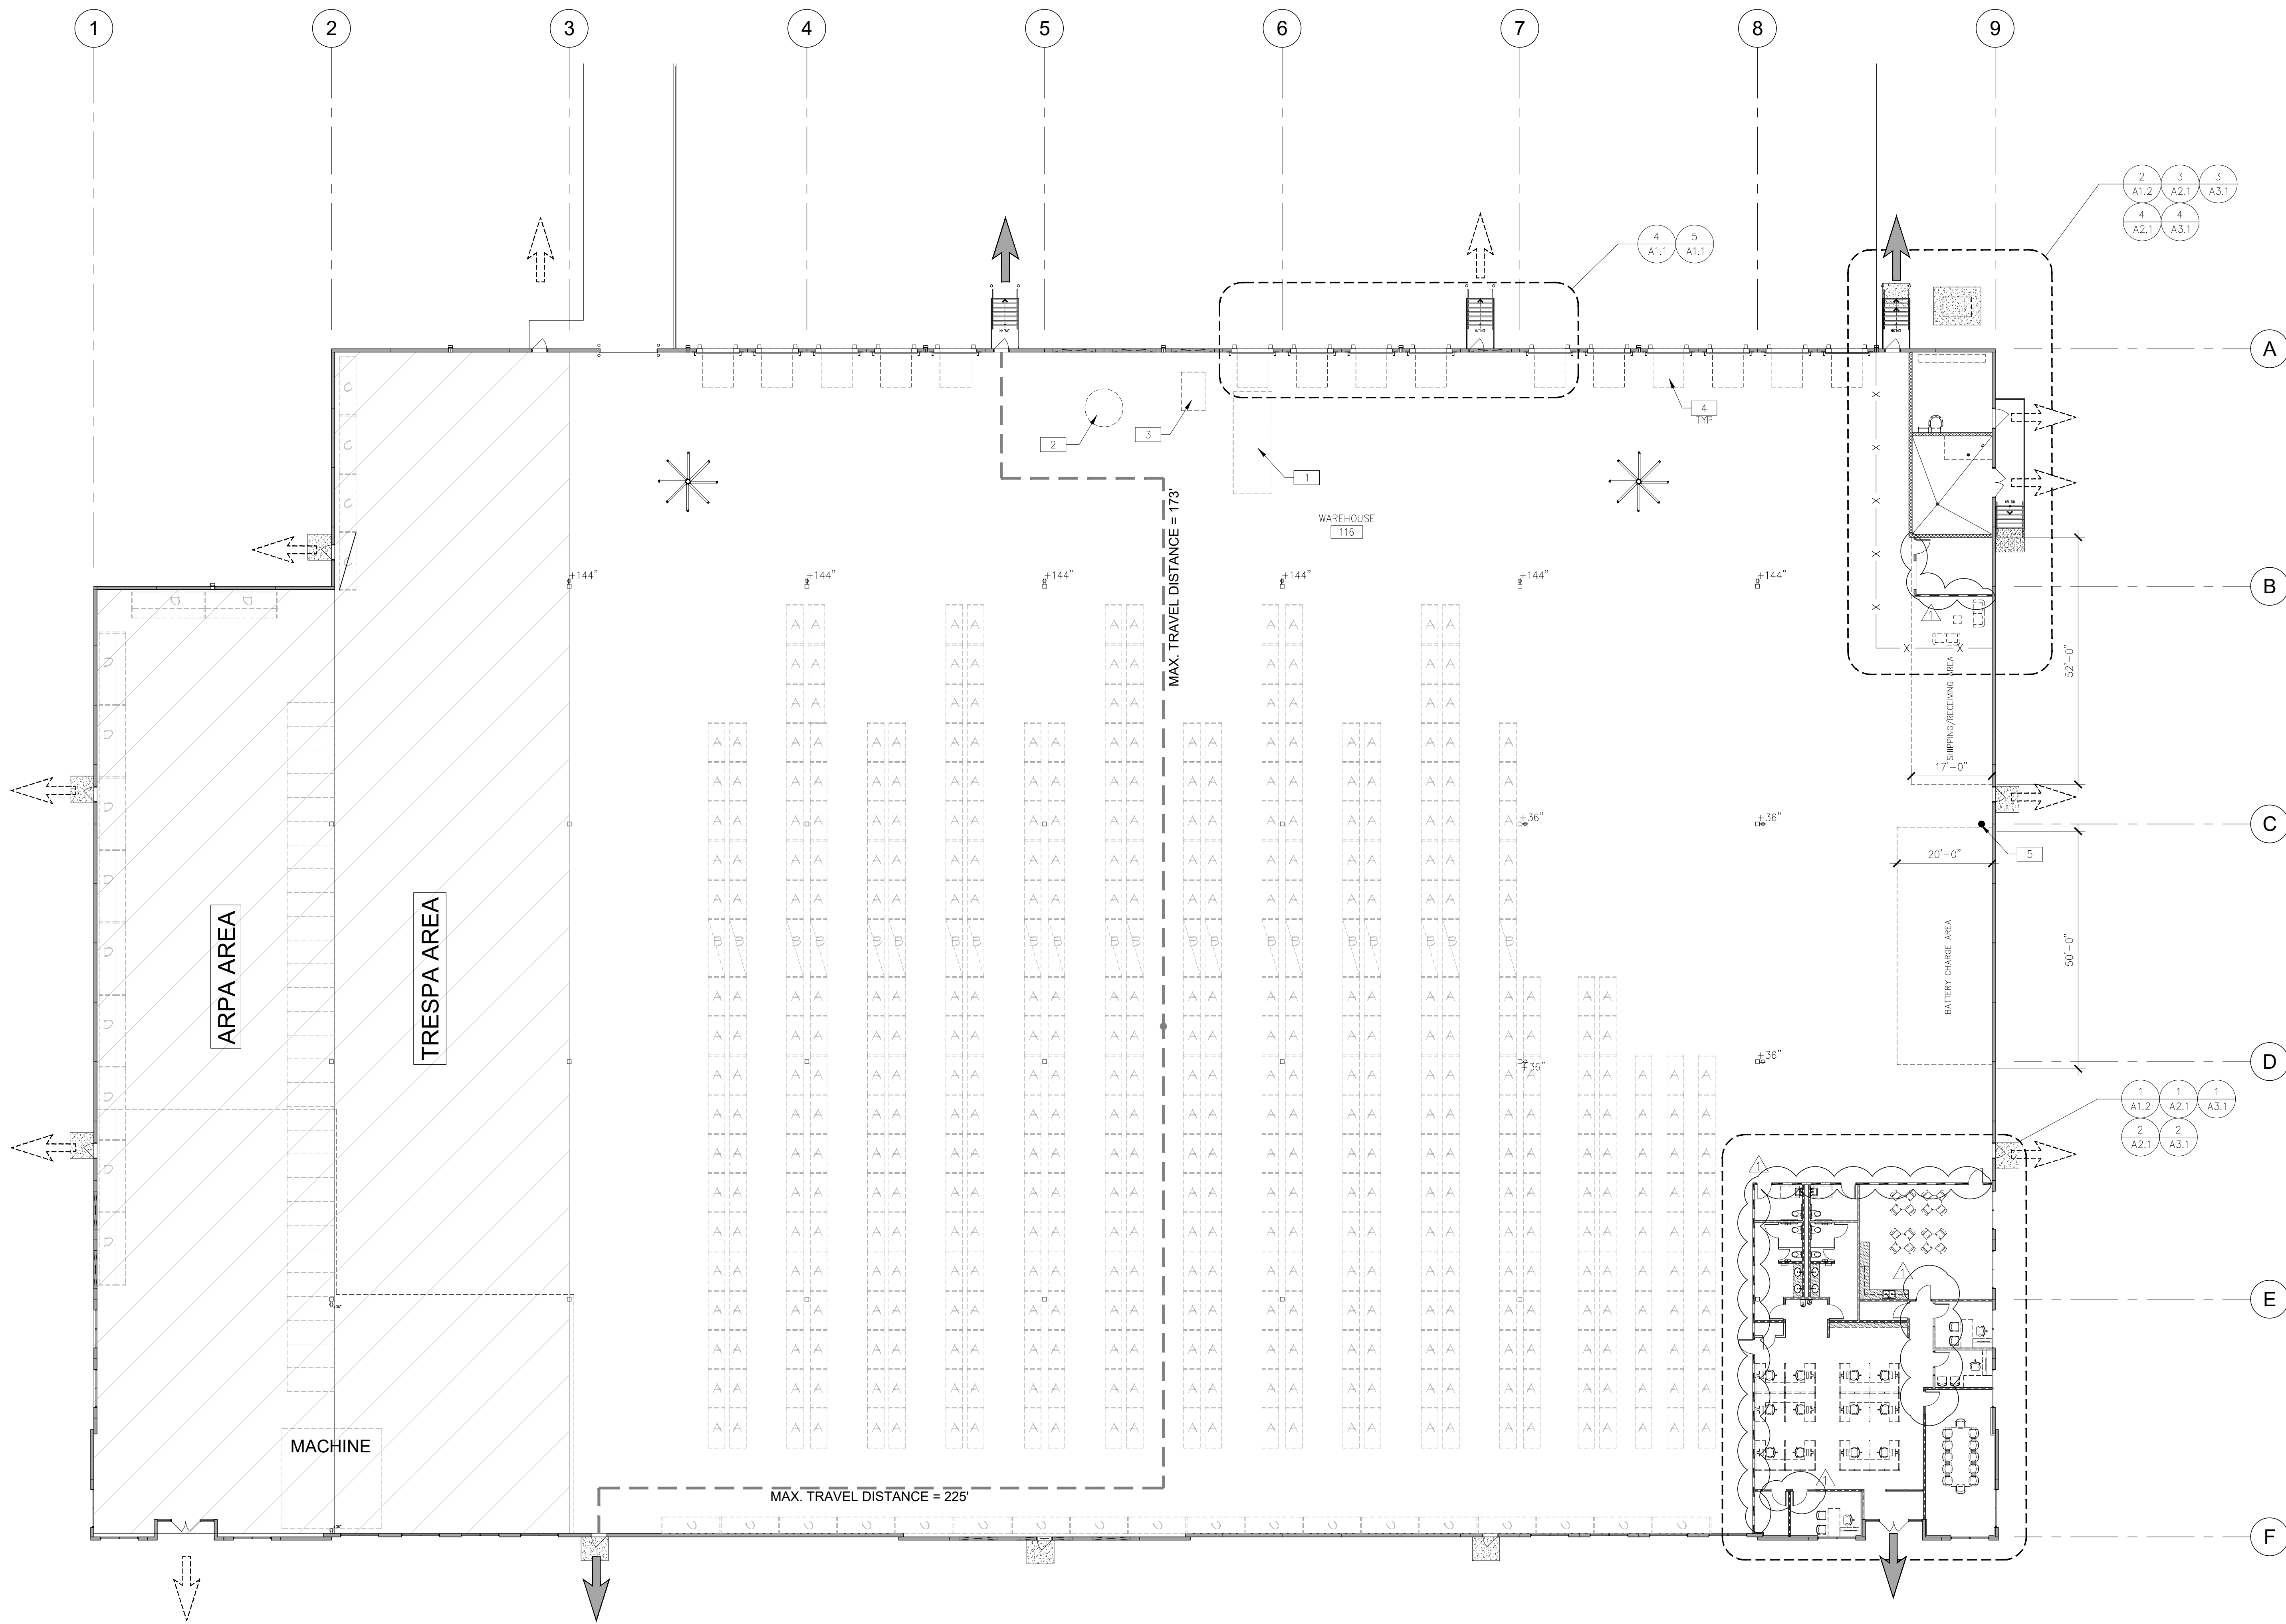

FLOOR NOTES

- 1 TRASH COMPACTOR.
- 2 SHRINK WRAP MACHINE.
- 3 SCALE.
- 4 EXISTING DOCK DOORS TO REMAIN.
- 5 HOSE BIB.

LEGENDS

OCCUPANCY & EGRESS LEGEND

- REQUIRED EXIT.
- EXISTING EXIT.

POWER AND SIGNAL LEGEND

- 110v. DUPLEX RECEPTACLE, MOUNTED VERTICALLY AT +18" A.F.F., U.O.N.
- "C" DESIGNATES RECESSED TYPE SOCKET.

OVERALL FLOOR PLAN

SCALE: 1/16"=1'-0"

1

CONSULTING ENGINEERS / DESIGN BUILDERS

SMITHROBERTS & ASSOCIATES, INC.
601 BLUFF ROAD
PO BOX 100
POVERTOWN PA 18123-0100
PH 317-961-1043 www.sraeng.com

PLUMBING: _____
HVAC: _____
ELECTRICAL: _____

CONTRACTOR

ARCO
DESIGN/BUILD NE

WARE MALCOMB
DESIGN/BUILD NE

ARCHITECT

WARE MALCOMB
DESIGN/BUILD NE

PROJECT FOR:

EXETER
PROPERTY GROUP

BIG BOX COMMERCE, A, LLC

BLOCK 120.1, LOT 5.28
BURLINGTON TOWNSHIP, BURLINGTON COUNTY, NEW JERSEY

JOB NO: NE 179
DRAWN BY: S.R.
ISSUED: 05/11/2018

REVISIONS

05/11/2018
ISSUE FOR PERMIT
06/19/2018
CLIENT REVISIONS

SHEET NUMBER

A1.0