



1 ENLARGED HANDICAP MENS/WOMENS BATHROOM PLAN  
1/2" = 1'-0"

**ACCESSORY SCHEDULE**


A. Toilet Paper Holder	Vertiv Tork 56TR Joseph.Smolinski@vertivcorp.com Office: 717-612-6165 Fax: 717-612-6120 GC Supplied, GC Installed	F. Soap Dispenser	Vertiv GO-JO FMX-12 Dispenser Model #GOJ 5150-06 (Color Gray) Joseph.Smolinski@vertivcorp.com GC supplied, GC installed
B. Framed Mirrors	Bobrick Model No. B-165, 18 by 30 inches GC supplied, GC installed	G. Toilet Seat Cover Dispenser	Bobrick Model No. B-221 Surface Mounted GC supplied, GC installed
C. Grab Bars	Bobrick Model No. B-5806.99 by 18,36,42 inches Bobrick Model No. B-5806.99 by 18,36,36 inches Bobrick Model No. B-5806.99 by 18,36,18 inches GC supplied, GC installed	H. Paper Towel Dispenser	Vertiv Tork 87T Joseph.Smolinski@vertivcorp.com Office: 717-612-6165 Fax: 717-612-6120 GC Supplied, GC Installed
D. Changing Stations	Horizontal Diaper Depot Safety - Strap Co., Inc Color: Ivory - Model DD2300 - Rite Aid Info@saferstrap.com or 800-356-7796 GC supplied, GC installed	I. Hand Dryers ADA Recess Kit	American Dryer, Inc. Model No. ADA-RK Recess Kit GC Supplied, GC Installed Keith Vanderbilt keith@restroomremodels.com Restroom Remodels Company Direct 617.500.2554 Fax 617.845.0350
E. Electric Hand Dryers	American Dryer, Inc. Model No. eXtremeAir GXT9-SS GC supplied, GC installed Keith Vanderbilt keith@restroomremodels.com Restroom Remodels Company Direct 617.500.2554 Fax 617.845.0350		

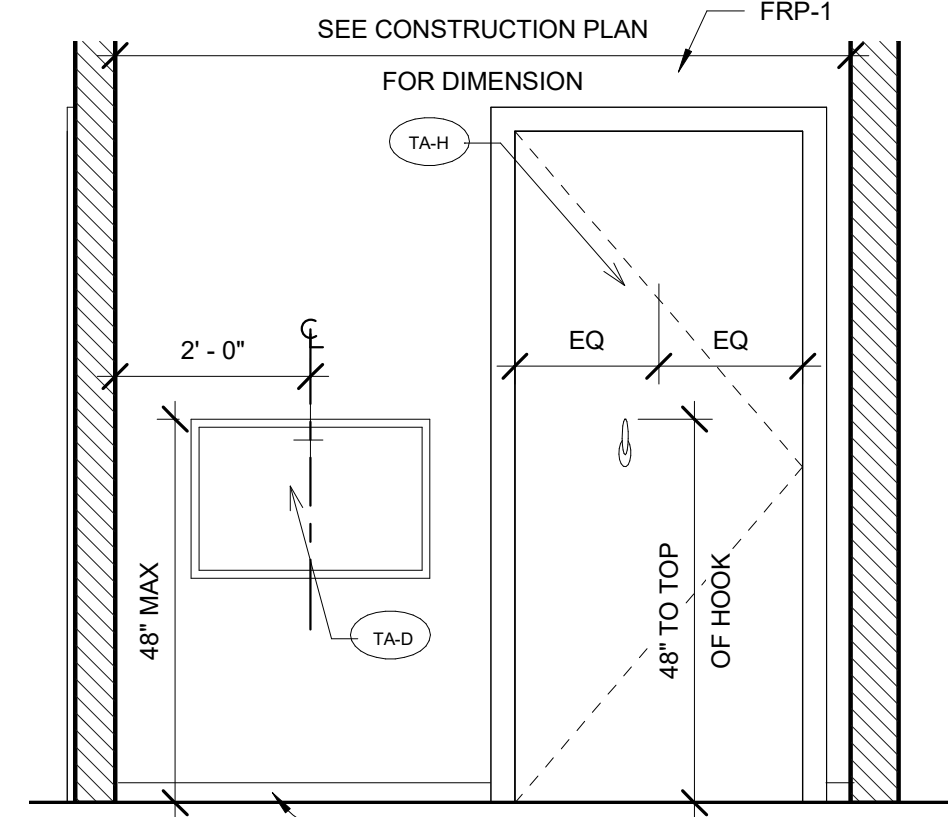


3 MENS HANDICAP BATHROOM ELEVATION 3  
1/2" = 1'-0"

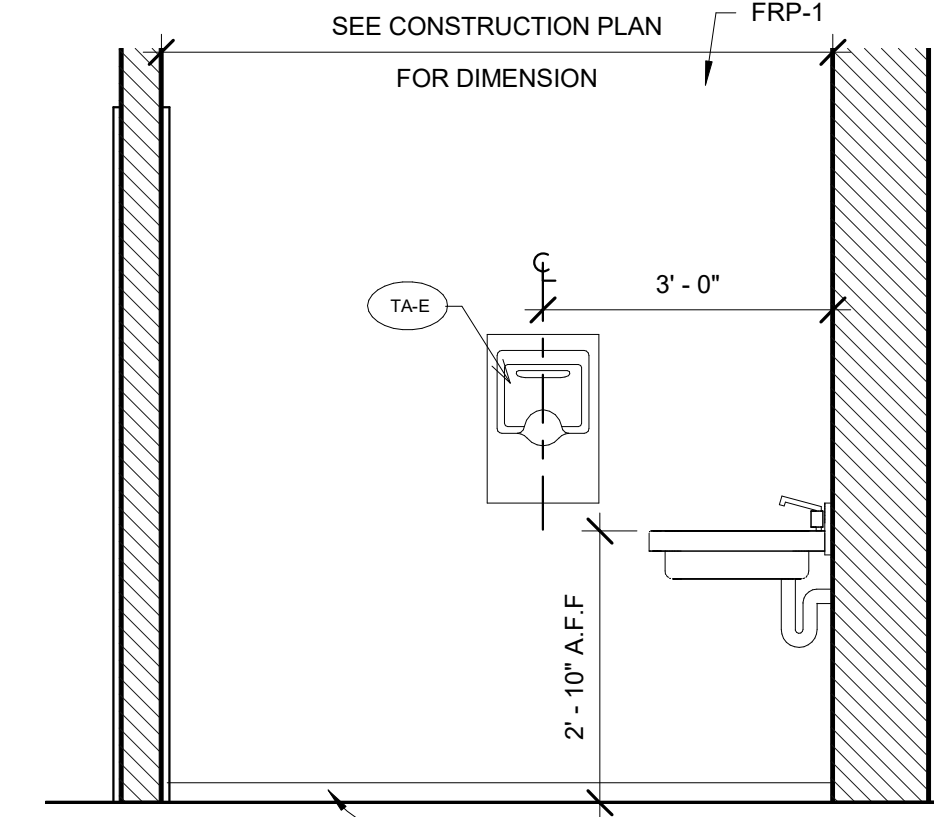


4 MENS HANDICAP BATHROOM ELEVATION 4  
1/2" = 1'-0"

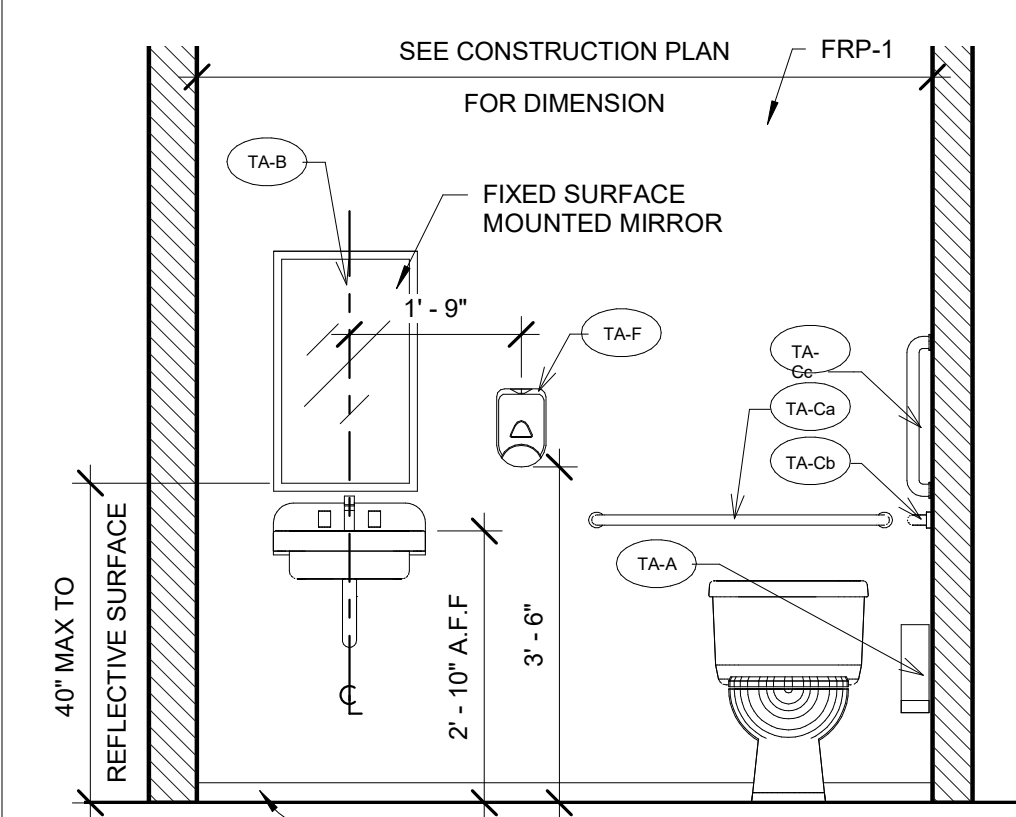


5 MENS HANDICAP BATHROOM ELEVATION 5  
1/2" = 1'-0"

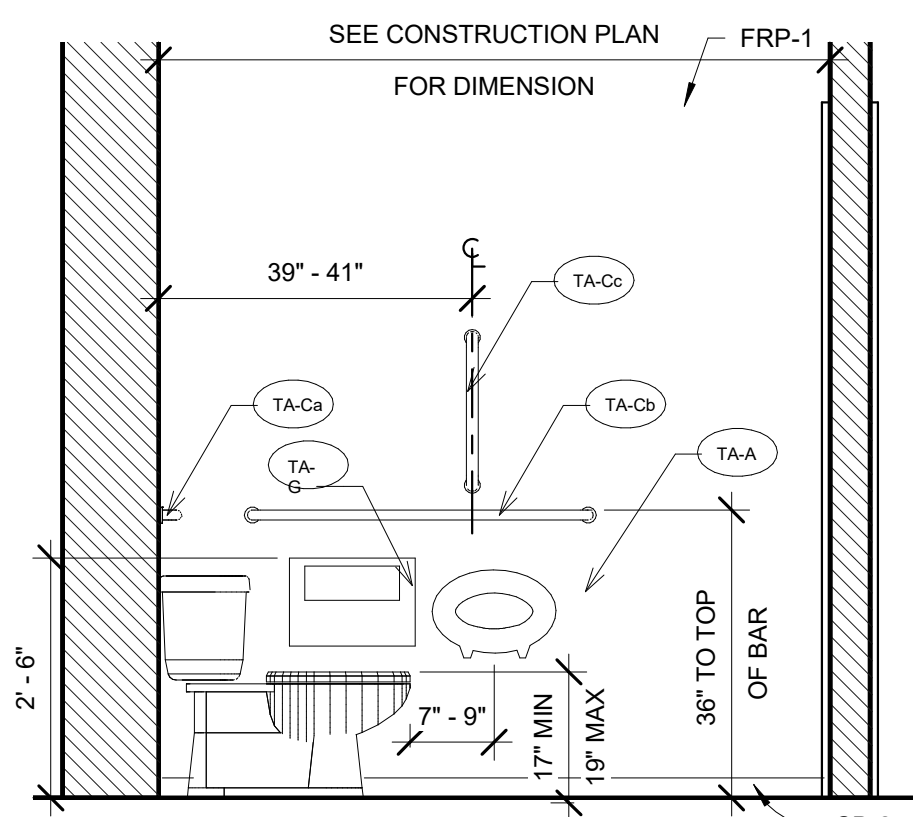


6 MENS HANDICAP BATHROOM ELEVATION 6  
1/2" = 1'-0"

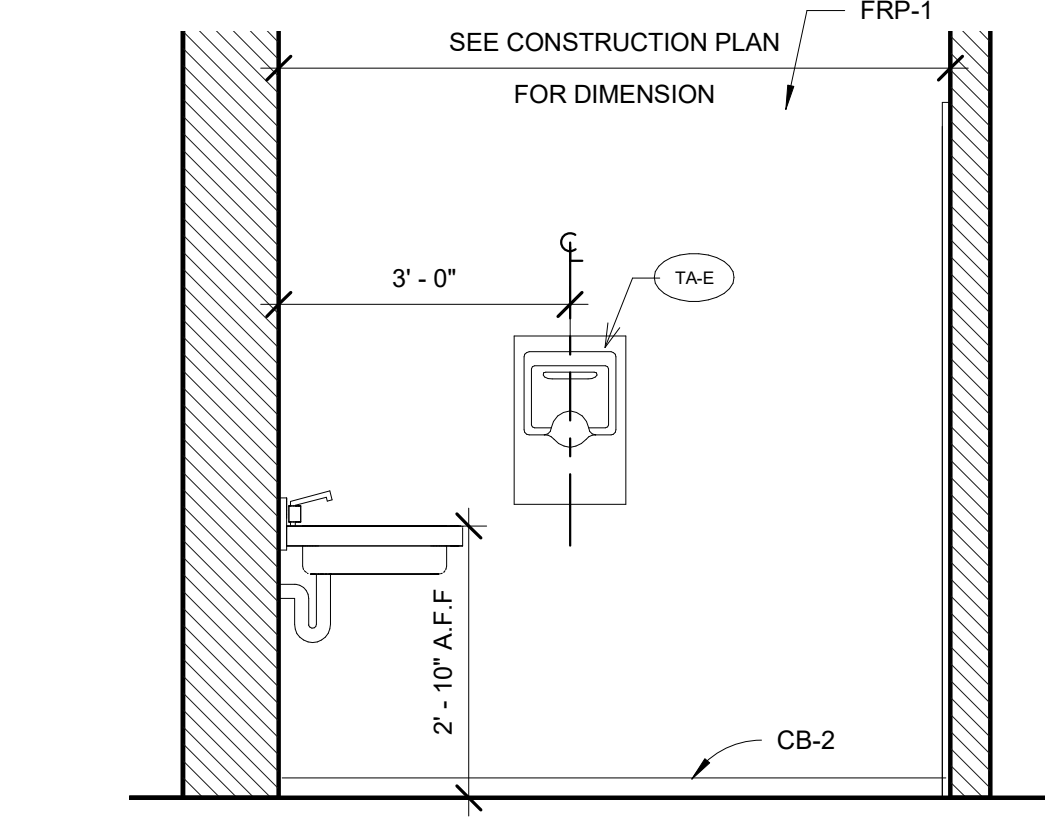


7 WOMENS HANDICAP BATHROOM ELEVATION 7  
1/2" = 1'-0"

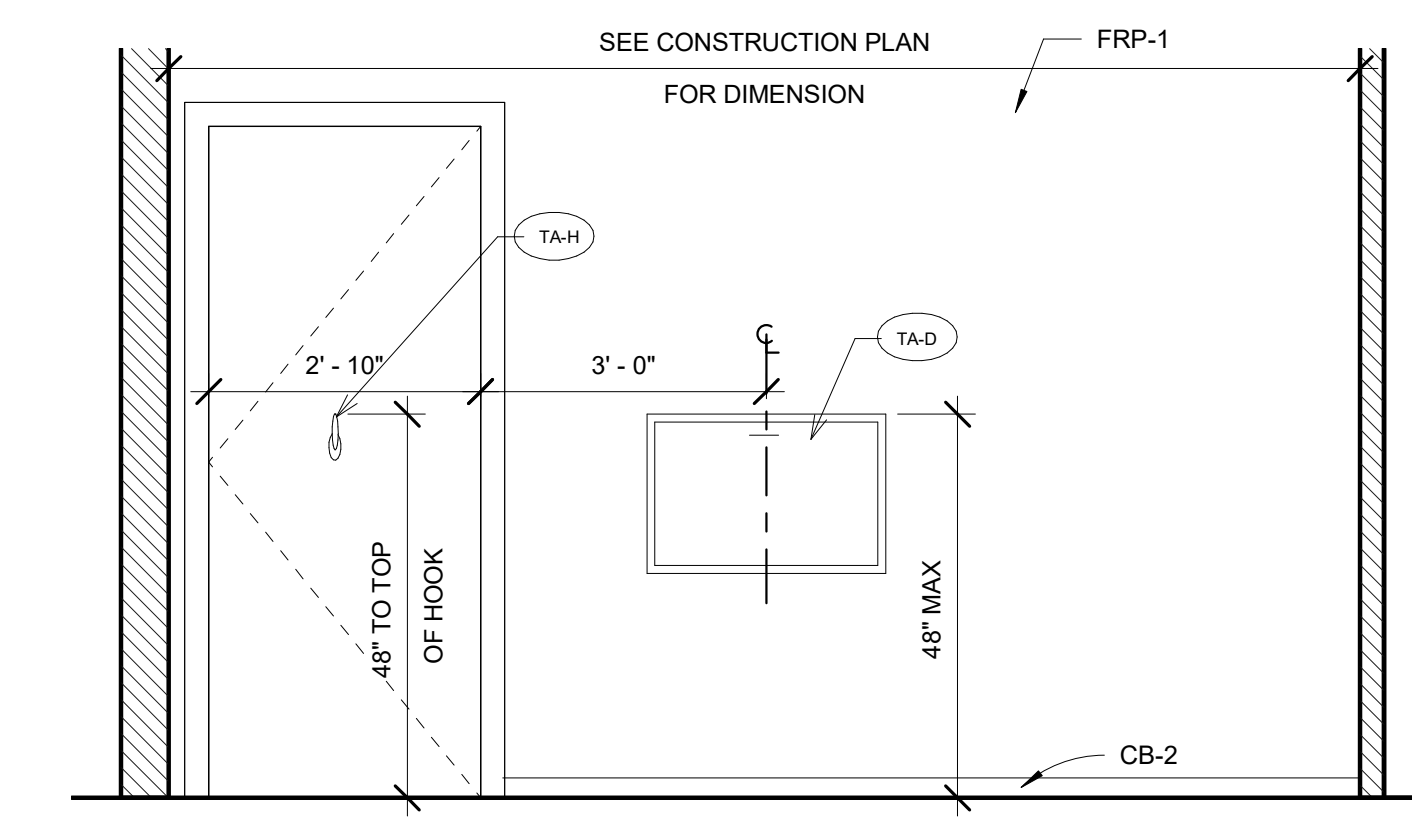

8 WOMENS HANDICAP BATHROOM ELEVATION 8  
1/2" = 1'-0"


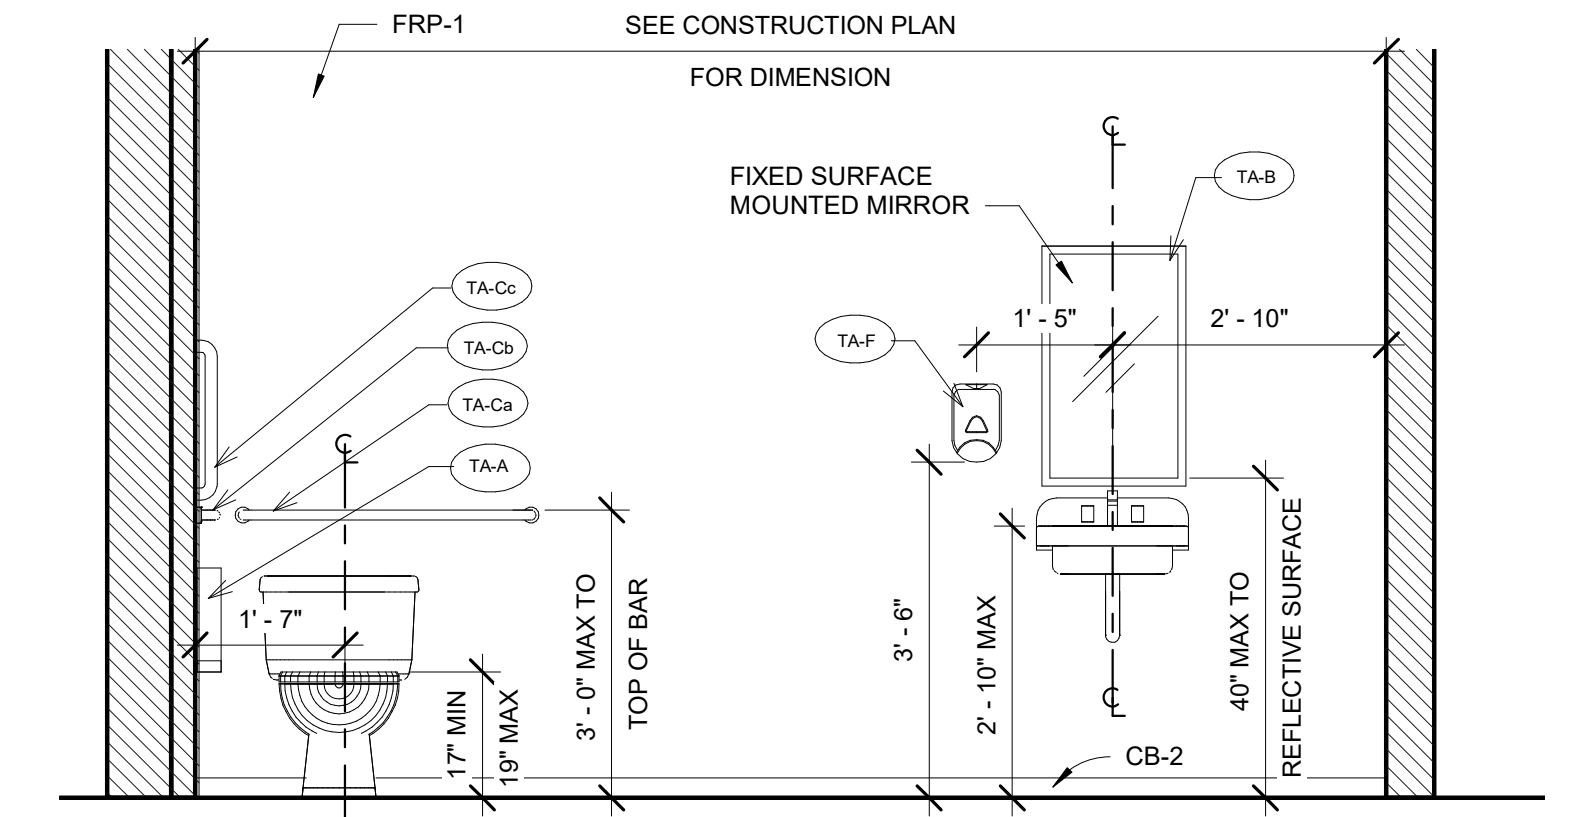


9 WOMENS HANDICAP BATHROOM ELEVATION 9  
1/2" = 1'-0"

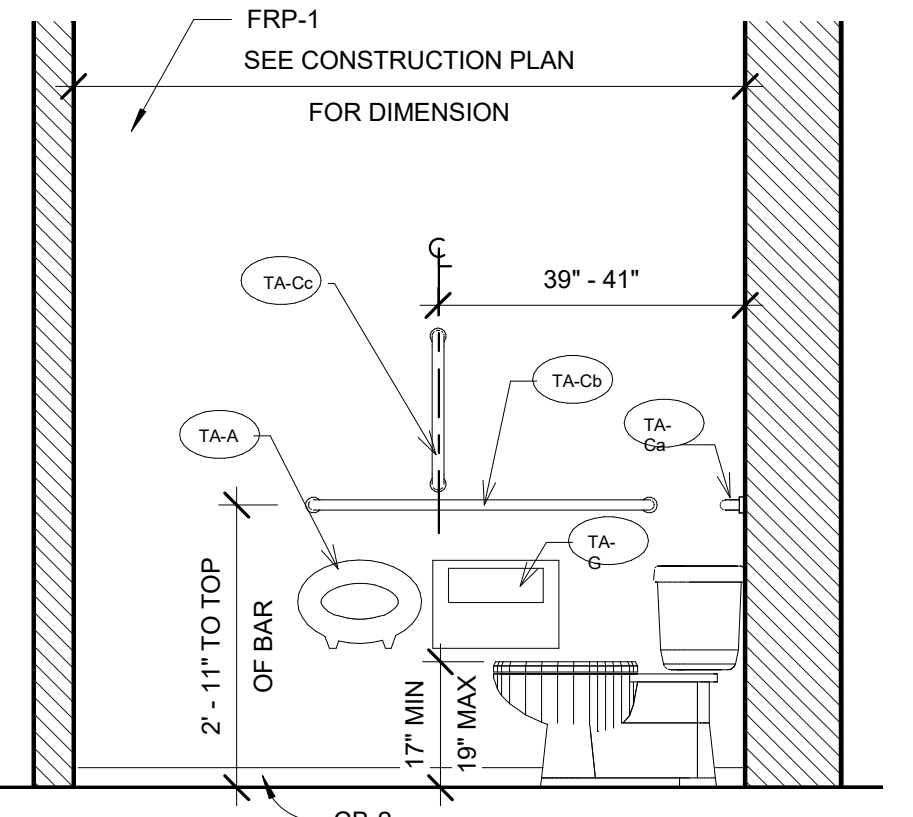

10 WOMENS HANDICAP BATHROOM ELEVATION 10  
1/2" = 1'-0"

- NOTES**
1. CHARACTERS AND SYMBOLS SHALL CONTRAST WITH THEIR BACKGROUND.
  2. IDENTIFICATION SYMBOLS ARE TO BE ON WALL ADJACENT DOOR 20" ABOVE FLOOR AND ARE TO BE DISTINCTLY DIFFERENT FROM DOOR AND WALL IN COLOR AND CONTRAST.
  3. PROVIDE ROOM IDENTIFICATION SIGN ON LATCH SIDE OF DOOR.
  4. LETTERS & NUMBERS ON SIGNS SHALL BE RAISED 1/32" MIN. SHALL BE A MIN. OF 5/8" HIGH & SHALL BE SANS-SERIF UPPERCASE CHARACTERS. A.D.A. SIGNAGE ACCOMPANIED BY GRADE 2 BRAILLE.
  5. REGULATORY SIGNS TO BE TYPICALLY ADA COMPLIANT TACTILE 3-D PLAQUES PER CODE REQUIREMENTS.
  6. SIGNS TO BE A TYPICAL ONE PIECE INJECTION MOLDED FABRICATION WITH RAISED SECOND SURFACE GRAPHICS.
  7. STANDARD ADA SIGN PROVIDED BY RITE AID. MODEL # MEN ADA 304, AND MODEL # WOMEN ADA 305 DIMENSIONS: 4"X9".
  8. BRAILLE SHOWN IS FOR PLACEMENT ONLY. USE CORRECT BRAILLE FOR SIGN PRODUCTION.

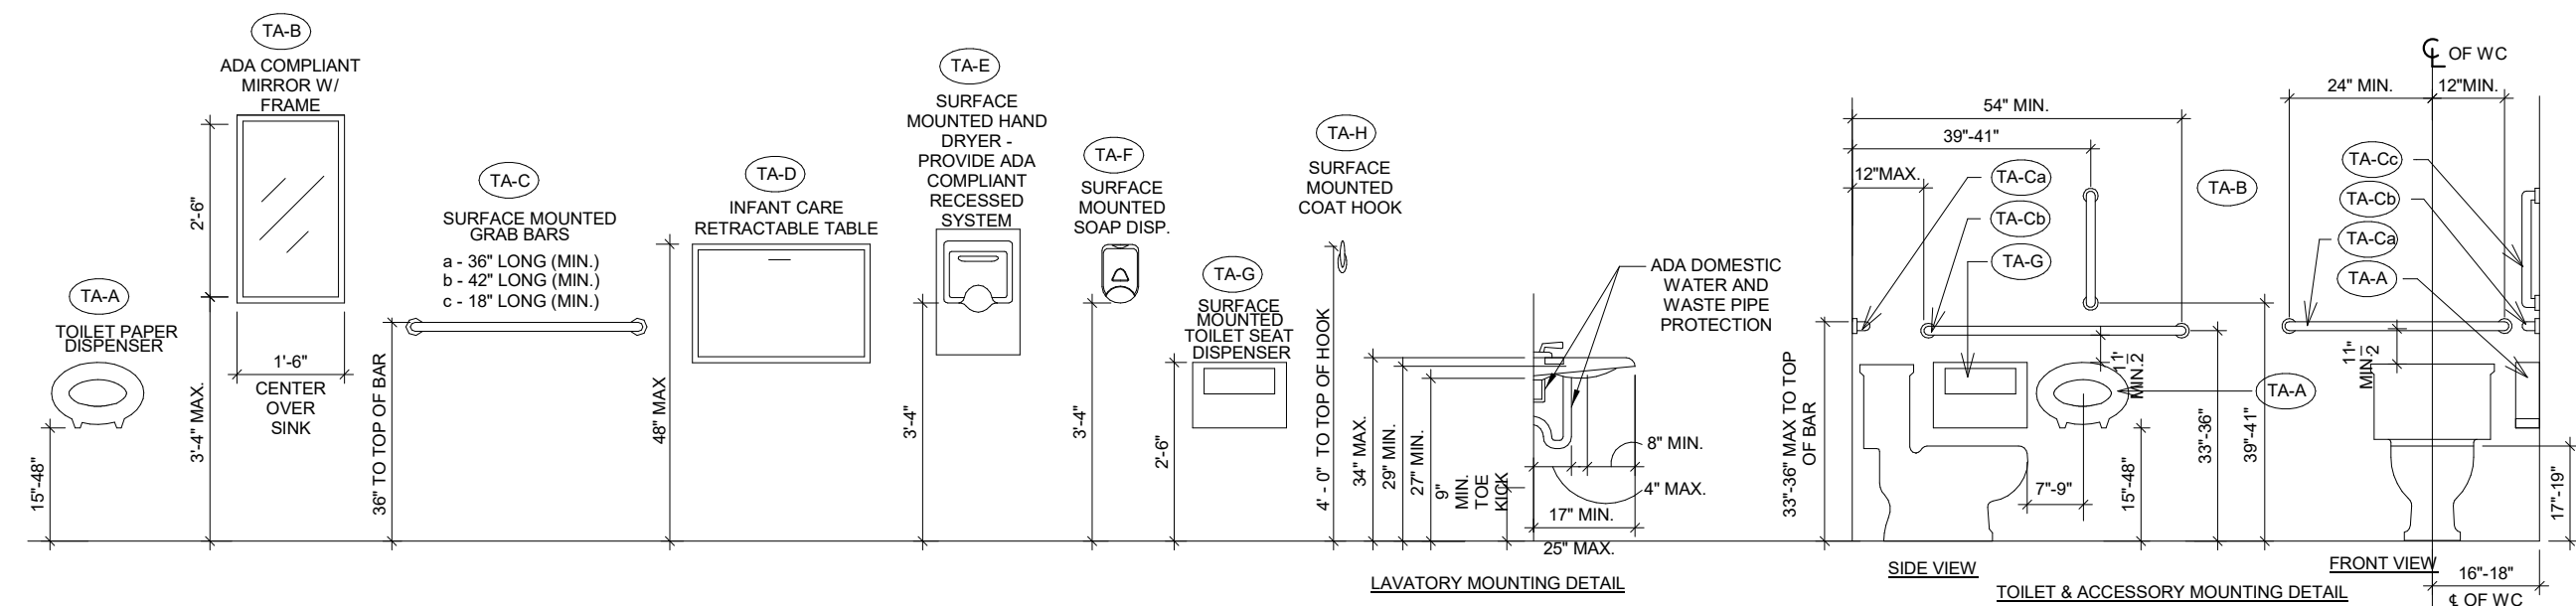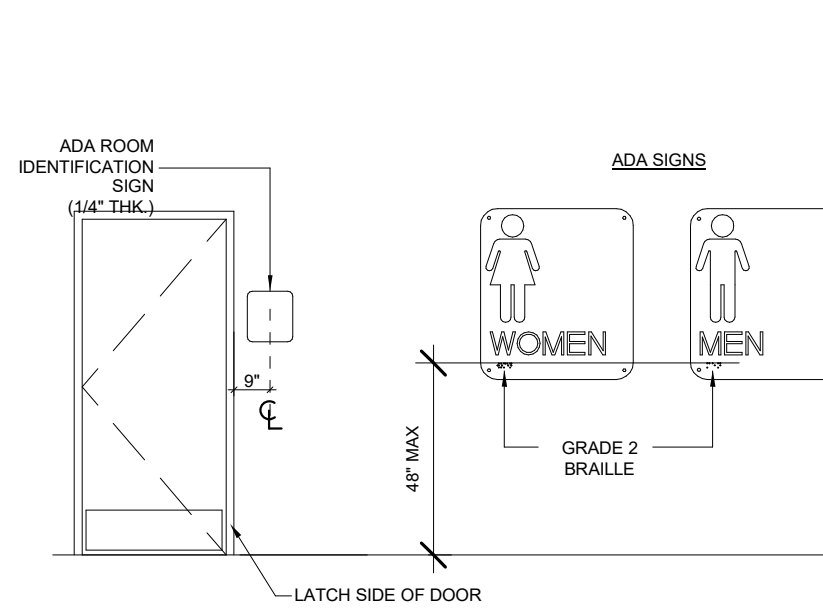


NOTE: LANDLORD TO PROVIDE METAL OR FIRE RETARDANT TREATED WOOD BLOWING AS REQUIRED FOR ALL RESTROOM ACCESSORIES.

**Issues/Revisions:**

No.	Description	Date
9	Revised As Per Tenants Review	11/10/2017

**Key Plan:**

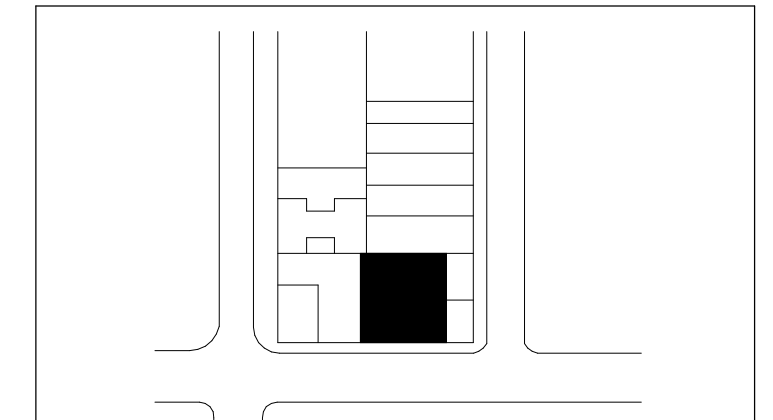

Block: Lot: District: Map:

**DOB Approvals:**

**B Scan Sticker:**

**Project/Building:**

**Rite Aid Store**  
85 Avenue D, New York, NY 10009

**Sheet Title:**

**ENLARGED HANDICAP BATHROOM PLANS & DETAILS**

Seal: Project Number: **1639**  
Date: **3/27/2017**  
Scale: **As indicated**


**A-300.00**











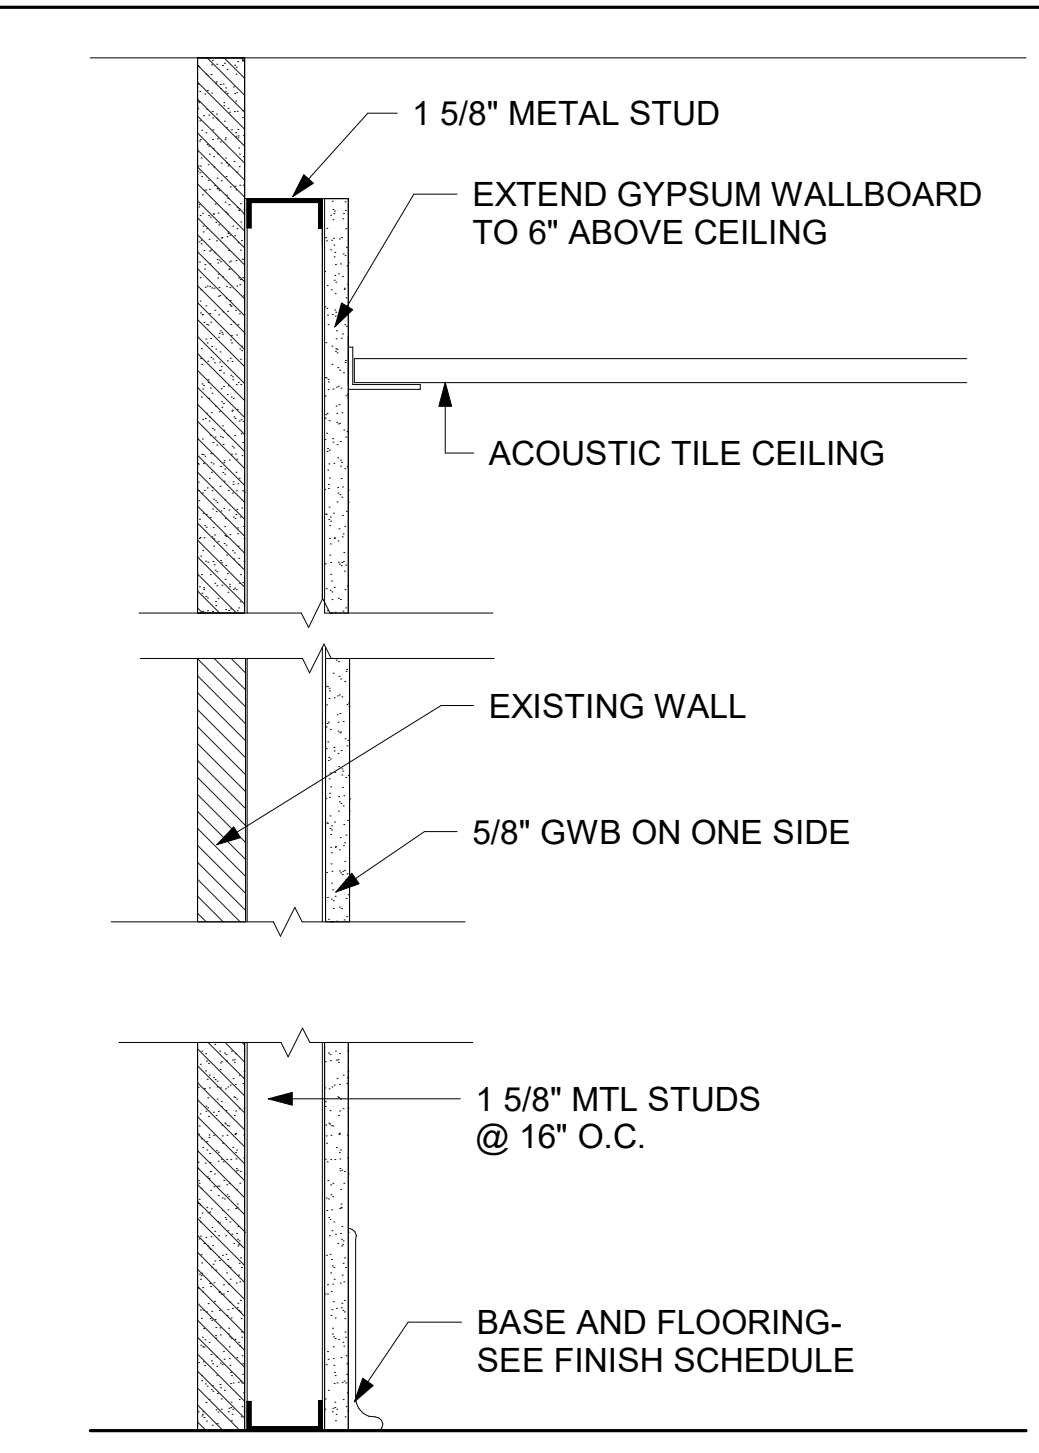


TYPE A

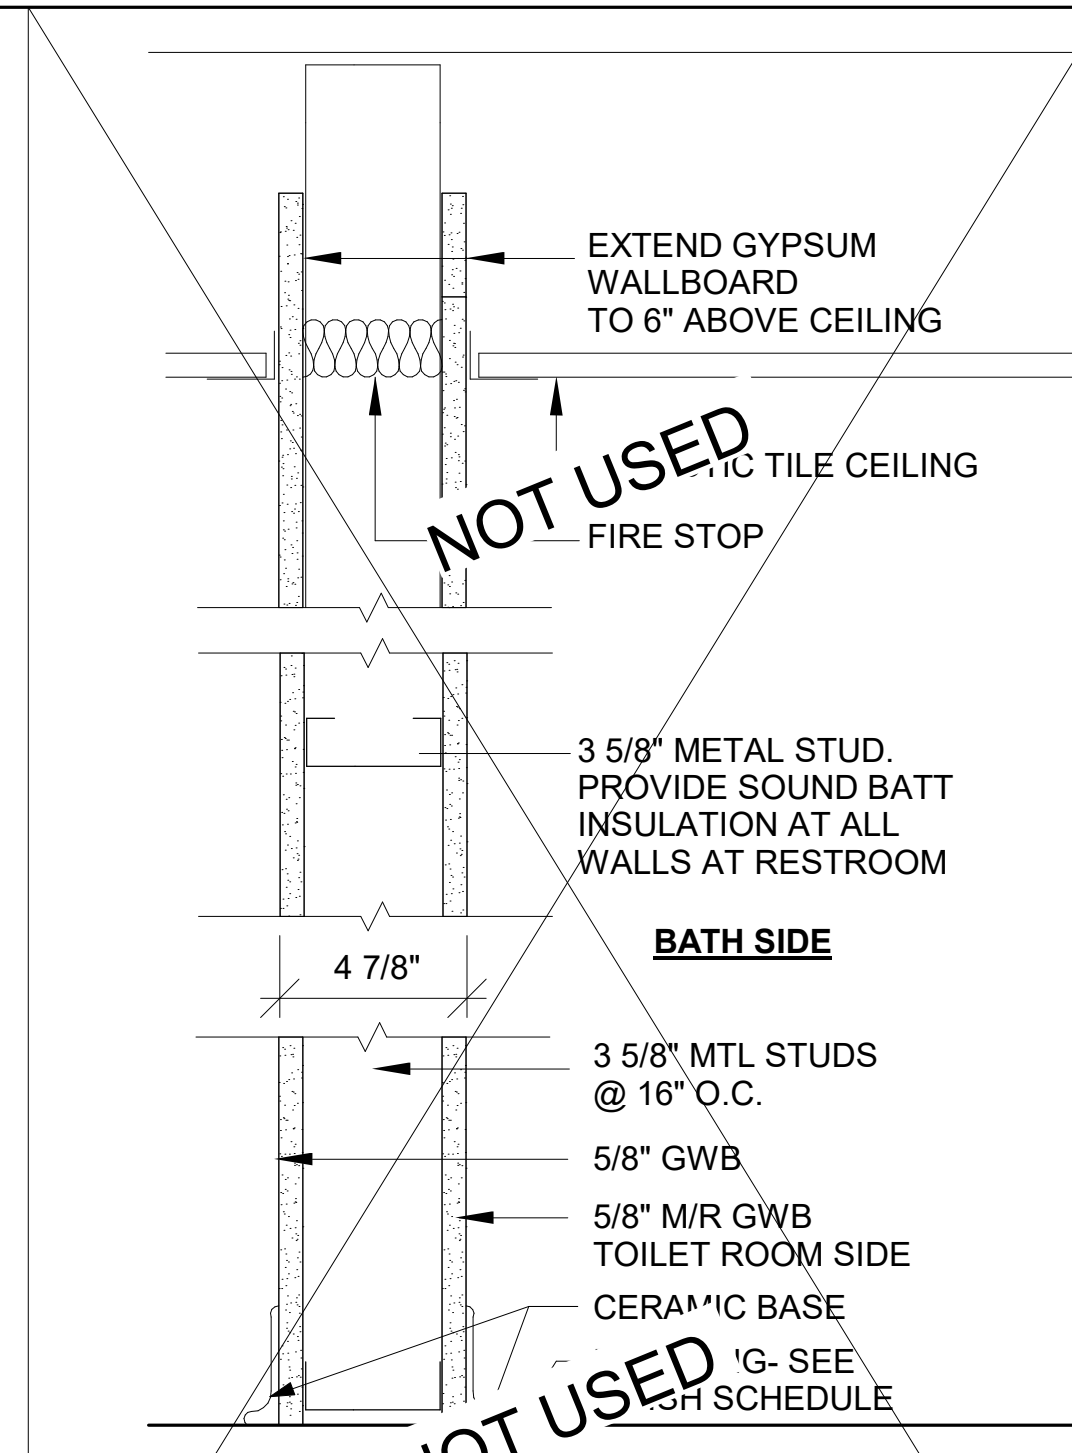


TYPE A1

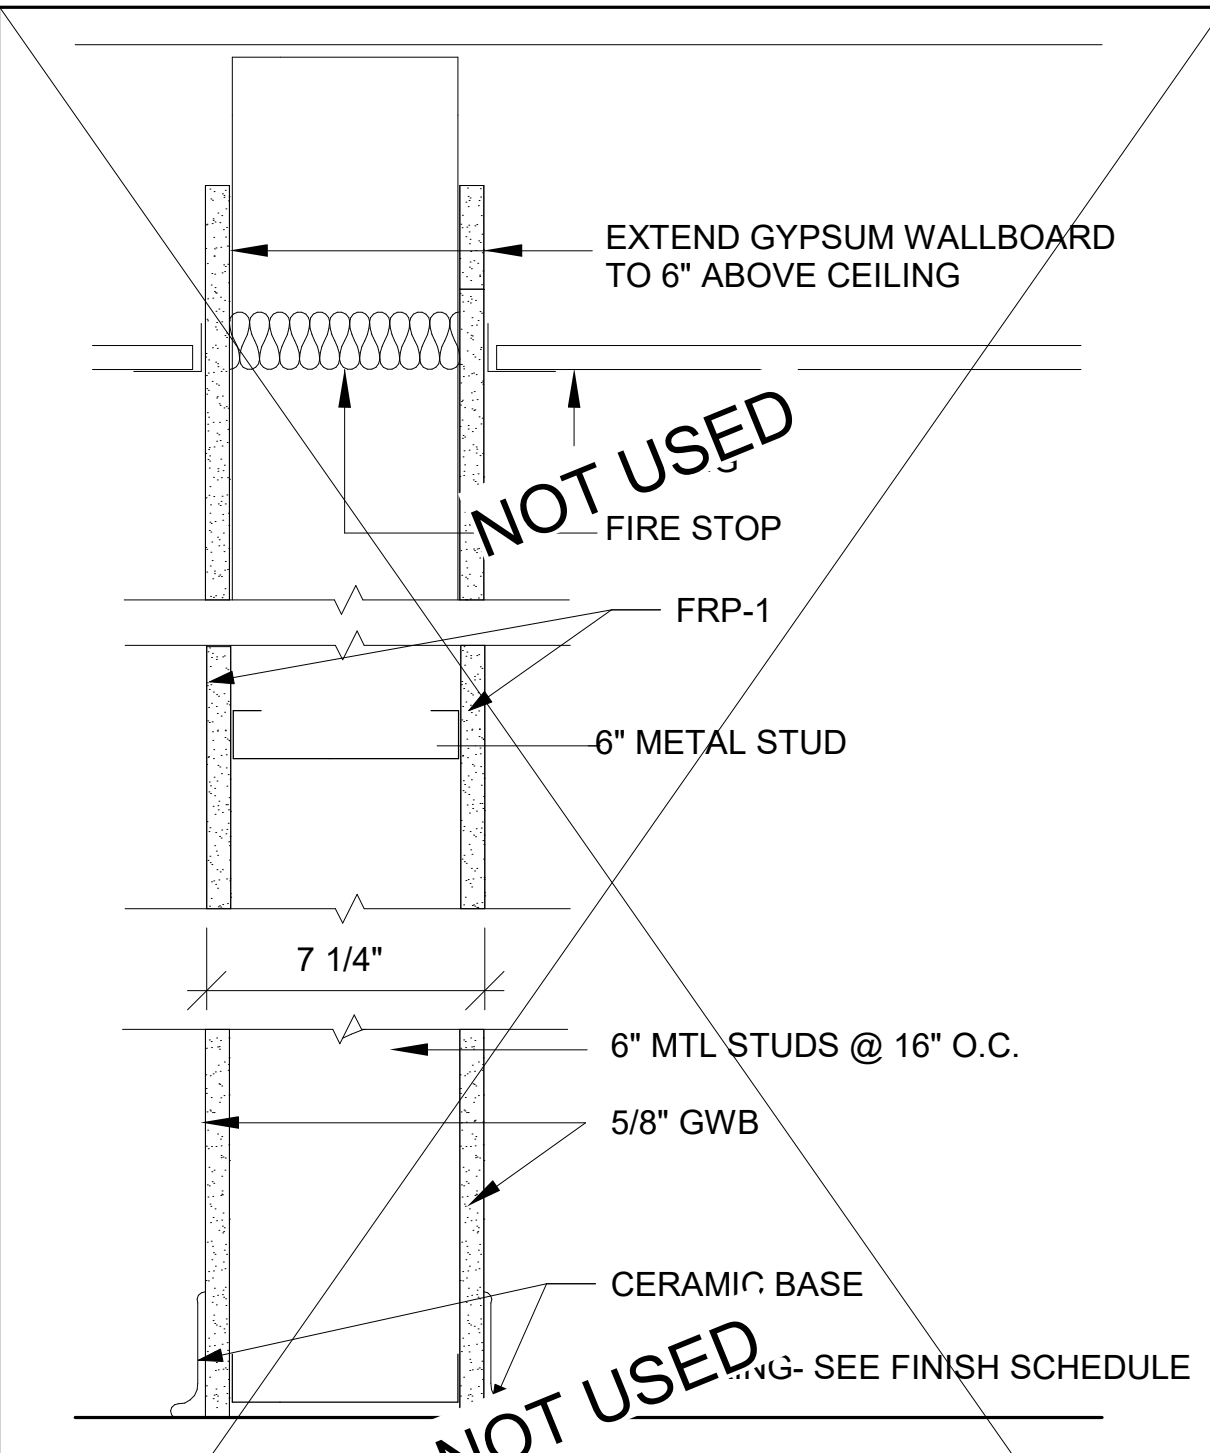


TYPE A2

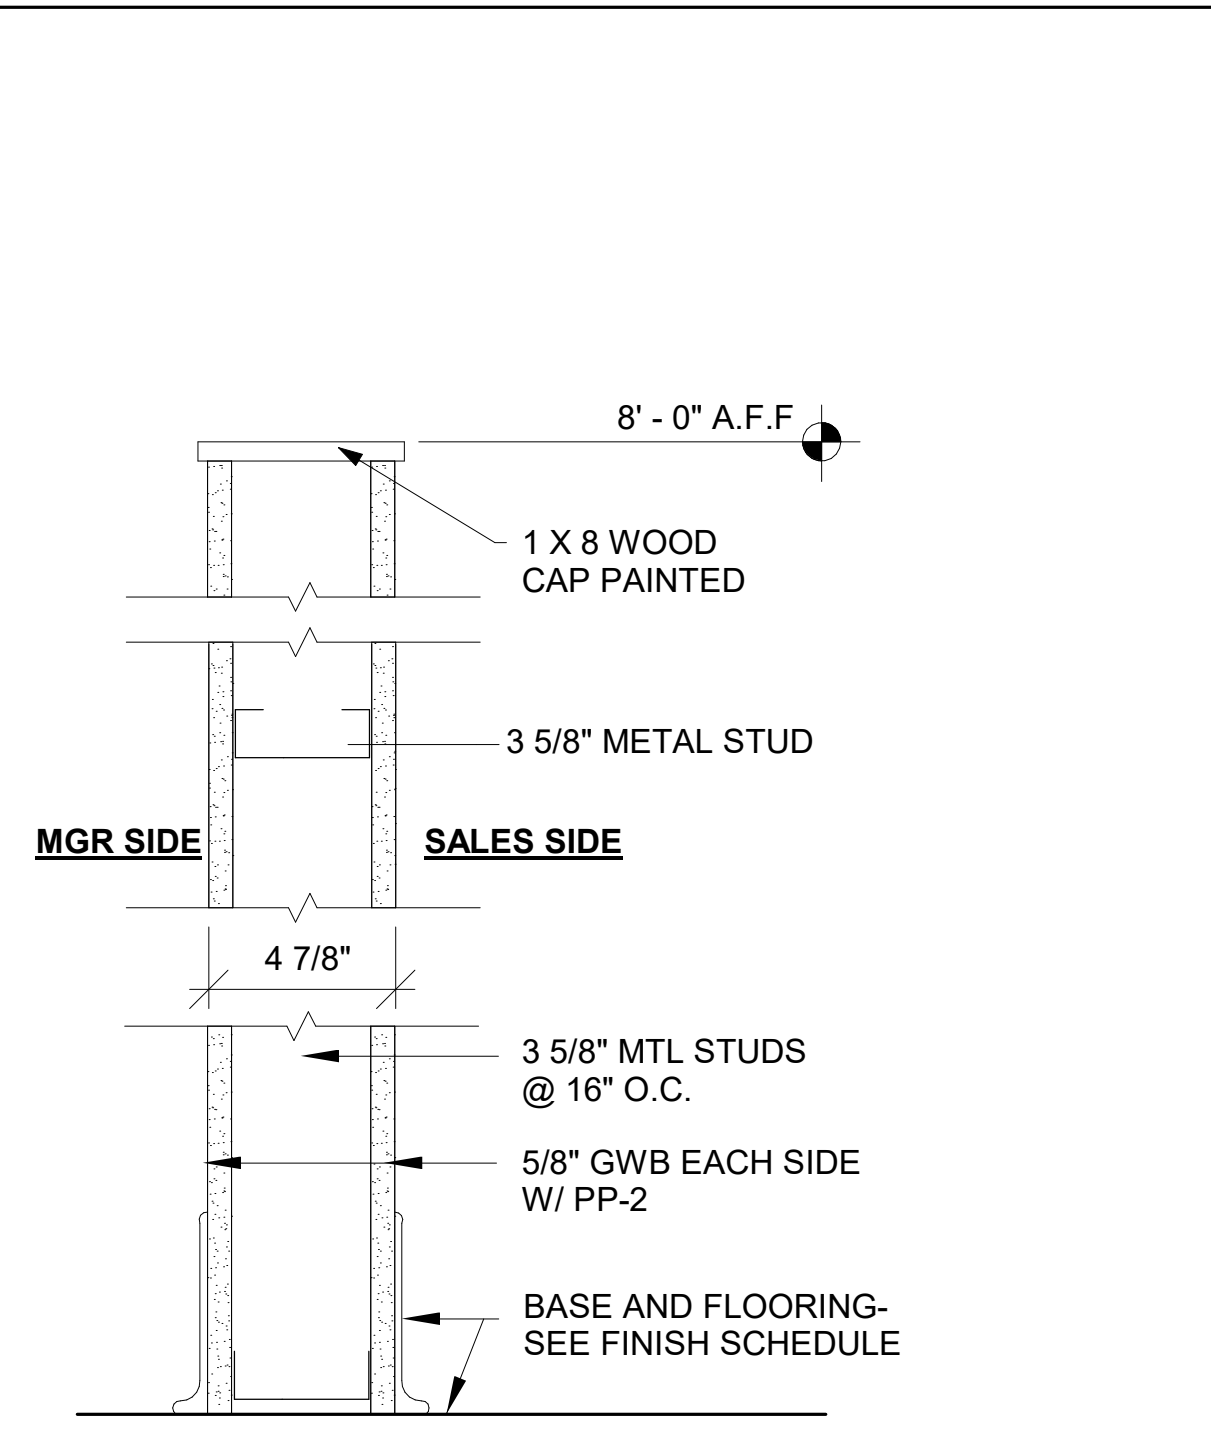


TYPE A4

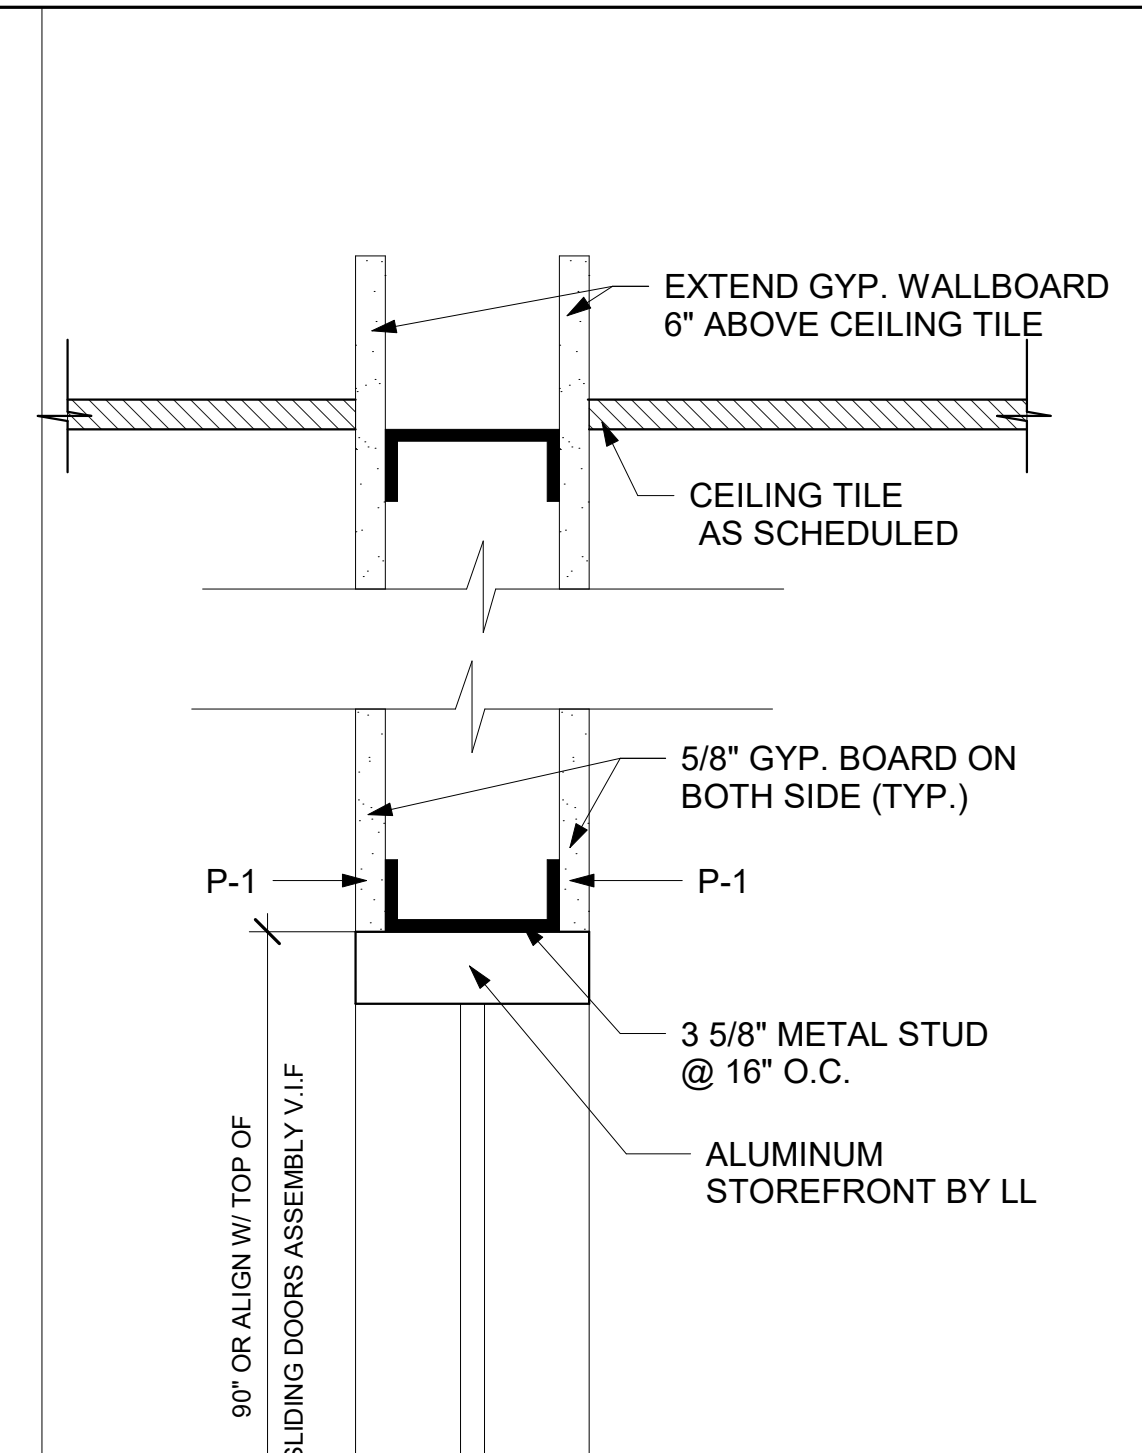


LOW WALL SECTION @ VESTIBULE  
3" = 1'-0"

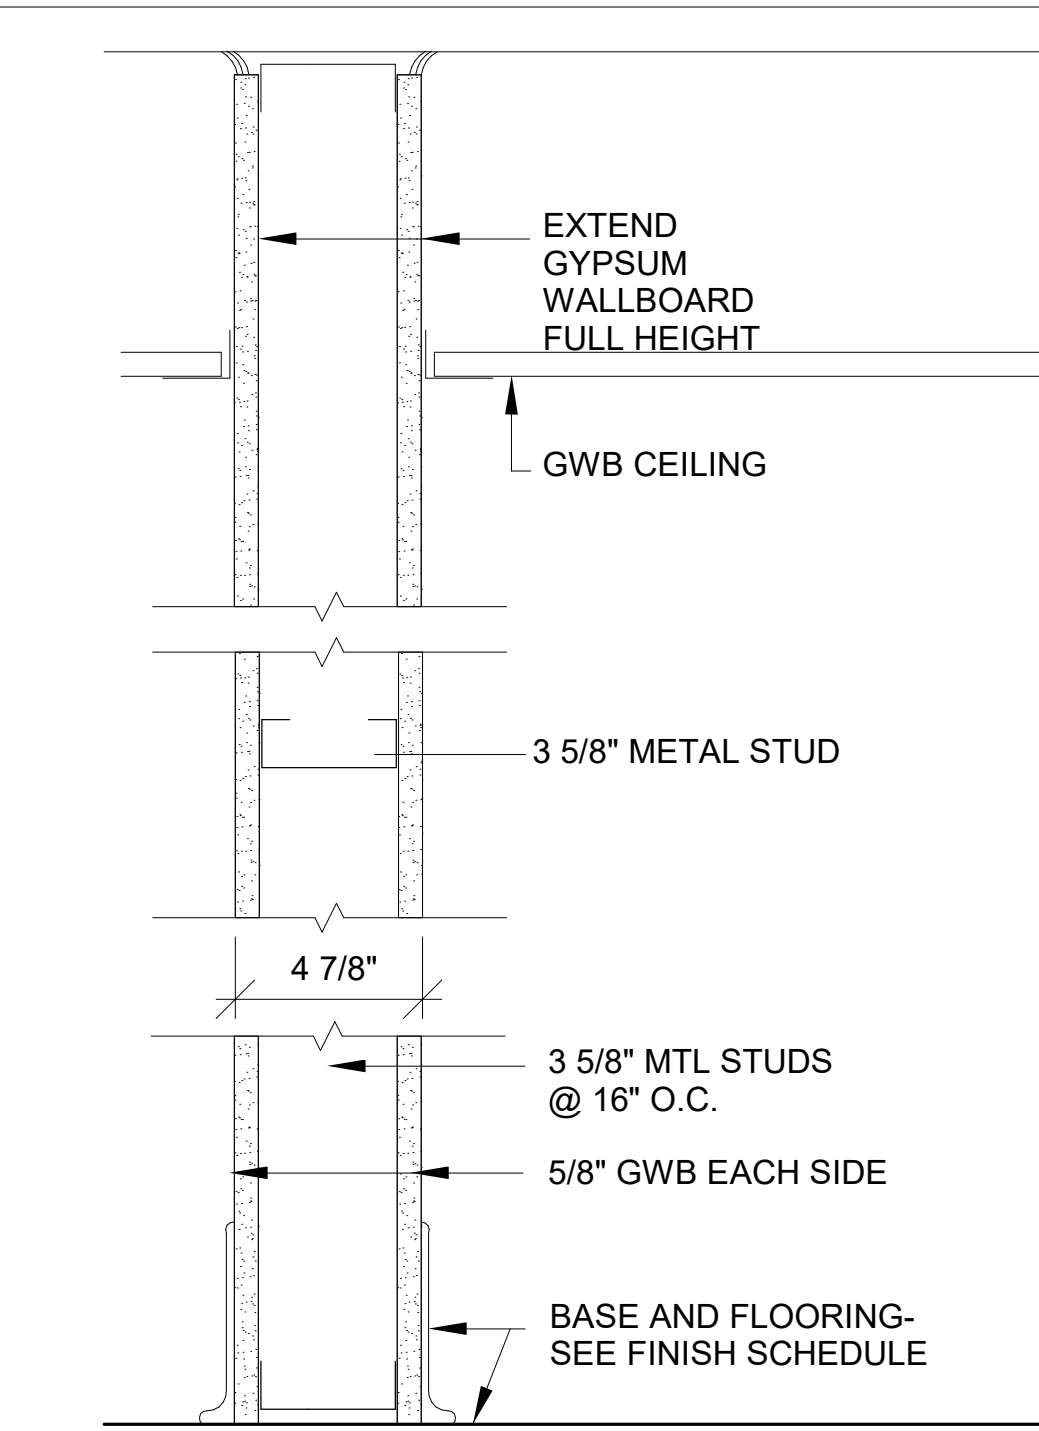


TYPE B 1 HOUR RATED

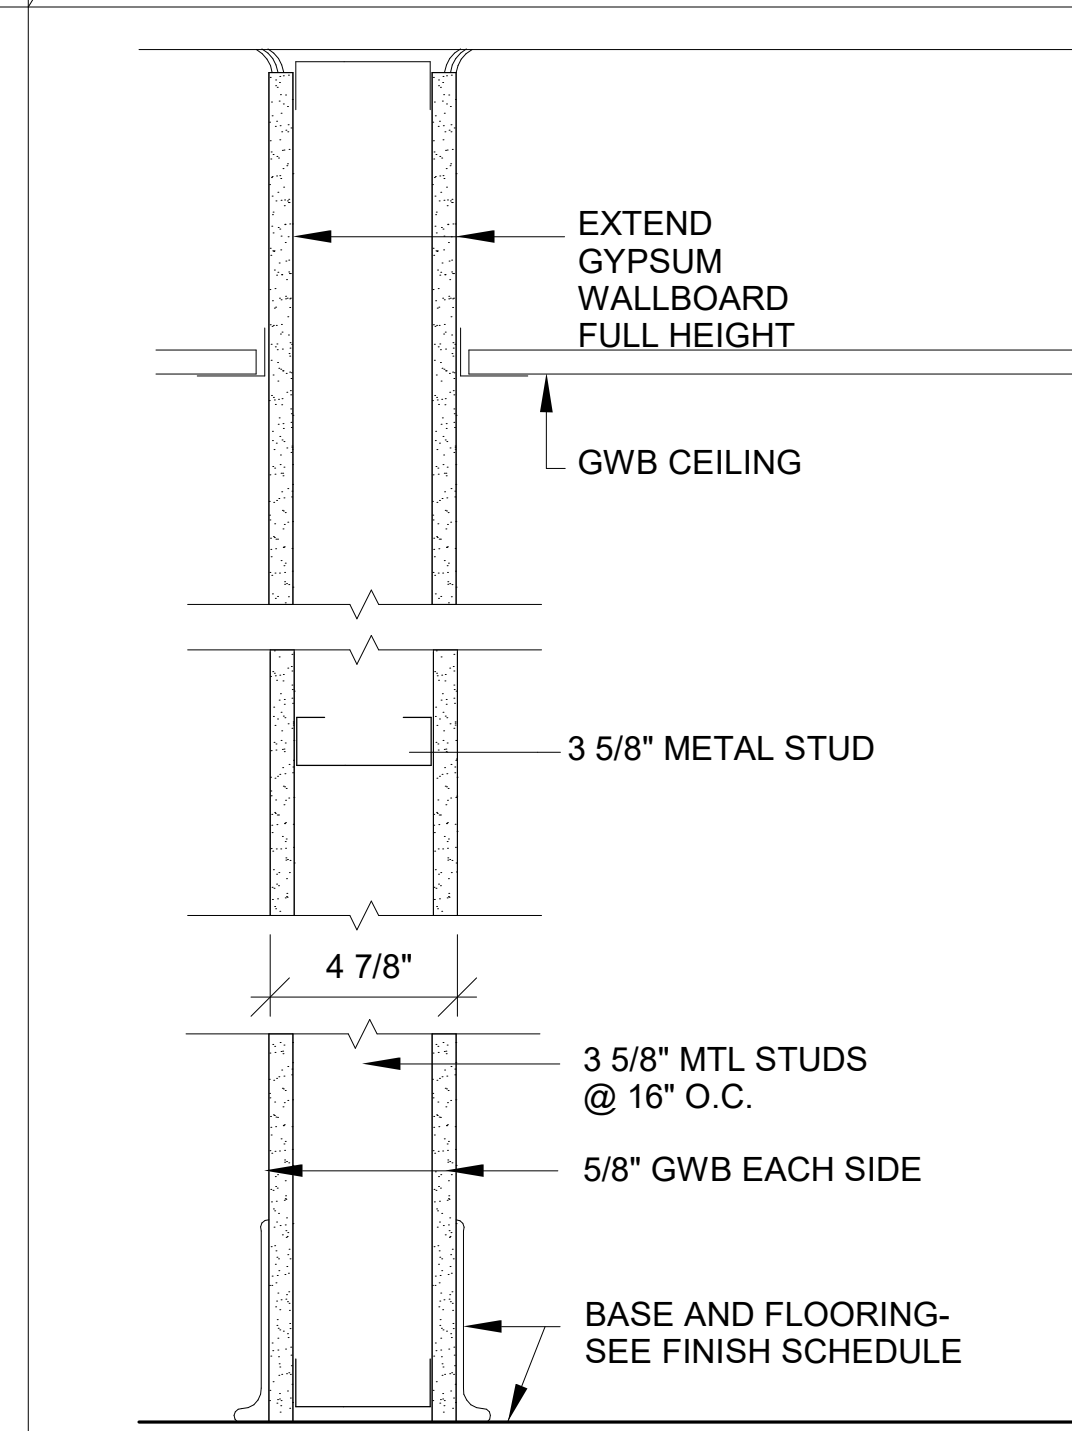



TYPE B1 NON - RATED

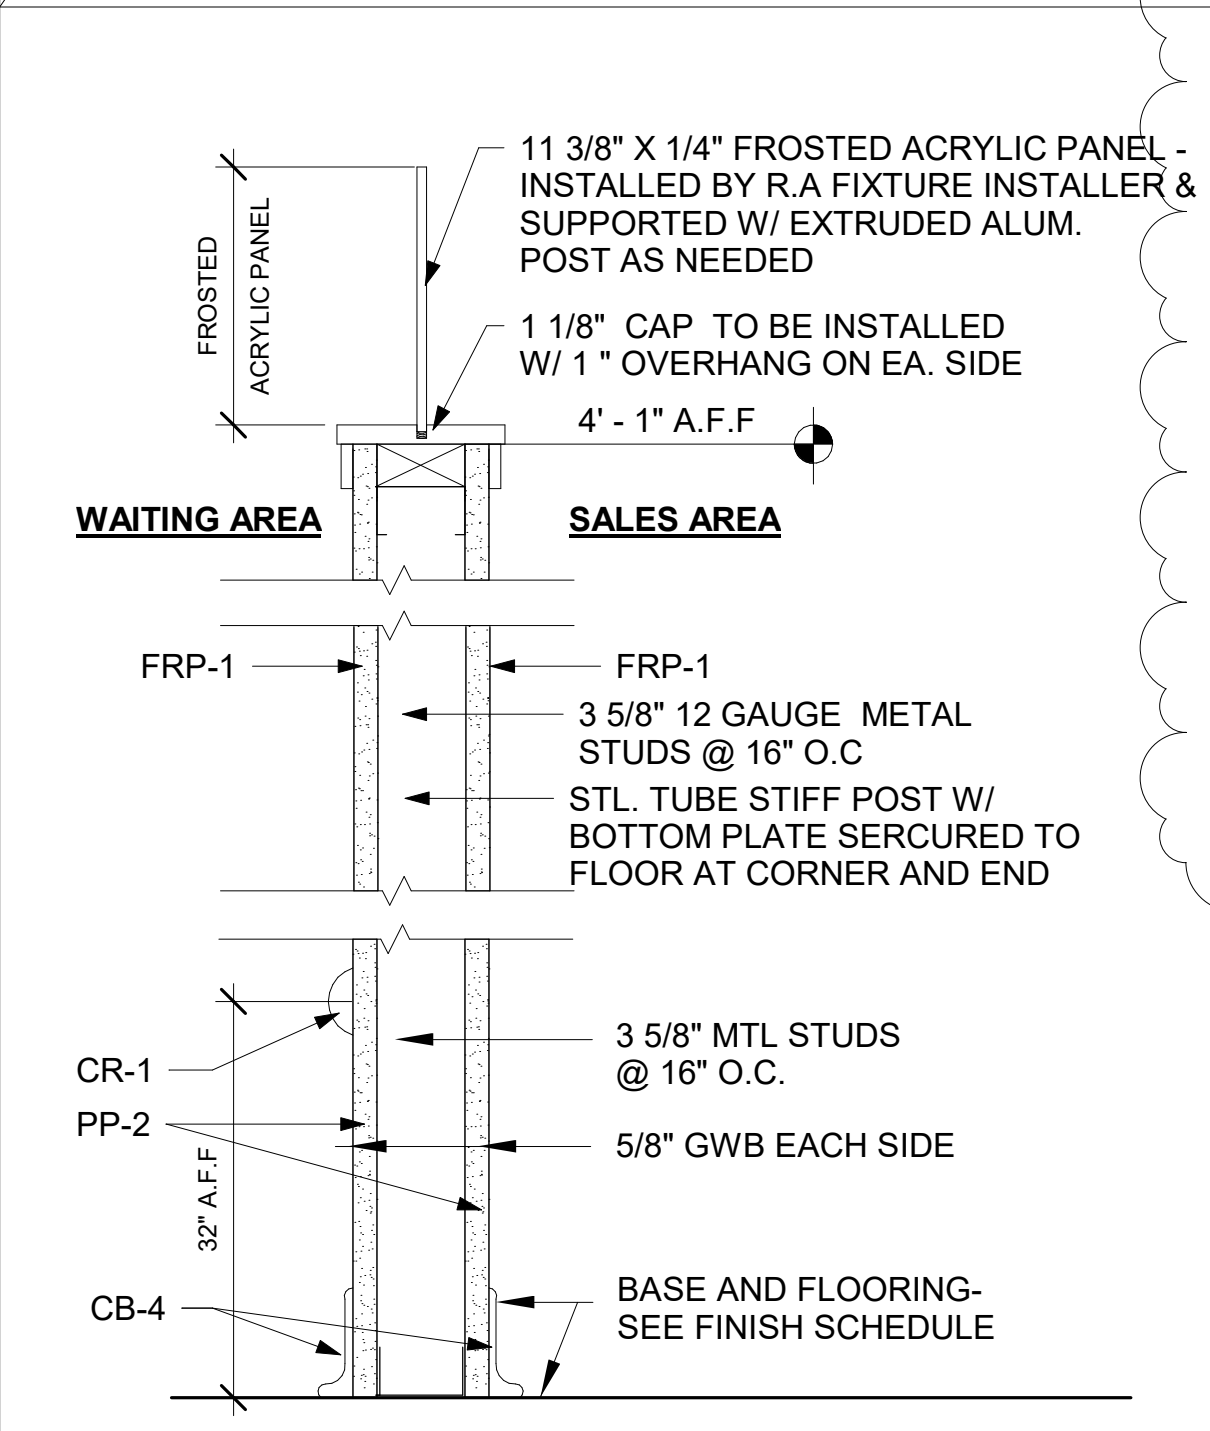


TYPE A5

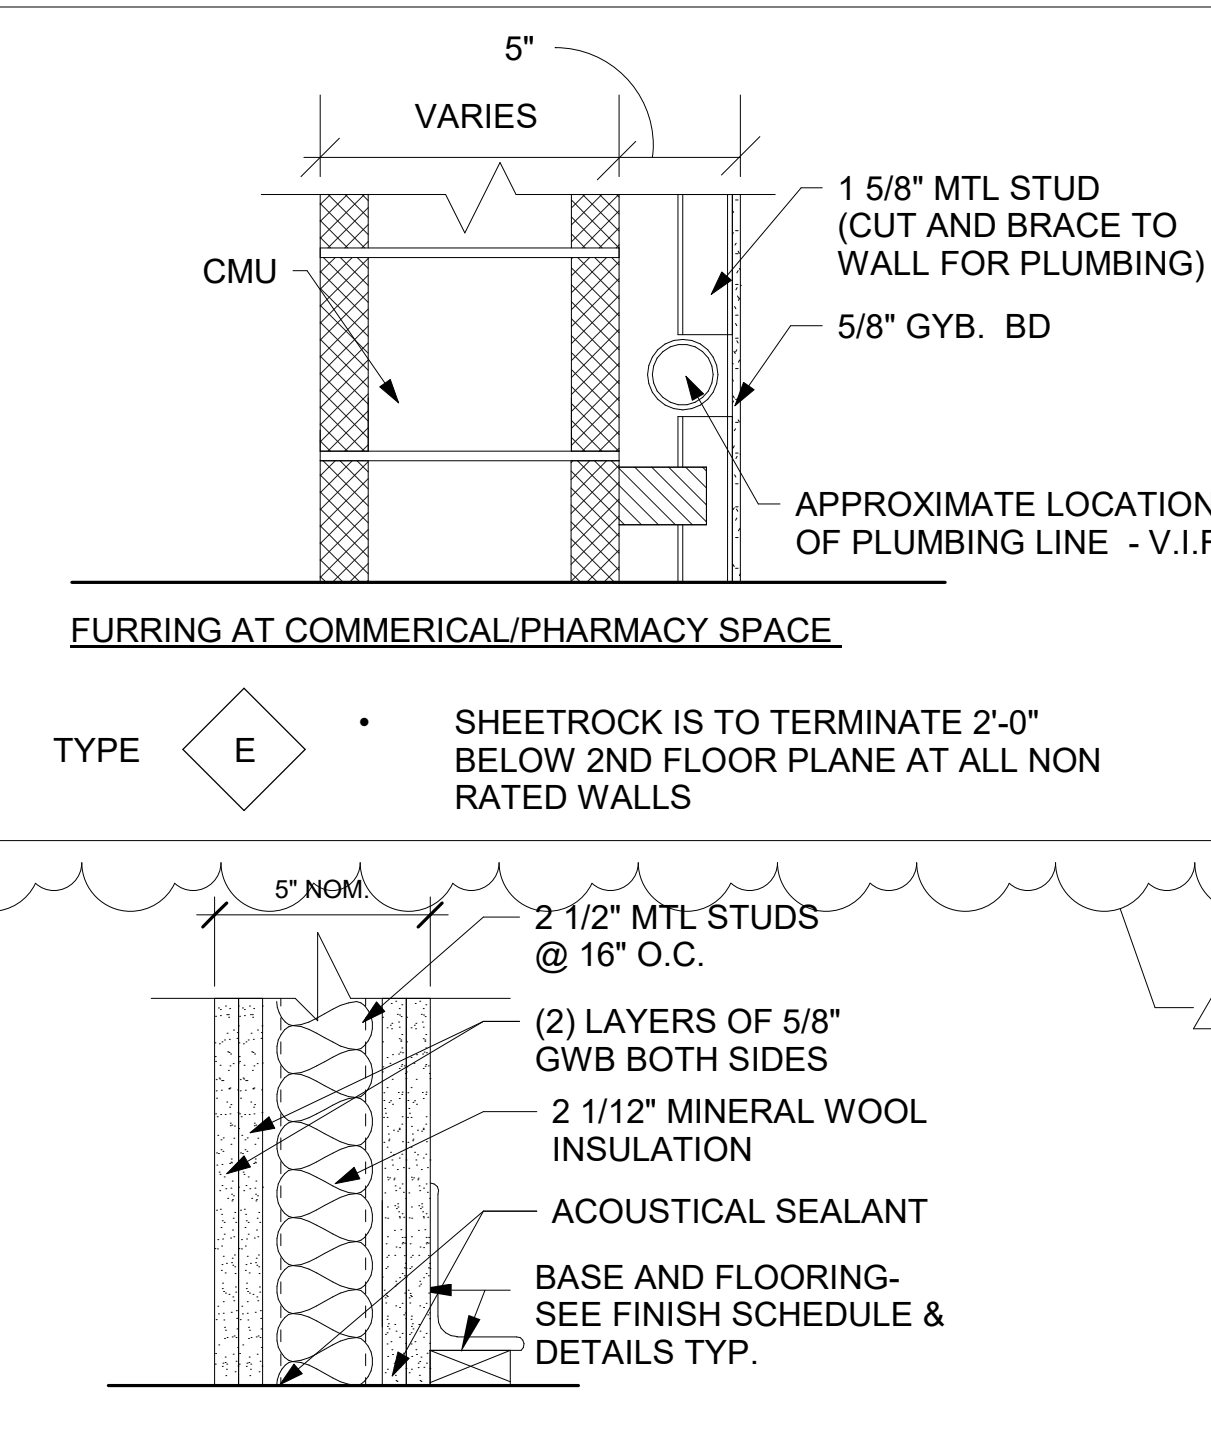


TYPE 1 2 HOUR RATED PARTITION  
UL # U419  
STC: MIN 50 TYP.  
MIN. 35 @ ENTRANCE DOOR

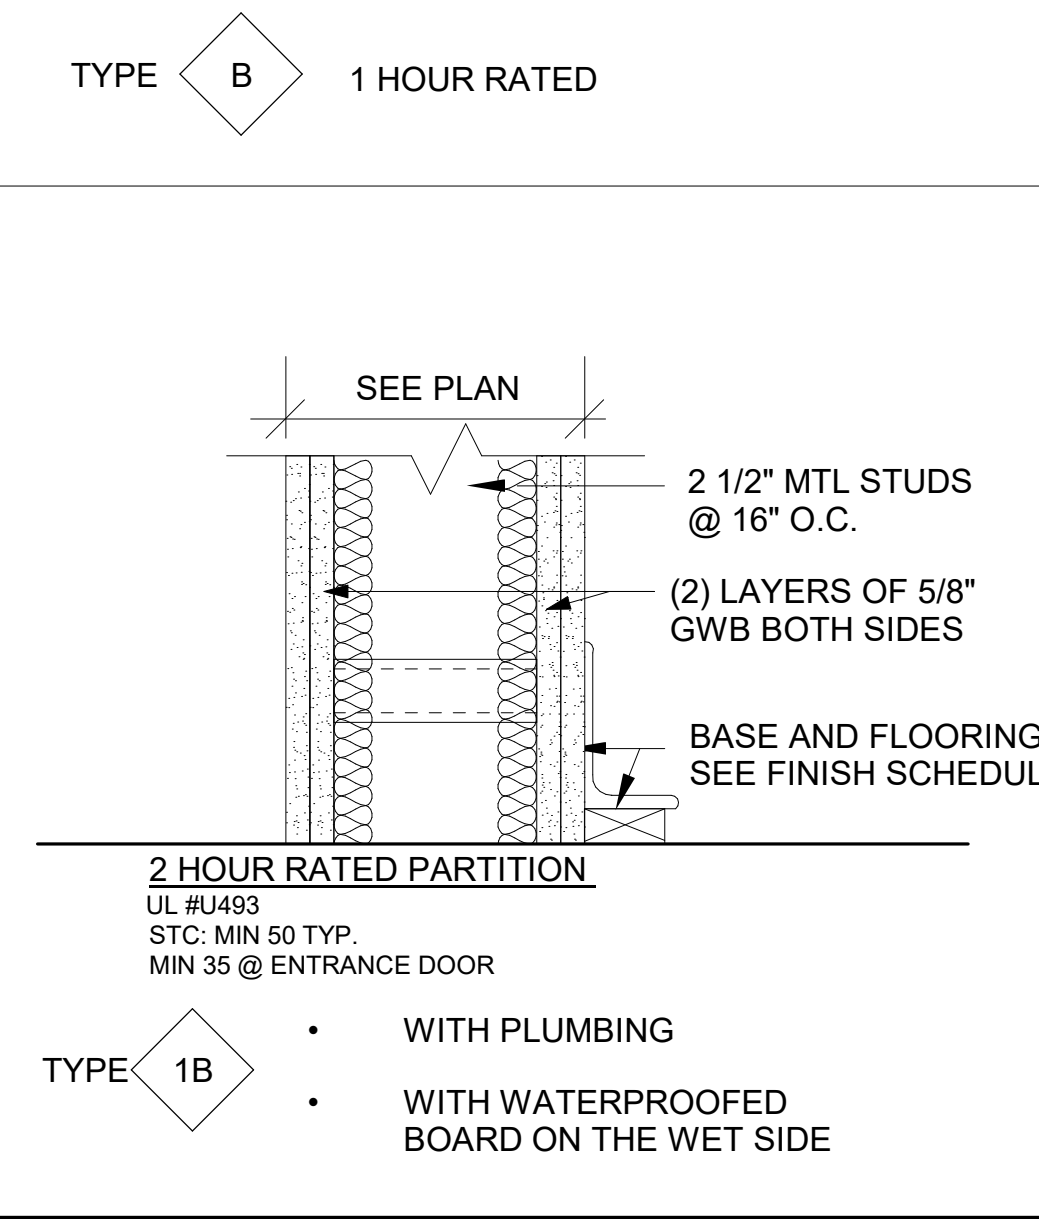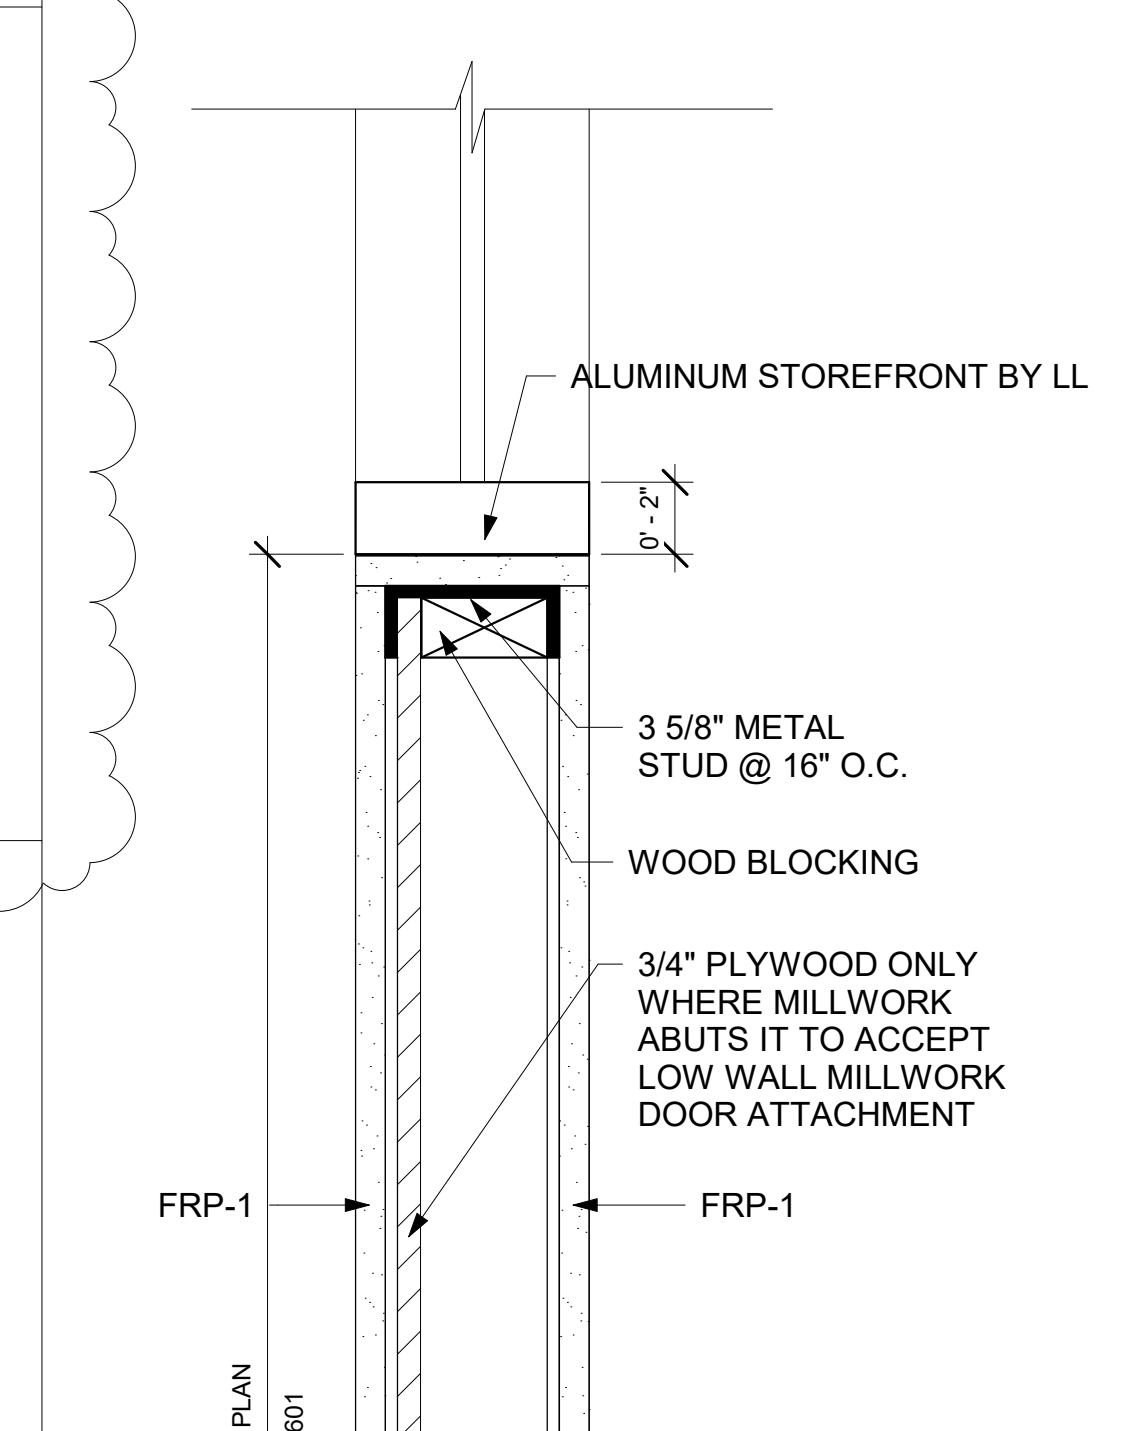


TYPE 1B WITH PLUMBING  
WITH WATERPROOFED BOARD ON THE WET SIDE

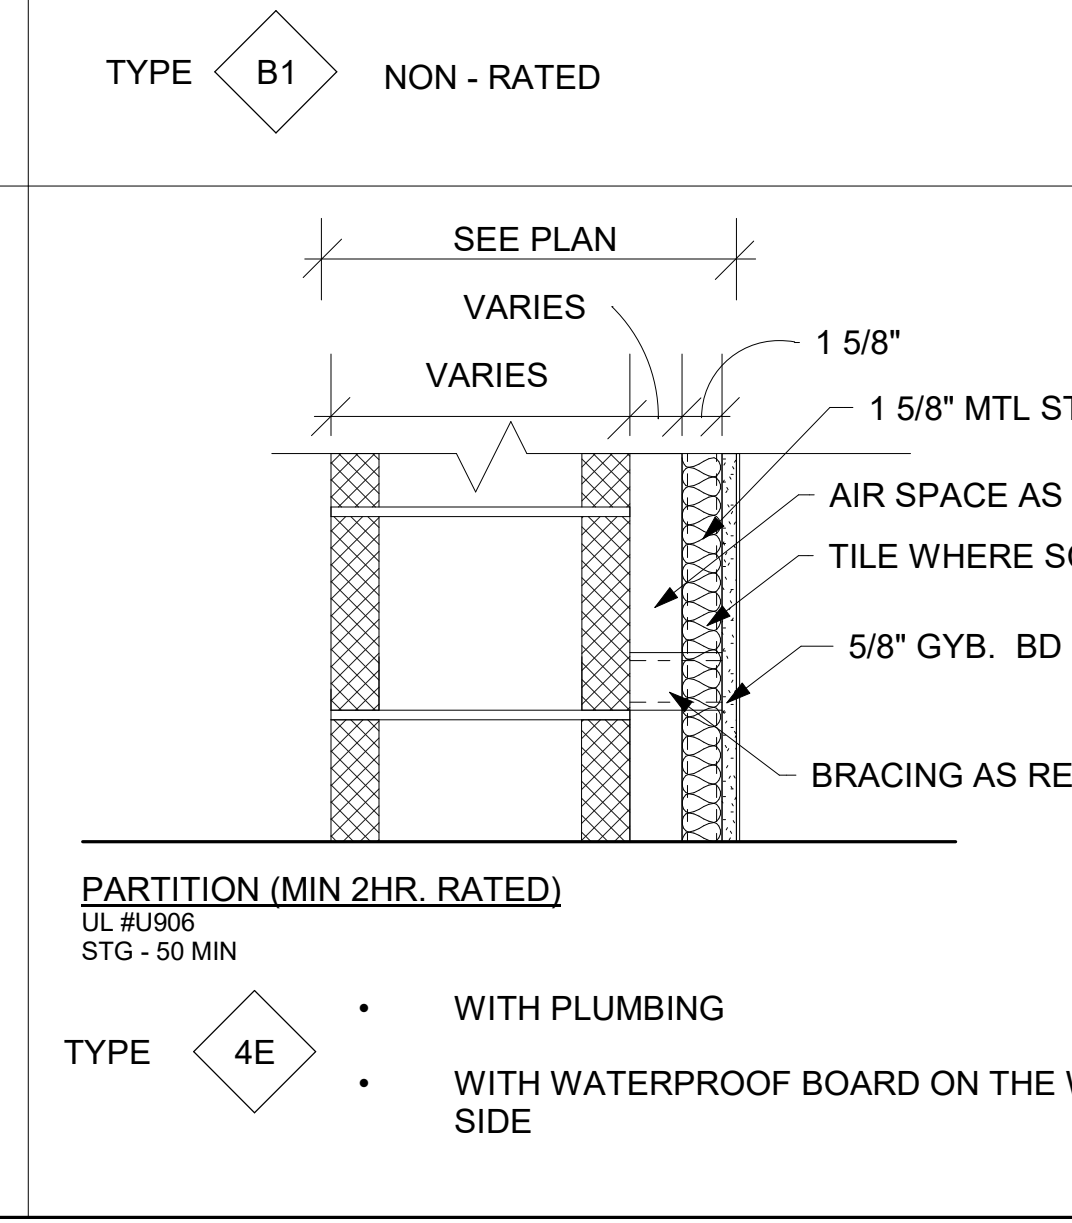

TYPE 4E PARTITION (MIN 2HR. RATED)  
UL #U906  
STC - 50 MIN  
WITH PLUMBING  
WITH WATERPROOF BOARD ON THE WET SIDE

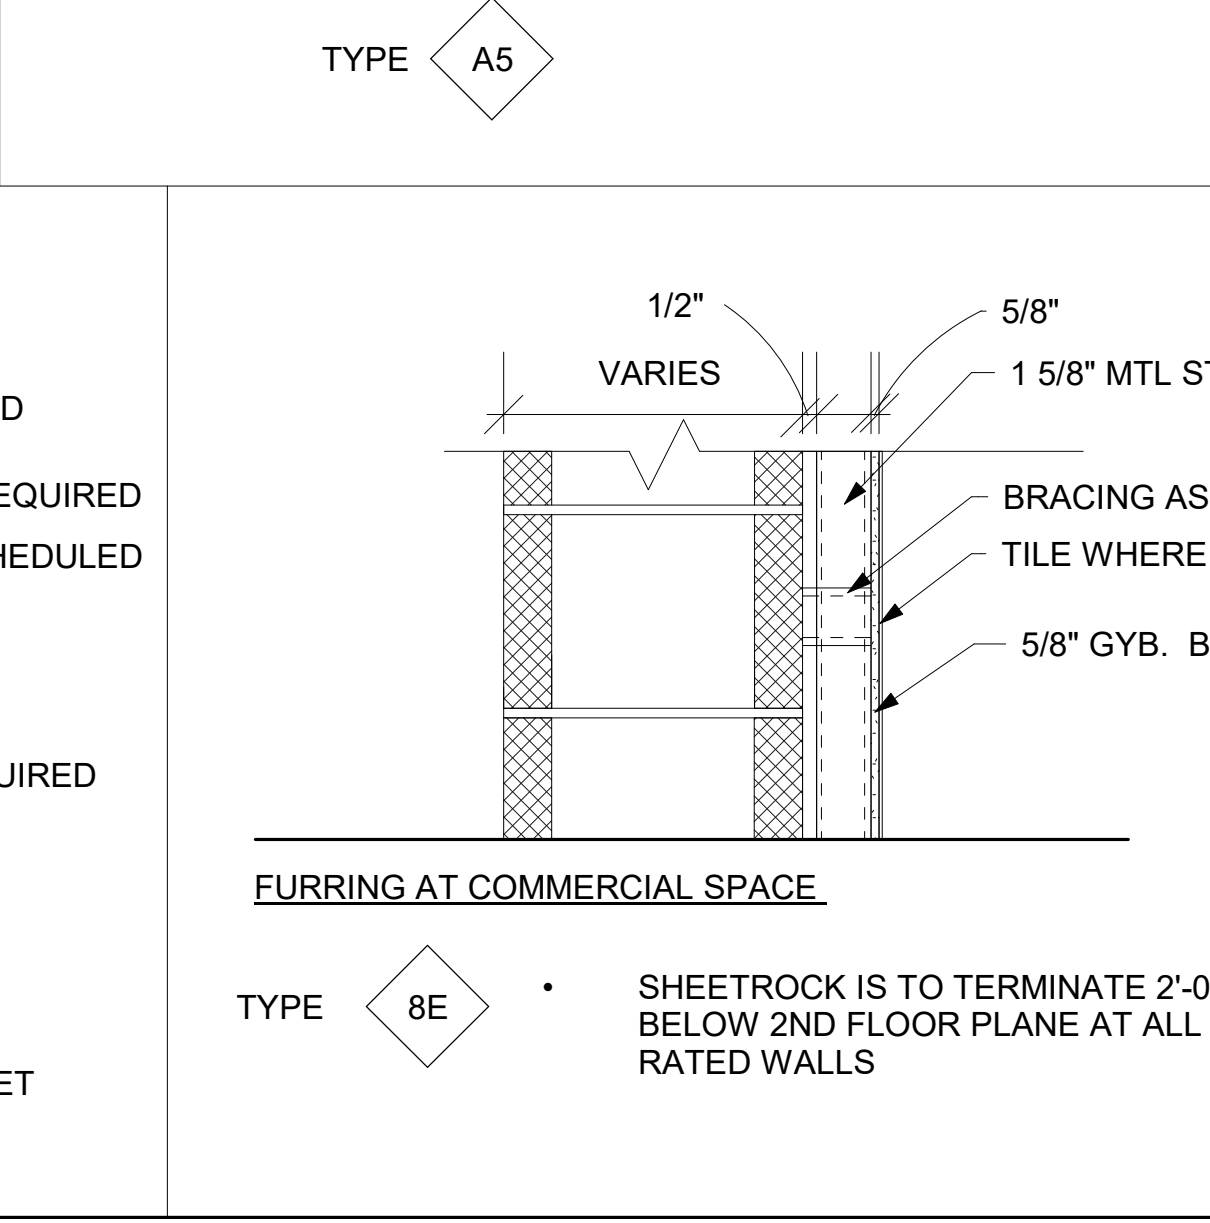


TYPE 8E SHEETROCK IS TO TERMINATE 2'-0\"/>

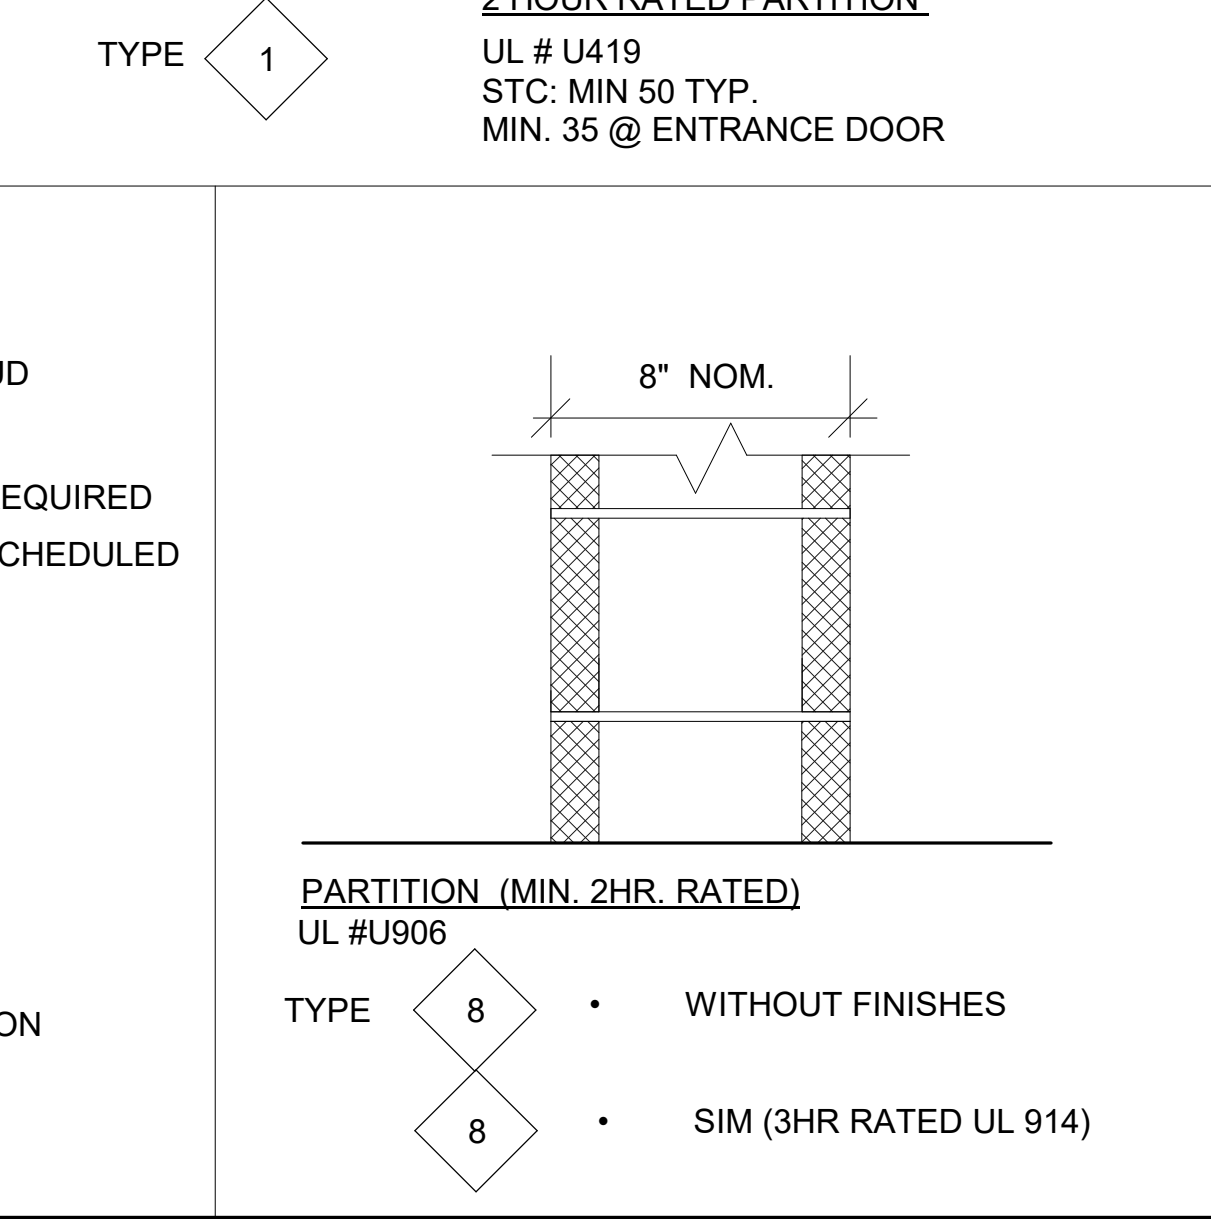

TYPE 8 PARTITION (MIN. 2HR. RATED)  
UL #U906  
WITHOUT FINISHES  
SIM (3HR RATED UL 914)

Issues/Revisions:

No.	Description	Date
9	Revised As Per Tenants Review	11/10/2017

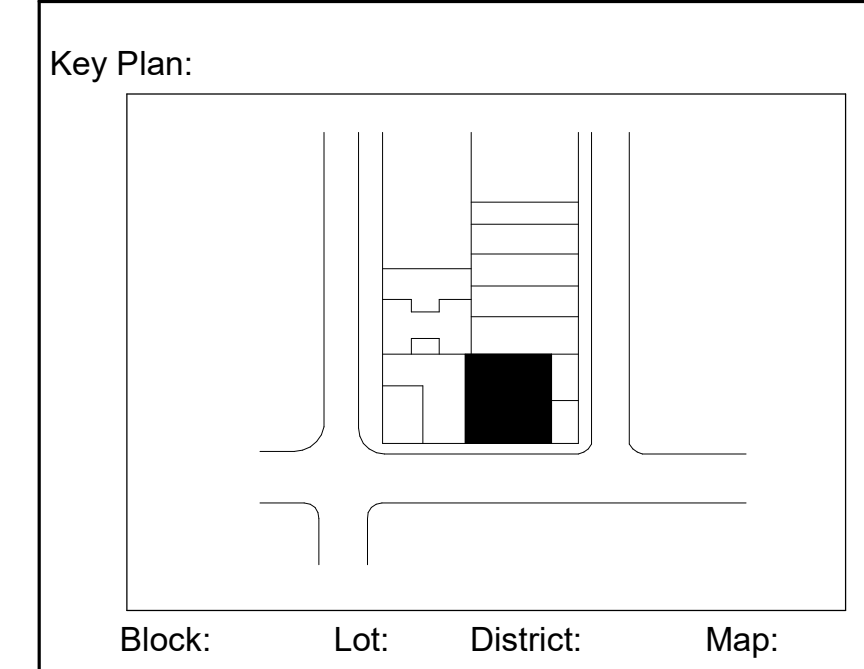

DOB Approvals:

B Scan Sticker:

Project/Building:  
**Rite Aid Store**  
85 Avenue D, New York, NY 10009

Sheet Title:  
**PARTITION TYPES**

Seal: Project Number: **1639**  
Date: **3/27/2017**  
Scale: **As indicated**

**A-500.00**

SHEET 7 of 35
















**RCP LEGEND**

Luminaire Schedule						
Symbol	Qty	Label	Arrangement	LLF	Description	Lumens/Lamp
⊙	12	A	SINGLE	0.850	ZR24M-40L-35K-10V-FD	4000
⊙	162	AA	SINGLE	0.850	KR6-34L-35K-120 KR6T-SSGC-FF-BH	N.A.
⊙	4	AE	SINGLE	0.850	ZR24M-40L-35K-10V-FD-EB14	4000
⊙	8	C	SINGLE	0.850	LS4-40L-35K-10V-FD	4000
⊙	16	D	SINGLE	0.850	LS8-80L-35K-10V-FD	8000
⊙	18	T	SINGLE	0.850	LR6-10L-35K-120-DR w/ RC612W-GU24	1000
⊙	9				LS4-40L-35K-10V or Approved Equal	2500 - 10000
⊙	13				LS6-40L-35K-10V or Approved Equal	2500 - 10000

NOTE:  
G.C TO VERIFY FIXTURE COUNTS PRIOR TO PURCHASE


Calculation Summary						
Label	Units	Avg	Max	Min	Avg/Min	Max/Min
CELLAR_Workplane	Fc	20.37	41.3	3.1	6.57	13.32
MENS_Workplane	Fc	33.88	41.4	26.7	1.27	1.55
NEW CONSULT_Workplane	Fc	56.22	68.5	47.3	1.19	1.45
PHARMACY_Workplane	Fc	75.02	100.0	40.6	1.85	2.46
SALES_Workplane	Fc	71.08	113.0	26.9	2.64	4.20
VESTIBULE_Workplane	Fc	74.17	98.9	52.5	1.41	1.88
WOMENS_Workplane	Fc	36.00	43.2	27.0	1.33	1.60

FIXTURE MOUNTING HEIGHT: AT 10' A.F.F U.O.N @ 1ST FLOOR  
REFLECTANCES: 80-50-20%

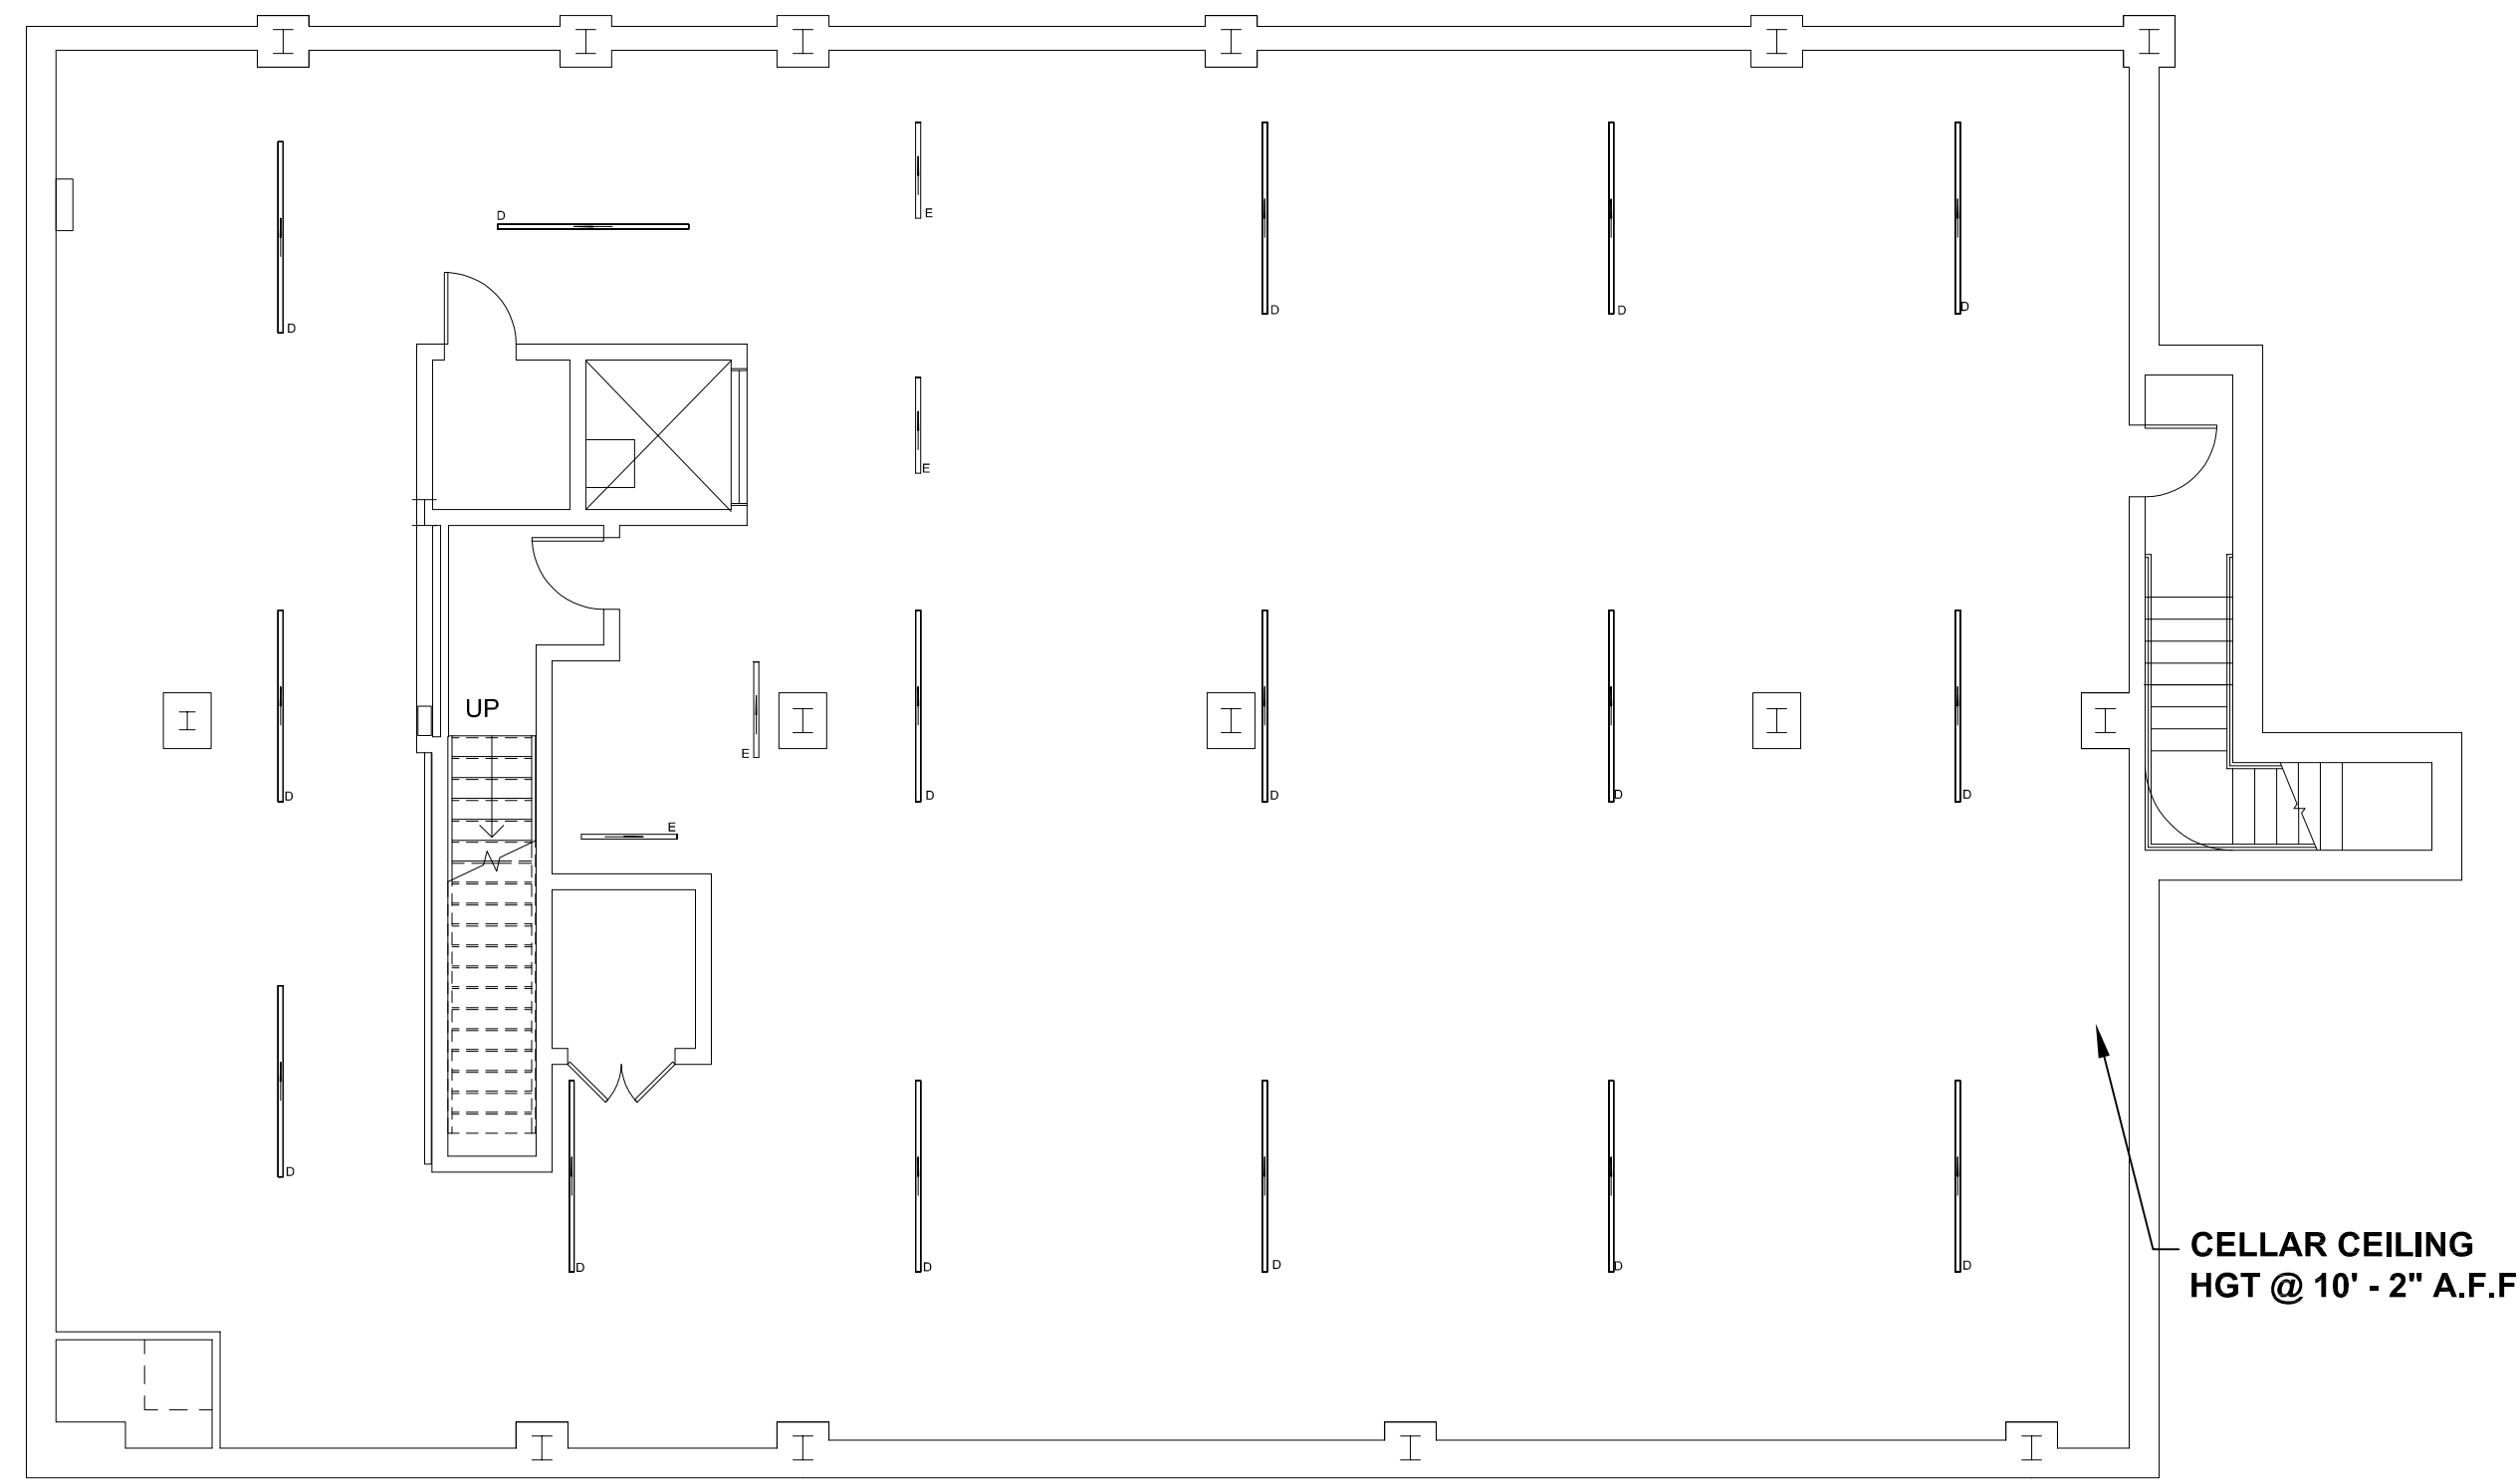

1 CELLAR REFLECTED CEILING PLAN  
1/8" = 1'-0"

NOTE: PHARMACY AREA ONLY  
ALL FIXTURES IN FIRST ROW, RUNNING PARALLEL TO THE PHARMACY WALL ARE TO RECEIVE A WALL WASH TRIM.  
A TOTAL OF 25 WALL WASH TRIMS SHOULD BE ORDERED FOR THIS PROJECT.  
BALANCE OF WALL WASH TRIMS TO BE USED IN FIXTURES LOCATED IN FRONT OF WALL WASH SIGNAGE AS REQUIRED.

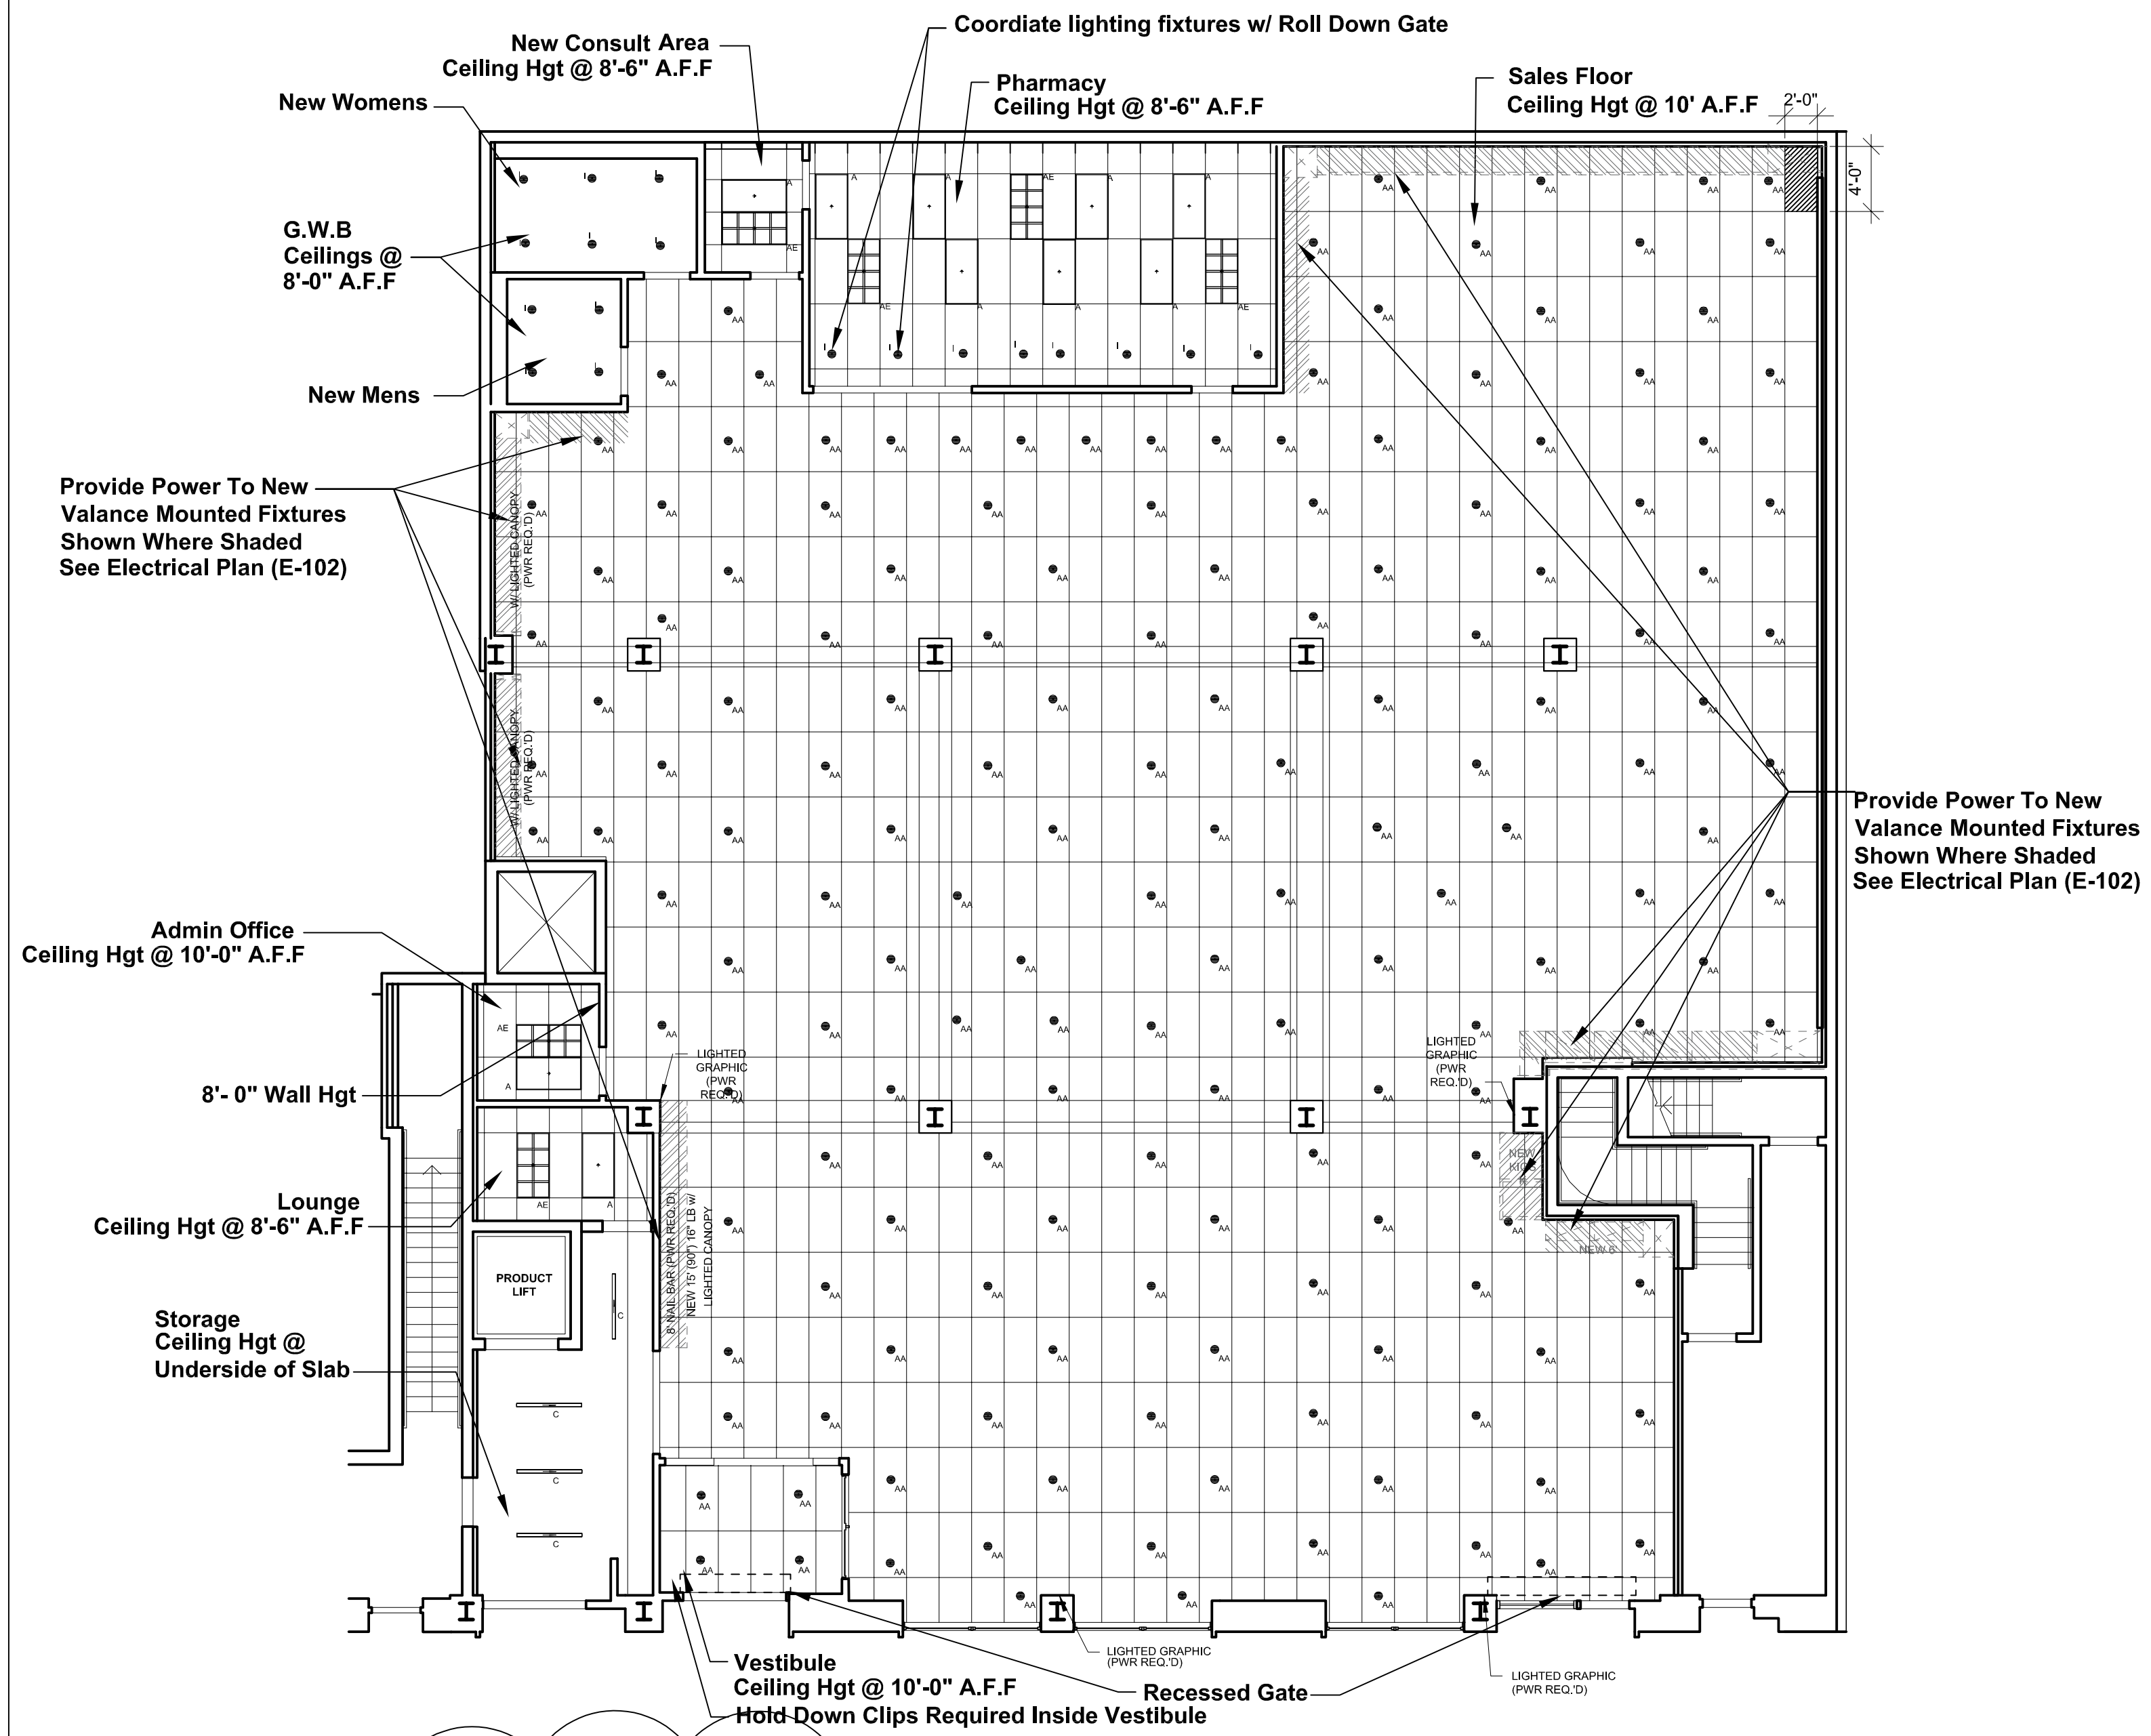

2 FIRST FLOOR REFLECTED CEILING PLAN  
1/8" = 1'-0"


Consultants:

Owner:

Issues/Revisions:

No.	Description	Date
9.	REVISED AS PER TENANT REVIEW	11/10/2017

 Key Plan:



Block: Lot: District: Map:

DOB Approvals:

B Scan Sticker:

Project/Building:

**Rite Aid Store**  
85 Avenue D, New York, NY 10009

Sheet Title:

**REFLECTED CEILING PLAN**

Seal:

Project Number: 1639  
Date: 3/27/2017  
Scale: 1/8" = 1'-0"

**RCP-100.00**

SHEET 11 of 35

RCP LEGEND

Symbol	Label	Arrangement
	A	SINGLE
	AA	SINGLE
	AE	SINGLE
	C	SINGLE
	D	SINGLE
	I	SINGLE
	EXISTING SPRINKLER HEAD	
	NEW SPRINKLER HEAD	
	NEW CEILING MOUNTED DIRECTIONAL EXIT SIGN	
	NEW CEILING MOUNTED EXIT SIGN	
	DIFFUSER GRILLE	

 
Consultants:

Owner:

Issues/Revisions:

No.	Description	Date
7.	REVISED AS PER TENANT REVIEW	08/08/2017

Key Plan:



Block: Lot: District: Map:

DOB Approvals:

B Scan Sticker:

Project/Building:

**Rite Aid Store**  
85 Avenue D, New York, NY 10009

Sheet Title:


**COORDINATED REFLECTED  
CEILING PLAN**

Seal:


Project Number: 1639  
Date: 3/27/2017  
Scale: 1/8" = 1'-0"

**RCP-101.00**

SHEET 12 of 35

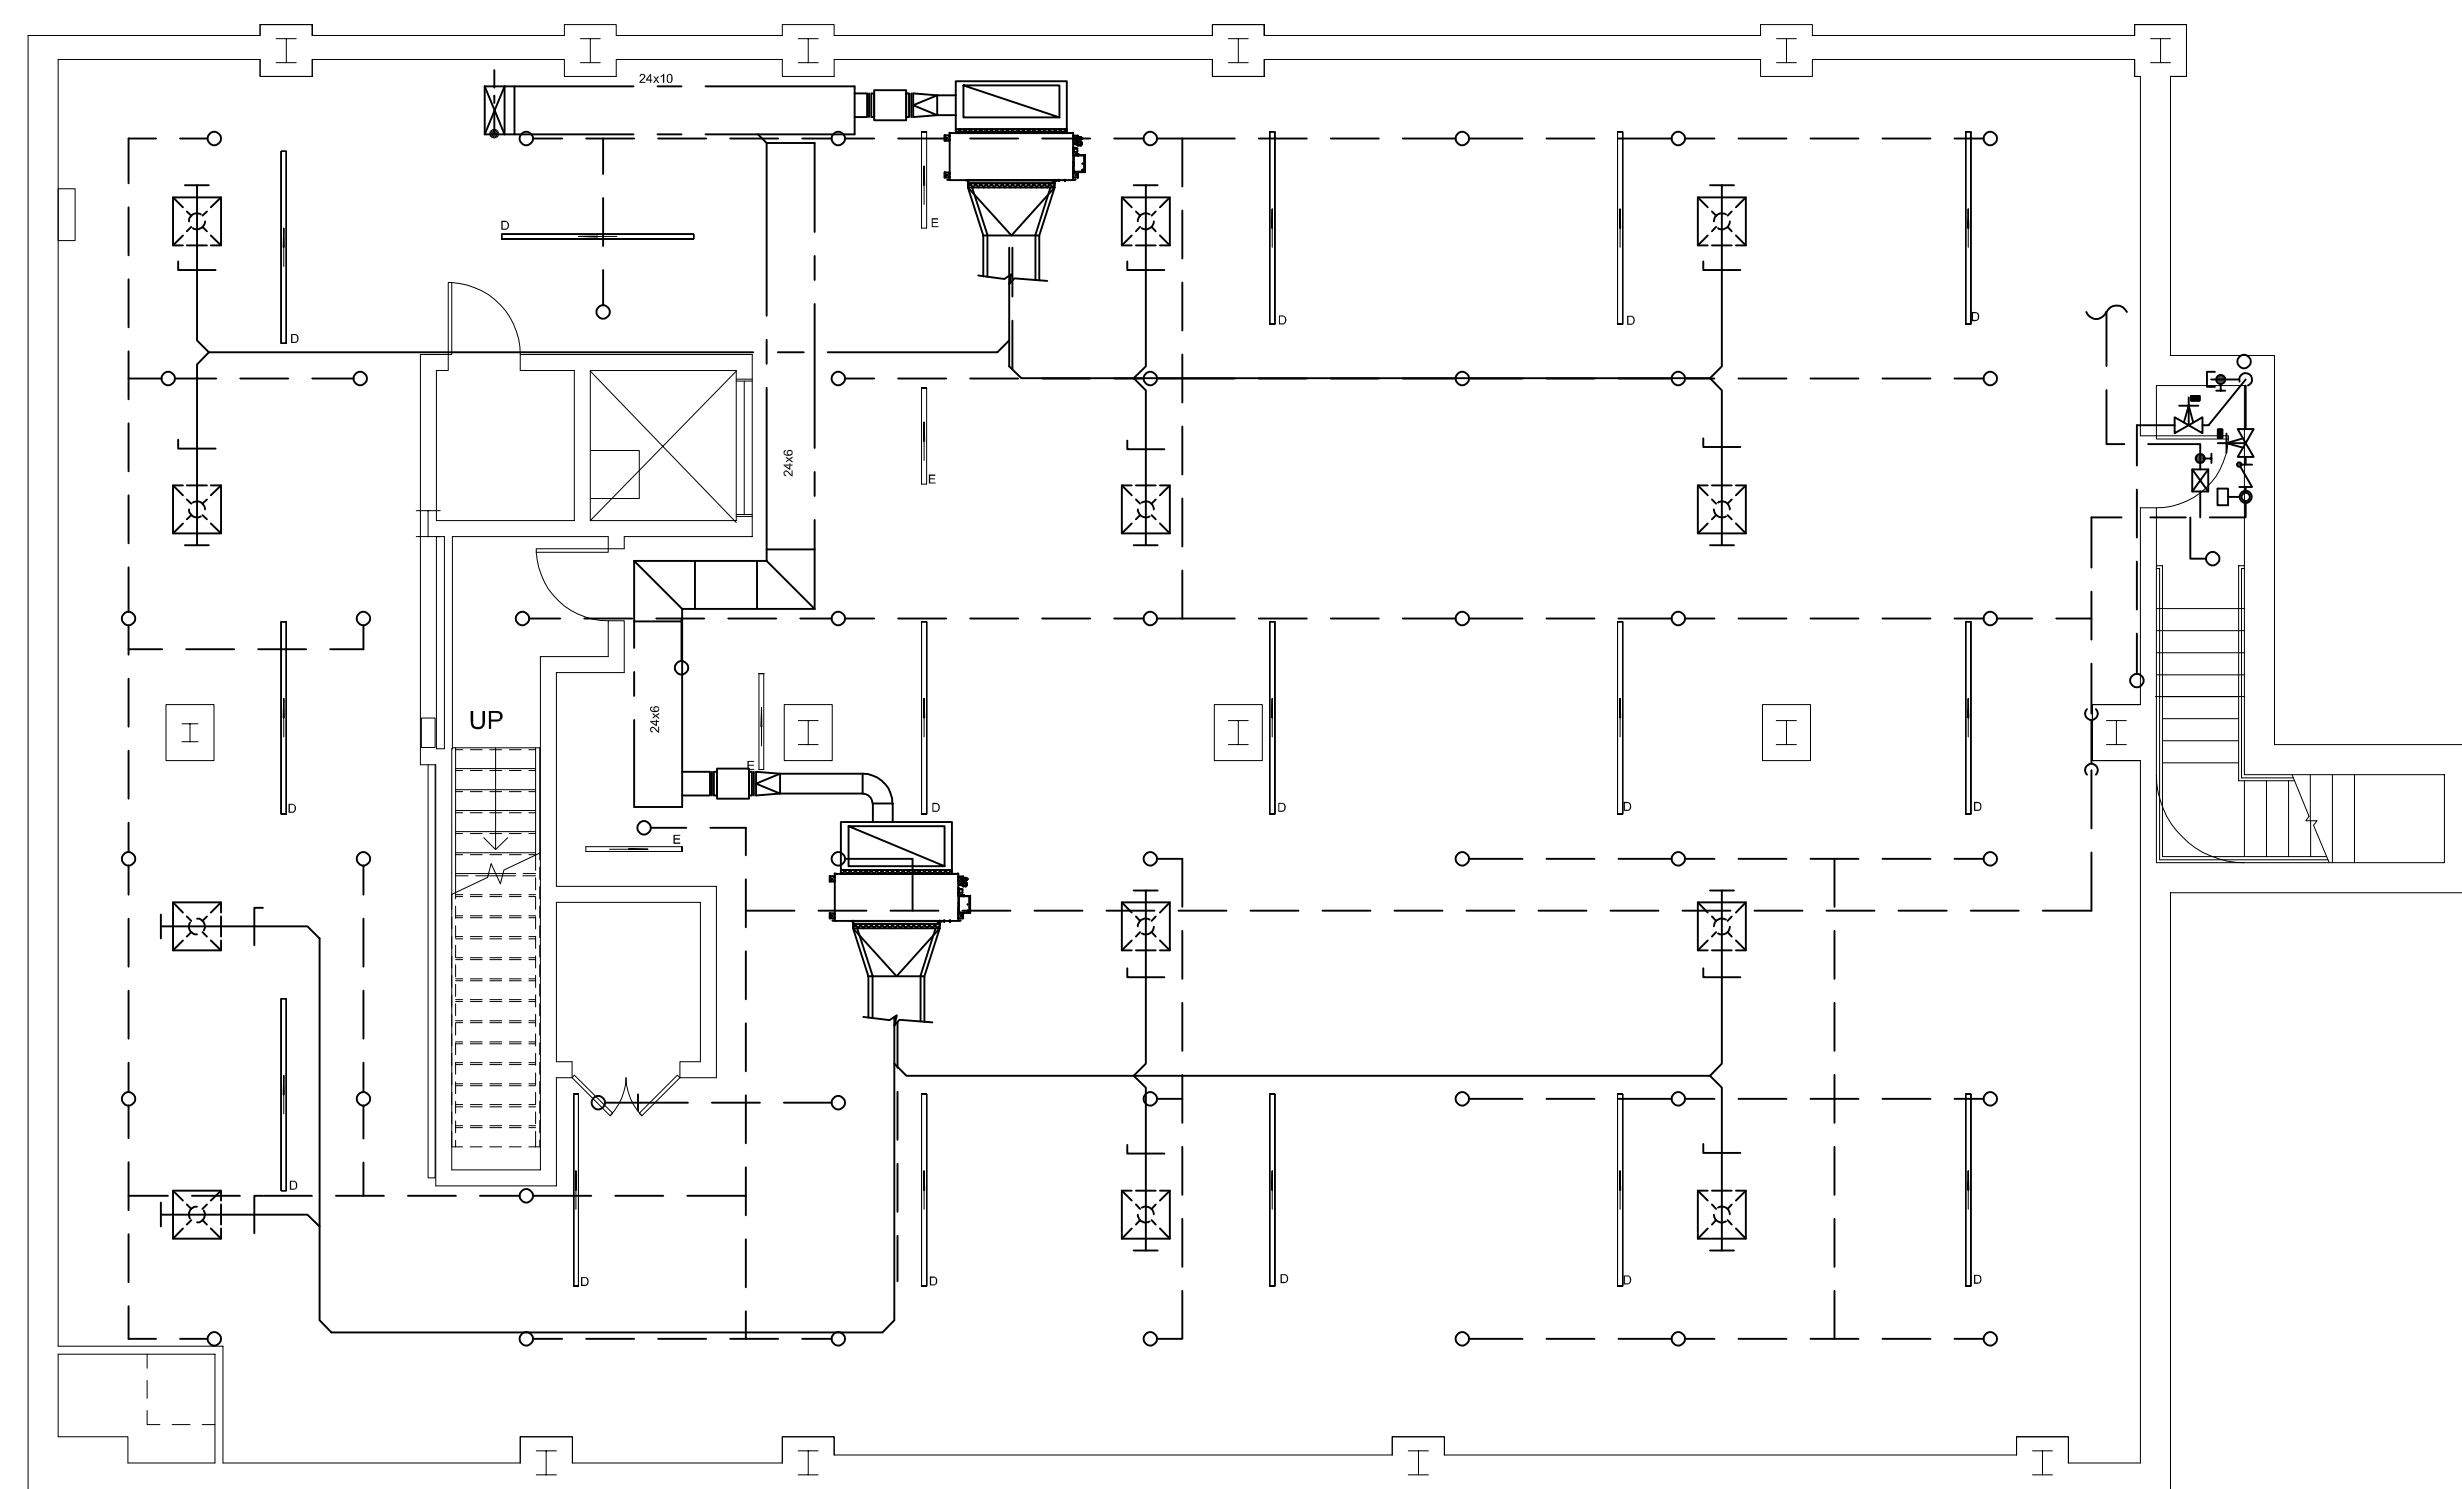

① CELLAR COORDINATED REFLECTED CEILING PLAN  
1/8" = 1'-0"

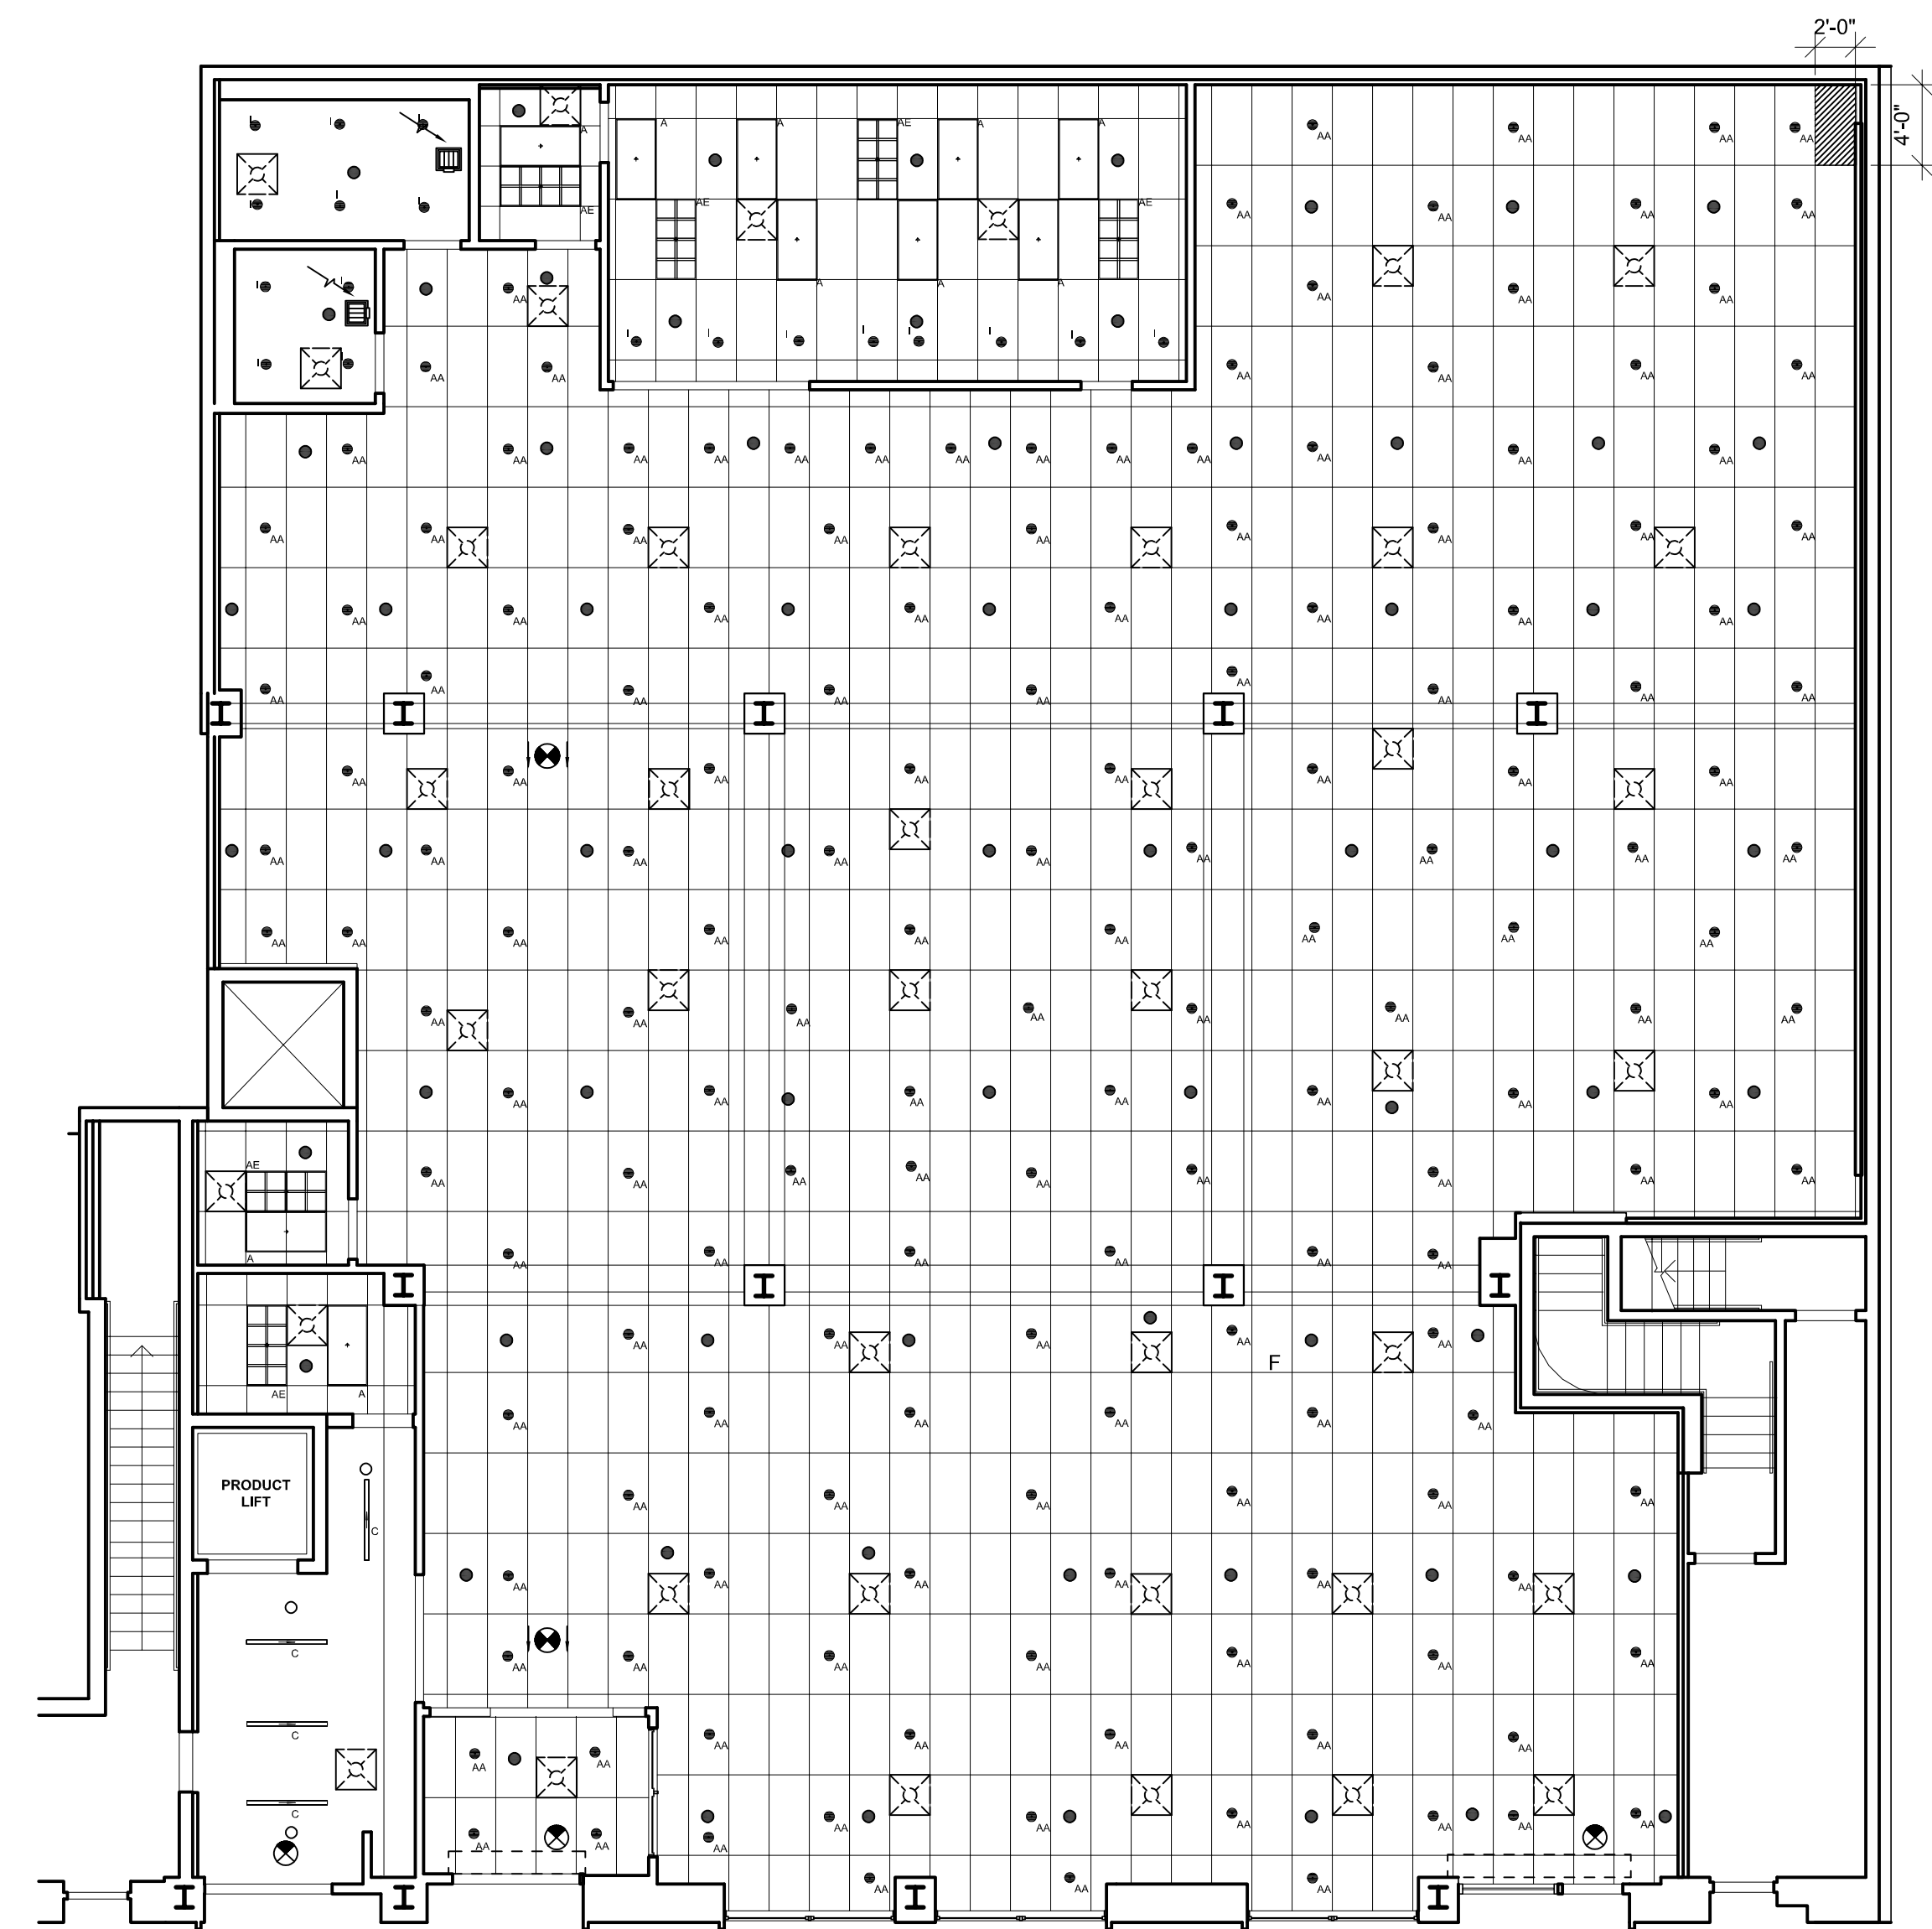

② FIRST FLOOR COORDINATED REFLECTED CEILING PLAN  
1/8" = 1'-0"






**FINISH SCHEDULE**

 KEY	ITEM	MANUFACTURER	DESCRIPTION PRODUCT	COLOR	DIMENSION	LOCATION	ADDITIONAL INFORMATION	
CEILING	AC-1	ACOUSTIC CEILING	ARMSTRONG	# MR8 HEAVY DUTY MAIN BEAM # 7301 # 7342 # 7328 # 7890 # MR87524 FINE FISSURED	TILE GRID - PREDULE CUSTOM COLOR # FZ44634	2' X 4'	HEAVY DUTY MAIN BEAM 4 TEE PROVIDED AND INSTALLED BY LANDLORD HEAVY DUTY MAIN BEAM HEAVY DUTY MAIN BEAM	
FLOOR	C-1	CARPET	INTERFACE	M26479-001 SA (Rite Aid)	# 7769 FOUNDATION	TILE	CONSULTATION PROVIDED AND INSTALLED BY LANDLORD. INSTALL POST FIXTURE INSTALLATION INSTALL POST FIXTURE INSTALLATION	
	C-3	ANTI-FATIGUE MAT	MATWORKS	INTERFACE	HELIX Z1	PREFERENCE EZE COLOR: SILVER	18" X 18" X 3/4" TILE PHARMACY PROVIDED AND INSTALLED BY LANDLORD. INSTALL POST FIXTURE INSTALLATION	
	CT-1	PORCELAIN TILE	DALTILE	UNDERLAYMENT & TOPPING	FUSION PRO - SINGLE COMPONENT	N/A	RESTROOMS VESTIBULE PROVIDED AND INSTALLED BY LANDLORD	
	G-1	PREMIUM CEMENT GROUT	DALTILE	UNDERLAYMENT & TOPPING	FUSION PRO - SINGLE COMPONENT	TOBACCO BROWN #52	RESTROOMS - S & I BY LL PROVIDED BY RITE AID INSTALLED BY LANDLORD PROVIDED BY RITE AID INSTALLED BY LANDLORD	
TRANSITIONS	SC-1	SEALED CONCRETE	SHERWIN WILLIAMS	WATER-BASED URETHANE ENAMEL	ARMORSEAL 1K B65C775 CLEAR	12" X 24"	BACK OF HOUSE, STOCK ROOM & MEZZANINE SALES OFFICE, LOUNGE PROVIDED AND INSTALLED BY LANDLORD CONCRETE TO BE MOISTURE TESTED FOR CORRECT MASTIC TO BE USED	
	VC-1	VCT TO CONCRETE	JOHNSONITE	JOHNSONITE	CTA-20-C / COLOR: 167 FUDGE AT WAITING AND CONSULTATION ROOM ONLY	WIDTH OF OPENING	PHARMACY TO RETAIL RECEIVING AREA TO RETAIL PROVIDED AND INSTALLED BY LANDLORD. NOTE: VERIFY ALL FLOORING HEIGHTS PRIOR TO ORDERING TRANSITION STRIPS	
	TG-3	CARPET TO CARPET	JOHNSONITE	EPOXY TROWELED FINISH	METAL REDUCER	CTA-20-C / COLOR: 167 FUDGE AT WAITING AND CONSULTATION ROOM ONLY	WIDTH OF OPENING	PHARMACY TO CONSULTATION RESTROOMS TO RETAIL PROVIDED AND INSTALLED BY LANDLORD. NOTE: VERIFY ALL FLOORING HEIGHTS PRIOR TO ORDERING TRANSITION STRIPS
	TG-4	CARPET TO TILE	DALTILE	POLISHED MARBLE DBL BEVEL THRESHOLD	CHAIR0 BEIGE #M710	2" X 36" X 3/8"	2" X 36" X 3/8"	PROVIDED AND INSTALLED BY LANDLORD. NOTE: VERIFY ALL FLOORING HEIGHTS PRIOR TO ORDERING TRANSITION STRIPS
	TG-5	TILE TO TILE	REESE	MILL ALUM. FINISH SADDLE THRESHOLD	ALUM.	2 1/2" X 36" X 1/4"	2 1/2" X 36" X 1/4"	PROVIDED AND INSTALLED BY LANDLORD
BASE	CB-1	COVE BASE	JOHNSONITE	VINYL	FUDGE RWDC -167F	4"	VESTIBULE / PHARMACY 2" X 2" RESTROOMS PROVIDED AND INSTALLED BY LANDLORD	
	CB-2	COVE BASE	DALTILE	PORCELAIN BUILT-UP COVE BASE	KEYSTONES - ARTISAN - BROWN SPECKLE - #D204	2" X 36" X 3/8"	2" X 36" X 3/8"	PROVIDED AND INSTALLED BY LANDLORD
	CB-3	COVE BASE	JOHNSONITE	VINYL	FUDGE RWDC -167F	4"	WAITING AND CONSULTATION / GENERAL PROVIDED AND INSTALLED BY LANDLORD. INSTALL POST FIXTURE INSTALLATION	
WALL	CR-1	CHAIR RAIL	JOHNSONITE	VINYL	FUDGE CHAR-167-C	1 1/16" x 3" x 12"	WAITING AND CONSULTATION PROVIDED AND INSTALLED BY LL. NOTE: CHAIR RAIL TO BE MOUNTED 32" AFF O.C. TO CENTER. THE CHAIR RAIL SHOULD BE INSTALLED THEN PAINTED.	
	FRP-1	FIBERGLAS REINFORCED PANEL	MARLITE	ARTIZAN FRP	MONTEREY SAND - #5408	4' X 8'	RESTROOMS PHARMACY DROP OFF AND PICK UP PROVIDED AND INSTALLED BY LANDLORD	
	FRP-2	FIBERGLAS REINFORCED PANEL	MARLITE	ARTIZAN FRP	P-118 COLOR: ALMOND	4' X 8'	PHARMACY WALL PROVIDED AND INSTALLED BY LANDLORD	
	PP-1	CUSTOM GREEN LEAF WALL COVERING	FIREFLY	VINYL WALL COVERING	MONTEREY SAND-#5408		PHARMACY WALL	PROVIDED AND INSTALLED BY LANDLORD VENDOR. NOTE: 2" BUMPER AT 4 1/2" AFF
WALL	WP-1	WALL PAPER / KOROGUARD CORNER GUARD	KOROSEAL	# NAGA 803	NAVAJO WHITE (WALL PAPER) / K-4 Balsa (CORNER GUARD) (RAWC-01/RACG)	30 YARD ROLL	PHARMACY, CONSULTATION ROOM PROVIDED AND INSTALLED BY LANDLORD	
	WP-2	WALL PAPER / KOROGUARD CORNER GUARD	KOROSEAL	# NAGA 803	NAVAJO WHITE (WALL PAPER) / K-4 Balsa (CORNER GUARD) (RAWC-01/RACG)	30 YARD ROLL	PHARMACY, CONSULTATION ROOM PROVIDED AND INSTALLED BY LANDLORD	
PAINT	P-1	PAINT	SHERWIN WILLIAMS	SEE SPECIFICATIONS	SW-CUSTOM-996 ASHEN TAN EGGSHELL FINISH		GENERAL INTERIOR PERIMETER WALLS PHARMACY COLUMNS, DOOR & DOOR FRAMES PROVIDED AND INSTALLED BY LANDLORD	
	P-2	PAINT	SHERWIN WILLIAMS	SEE SPECIFICATIONS	SW-CUSTOM-OC-25 CLOUD COVER, SEMI-GLOSS FINISH		CONSULTATION ROOM DOOR FRAME MOST DOORS & FRAMES, EXCLUDES CONSULTATION ROOM PROVIDED AND INSTALLED BY LANDLORD	
	P-3	PAINT	SHERWIN WILLIAMS	SEE SPECIFICATIONS	SW-CUSTOM-OC-16 CEDAR KEY, SEMI-GLOSS FINISH		PROVIDED AND INSTALLED BY LANDLORD	
	P-4	PAINT	SHERWIN WILLIAMS	SEE SPECIFICATIONS	SW-CUSTOM-2108-20 SIERRA SPRUCE, SEMI-GLOSS FINISH		PROVIDED AND INSTALLED BY LANDLORD	
	P-6	PAINT	SHERWIN WILLIAMS	SEE SPECIFICATIONS	SW-CUSTOM-995 MOCHA CREAM		PRECOAT TO MATCH CEILING TILES PROVIDED AND INSTALLED BY LANDLORD	
LAMINATE	P-8	PAINT	SHERWIN WILLIAMS	SEE SPECIFICATIONS	SW7012 CREAMY, FINISH: SEE SPECIFICATIONS		PHARMACY, BACK OF HOUSE PROVIDED AND INSTALLED BY LANDLORD SEE DRAWINGS FOR FINAL APPROVED LOCATION	
	P-12	PRIMER	SHERWIN WILLIAMS	MULTI-PURPOSE LATEX PRIMER/ SEALER	SW - B51W00450		GENERAL, UNDER WALL COVERINGS PROVIDED AND INSTALLED BY LANDLORD SEE DRAWINGS FOR FINAL APPROVED LOCATION	
	PL-1	LAMINATE	NEVAMAR	SEE SPECIFICATIONS	WZ2001T SANTA ROSA PLUM TREE, ARMORED PROTECTION, TEXTURED FINISHED		SEE DECOR DRAWINGS FOR FINAL APPROVED LOCATION	
	PL-5	LAMINATE	WILSONART	SEE SPECIFICATIONS	4944-38 CASUAL LINEN, HORIZONTAL GRADE 605		COUNTER TOPS SEE DECOR DRAWINGS FOR FINAL APPROVED LOCATION	
	PL-7	LAMINATE	LAMIN-ART	SEE SPECIFICATIONS	2428-A BISQUE, CHRYSALIS FINISH		10" FACIA/AVANCE SEE DECOR DRAWINGS FOR FINAL APPROVED LOCATION	
STOREFRONT & GLAZING	WF-1	FROSTED WINDOW FILM	SCOTCHCAL	PLEXIGLAS	7725-324	1/4"	GENERAL CONSULTATION PROVIDED AND INSTALLED BY LANDLORD	
	WF-2	FROSTED PLEXIGLAS	PLEXIGLAS	SOLARGARD	P-95		PROVIDED AND INSTALLED BY LANDLORD. NOTE: FROSTED ON / INTERIOR SIDE	
	WF-3	WINDOW FILM	SOLARGARD	SLATE-10 (INTERIOR)			PROVIDED AND INSTALLED BY LANDLORD	
MASONRY			LATICRETE	GROUT	#89 SMOKE GREY #H160 DELOREAN GRAY	VARIES (SEE ELEVATIONS) VARIES (SEE ELEVATIONS)	BR-1 & BR-3 BR-2, BR-4 & BR-5 PROVIDED AND INSTALLED BY LANDLORD	
							RESTROOMS PROVIDED AND INSTALLED BY LANDLORD	
TOILET								

**Issues/Revisions:**

No.	Description	Date

**Key Plan:**



Block: Lot: District: Map:

**DOB Approvals:**

**B Scan Sticker:**

Project/Building:  
**Rite Aid Store**  
**85 Avenue D, New York, NY 10009**

Sheet Title:  
**FINISH SCHEDULE**

Seal: Project Number: 1639  
Date: 3/27/2017  
Scale: 6" = 1'-0"

**F-101.00**