















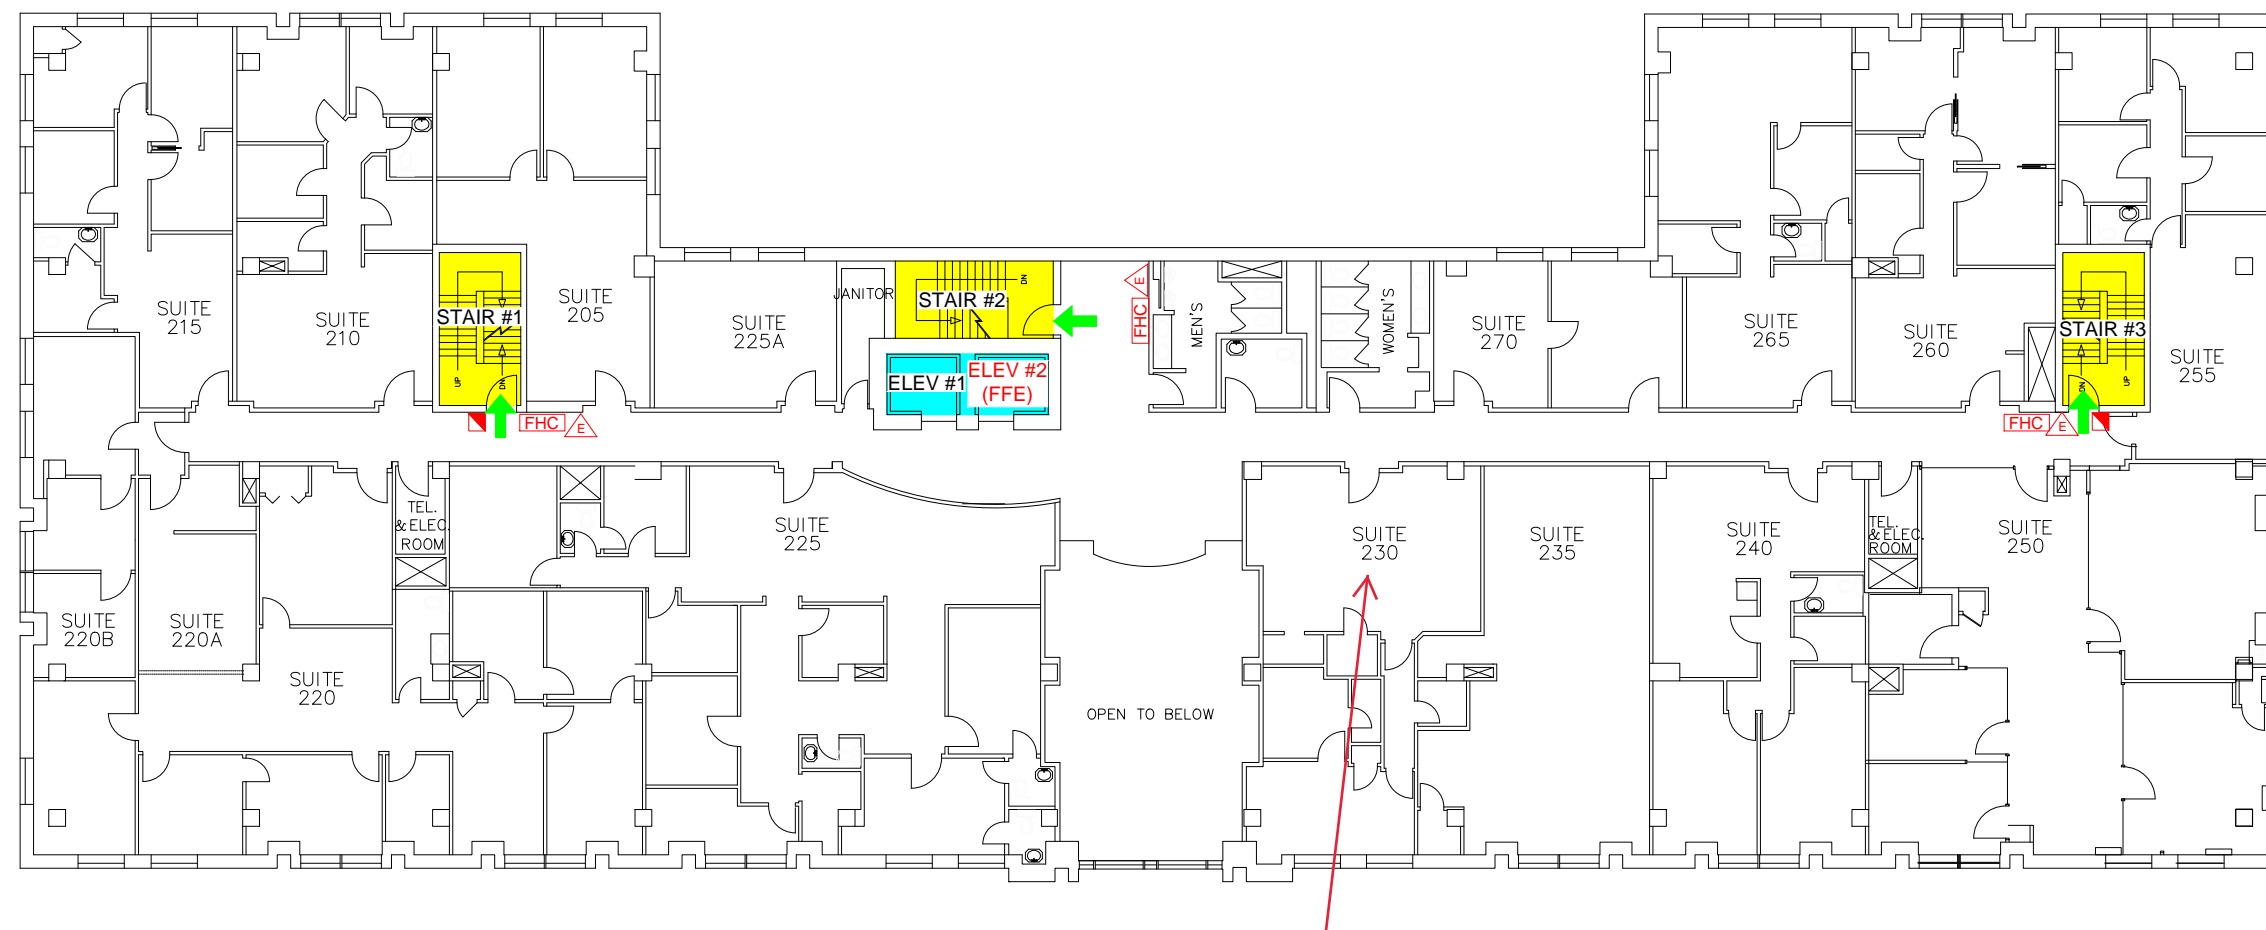


LEGEND

-  MANUAL PULL STATION
-  ELECTROMAGNETIC LOCKING DEVICE
-  SMOKE DETECTOR
-  HEAT DETECTOR
-  FIRE PUMP
-  FIRE EXTINGUISHER
-  FIRE HOSE CABINET
-  SP STANDPIPE SYSTEM RISER
-  DRY SPRINKLER RISER
-  WET SPRINKLER RISER
-  FIRE SAFETY PLAN BOX
-  AP FIRE ALARM ANNUNCIATOR PANEL
-  CP FIRE ALARM CONTROL PANEL
-  BUILDING / FLOOR EXIT
-  EXIT STAIR SHAFT
-  ELEVATOR SHAFT



PROJECT
340 COLLEGE STREET
 340 COLLEGE STREET
 TORONTO ONTARIO

TITLE
SECOND FLOOR

FIRE SAFETY PLAN

DRAWN BY S.Z.	CHECKED BY B.L.	SHEET 06 of 11
OCT 2021	DWG NO.	FSP-6
4T1911530		
NTS		

REV/DATE: FILE NAME: Y:\Shared\Legacy\CAM\TOR\Proj\2019\Design\Drawings\4T1911530_340_College_SL_FSP_Update\06_Working_Docs\Drawings\4T1911530_RB_340_College_SL_FSP_Dwgs.dwg LAYOUT NAME: FSP-6 PLOTTED: Friday, October 29, 2021 - 11:36pm