


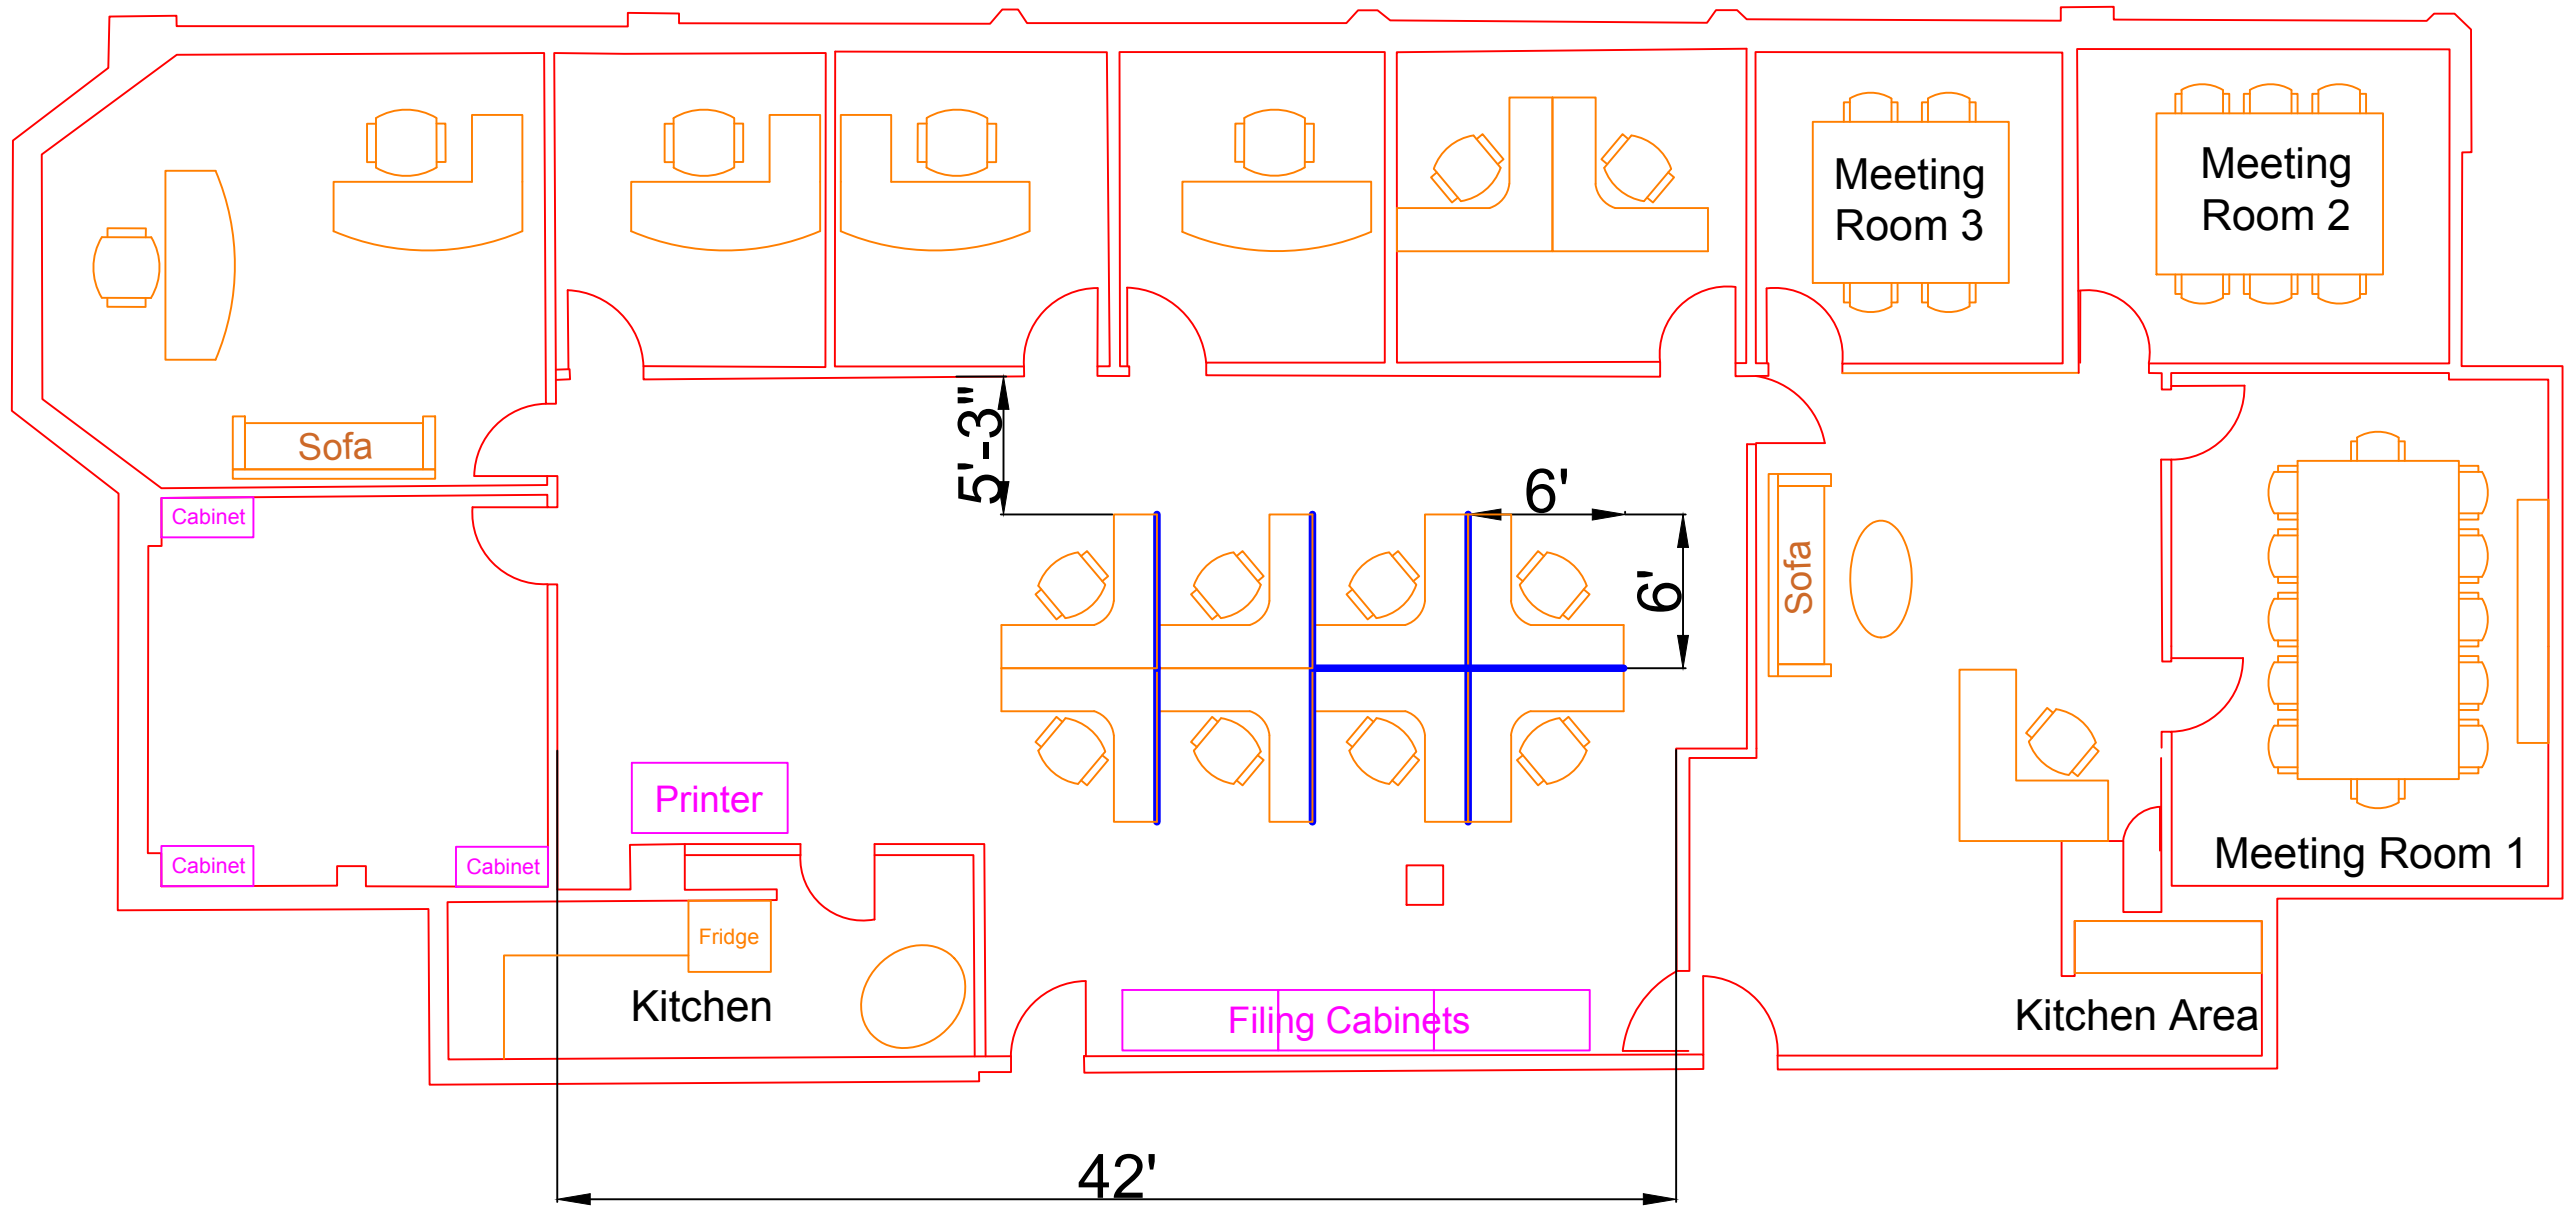

THIS DRAWING IS AN INSTRUMENT OF SERVICE, IS PROVIDED BY AND IS THE PROPERTY OF SKY CLEAN ENERGY LTD. THIS DRAWING CANNOT BE MODIFIED AND/OR REPRODUCED WITHOUT THE CONSENT OF THIS OFFICE



275 RENFREW DR, SUIT 204
MARKHAM, ON L3R 0C8
T: (905) 604 4436
F: (905) 604 4437

ISSUE STAGE:
ISSUE STAGE

ENGINEER'S SEAL

DRAWING NAME:
Sky Office Floor Plan

DRAWN BY: X.X.	CHECKED BY: F.R.
SCALE: N.T.S.	DATE: 01/04/2022

PROJECT NAME:

PROJECT NO.:

DRAWING NO: E-0	REV. NO: 00
--------------------	----------------