


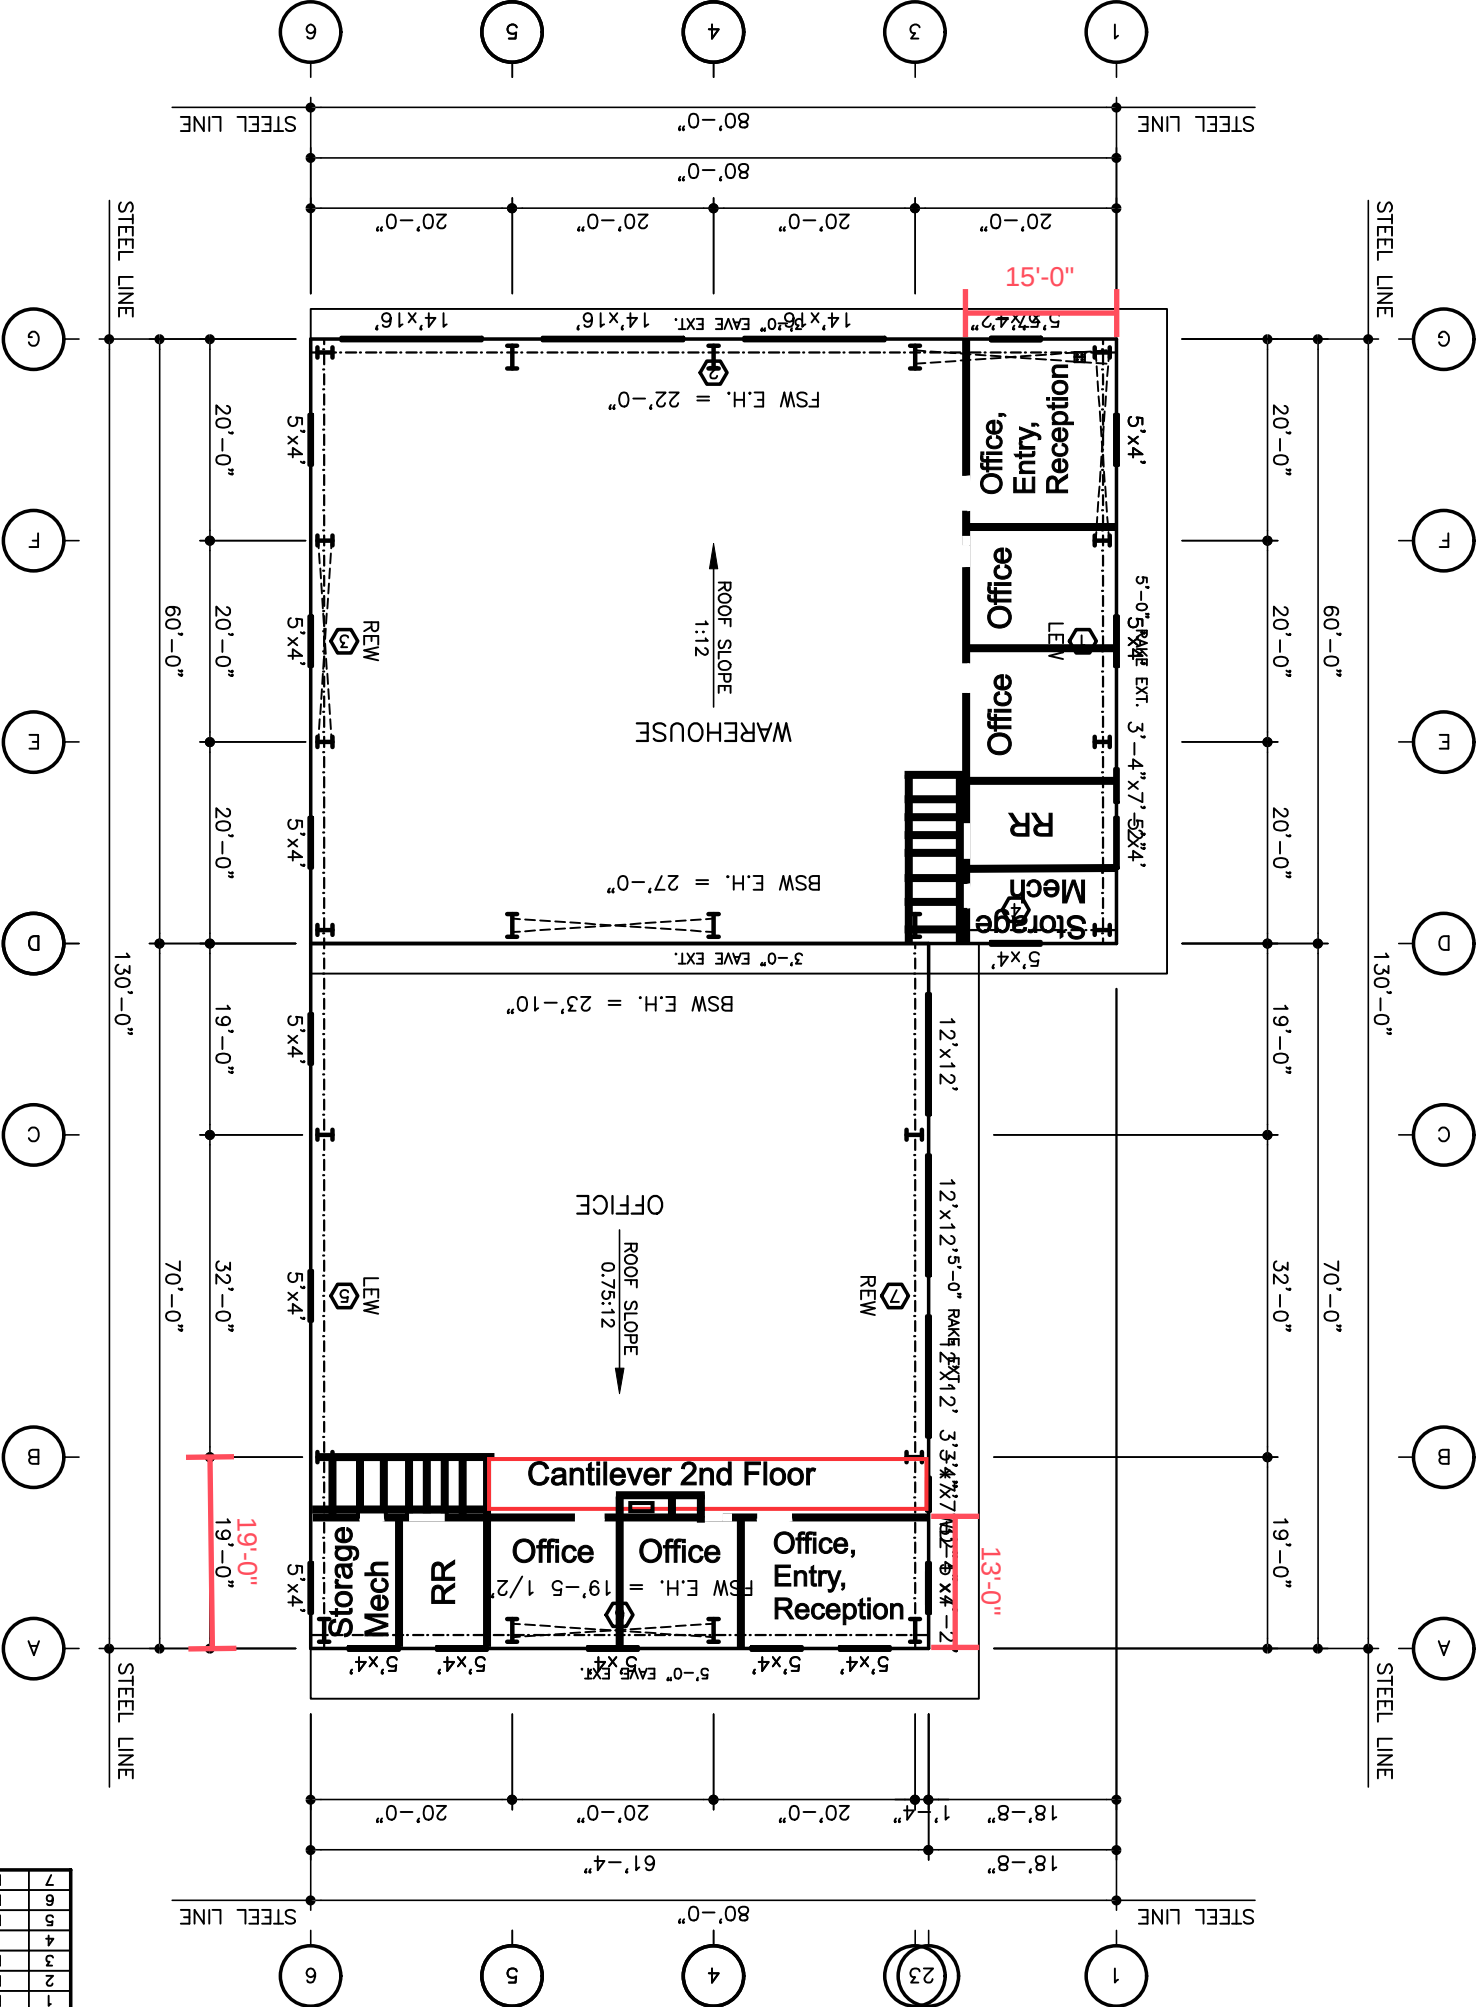

WALL LINER PANEL SCHEDULE			
④	LINER TYPE	DIST. FROM LEFT BOTTOM OF PANEL AFF	TOP OF PANEL AFF
1	FULL WIDTH	0'-0"	8'-0"
2	FULL WIDTH	0'-0"	8'-0"
3	FULL WIDTH	0'-0"	8'-0"
4	PARTIAL	60'-0"	20'-0"
5	FULL WIDTH	0'-0"	8'-0"
6	FULL WIDTH	0'-0"	8'-0"
7	FULL WIDTH	0'-0"	8'-0"

DO NOT USE FOR FINAL CONSTRUCTION

SHEET TITLE:
PRELIMINARY FLOOR PLAN

SHEET NUMBER:
FP1

2/20/2025 7:03 PM

QUOTE NUMBER:
12232024-03

PROJECT NAME:
BRYCE – OFFICE AND WAREHOUSE V4

BENTON CITY, WA

CUSTOMER NAME:
CRF METAL WORKS

PASCO, WA