
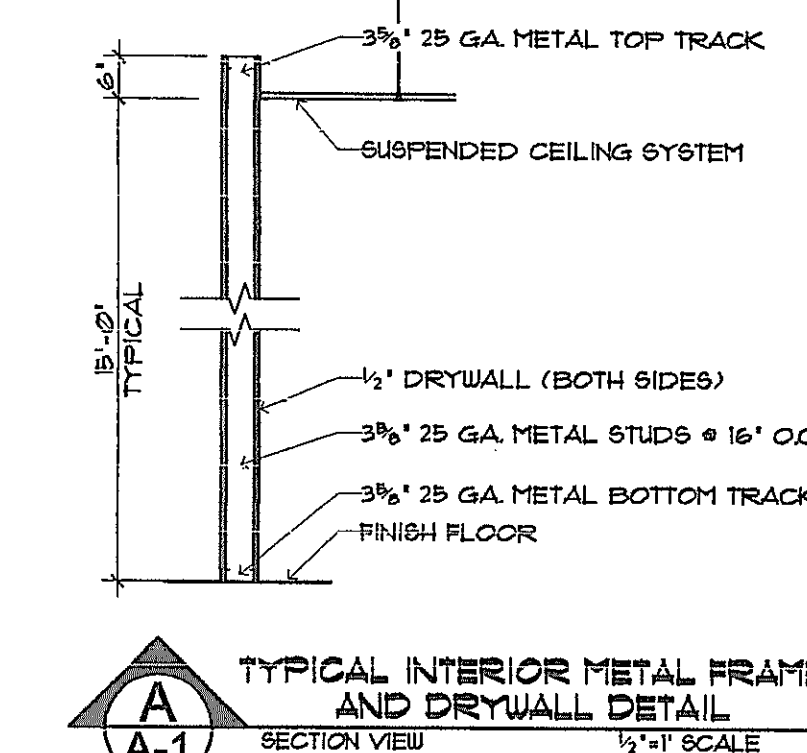
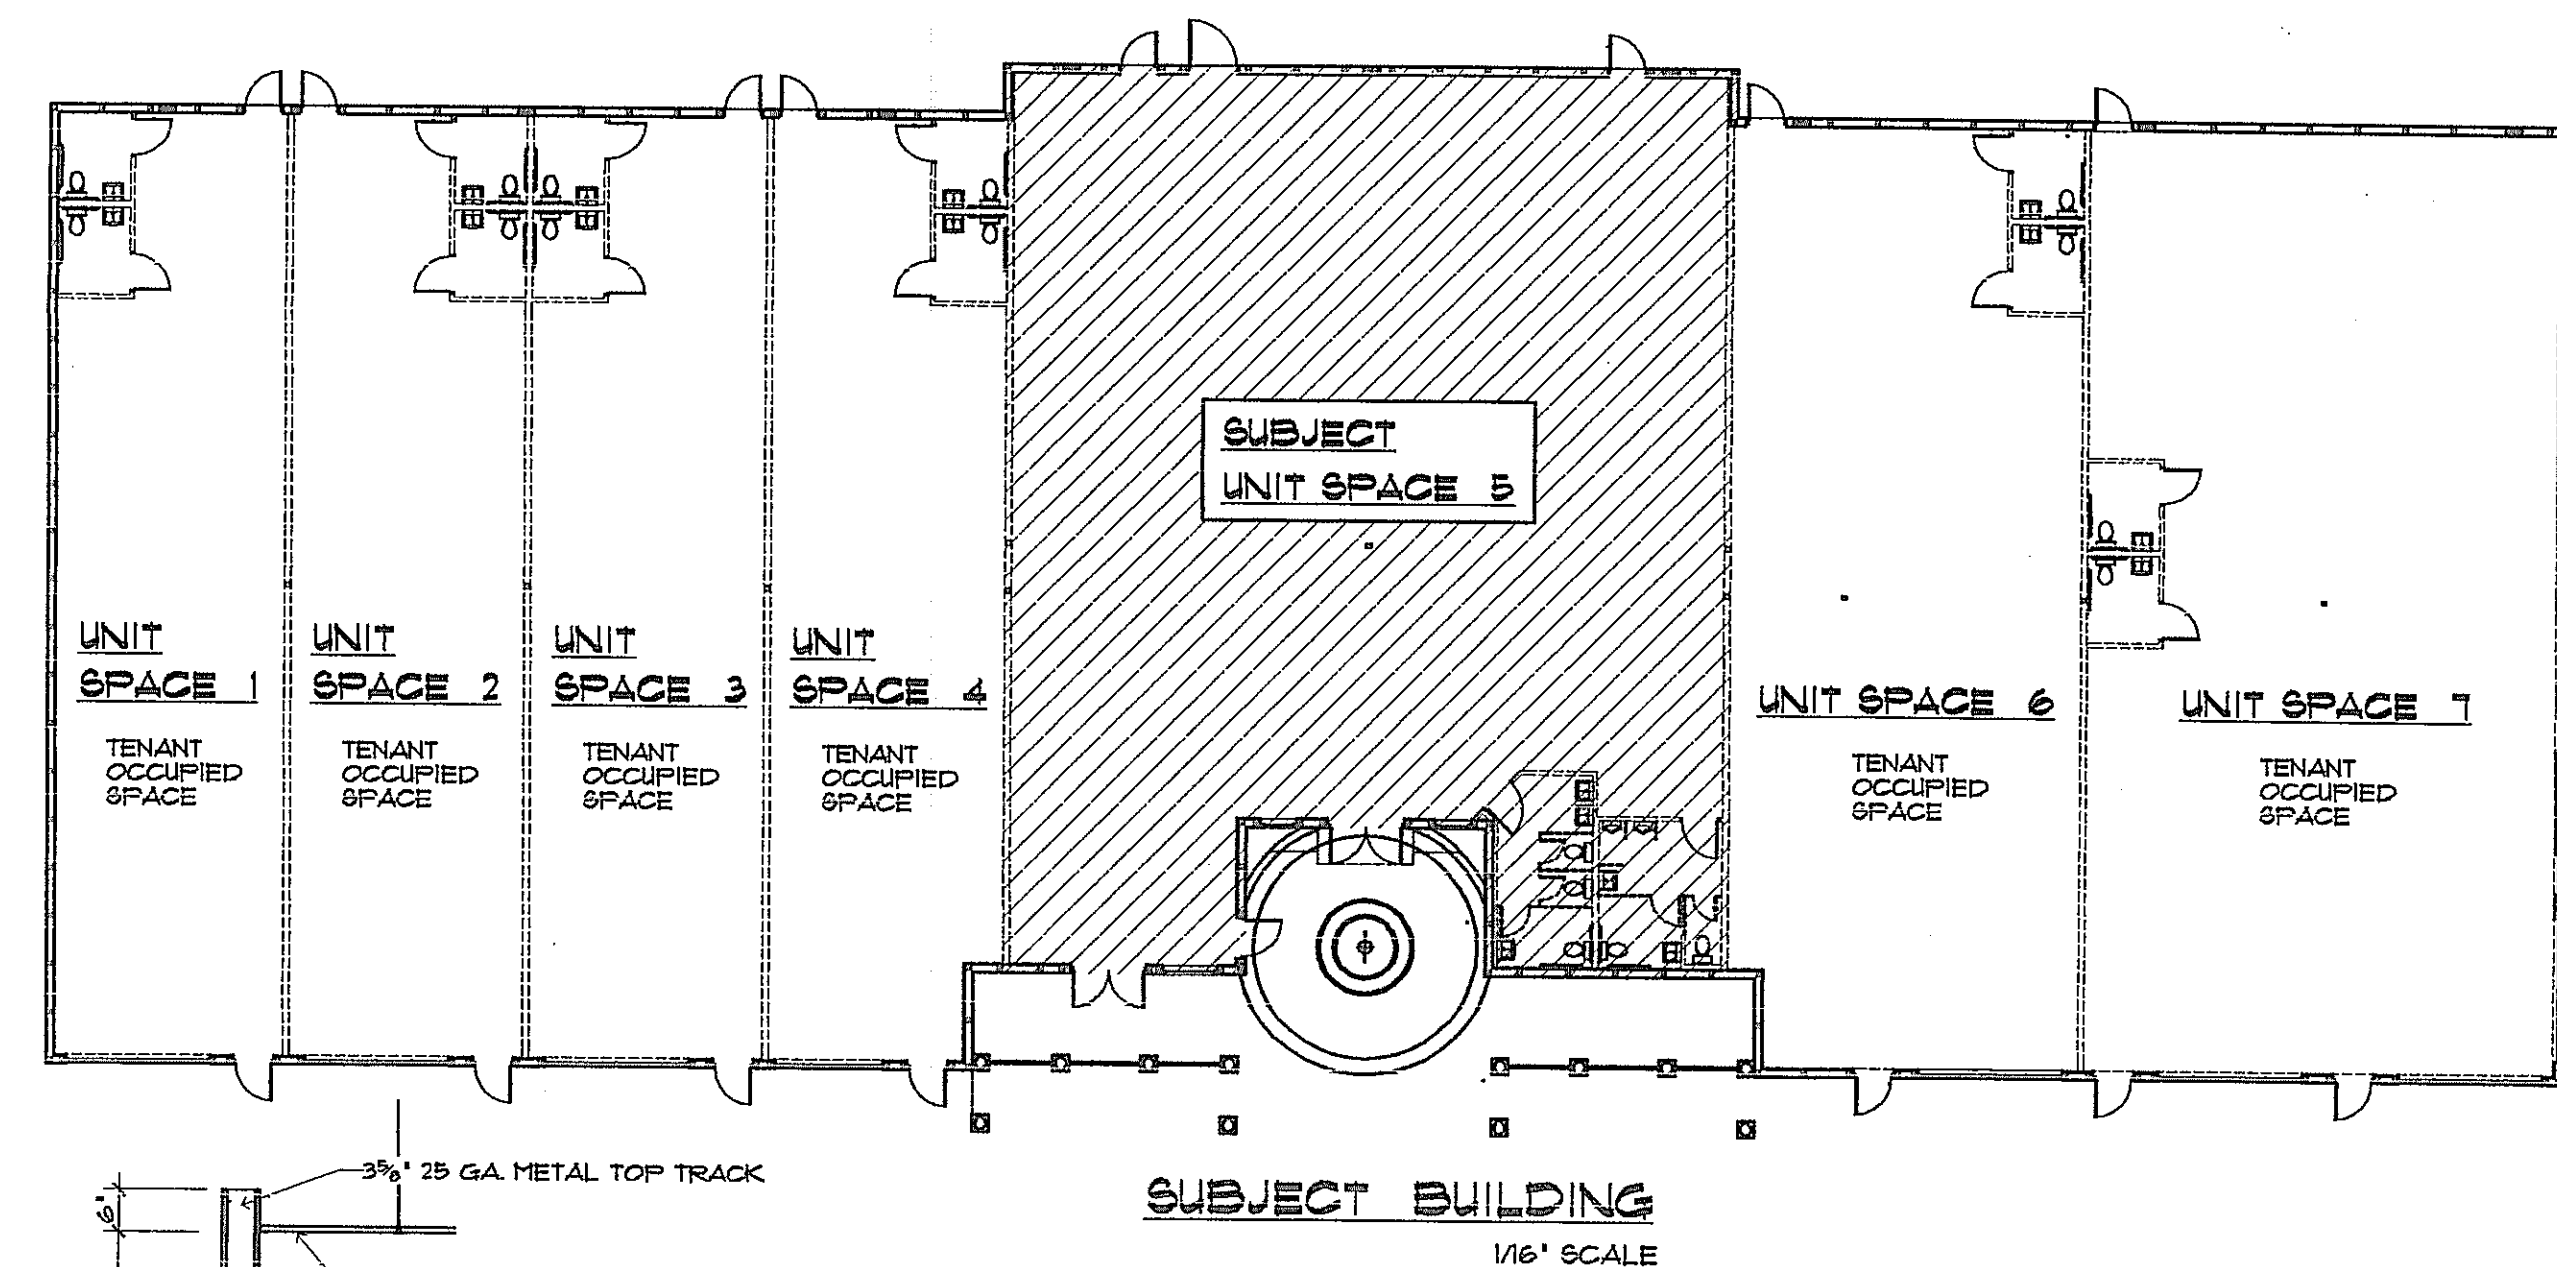
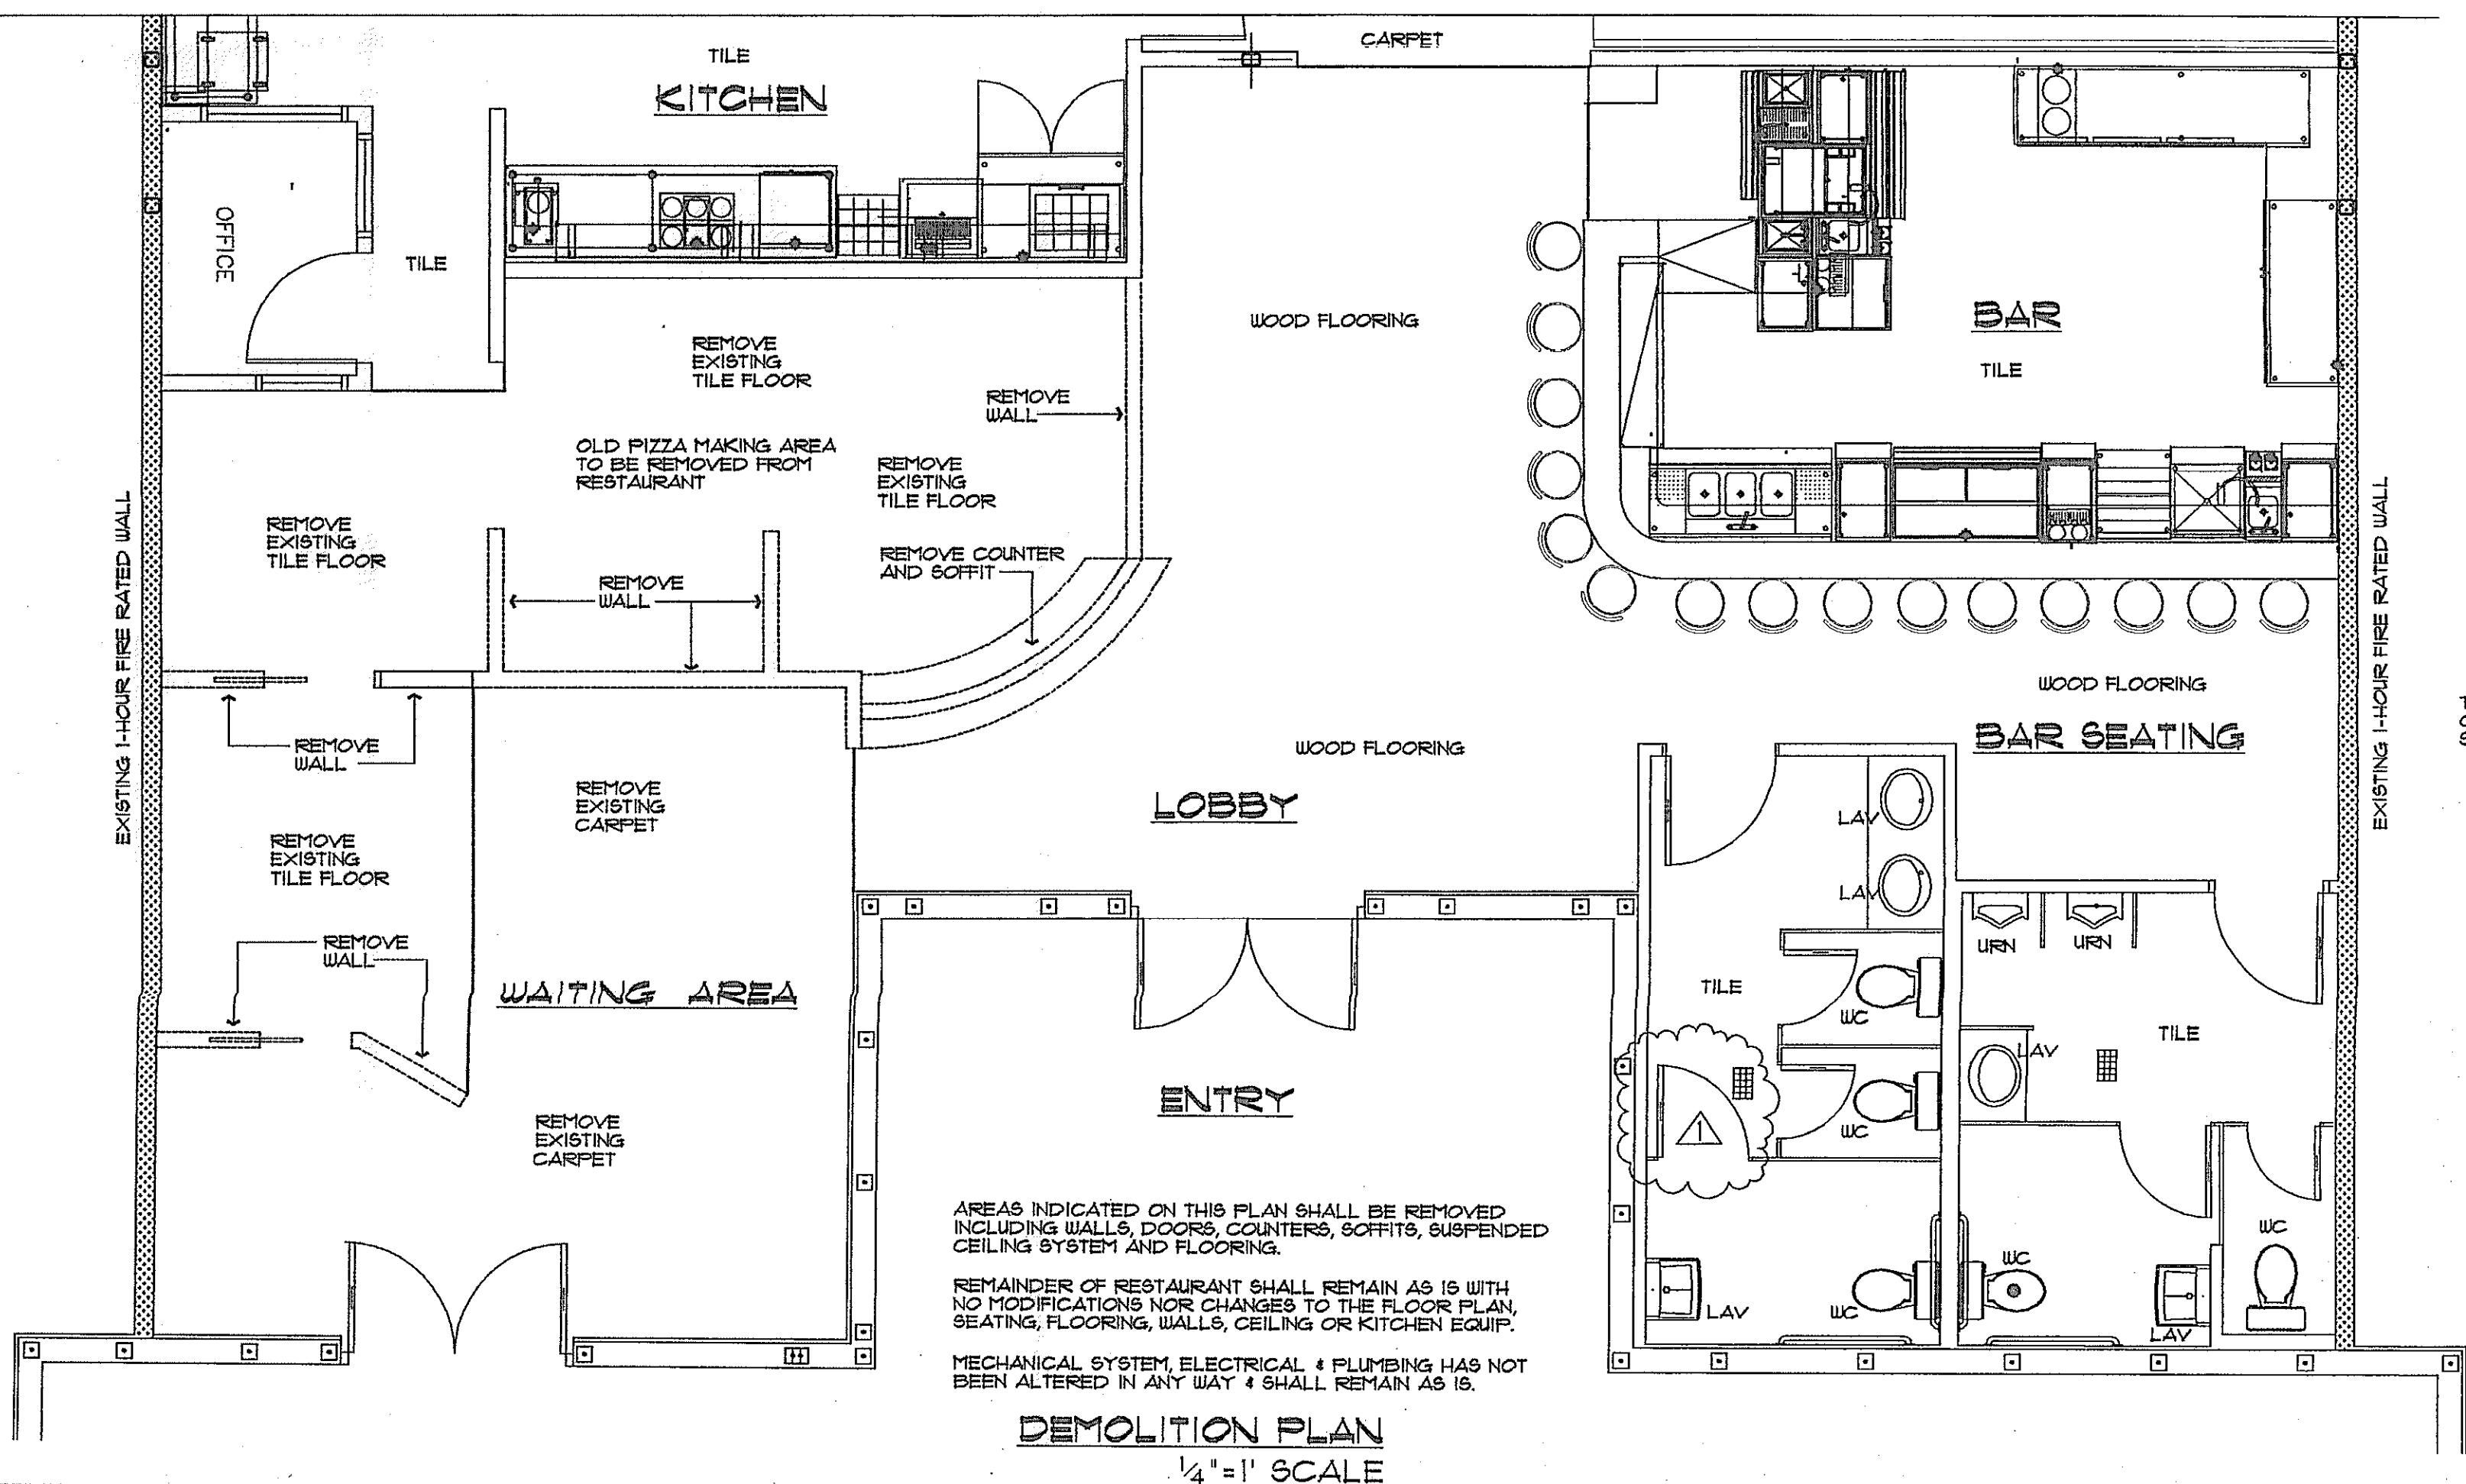


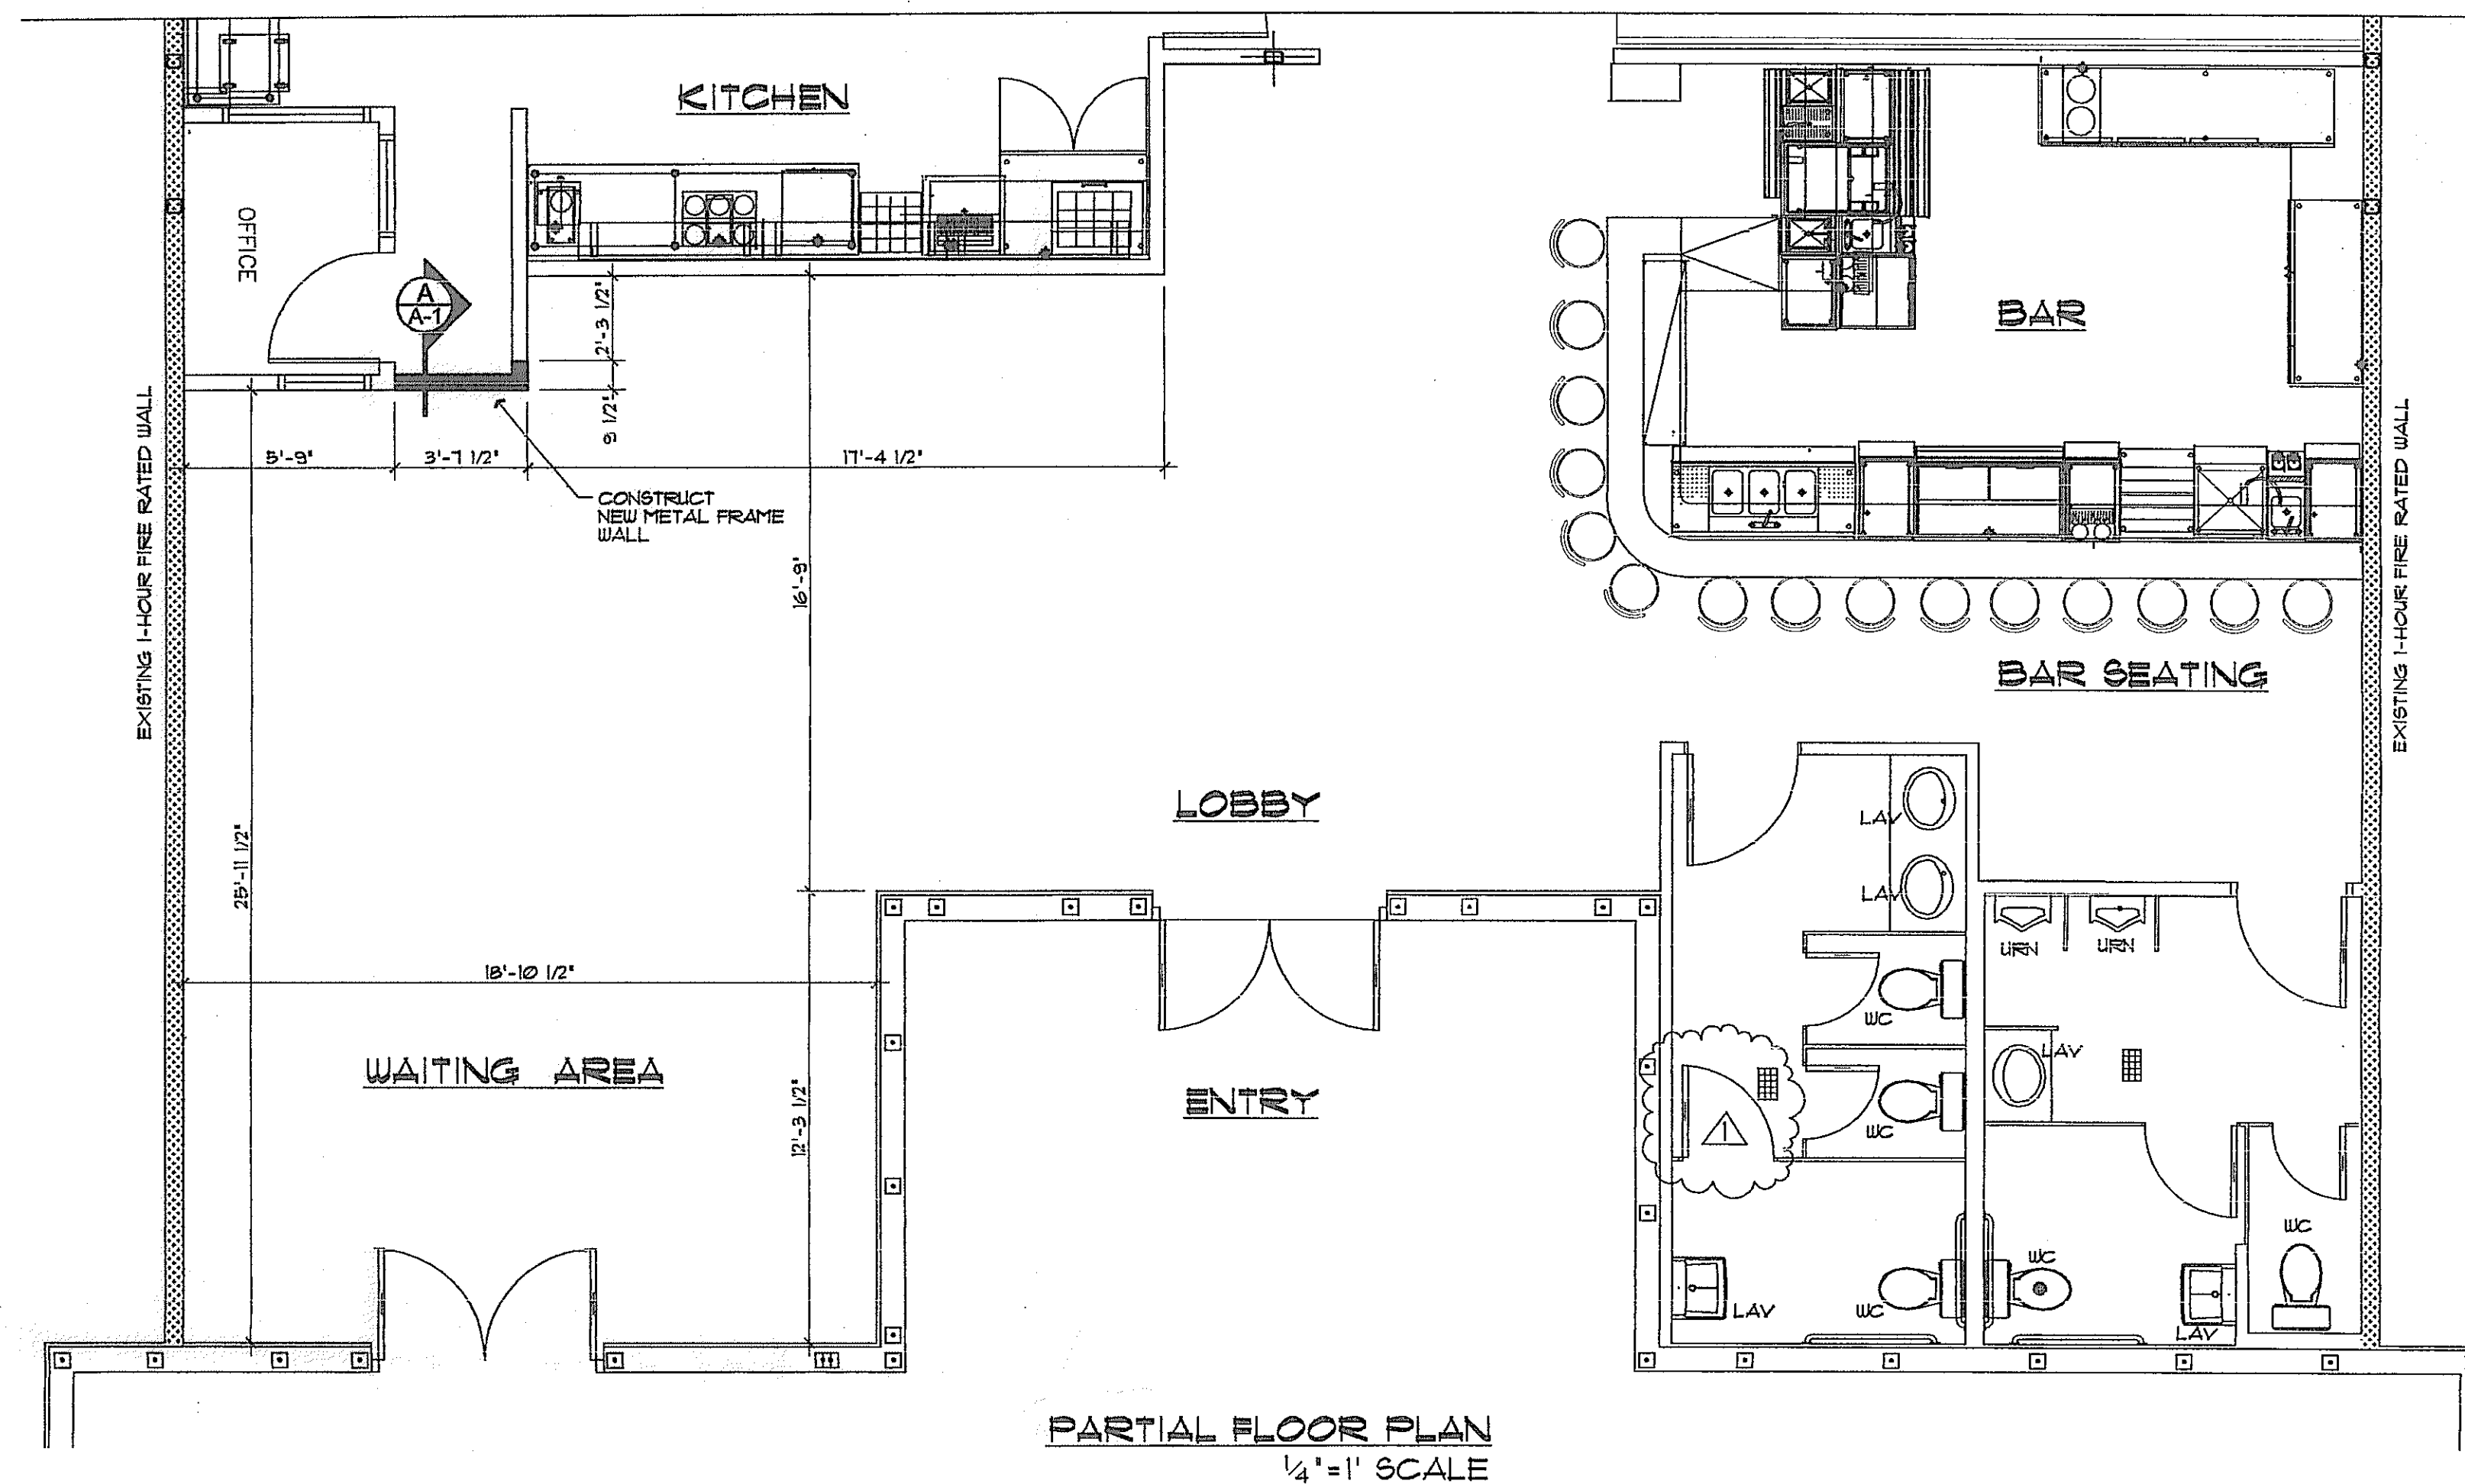


COMPLIANCE EXISTING BUILDING

THIS PROJECT WILL BE CLASSIFIED UNDER CHAPTER 4 "CLASSIFICATION OF WORK" IN THE FLORIDA BUILDING CODE - EXISTING BUILDING, SECTION 403 ALTERATION LEVEL 1.

LEVEL 1 ALTERATIONS INCLUDES THE REMOVAL & REPLACEMENT OR THE COVERING OF EXISTING MATERIALS, SUBSTITUTIONS OF EQUIVALENTS THAT SERVE THE SAME PURPOSE.

INCLUDE ANY REMOVAL, REPLACEMENT OR COVERING OF EXISTING MATERIALS, ELEMENTS, EQUIPMENT OR FIXTURES UNDERTAKEN FOR PURPOSE OF REPAIR AS DEFINED IN CHAPTER 2 & DESCRIBED IN SECT. 402.

LEVEL 1 ALTERATIONS SHALL COMPLY WITH THE PROVISIONS OF CHAPT. 6.

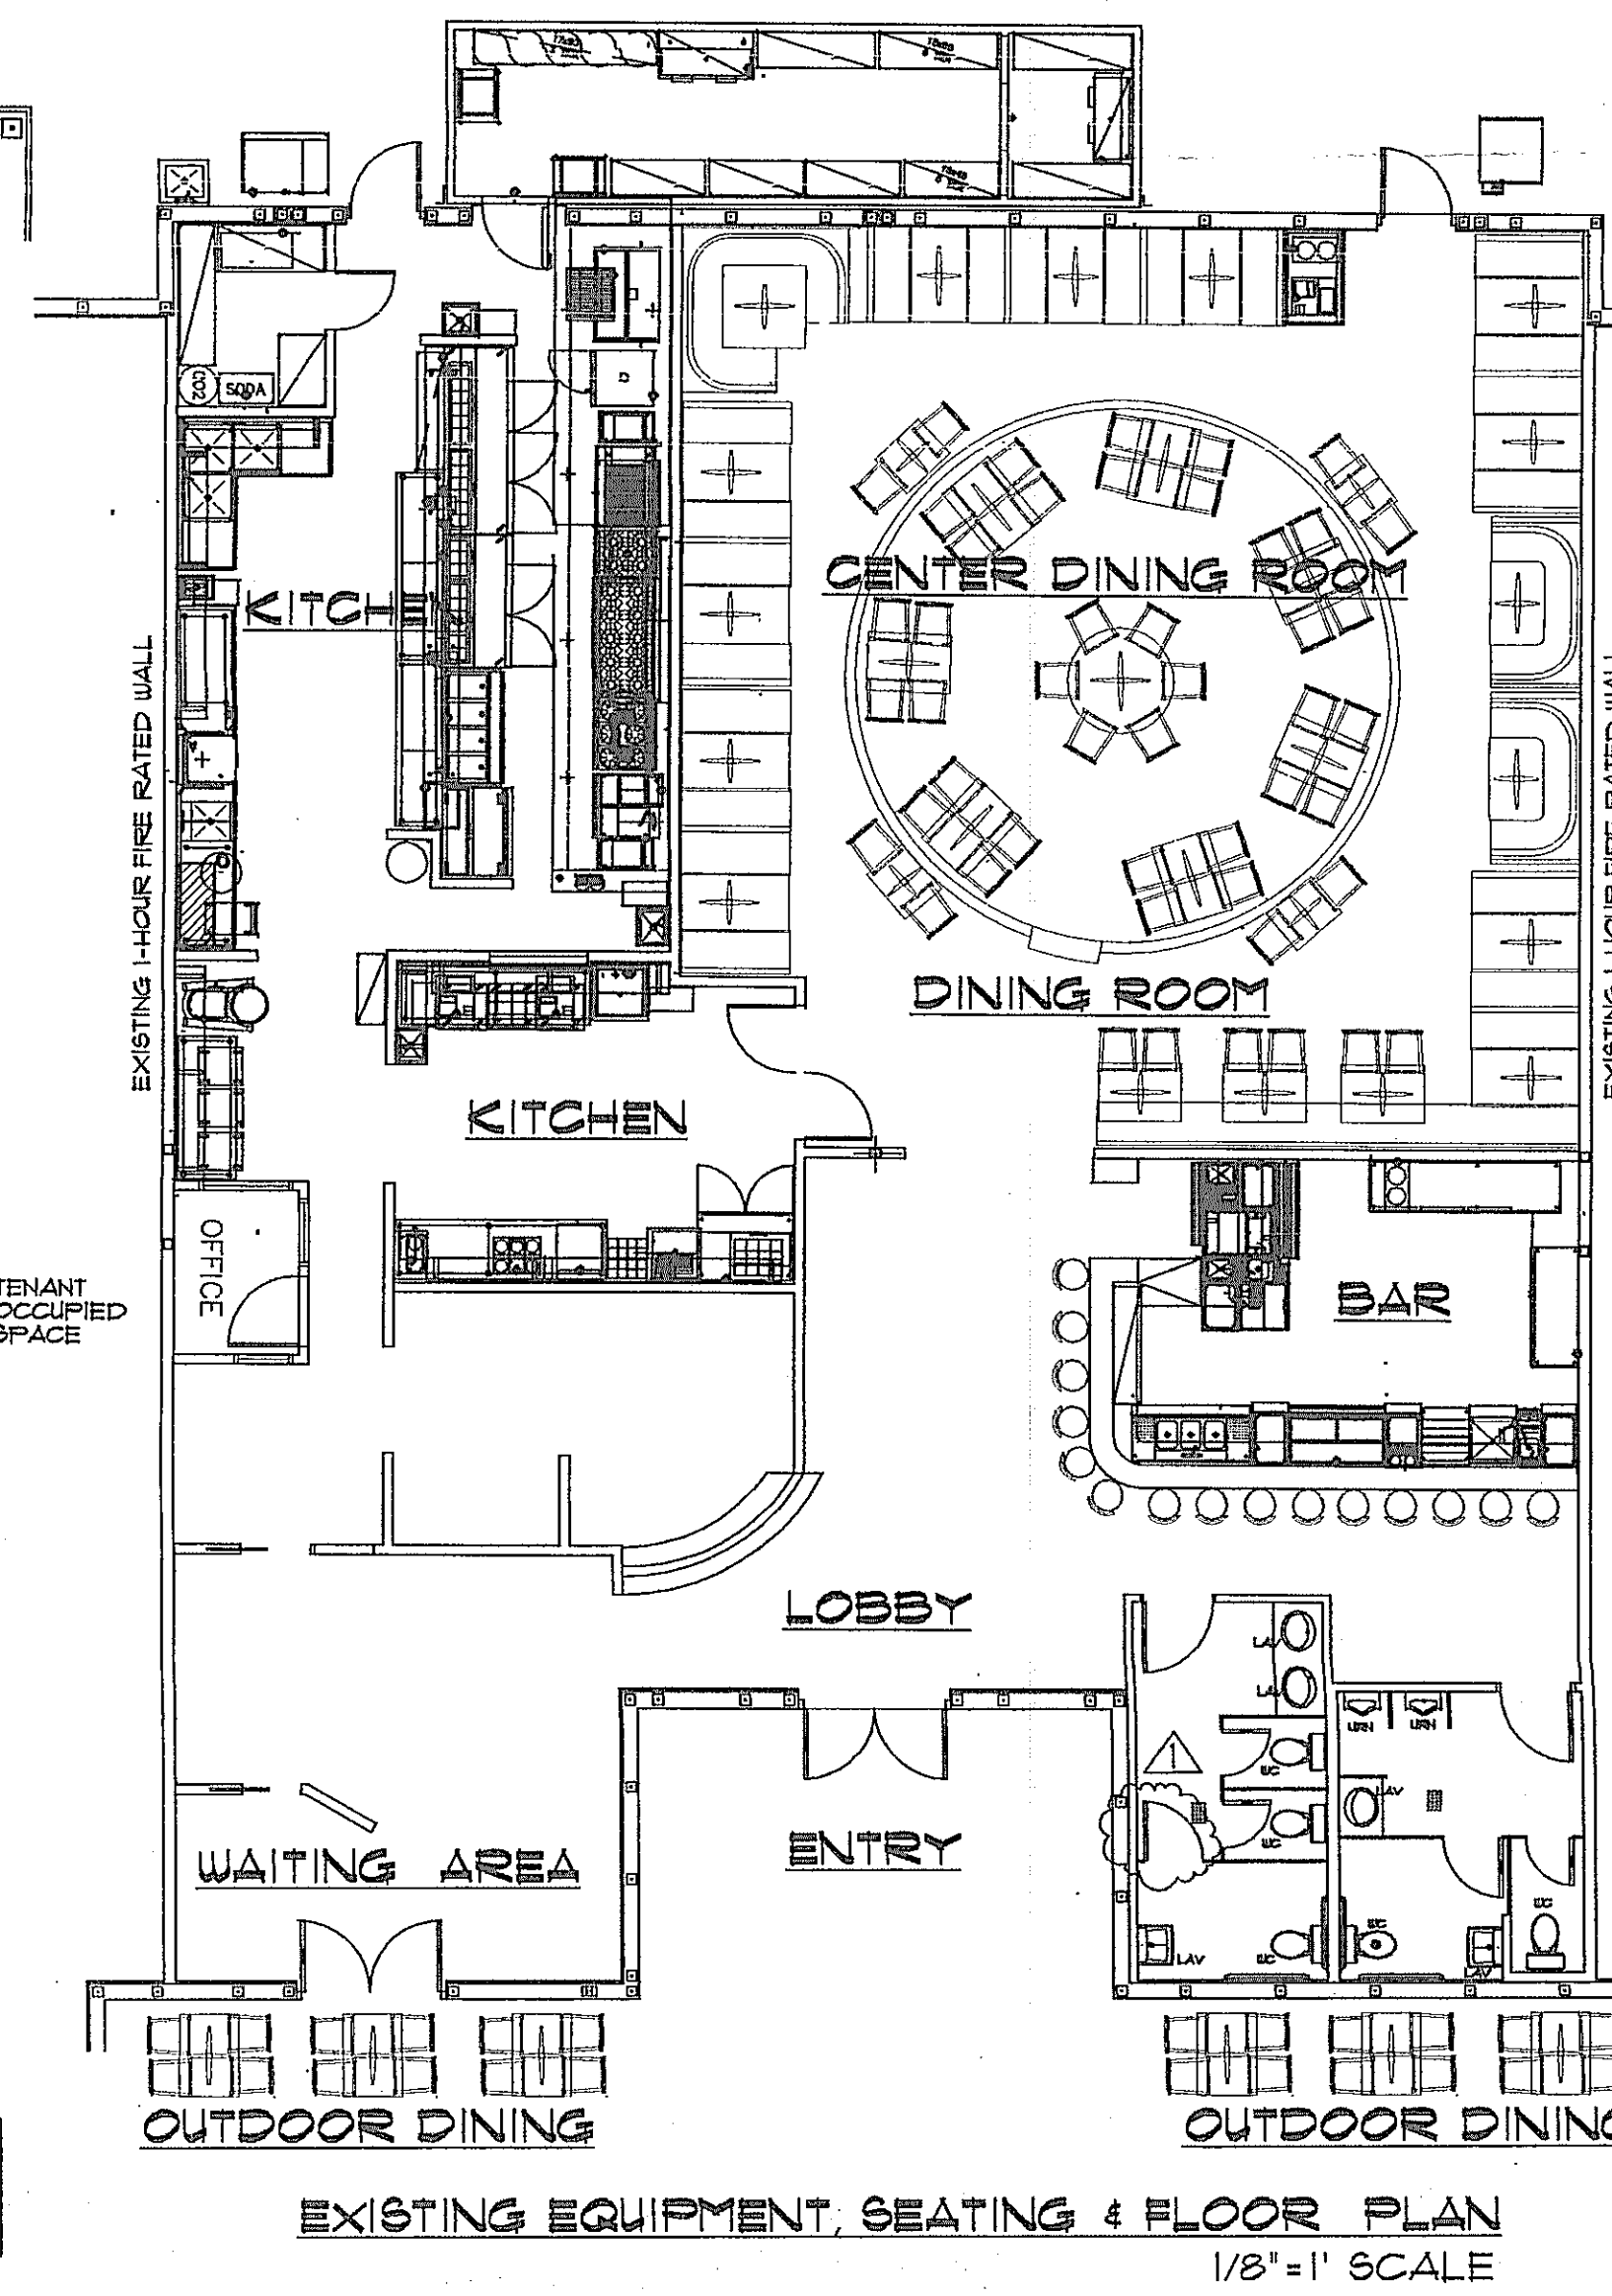

FIRE DISTRICT INSPECTION REQUIRED
Before A Certificate of Occupancy
Can Be Issued

REVIEWED FOR CODE COMPLIANCE
DEVELOPMENT SERVICES
By *[Signature]* DATE 11/14/2011

EXISTING BUILDING CONSTRUCTION:

- TYPE (1 & 2) SPRINKLED
- MASONRY-BLOCK EXTERIOR WALLS
- CONCRETE SLAB FLOORING
- METAL BAR JOIST & GIRDERS WITH METAL DECKING (WITH INSULATION) ROOF

OCCUPANCY GROUP

ASSEMBLY

FIRE NOTES:

- NO MODIFICATION IS REQUIRED TO THE EXISTING FIRE SPRINKLER SYSTEM
- NO NEW EXTERIOR WORK SHALL BE PERFORMED
- NO NEW PENETRATIONS ARE TO BE MADE INTO EXISTING FIRE RATED WALLS
- NO NEW FIRE RATED ASSEMBLIES SHALL BE INSTALLED.

WALL LEGEND

- EXISTING EXTERIOR CMU WALL
- EXISTING TENANT SEPARATION WALL WITH 1 HOUR FIRE RATING
- NEW 4" OR 6" FRAME WALL
- EXISTING FRAME WALL

THE CONSTRUCTION COST OF THIS PROJECT IS LESS THAN \$25,000

COMPLIANCE STATEMENT

THIS TENANT BUILD-OUT IN THIS BUILDING HAS BEEN DESIGNED IN ACCORDANCE WITH THE:

- 2001 FLORIDA BUILDING CODE
- 2001 EXISTING BUILDING CODE
- 2001 FLORIDA MECHANICAL CODE
- 2002 NATIONAL ELECTRIC CODE (N.E.C.)
- 2001 FLORIDA PLUMBING CODE
- 2001 FLORIDA FIRE PREVENTION CODE

J & P DESIGN GROUP, INC.
ARCHITECT

13381 EAGLE RIDGE DRIVE, UNIT 1411 FT. MYERS, FLORIDA 33912
PHONE (239) 788-2181 FAX (239) 788-8386
C. PAUL PRECHT, ARCHITECT AR0014356

THE HUNKY FISH
8911 DANIELS PARKWAY, UNIT 5, FT. MYERS, FLORIDA

© COPYRIGHT 2011
J & P DESIGN GROUP, INC.

WHEREAS EVERY ATTEMPT HAS BEEN MADE TO INCLUDE ALL DETAILS AND PERTINENT INFORMATION ON THE DRAWINGS, CONTRACTORS ARE RESPONSIBLE TO VERIFY ALL DIMENSIONS, DETAILS, AND INFORMATION PROVIDED ON THE DRAWINGS. CONTRACTORS SHALL NOTIFY J&P DESIGN GROUP IN WRITING, FOR ANY OMISSION, OR DISCREPANCY, ON THE DRAWINGS PRIOR TO THE START OF ANY WORK.

PRELIMINARY CONSTRUCTION ☒
FINAL RECORD ☐

DRAWN BY *D'ANGELO*
CHECKED BY *C.P.P.*





DATE 11-2-2011

REVISIONS
11-10-2011

SHEET NO.

A-1

JOB NO. 11-023

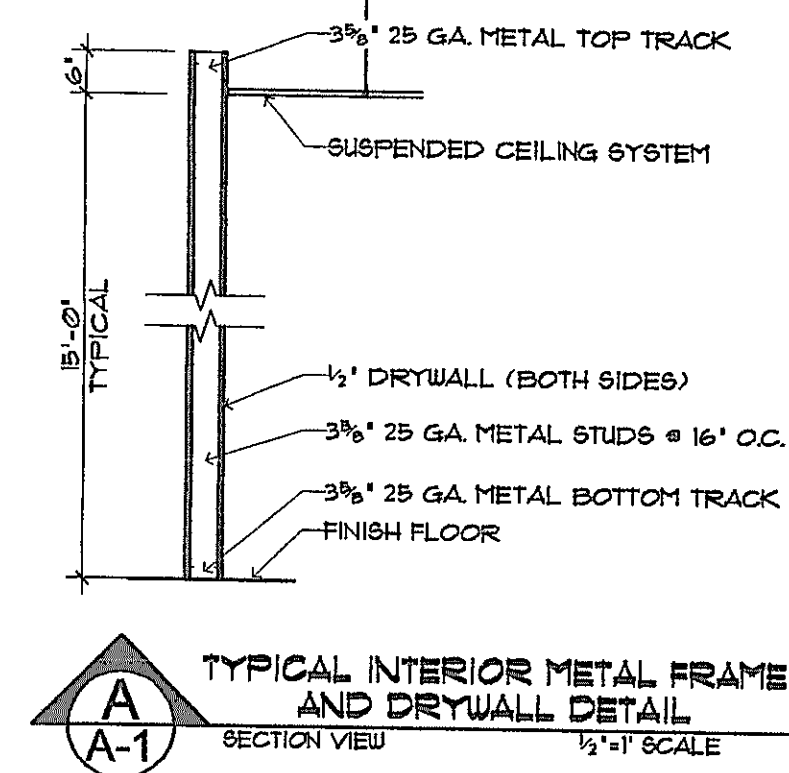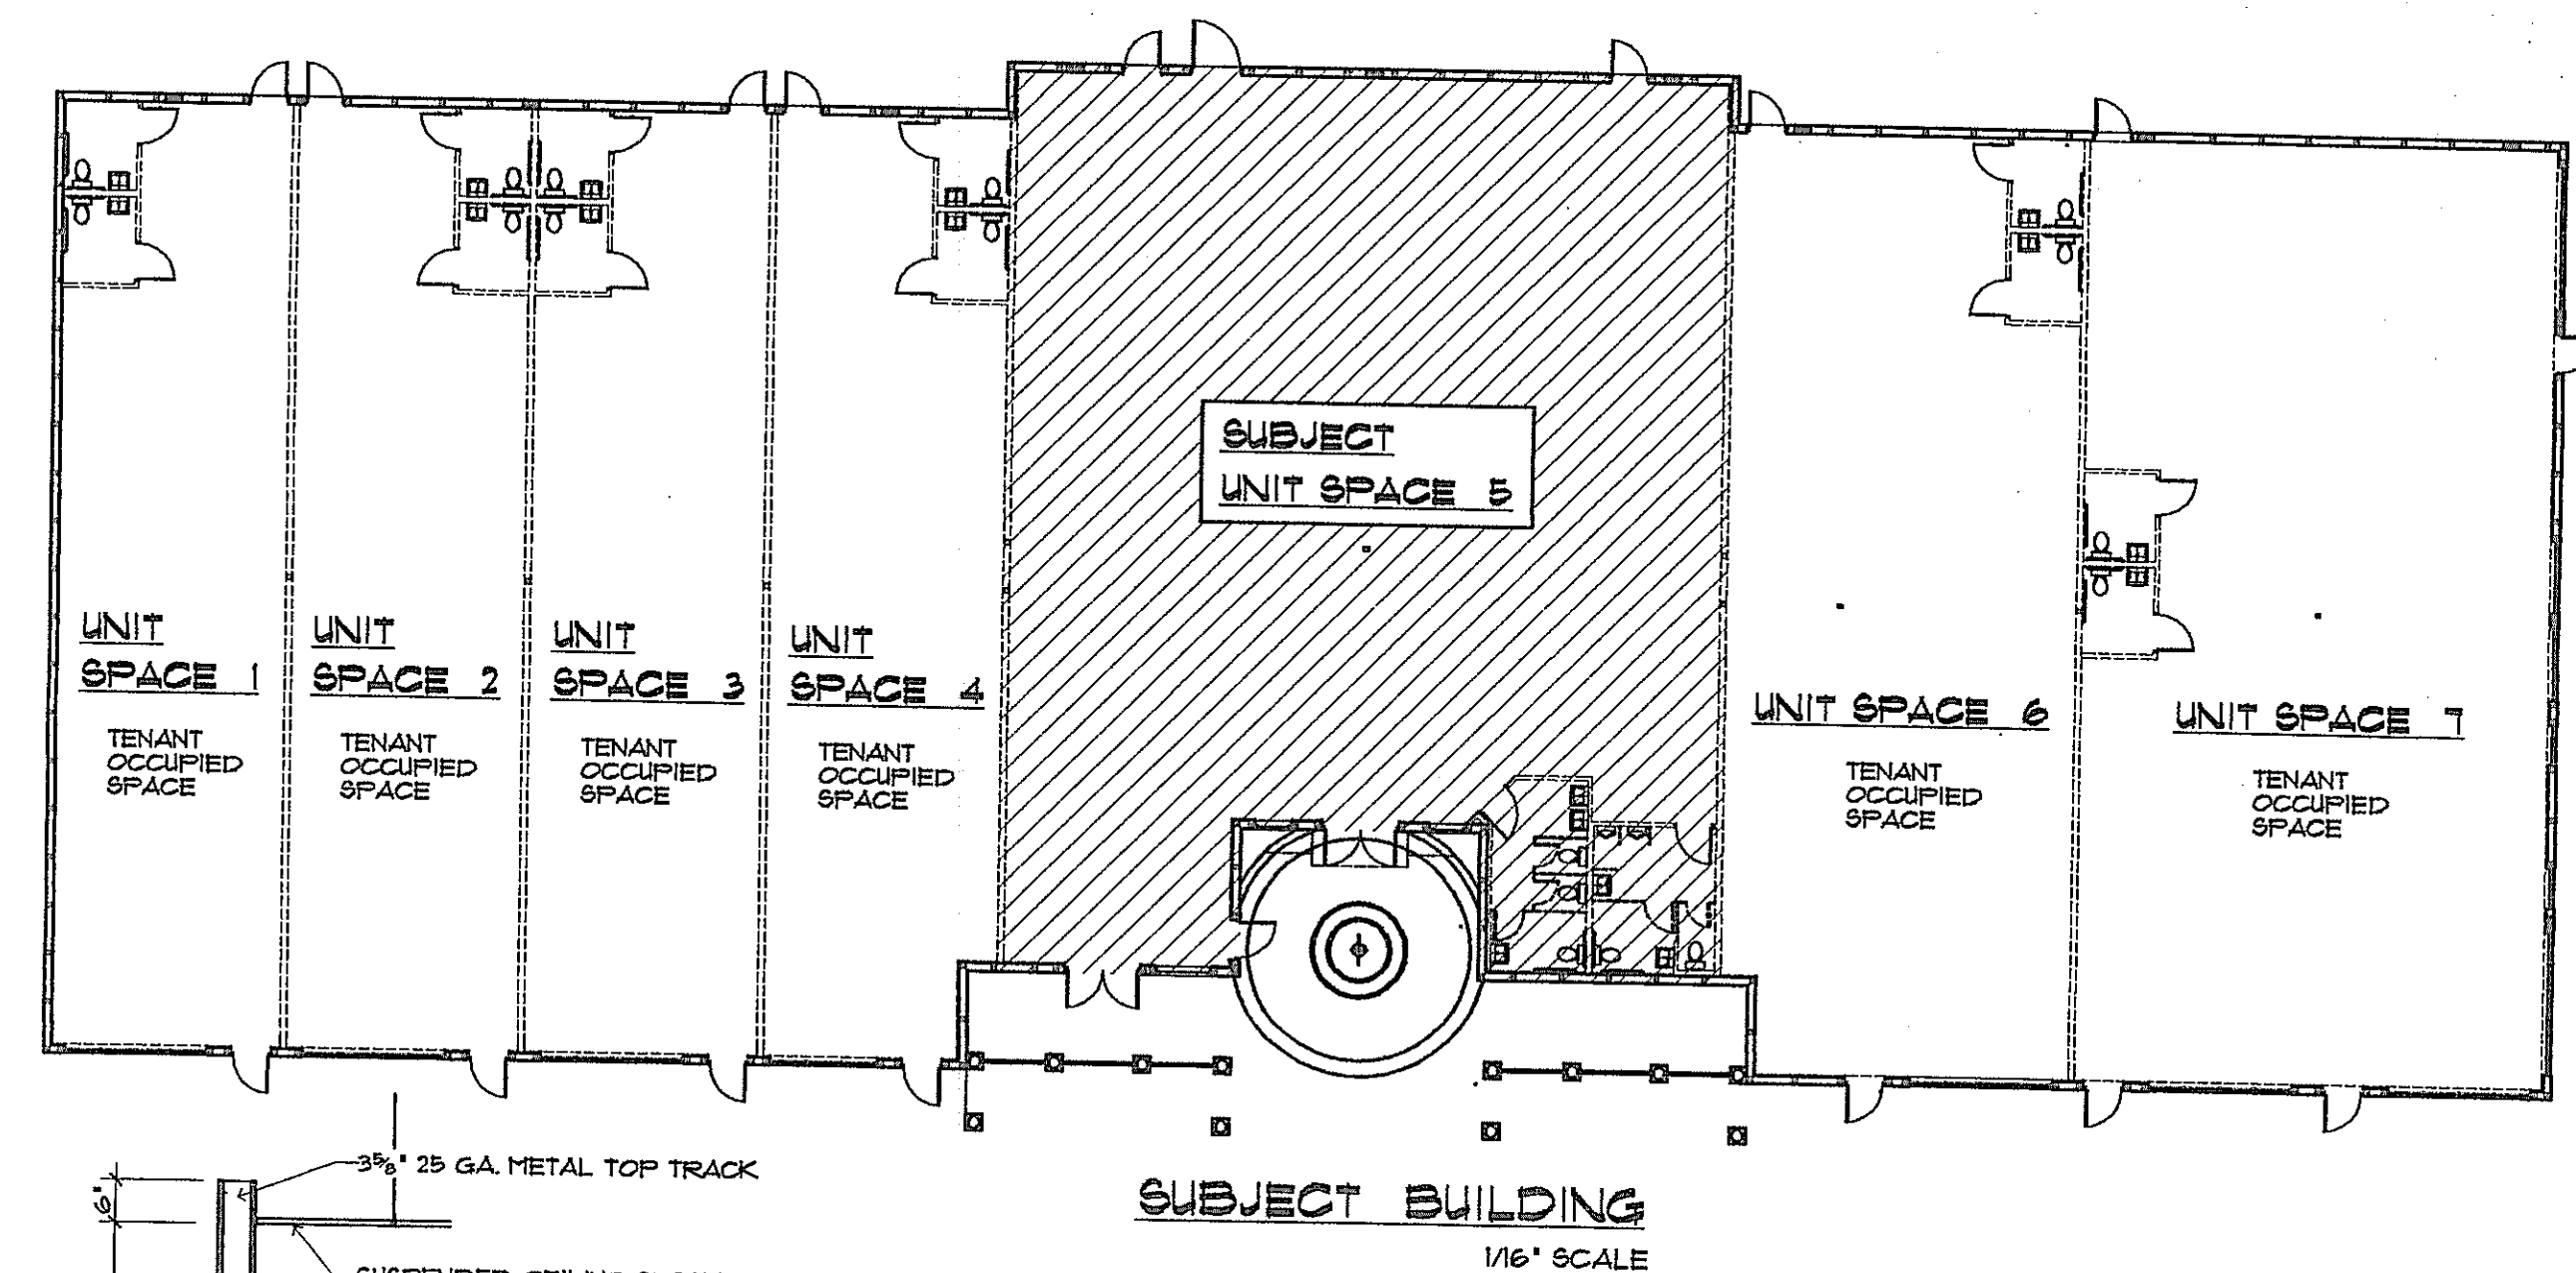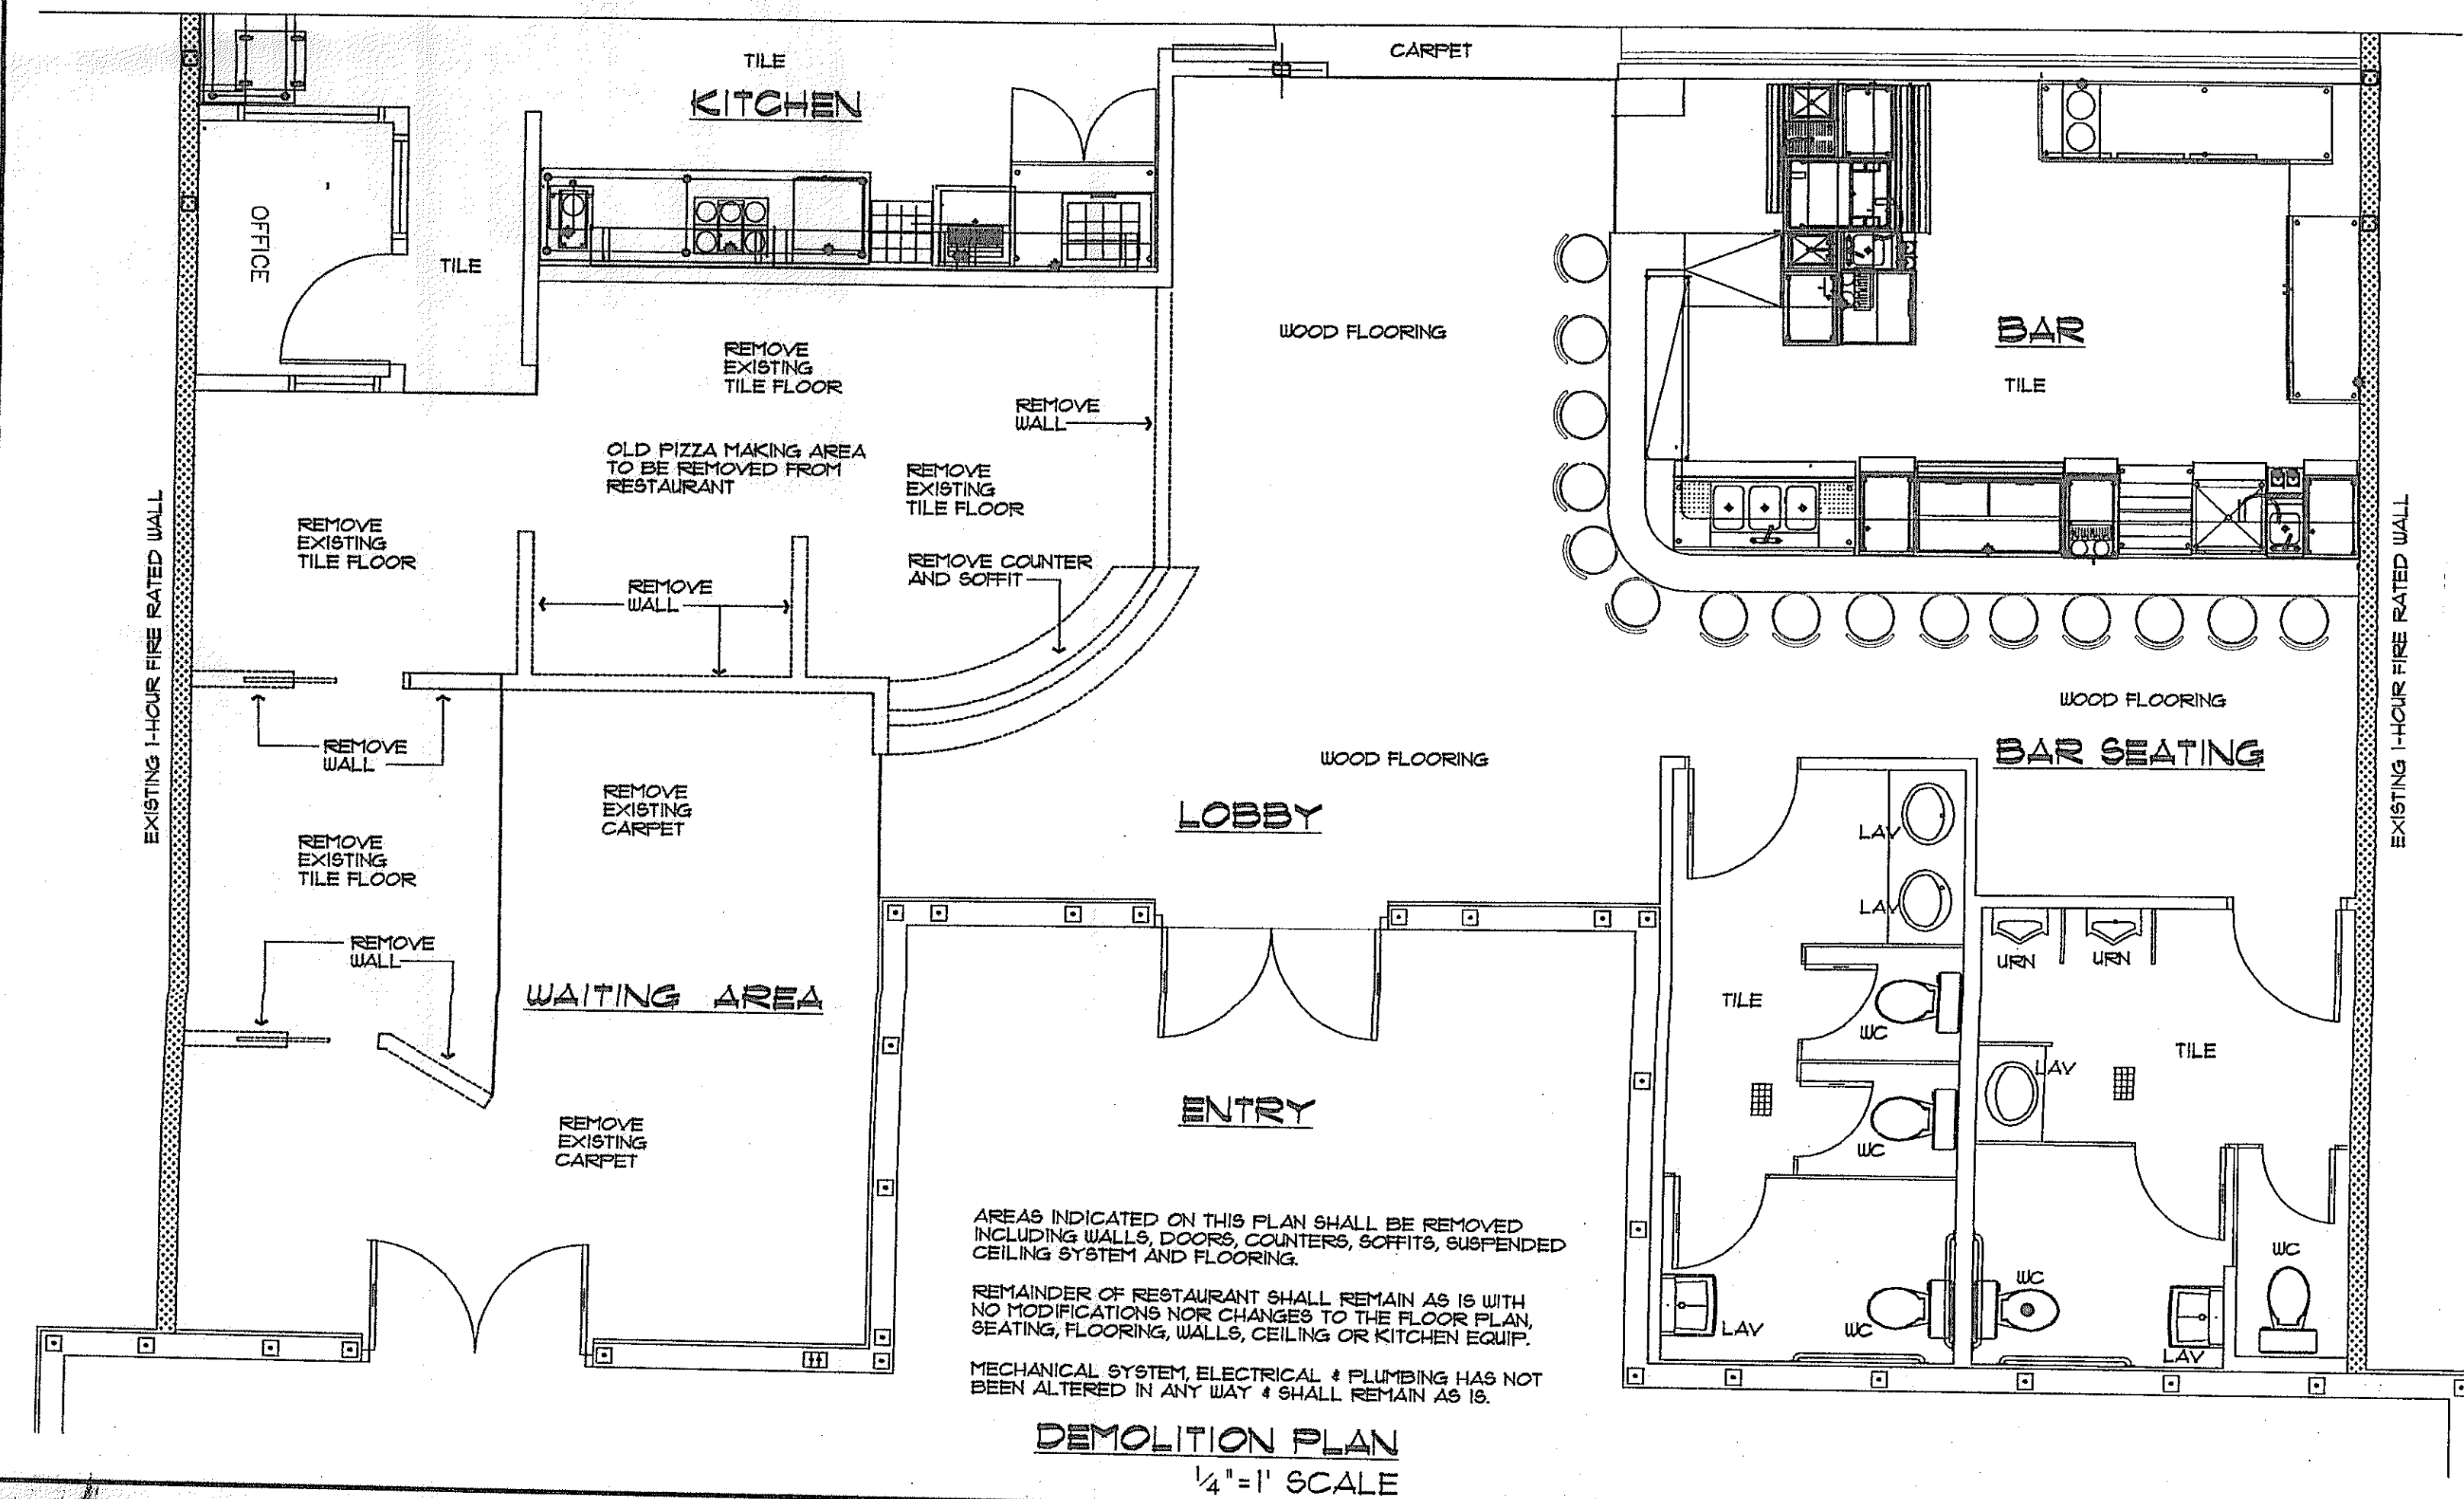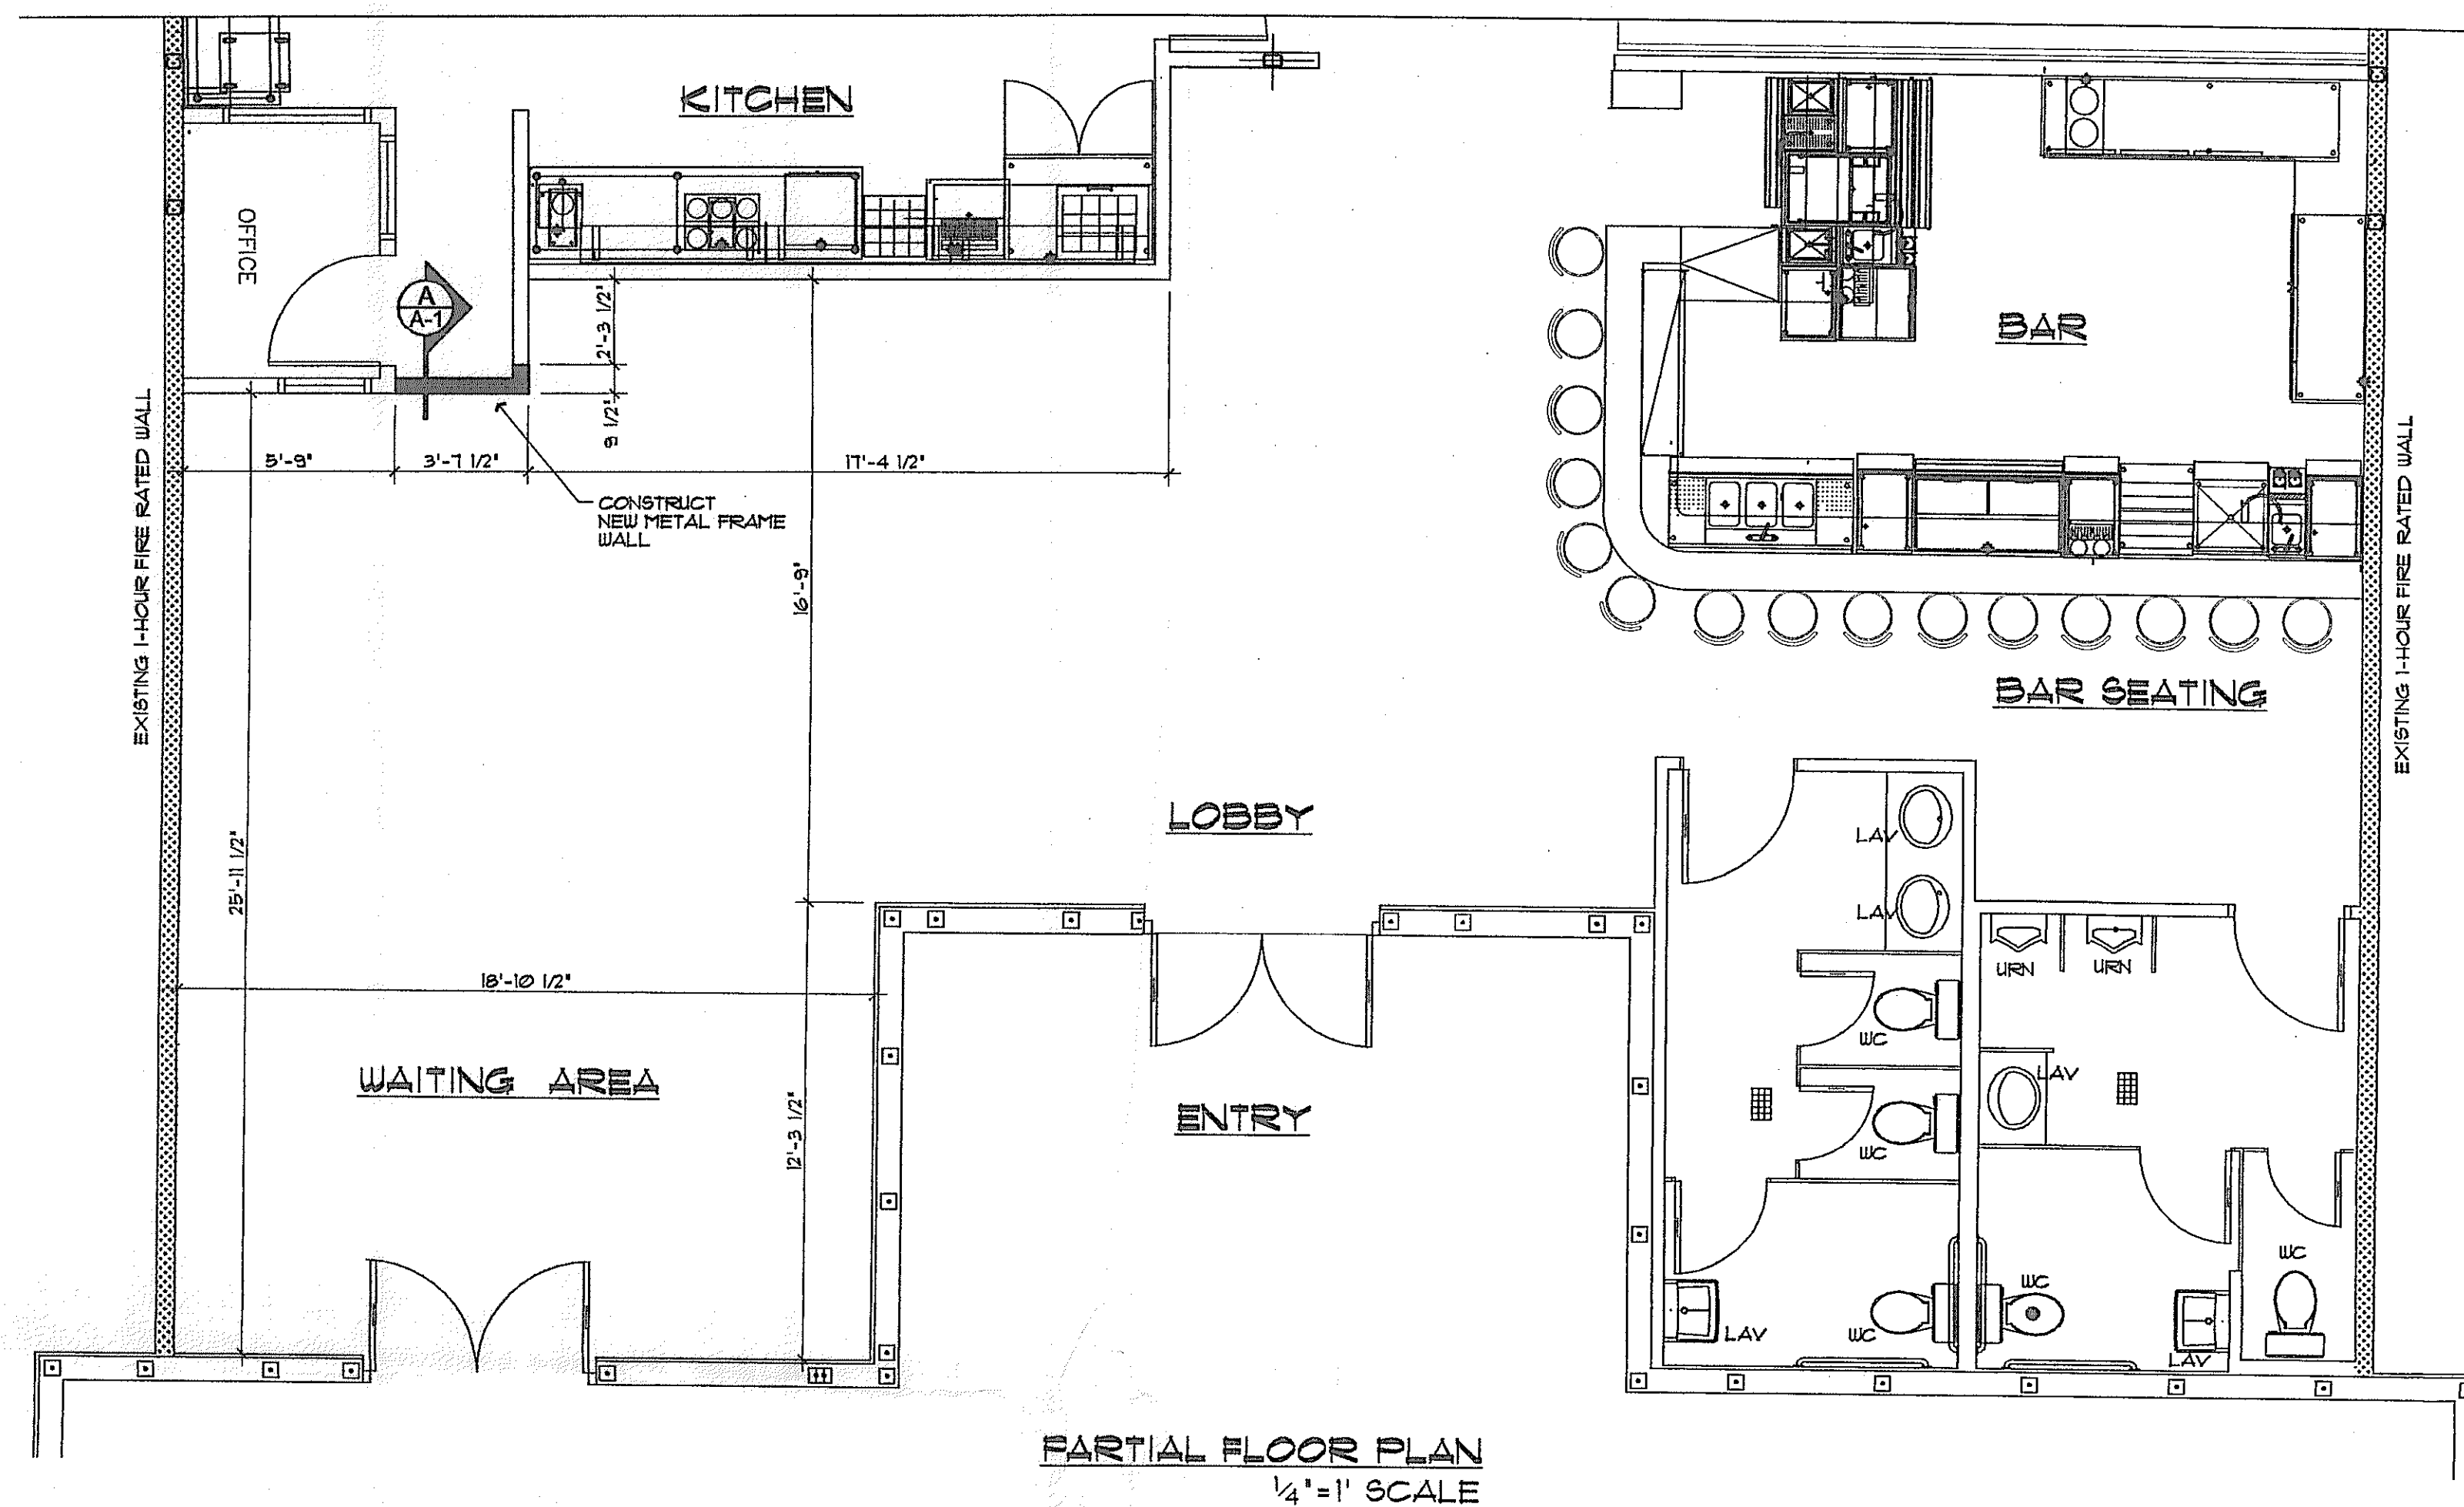


LEE COUNTY DEVELOPMENT SERVICES APPROVAL

By: TLK Date: 11/02/11

FOR: Salrose Plastics Inc. unit 5,
Danids Parkway Center
interior remodel of restaurant to
restaurant, 627 sq. with parking

* APPROVAL BASES ON SITE INFORMATION SUPPLIER
BY APPLICANT

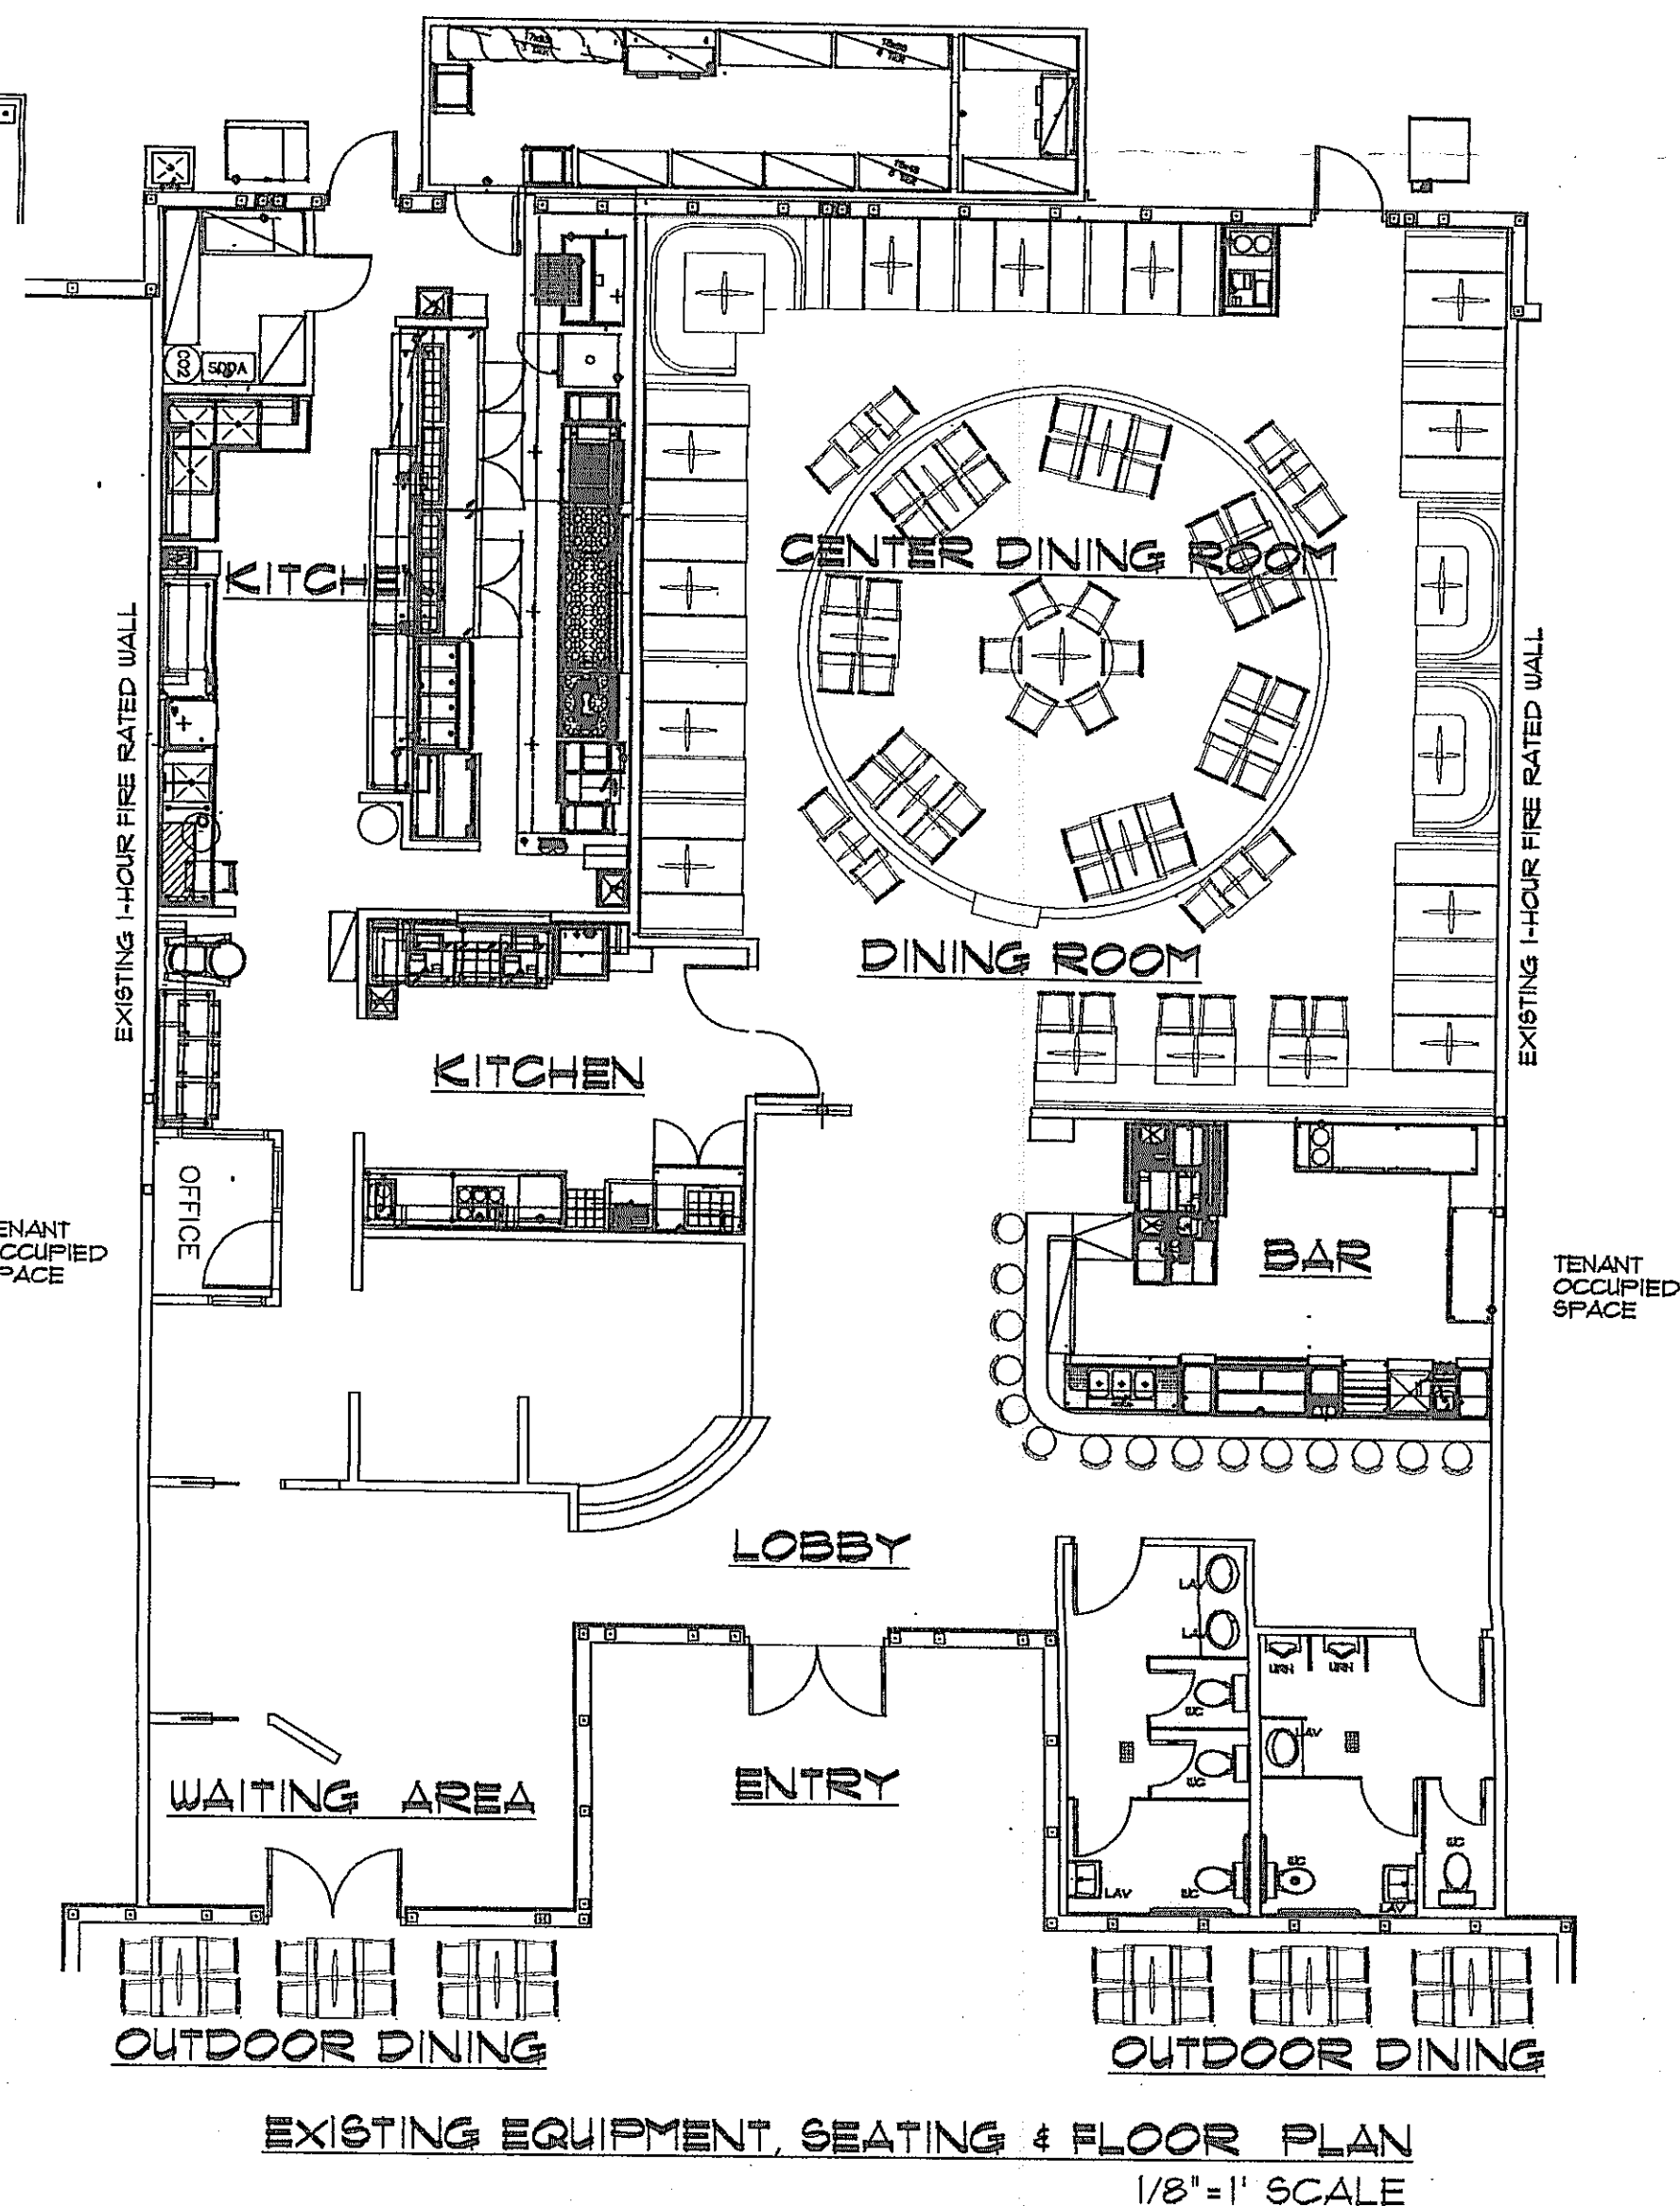

EXISTING BUILDING CONSTRUCTION:

 
- TYPE III - B, SPRINKLED
- MASONRY BLOCK EXTERIOR WALLS
- CONCRETE SLAB FLOORING
- METAL BAR JOIST & GIRDERS WITH METAL DECKING
(WITH INSULATION) ROOF

OCCUPANCY GROUP
BUSINESS, GROUP B

FIRE NOTES:


- NO MODIFICATION IS REQUIRED TO THE EXISTING FIRE SPRINKLER SYSTEM
- NO NEW EXTERIOR WORK SHALL BE PERFORMED
- NO NEW PENETRATIONS ARE TO BE MADE INTO EXISTING FIRE RATED WALLS
- NO NEW FIRE RATED ASSEMBLIES SHALL BE INSTALLED.

WALL LEGEND


	EXISTING EXTERIOR CMU WALL
	EXISTING TENANT SEPARATION WALL WITH 1 HOUR FIRE RATING
	NEW 4' OR 6' FRAME WALL
	EXISTING FRAME WALL

THE CONSTRUCTION COST OF THIS PROJECT
IS LESS THAN \$ 25,000


COMPLIANCE STATEMENT
 THIS TENANT BUILD-OUT IN THIS BUILDING HAS BEEN
 DESIGNED IN ACCORDANCE WITH THE:
 2007 FLORIDA BUILDING CODE,
 2007 EXISTING BUILDING CODE,
 2007 FLORIDA MECHANICAL CODE,
 2009 NATIONAL ELECTRIC CODE (N.E.C.)
 2007 FLORIDA PLUMBING CODE,
 2007 FLORIDA FIRE PREVENTION CODE

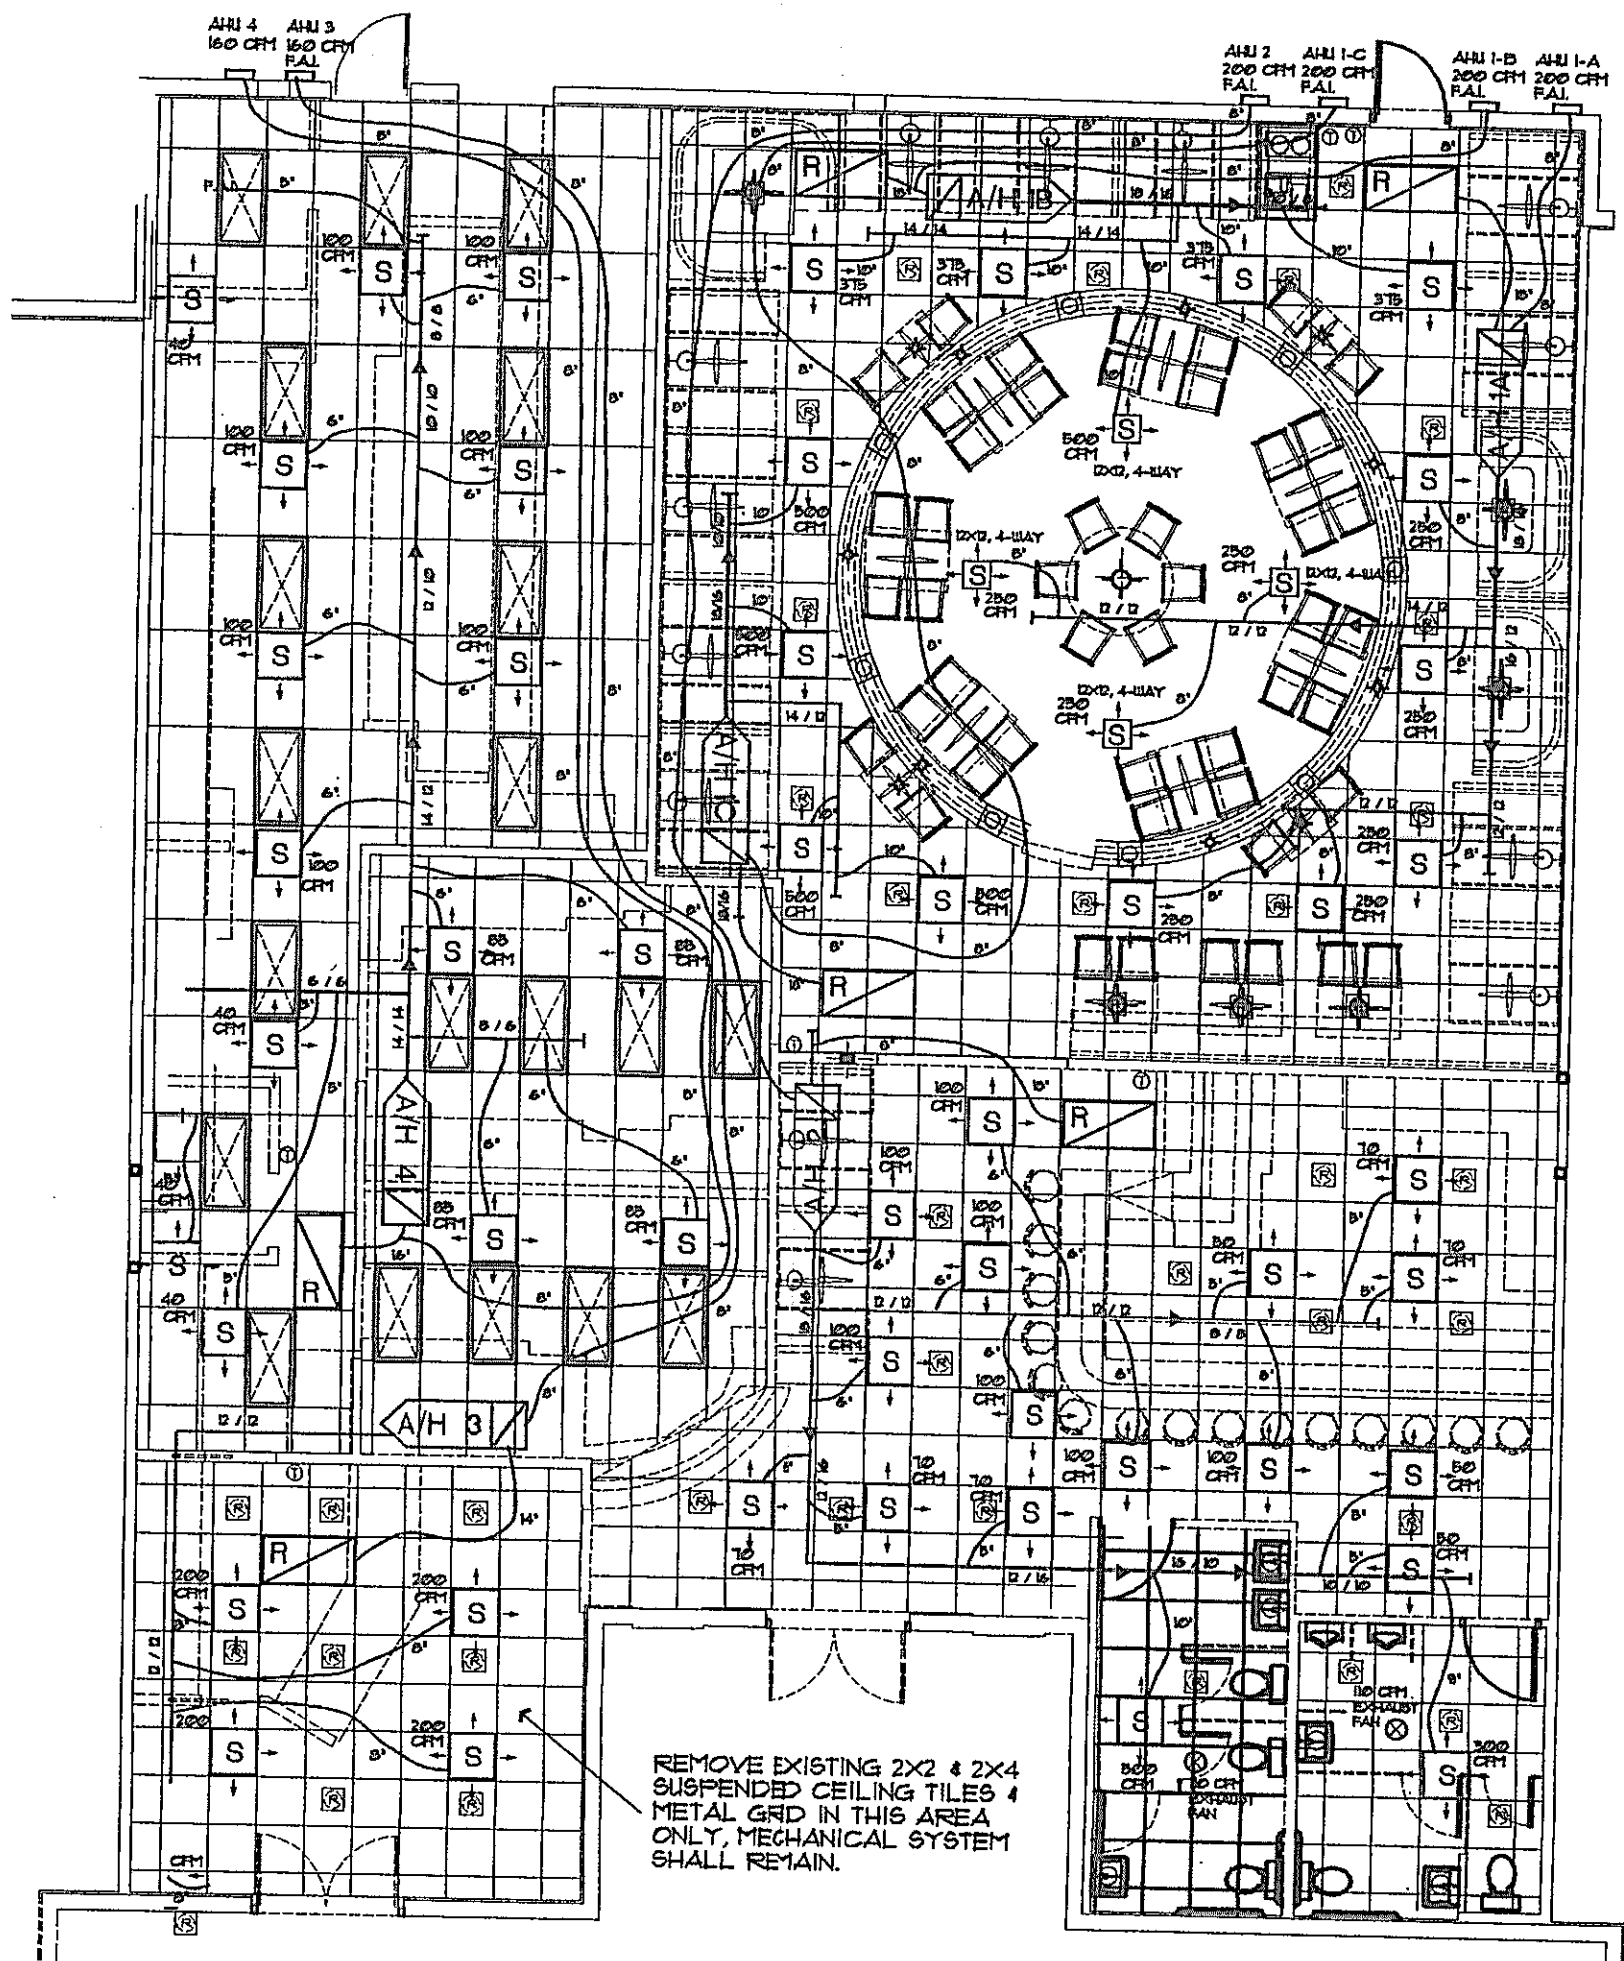


EXISTING MECHANICAL PLAN
1/8" = 1' SCALE

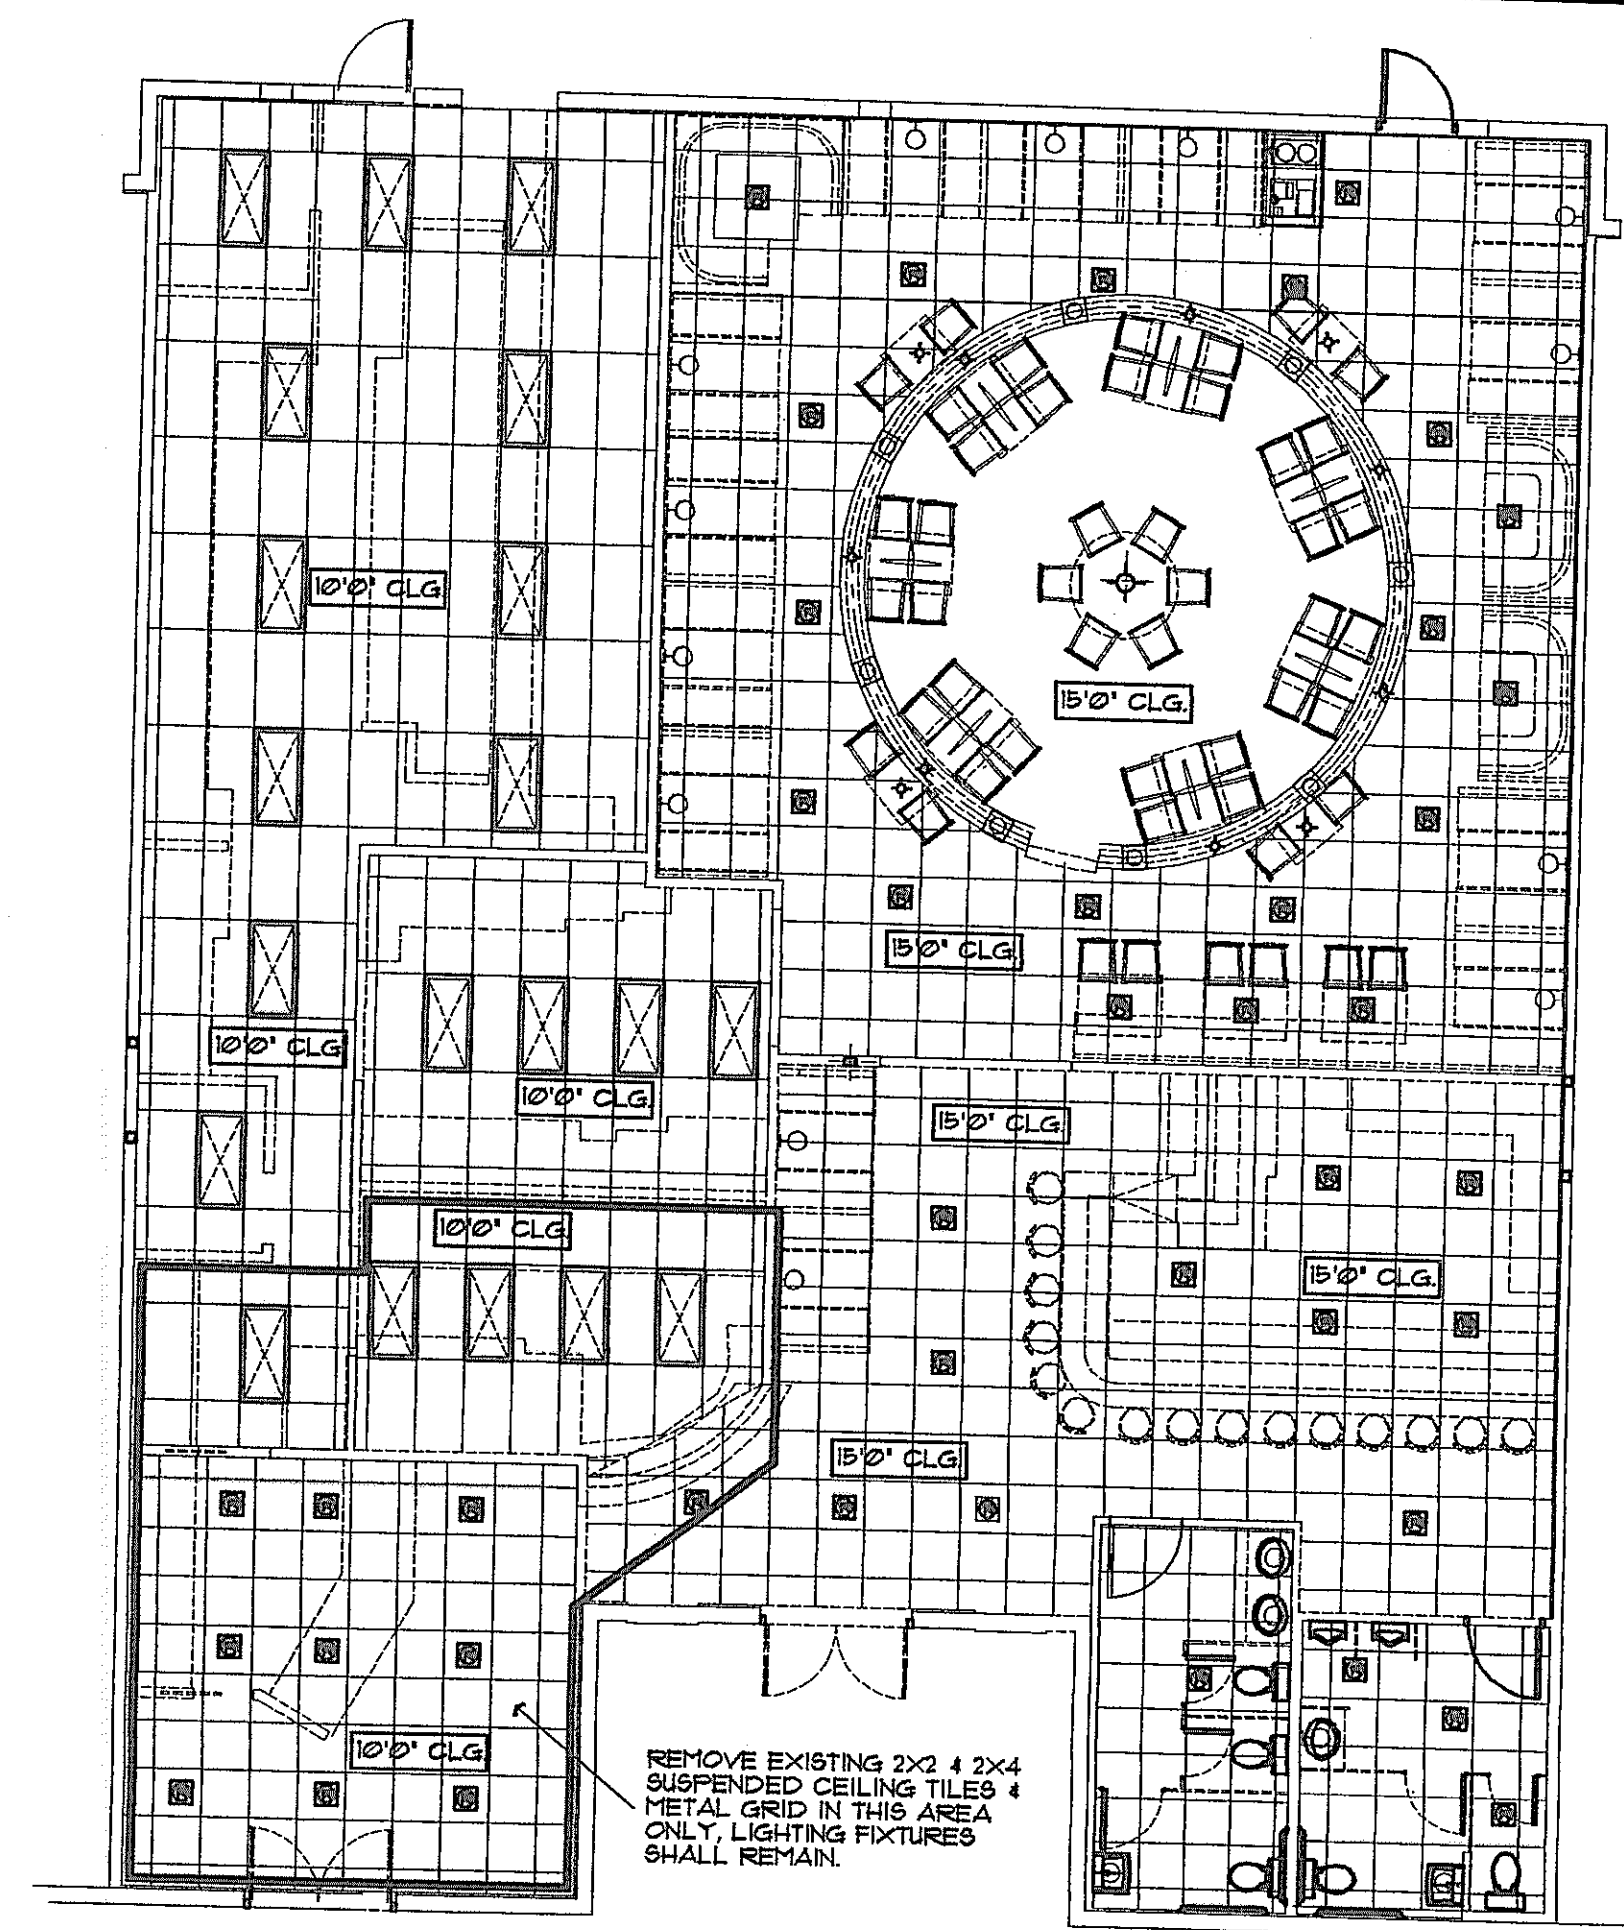

EXISTING REFLECTED CEILING PLAN
1/8" = 1' SCALE

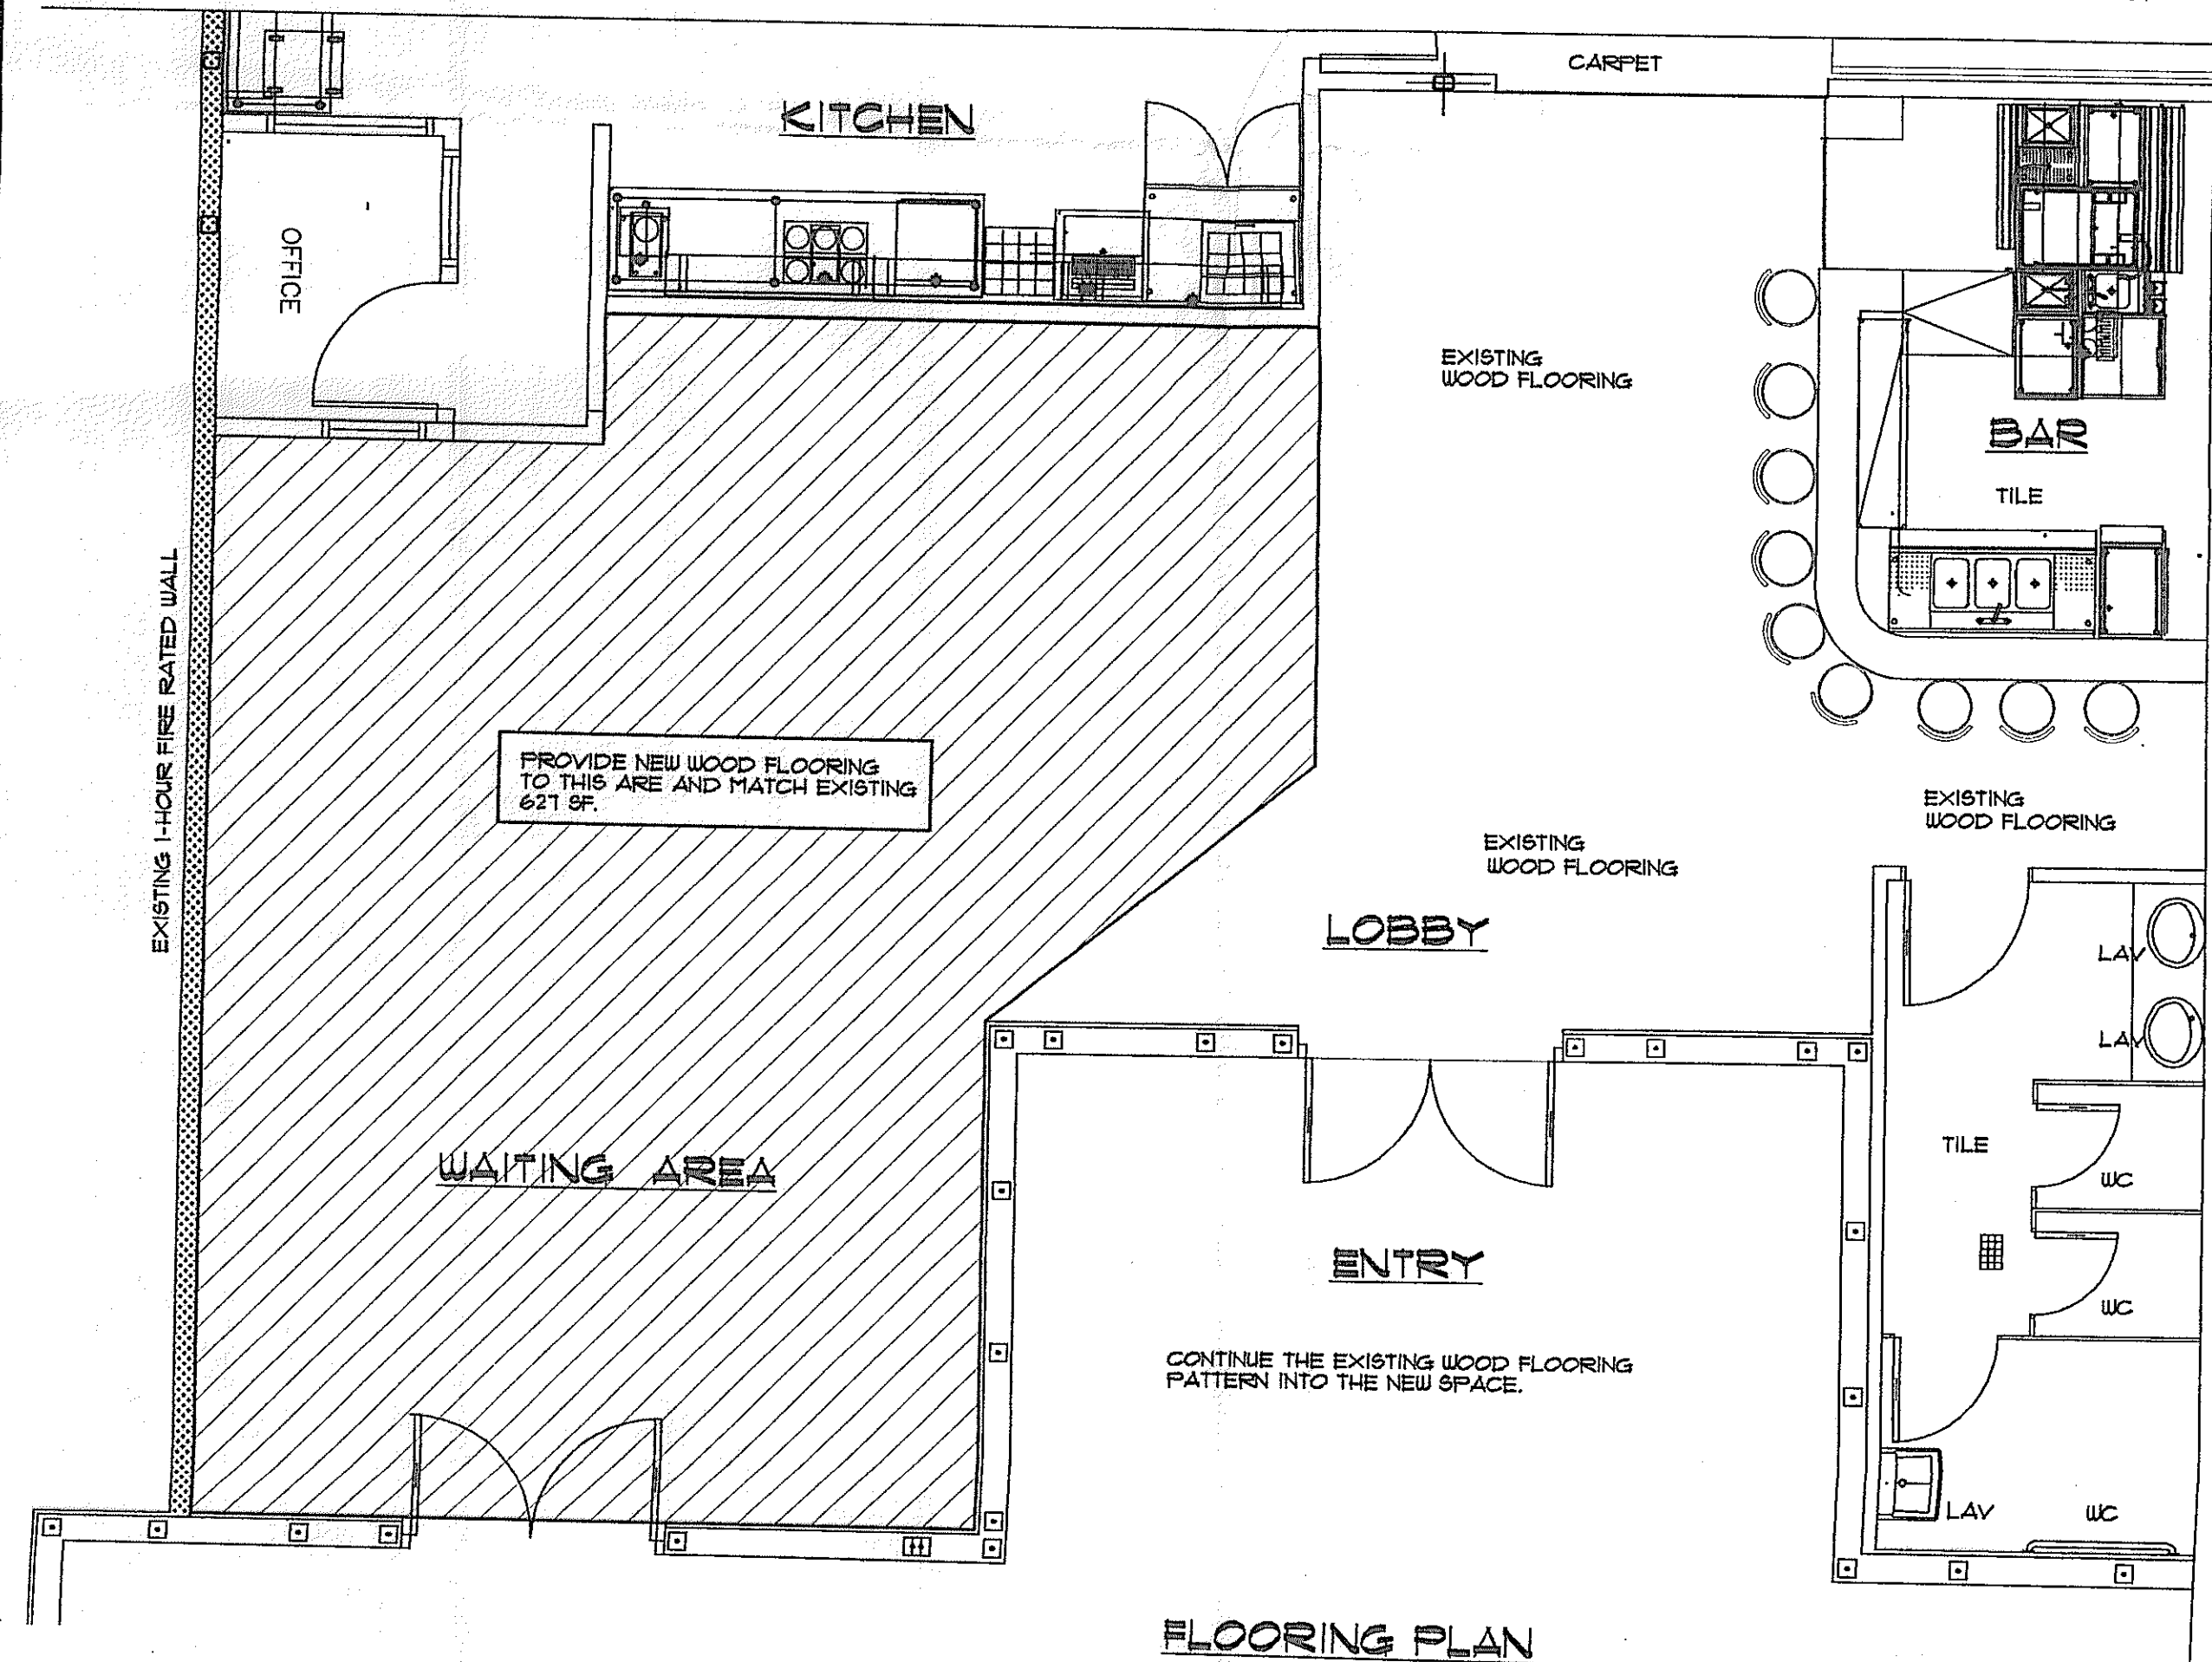

FLOORING PLAN
1/4" = 1' SCALE

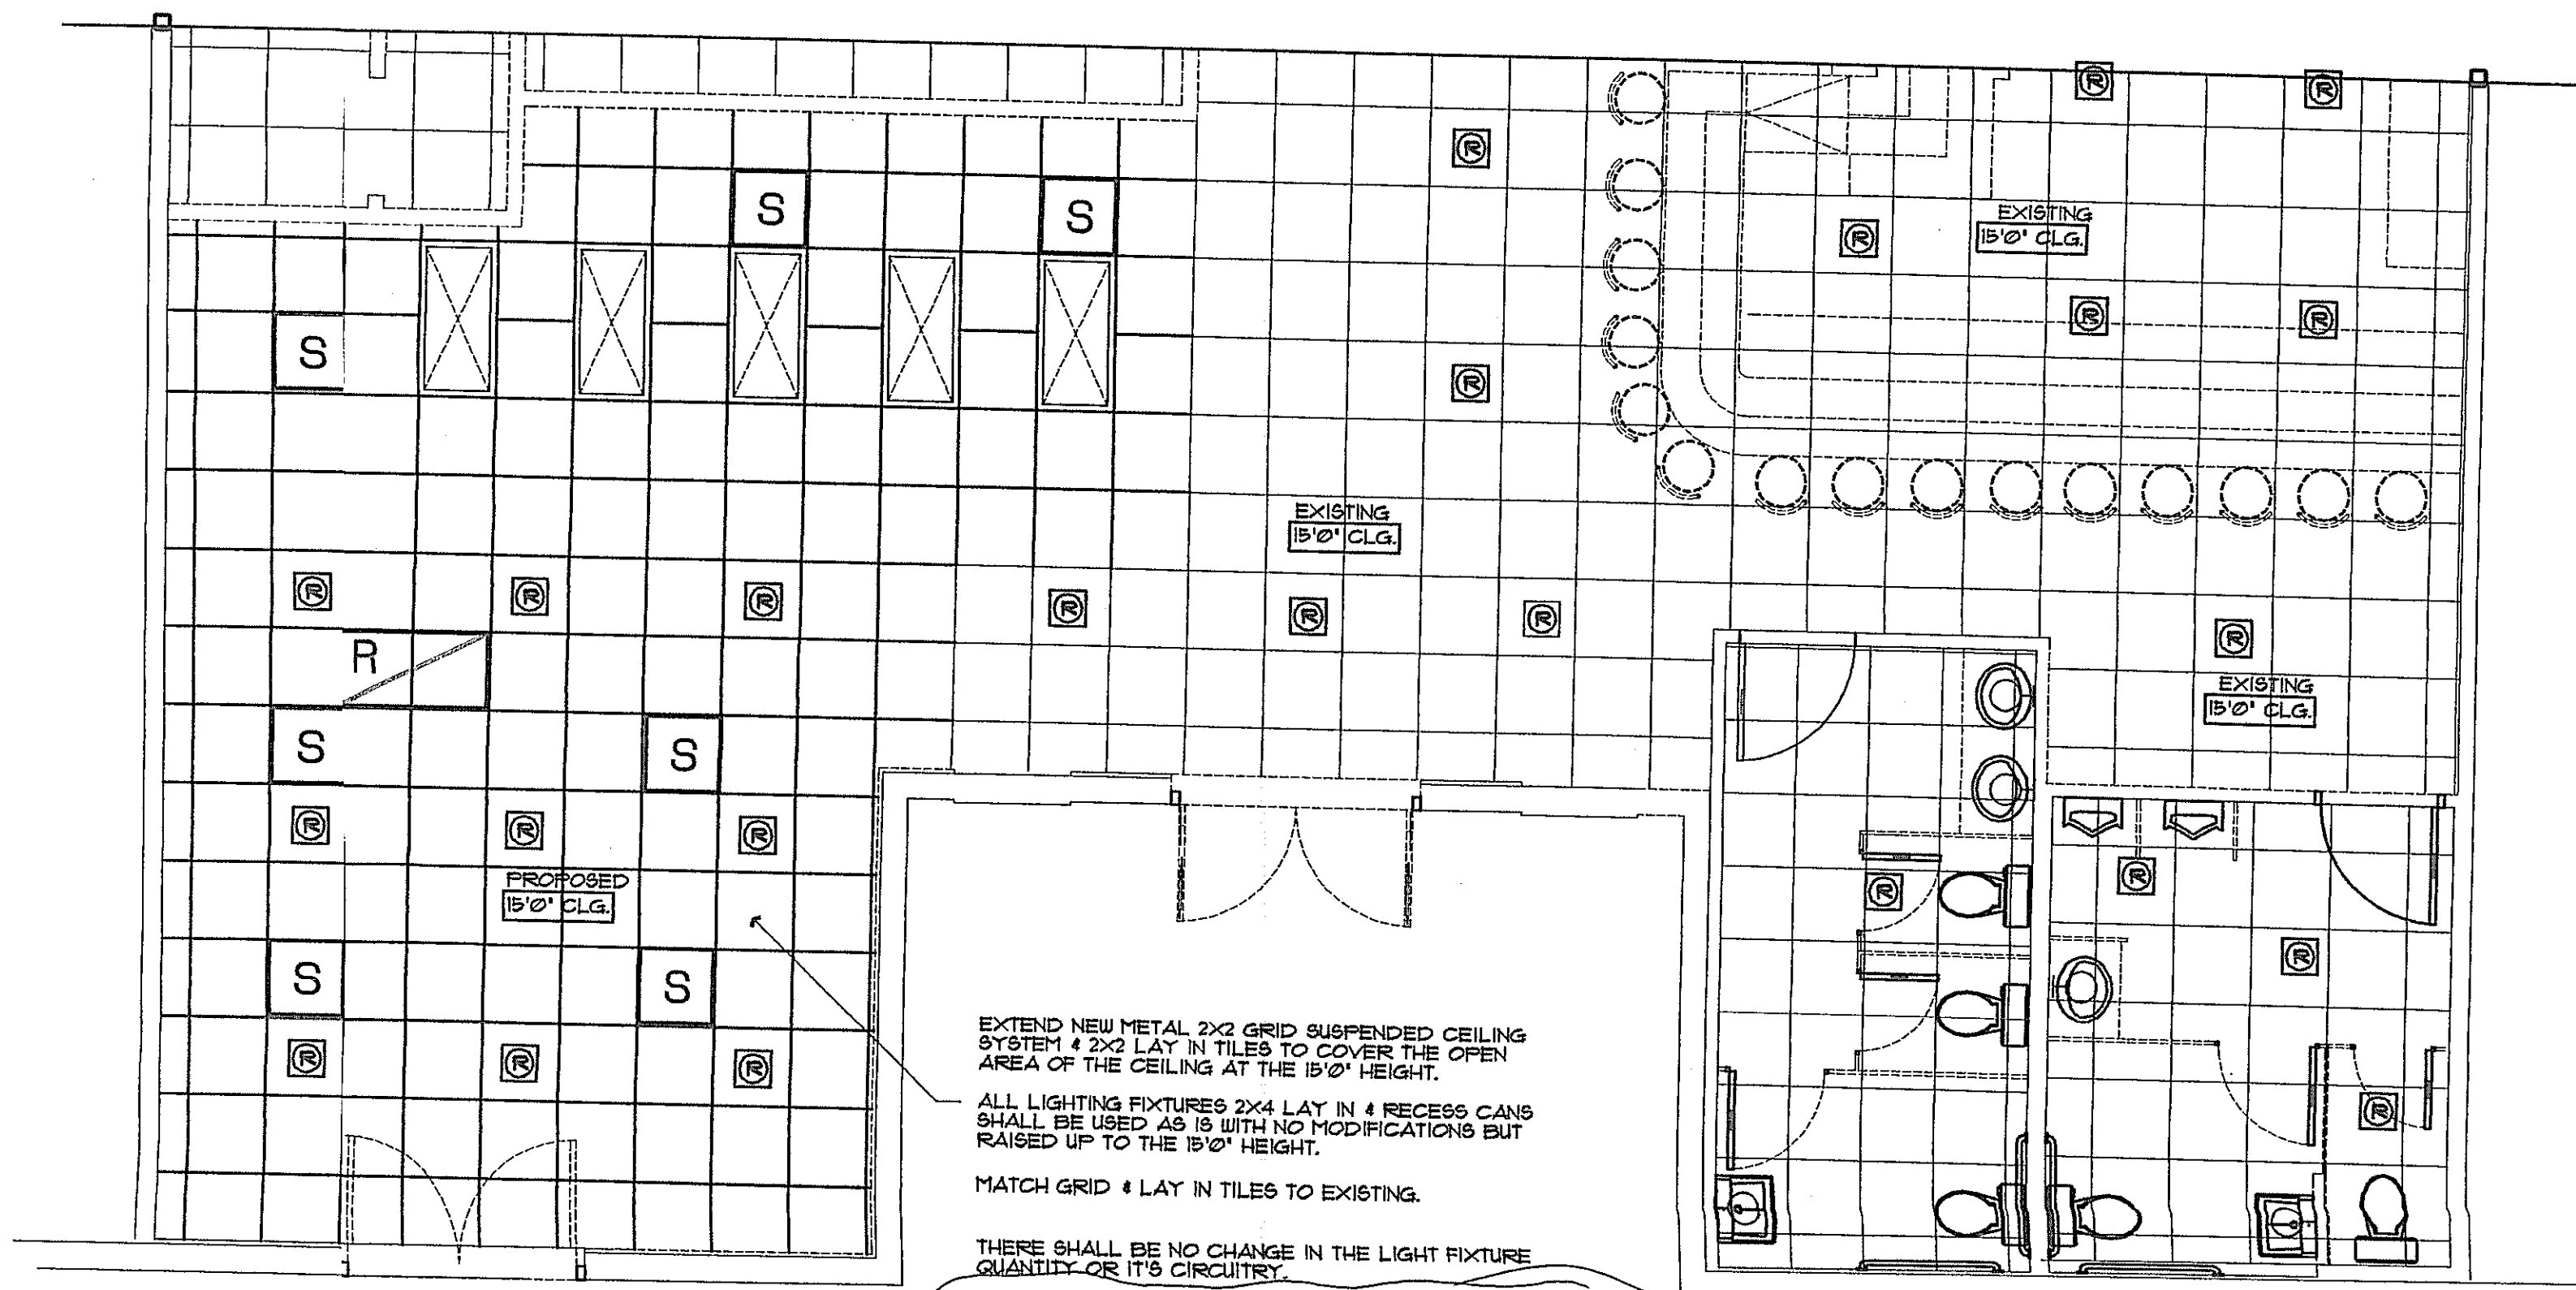

REFLECTED CEILING & MECHANICAL PLAN
SCALE 1/4" = 1'-0"

Reviewed by: RAO

THE CONSTRUCTION COST OF THIS PROJECT IS LESS THAN \$ 25,000

COMPLIANCE STATEMENT

THIS TENANT BUILD-OUT IN THIS BUILDING HAS BEEN DESIGNED IN ACCORDANCE WITH THE:
2001 FLORIDA BUILDING CODE
2001 FLORIDA MECHANICAL CODE
2001 FLORIDA ELECTRICAL CODE (NEC)
2001 FLORIDA PLUMBING CODE
2001 FLORIDA FIRE PREVENTION CODE

THE AFFIXED SEAL IS TO ATTEST THAT I HAVE REVIEWED THE CONSTRUCTION DOCUMENTS FOR THIS STRUCTURE AND IT IS IN COMPLIANCE WITH THE REQUIREMENTS OF SECTION 1609 OF THE 2001 FLORIDA BUILDING CODE FOR THE DESIGN PRESSURE GENERATED BY A WIND VELOCITY OF 150 MPH.
C. PAUL PRECHT, AR-2014356

THE FUNKY FISH
8311 DANIELS PARKWAY, UNIT 5, FT. MYERS, FLORIDA
CONTRACTOR

© COPYRIGHT 2011
J & P DESIGN GROUP, INC.
WHEREAS EVERY ATTEMPT HAS BEEN MADE TO INCLUDE ALL DETAILS AND PERTINENT INFORMATION ON THE DRAWINGS, CONTRACTORS ARE RESPONSIBLE TO VERIFY ALL DIMENSIONS, DETAILS, AND INFORMATION PROVIDED ON THE DRAWINGS. CONTRACTORS SHALL NOTIFY J & P DESIGN GROUP IN WRITING FOR ANY OMISSION OR DISCREPANCY ON THE DRAWINGS, PRIOR TO THE START OF ANY WORK.

PRELIMINARY ☐
CONSTRUCTION ☒
FINAL RECORD ☐

DRAWN BY: D'ANGELO
CHECKED BY: C.P.P.

DATE: 11-2-2011
PERMIT SET

REVISIONS

SHEET NO.

A-2

JOB NO. 11-023