



Better Ingredients.
Better Pizza.

NEW STORE LOCATION

15 FEBRUARY, 1999

WEST PARKER ROAD
PLANO, TX.

NOTE :

THESE PLANS ARE THE PROPERTY OF PAPA JOHN'S INTERNATIONAL, INC. AND THEY MAY NOT BE REPRODUCED IN WHOLE OR IN PART IN ANY FORM WITHOUT THE WRITTEN PERMISSION OF PAPA JOHN'S INTERNATIONAL, INC. 11492 BLUEGRASS PARKWAY, LOUISVILLE, KENTUCKY 40299


CORPORATE ARCHITECT :

BAYUS - EVOLA ARCHITECTS
661 S. HURSTBOURNE PKWY - SUITE 140
LOUISVILLE, KENTUCKY 40222
(502)-426-8020

ENGINEER :

KERR-GREULICH ENGINEERS, INC.
1534 ORMSBY STATION CT.
LOUISVILLE, KENTUCKY 40224
(502)-426-9457



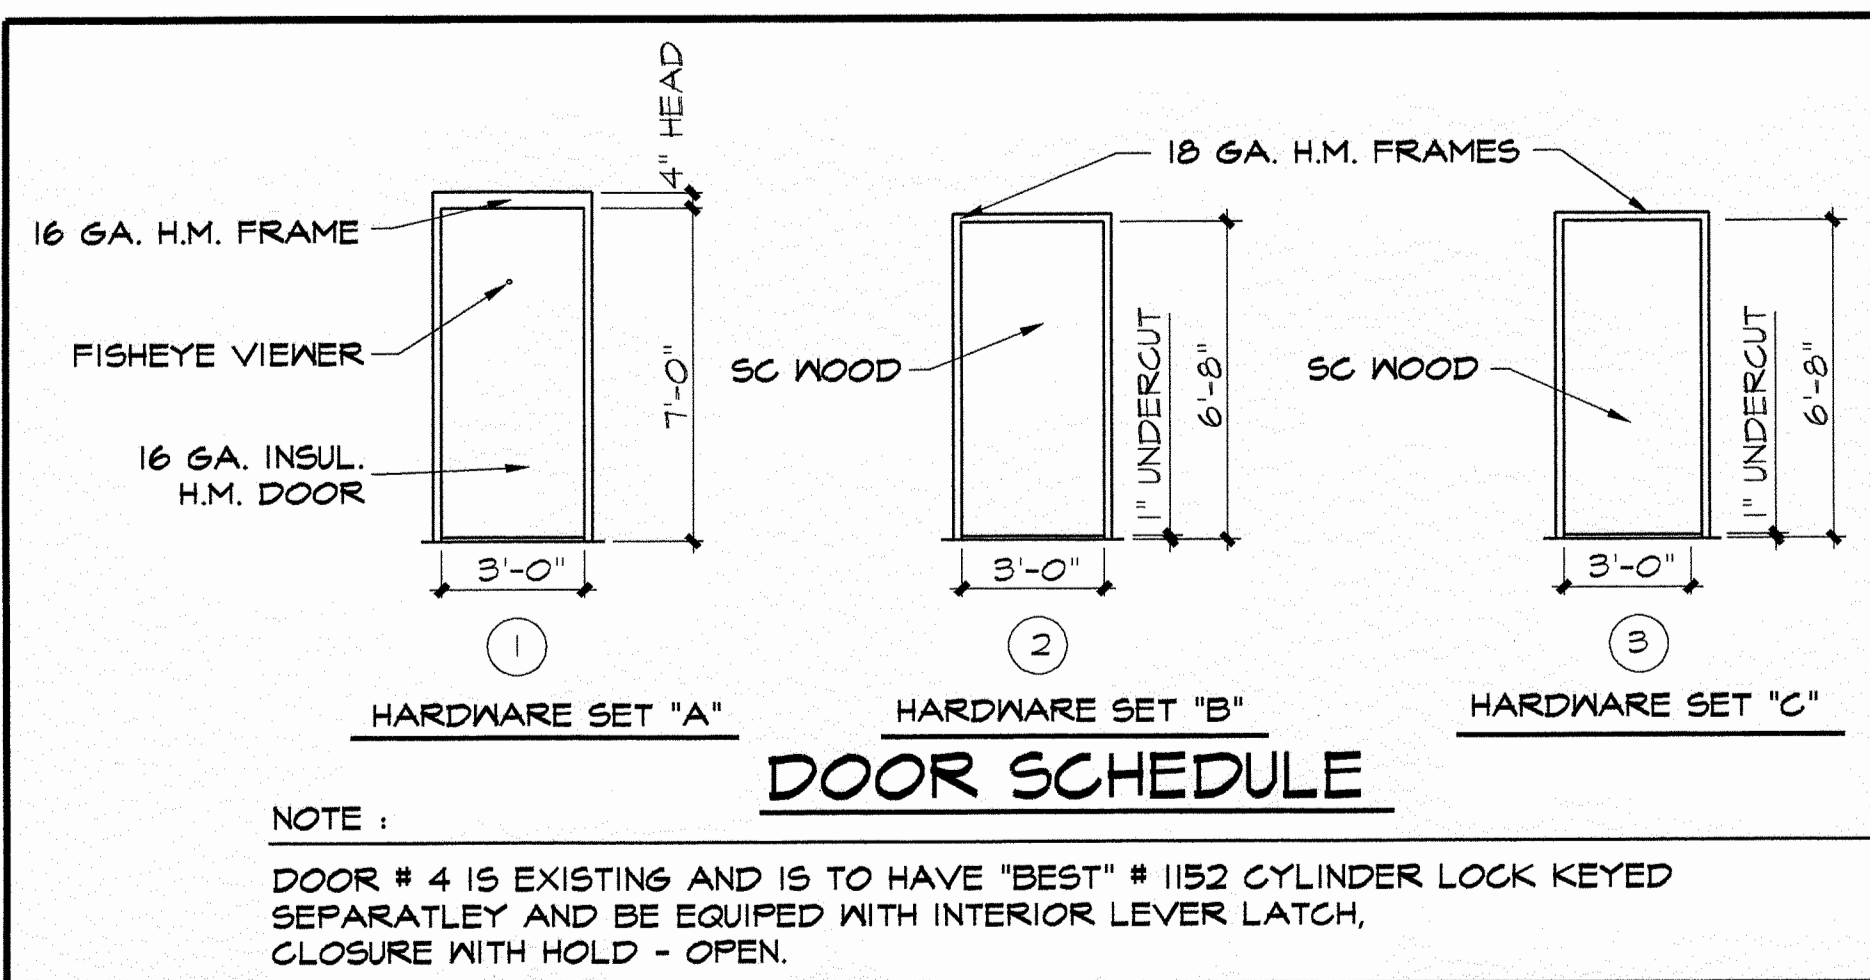


NOTE :

DOOR # 4 IS EXISTING AND IS TO HAVE "BEST" # 1152 CYLINDER LOCK KEYED SEPARATELY AND BE EQUIPED WITH INTERIOR LEVER LATCH, CLOSURE WITH HOLD - OPEN.


ROOM FINISH SPECIFICATIONS

- ALL DRYWALL WALLS TO RECEIVE "FRP" PANELS FROM FLOOR TO CEILING EXCEPT BEHIND THE COOLER
- PAPA JOHN'S SPECIAL PAINT COLORS:
WHITE - "SHERWIN WILLIAMS" B 33 W 201 - 200 OIL BASE E66 SHELL
RED - "SHERWIN WILLIAMS" B54R38 (SAFETY RED) + VIOLET-4/32 + BLUE-4/32.
GREEN - "SHERWIN WILLIAMS" B54T104 (SAFETY GREEN MC-42) + 8/32 BLACK.
- FLOOR TILE TO BE PJ 9610 (2'X12') CERAMIC TILE MANUFACTURED BY KPT UNDER PRIVATE LABEL EXCLUSIVE FOR PAPA JOHN'S. GROUT TO BE CADET GREY. BASE IS TO BE 6"X8" CERAMIC COVE BASE BY KPT. ALL TILES TO BE ADHESIVE SET. AVAILABLE AT TILE DISTRIBUTORS 1-800-274-8453.
- INSTALL "FRP" PANELS ON ALL WALLS FROM FLOOR TO CEILING. THIS INCLUDES THE OFFICE AND THE RESTROOM. INSTALL COMPLETE WITH ALL TRIM AND ACCESSORIES TO BE INSTALLED PER MANUFACTURER'S INSTRUCTIONS. PANELS TO BE "FRP" PANELS AS MANUFACTURED BY "KEMITE CORPORATION" - RICH EICHORN 1-800-435-0080 "FRP" PANEL TO BE (GLASBORO-P, PRODUCT CODE #BES385-P) FOR 2" CORNER GUARD (PRODUCT # 0A852-10 WHITE)
- CEILING SHALL BE WASHABLE, HARD SURFACE VINYL FACED 24"X48" LAY-IN ACOUSTIC PANELS IN "STIPPLE" FINISH WITH WHITE ALUMINUM "T" GRID SYSTEM IS PATTERN SHOWN STORAGE AREAS AND BATH CEILINGS MAY BE STANDARD ACOUSTIC OR PAINTED DRYWALL.
- ALL DOORS, FRAMES AND WOOD TRIM SHALL BE PAINTED TWO COATS OF "WHITE".
- FURNISH AND INSTALL A ONE-WAY GLASS VIEW WINDOW IN OFFICE WALL - WINDOW TO BE WOOD FRAMED AND TRIMMED WITH "FRP" CORNERS. (SEE DETAIL THIS SHEET)
- ALL EXPOSED PARTITION ENDS AND CORNERS SHALL HAVE 5' 2"X2" "FRP" CORNER GUARDS INSTALLED.

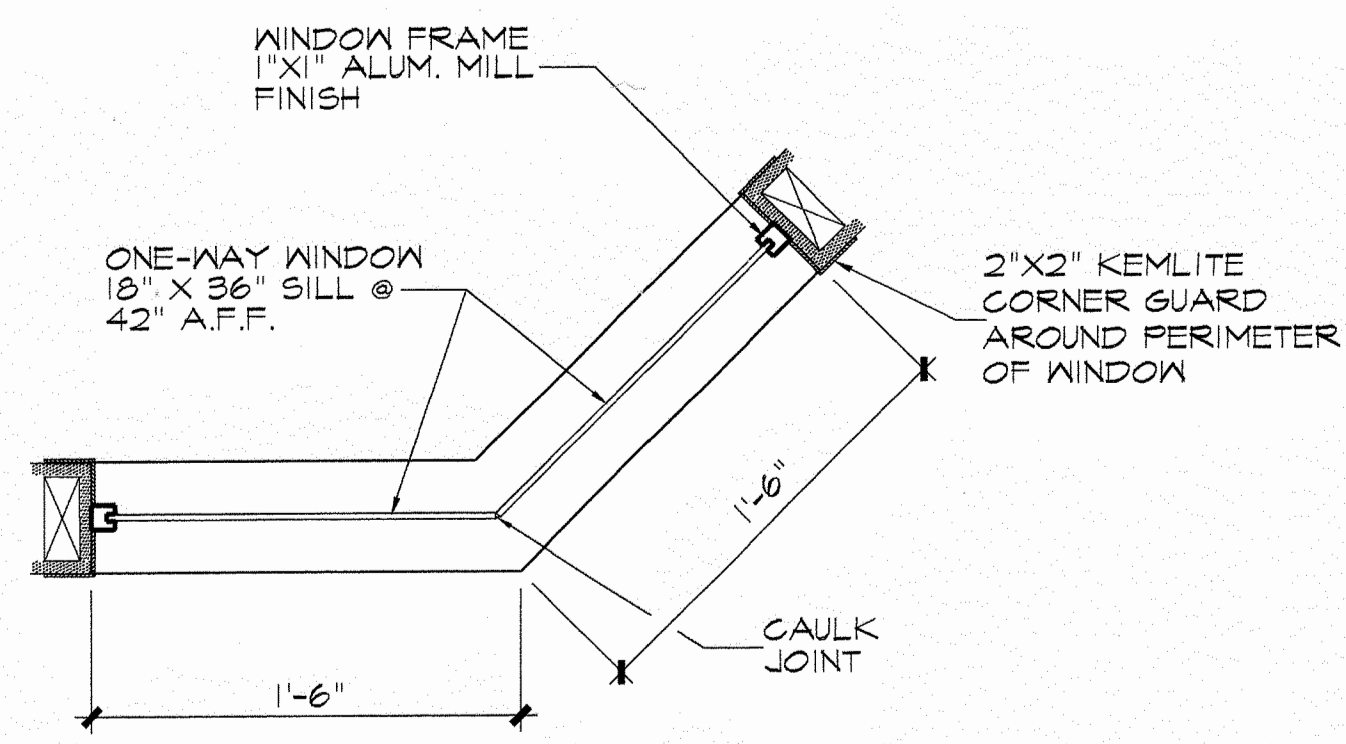

OFFICE WINDOW

SCALE : 1/2"=1'-0"

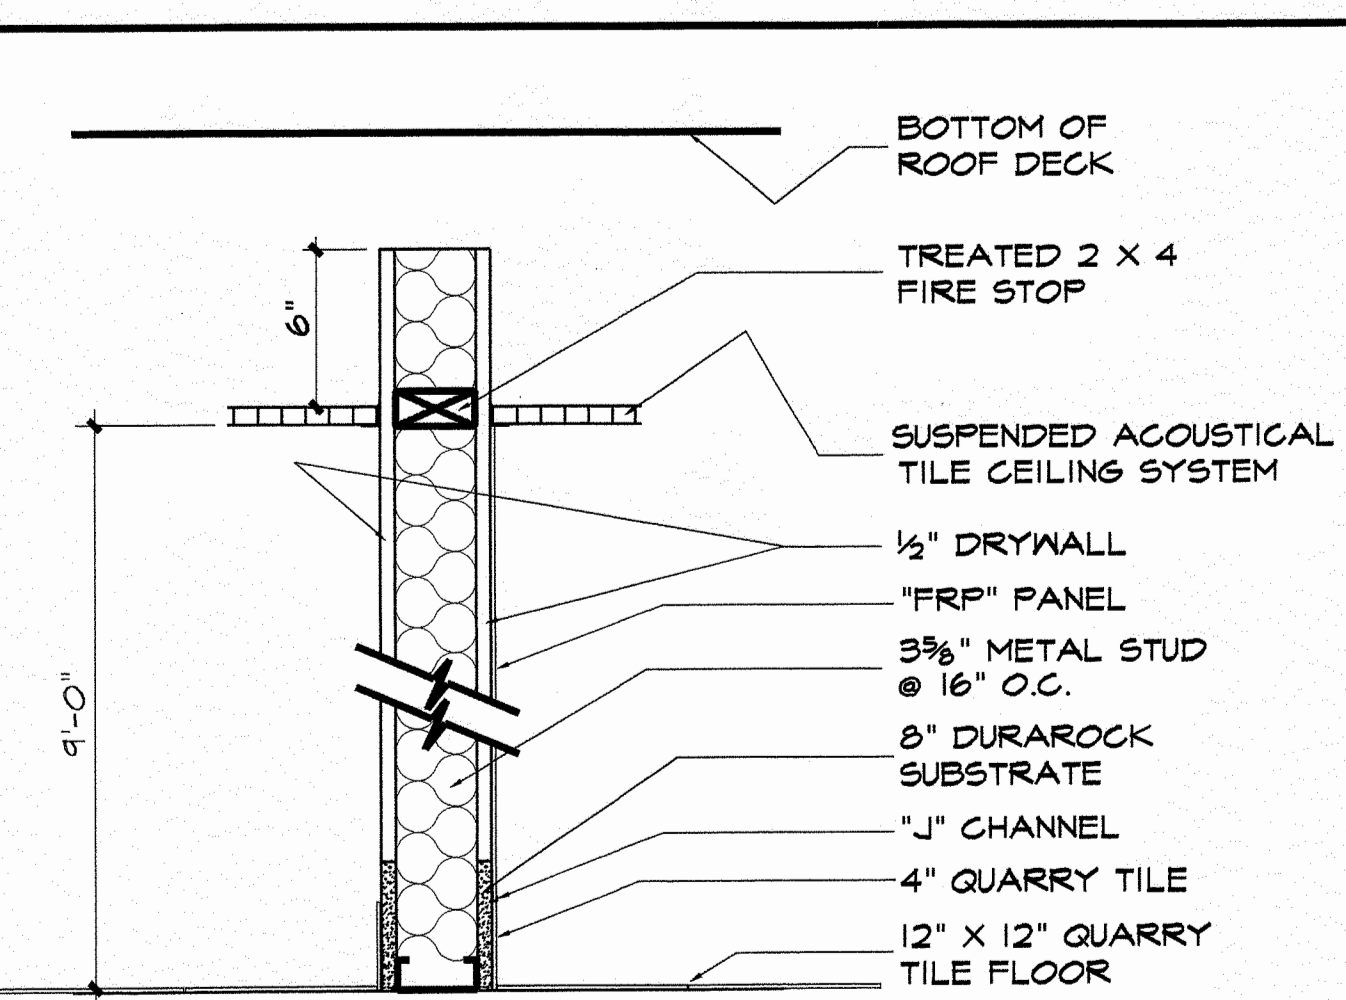

NOTE :
THIS IS A NON LOAD BEARING WALL AND IS NOT A FIRE RATED ASSEMBLY.

INTERIOR WALL SECTION


SCALE : 1/2"=1'-0"

EQUIPMENT REQUIRED FOR SAFE INSTALLATION :


- 4ea. 3/8" MOLLY PARABOLT
- 1/2" DRILL MOTOR
- 3/8" CARBIDE BIT
- HAMMER
- 3/8" WRENCH OR SOCKET & DRIVER
- LIQUID ROCK (1 PKG.)
- SAFETY GOGGLES

INSTALLATION INSTRUCTIONS :

- POSITION SAFE IN PLACE WHERE IT IS GOING TO BE INSTALLED.
- TRACE THE HOLES ON THE BOTTOM OF THE SAFE ONTO THE FLOORSURFACE BELOW.
- REMOVE SAFE.
- DRILL THE HOLES W/ THE 3/8" CARBIDE BIT. HOLES MUST BE AT LEAST 4 1/2" DEEP.
- CLEAN THE HOLES OF DEBRIS, MIX & POUR LIQUID ROCK INTO EA. HOLE.
- POSITION SAFE BACK INTO PLACE.
- ADD WASHER & THREAD NUT FLUSH W/ THE TOP OF THE BOLT (SEE DET. #1)
- DRIVE BOLT THROUGH THE HOLE IN THE SAFE.
- TO SET THE FASTENERS, TIGHTEN THE NUT THREE (3) FULL TURNS W/ 3/8" WRENCH OR SOCKET (SEE DET. #2)

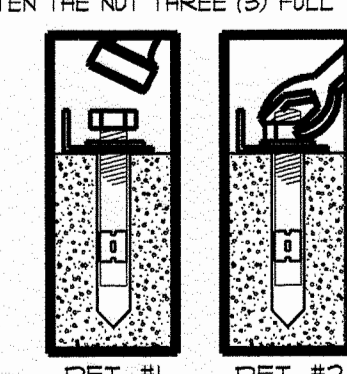

NOTE:
SEE NOTE #12 OF GENERAL NOTES

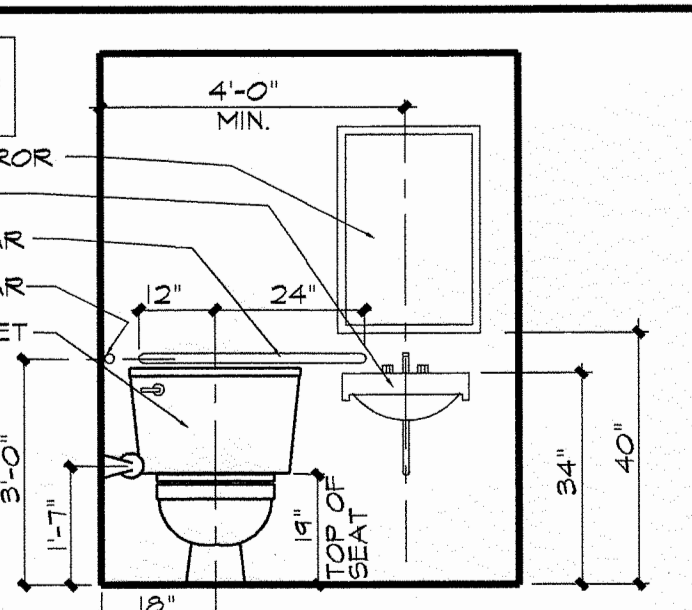

TYPICAL RESTROOM MOUNTING HEIGHTS

HARDWARE SCHEDULE

SET "A"			
MARK :	REAR DOOR	3068 F	HM X HM 1 3/4"
CURRIES :	FRAME	3068 "M" SERIES 5 3/4"	16 GA. KNOCKDOWN
CURRIES :	DOOR	3068 TOTS SERIES FLUSH 20SA W/ TOP CAP	26D
HASER :	3 HINGES	BB1274 NRP 4 1/2"X4 1/2"	26D
MONARCH :	EXIT DEVICE	14-R-L-CONTROL X DANE X 560	MAL/32D
SCHLAGE :	MORTISE CYLINDER	20-001 1 1/4" "C" SECTION	26D
NORTAN :	CLOSER	850IBF	ALUM
IVES :	VIEWER	TOOB426D	WIDE ANGLE
HASER :	DOOR SWEEP	156SAV	36"
HASER :	THRESHOLD	412SA	36"
HASER :	WEATHERSTRIP	126S	11"
HASER :	RAINDRIP	810SA	40"
PRECISION :	LOCK GUARD	162TNL	PRIME PAINT
SET "B"			
MARK :	RESTROOM DOOR	3068 F	WOOD X HM 1 3/4"
CURRIES :	FRAME	3068 "C" SERIES 5 3/4"	16 GA. KNOCKDOWN
CURRIES :	DOOR	3068 SOLID PARTICLEBOARD CORE 1 3/4" FLUSH	26D
HASER :	3 HINGES	BB1274 4 1/2"X4 1/2"	26D
SCHLAGE :	PRIVACY SET	AL40SKSATURNX2 3/4"X4 1/2"	26D
NORTAN :	CLOSER	850IBF	ALUM
HASER :	STOP WALL - 236W OR FLOOR - 24IF		26D
SET "C"			
MARK :	OFFICE DOOR	3068 F	WOOD X HM 1 3/4"
CURRIES :	FRAME	3068 "C" SERIES 5 3/4"	16 GA. KNOCKDOWN
CURRIES :	DOOR	3068 SOLID PARTICLEBOARD CORE 1 3/4" FLUSH	26D
HASER :	3 HINGES	BB1274 4 1/2"X4 1/2"	26D
SCHLAGE :	LOCKSET	AL53PD-SATURX2 3/4"X4 1/2"	26D
NORTAN :	CLOSER	850IBF	ALUM
HASER :	STOP WALL - 236W OR FLOOR - 24IF		26D
SET "D"			
MARK :	FRONT DOOR	PAIR (OR SINGLE) 3068 FS	ALUM X ALUM 1 3/4"
SCHLAGE :	MORTISE CYLINDER	20-001 1 1/4"XCYL. RING	FINISH TO MATCH ALUMINUM DOORS.
BALANCE BY DOOR SUPPLIER TO INCLUDE			
HINGES/PIVOTS 2 EA. CLOSERS			
1 FR. FLUSH BOLTS 2 EA. PUSH/PULLS			
1 MORTISE T-TURN 1 EA. THRESHOLD			
1 SET WEATHER STRIP			
NOTE :			
ALL HARD WARE TO MEET LOCAL AND A.D.A. CODES.			
PROVIDE TWO CHANGE KEYS PER LOCK/CYL. AND 3 MASTER KEYS			
ALL HARDWARE IS AVAILABLE FROM CONSTRUCTION HARDWARE, INC.			
1800 COBALT DRIVE - LOUISVILLE, KY. 40299-2414			
PHONE : (502)-267-0444			
FAX : (502)-267-0446			
CONTACT : JIM DELOZIER			
NOTE :			
ALL HARDWARE COMPLIES W/ SEC. 1114 OF THE N.C.S.B.C.G.			
ALL HARDWARE COMPLIES W/ SEC. 1017.4 OF THE 1993 B.O.C.A. CODE.			

GENERAL NOTES:

- DIMENSIONS ARE DRYWALL - TO - DRYWALL OR DRYWALL - TO - MASONRY.
- GENERAL CONTRACTOR SHALL INSTALL ALL REQUIRED BLOCKING FOR ALL EQUIPMENT, HANGERS, ETC.
- ALL WORK SHALL CONFORM TO ALL LOCAL AND STATE CODES AND REGULATIONS.
- ALL PARTY WALLS SHALL BE 35 SJ 20 GAUGE MINIMUM STEEL STUDS SPACED 16" O.C. AND EXTENDED FROM SLAB TO ROOF.
- PARTY WALLS SHALL BE FACED BOTH SIDES WITH 1/2" FIRE CODE DRYWALL FULL HEIGHT TO ROOF STRUCTURE TO CREATE A ONE-HOUR FIRE RATED PARTITION. (UL DESIGN # U468) OR 2 HOUR RATED PER UL 411.
- PARTY WALLS SHALL HAVE 3" THICK SOUND ATTENUATION BLANKET INSTALL FULL HEIGHT.
- ALL INTERIOR DRYWALL PARTITIONS SHALL BE 35 SJ 20 GAUGE STEEL STUDS SPACED 16" O.C. TO 9'-6" CEILING UNLESS NOTED OTHERWISE.
- INTERIOR PARTITIONS SHALL BE FACED BOTH SIDES WITH 1/2" STANDARD DRYWALL.
- ALL MASONRY WALLS SHALL RECEIVE 1 1/2" METAL "Z" FURRING AT 24" O.C. AND 1 1/2" STYROFOAM INSULATION WITH 1/2" STANDARD DRYWALL TO 9'-6" HEIGHT.
- GENERAL CONTRACTOR TO INSTALL PLYWOOD BACKING BEHIND ALL SHELVING AND SINKS AS NEEDED TO SUPPORT SUCH ITEMS. PLY WOOD BACKING IS TO BE INSTALLED BEHIND ITEMS 16, 28, 37, 51, & OFFICE CABINET. SEE SHEET A-2 FOR ITEM LOCATIONS.
- GENERAL CONTRACTOR TO RUN EXTERIOR EXPOSED PHONE LINE THRU STEEL CONDUIT.
- GENERAL CONTRACTOR SHALL FURNISH AND INSTALL THE FOLLOWING BATH ACCESSORIES: BY BOBRICK 800-833-4331 = SHAWN STONE
A. PAPER TOWEL DISPENSER = BOBRICK B-262
B. LIQUID SOAP DISPENSER = BOBRICK B-412
C. TOILET PAPER HOLDER = BOBRICK B-2140
D. 18"X21" STAINLESS STEEL FRAMED MIRROR = BOBRICK B-145
E. DOOR MOUNTED ROBE HOOK
F. WALL MOUNTED GRAB BAR = BOBRICK B-6106 36" & 48"
G. HANDICAP RESTROOM REG'D. EQUIPMENT PER LOCAL CODES

NOTE :
ALL NEW WALLS SHOWN SHADED

NOTE :
ALL EXIST. WALLS SHOWN HATCHED


NOTE :
ALL WALLS TO BE REMOVED SHOWN DASHED

CONTRACTOR OR OWNER TO VERIFY ALL DIMENSIONS AND CONDITIONS, PRIOR TO ERECTING WALLS AND STARTING CONSTRUCTION.

NEW PAPA JOHN'S PIZZA STORE :
WEST PARKER ROAD
PLANO, TX.
COPYRIGHT © BAYUS-EVOLA ARCHITECTS
1994 - ALL RIGHTS RESERVED

EQUIPMENT/FLOOR PLAN

SCALE : 1/4"=1'-0"

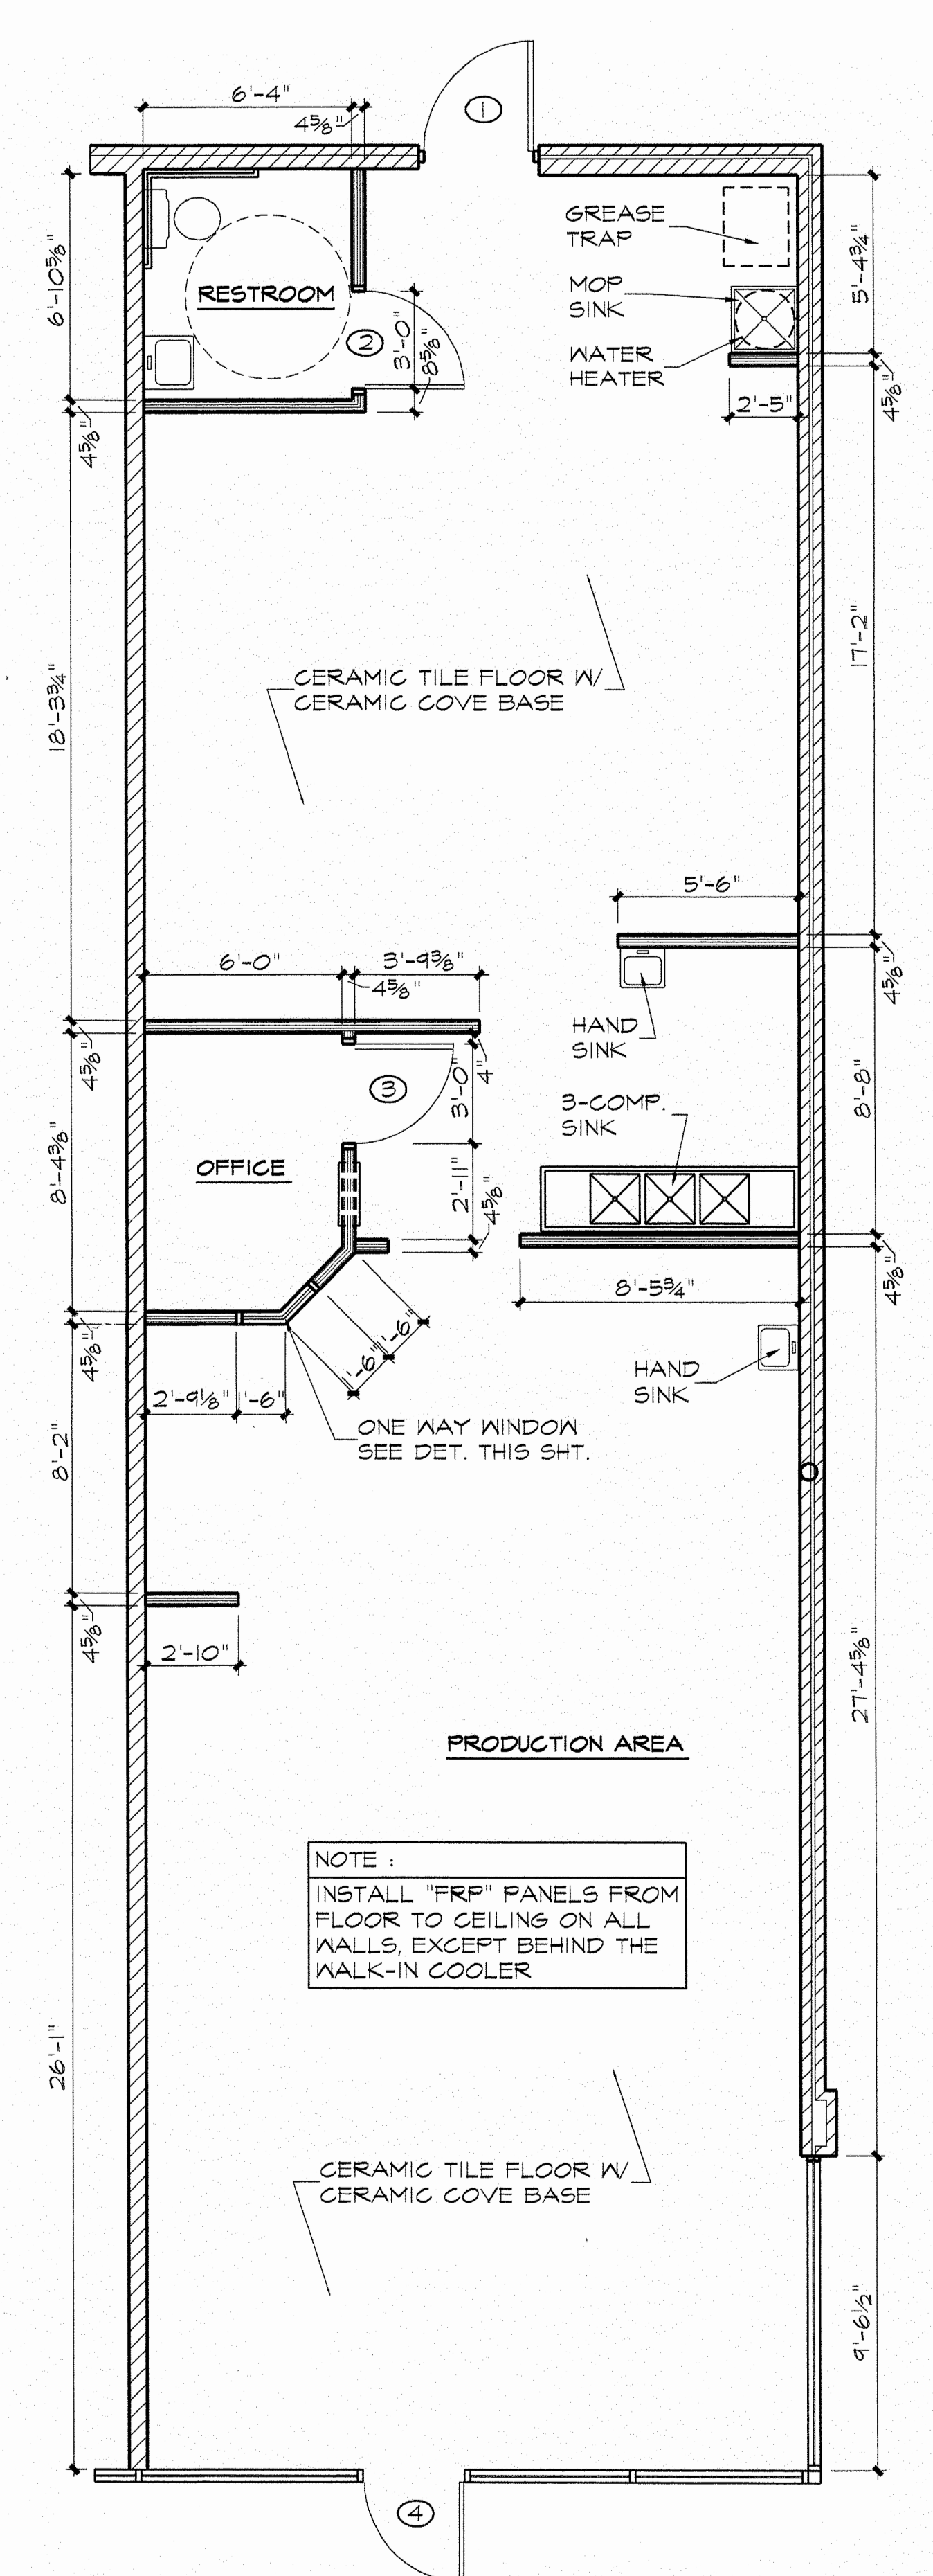

NOTE :
INSTALL "FRP" PANELS FROM FLOOR TO CEILING ON ALL WALLS, EXCEPT BEHIND THE WALK-IN COOLER

99-422-1093
PROJECT NUMBER

PAPAJOHN'S
Better Ingredients.
Better Pizza.

PAPA JOHN'S INTERNATIONAL, INC.
11492 BLUEGRASS PARKWAY
LOUISVILLE, KENTUCKY 40299

REGISTERED ARCHITECT
STATE OF TEXAS
1998

BAYUS EVOLA
ARCHITECTS

SUITE 140
661 SOUTH HURSTBOURNE LANE
LOUISVILLE, KENTUCKY 40222
(502) 426-8020


NEW PAPA JOHN'S PIZZA STORE :
WEST PARKER ROAD
PLANO, TX.

DATE: 2 / 15 / 99
DATE REVISED

SHEET TITLE
EQUIPMENT/FLOOR PLAN
SCHEDULE
NOTES

SHEET NUMBER

A-1

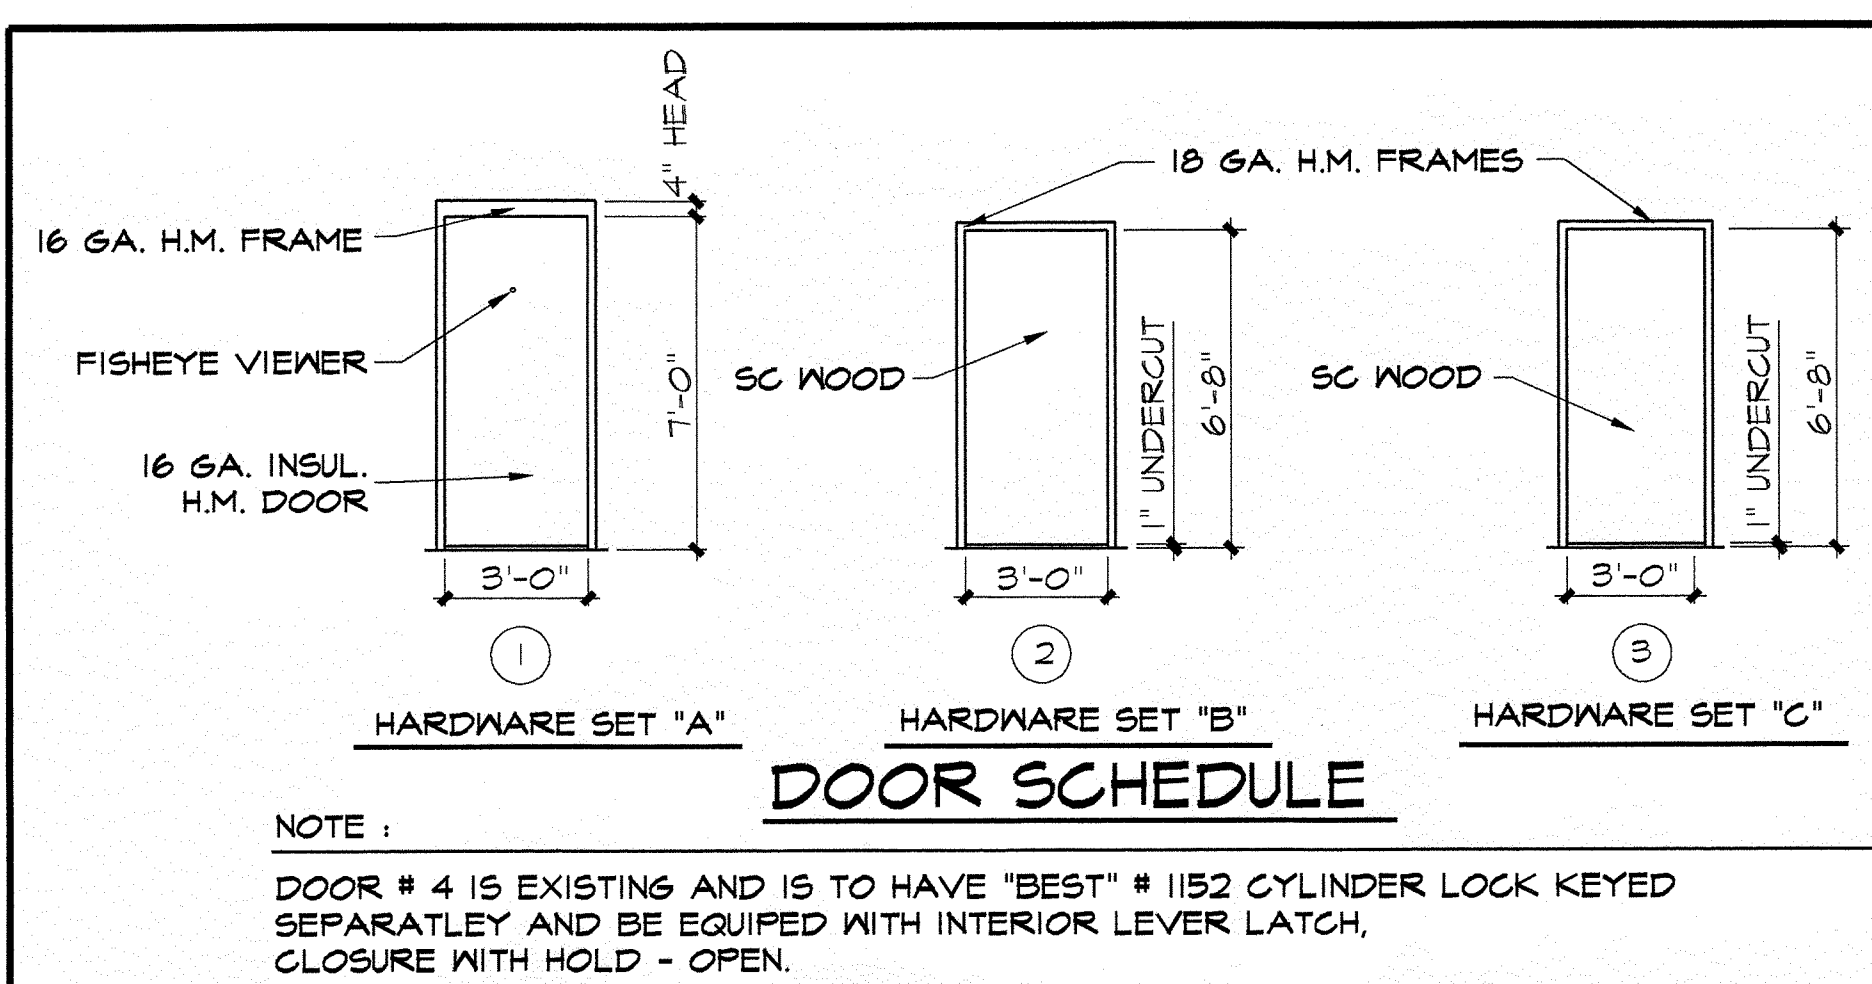


NOTE :

DOOR # 4 IS EXISTING AND IS TO HAVE "BEST" # 1152 CYLINDER LOCK KEYED SEPARATELY AND BE EQUIPED WITH INTERIOR LEVER LATCH, CLOSURE WITH HOLD - OPEN.


ROOM FINISH SPECIFICATIONS

- ALL DRYWALL WALLS TO RECEIVE "FRP" PANELS FROM FLOOR TO CEILING EXCEPT BEHIND THE COOLER
- PAPA JOHN'S SPECIAL PAINT COLORS:
WHITE - "SHERWIN WILLIAMS" B 33 W 201 - 200 OIL BASE EGG SHELL
RED - "SHERWIN WILLIAMS" B54R38 (SAFETY RED) + VIOLET-4/32 + BLUE-4/32
GREEN - "SHERWIN WILLIAMS" B54T104 (SAFETY GREEN MC-42) + 8/32 BLACK.
- FLOOR TILE TO BE PJ 9610 12"X12" CERAMIC TILE MANUFACTURED BY KPT UNDER PRIVATE LABEL EXCLUSIVE FOR PAPA JOHN'S. GROUT TO BE CADET GREY. BASE IS TO BE 6"X8" CERAMIC COVE BASE BY KPT. ALL TILES TO BE ADHESIVE SET. AVAILABLE AT TILE DISTRIBUTORS 1-800-274-8453.
- INSTALL "FRP" PANELS ON ALL WALLS FROM FLOOR TO CEILING. THIS INCLUDES THE OFFICE AND THE RESTROOM. INSTALL COMPLETE WITH ALL TRIM AND ACCESSORIES TO BE INSTALLED PER MANUFACTURER'S INSTRUCTIONS. PANELS TO BE "FRP" PANELS AS MANUFACTURED BY "KEMLITE CORPORATION" - RICH EIGHORN 1-800-435-0080 "FRP" PANEL TO BE (GLASBORD-F, PRODUCT CODE #BES385-FI) FOR 2" CORNER GUARD (PRODUCT # 0A852-10 WHITE)
- CEILING SHALL BE WASHABLE, HARD SURFACE VINYL FACED 24"X48" LAY-IN ACOUSTIC PANELS IN "STIPPLE" FINISH WITH WHITE ALUMINUM "T" GRID SYSTEM IS PATTERN SHOWN STORAGE AREAS AND BATH CEILINGS MAY BE STANDARD ACOUSTIC OR PAINTED DRYWALL.
- ALL DOORS, FRAMES AND WOOD TRIM SHALL BE PAINTED TWO COATS OF "WHITE".
- FURNISH AND INSTALL A ONE-WAY GLASS VIEW WINDOW IN OFFICE WALL - WINDOW TO BE WOOD FRAMED AND TRIMMED WITH "FRP" CORNERS. (SEE DETAIL THIS SHEET)
- ALL EXPOSED PARTITION ENDS AND CORNERS SHALL HAVE 5" 2"X2" "FRP" CORNER GUARDS INSTALLED.

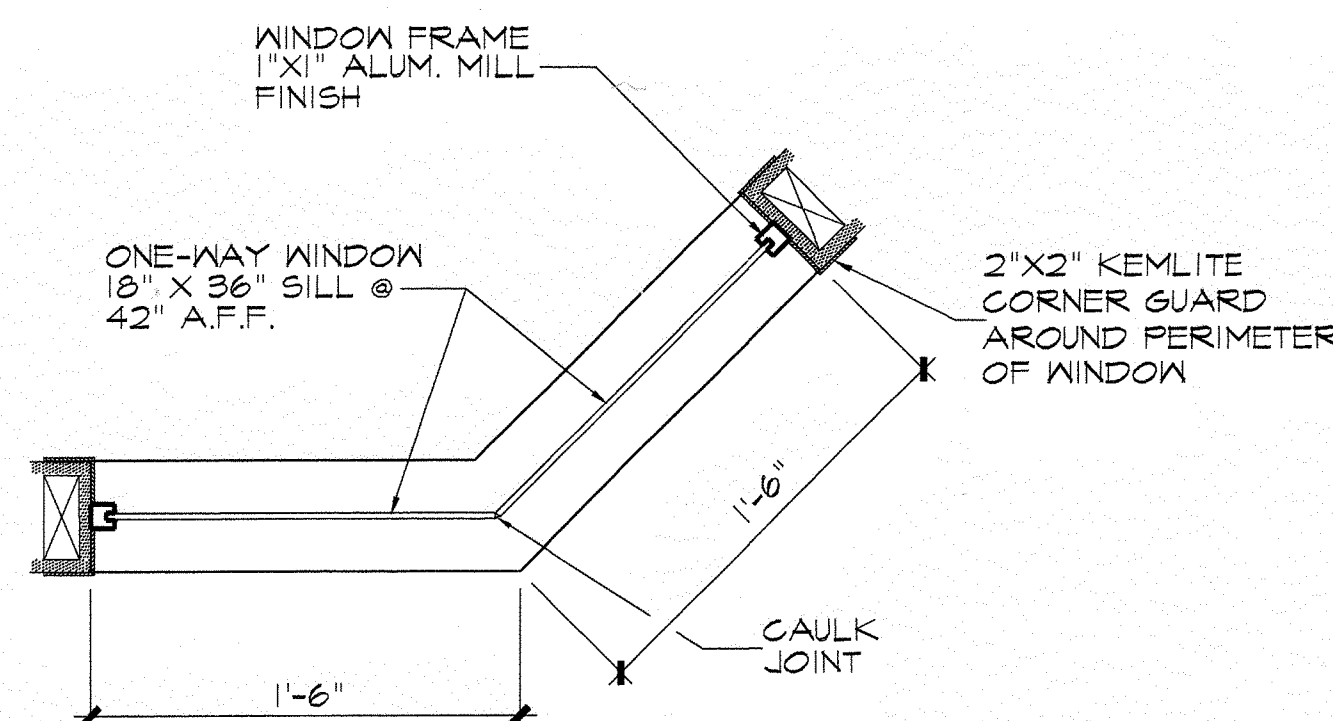

OFFICE WINDOW

SCALE : 1/2"=1'-0"

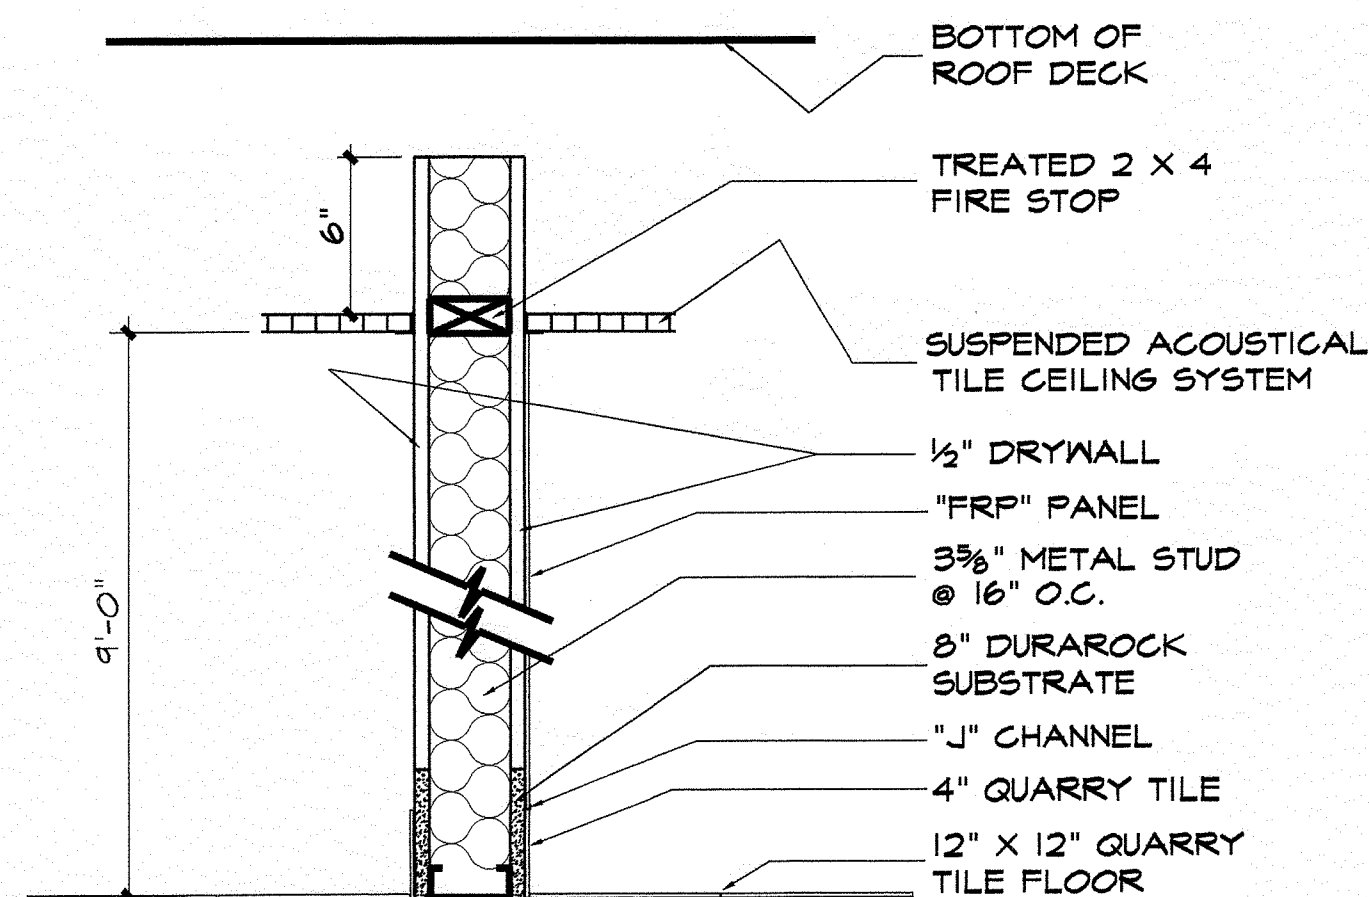

NOTE :
THIS IS A NON LOAD BEARING WALL AND IS NOT A FIRE RATED ASSEMBLY.

INTERIOR WALL SECTION


SCALE : 1/2"=1'-0"

EQUIPMENT REQUIRED FOR SAFE INSTALLATION :


- 4ea 3/8" MOLLY PARABOLT
- 1/2" DRILL MOTOR
- 3/8" CARBIDE BIT
- HAMMER
- 3/8" WRENCH OR SOCKET & DRIVER
- LIQUID ROCK (1 pkg)
- SAFETY GOGGLES

INSTALLATION INSTRUCTIONS :

- POSITION SAFE IN PLACE WHERE IT IS GOING TO BE INSTALLED.
- TRACE THE HOLES ON THE BOTTOM OF THE SAFE ONTO THE FLOORSURFACE BELOW.
- REMOVE SAFE.
- DRILL THE HOLES W/ THE 3/8" CARBIDE BIT. HOLES MUST BE AT LEAST 4 1/2" DEEP.
- CLEAN THE HOLES OF DEBRIS, MIX & POUR LIQUID ROCK INTO EA. HOLE.
- POSITION SAFE BACK INTO PLACE.
- ADD WASHER & THREAD NUT FLUSH W/ THE TOP OF THE BOLT (SEE DET. #1)
- DRIVE BOLT THROUGH THE HOLE IN THE SAFE.
- TO SET THE FASTENERS, TIGHTEN THE NUT THREE (3) FULL TURNS W/ 3/8" WRENCH OR SOCKET (SEE DET. #2)

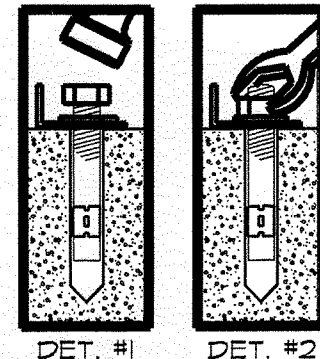

NOTE:
SEE NOTE #12 OF
GENERAL NOTES

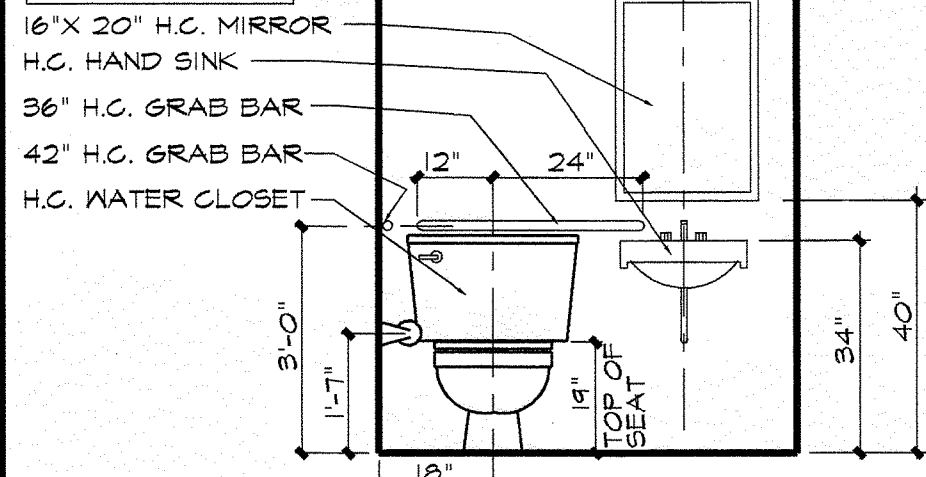

TYPICAL RESTROOM MOUNTING HEIGHTS

HARDWARE SCHEDULE

SET "A"

MARK :	REAR DOOR	3068 F	HM X HM	1 3/4"
CURRIES	1	FRAME	3068 1"X1" SERIES 5 3/8"	16 GA. KNOCKDOWN
CURRIES	1	DOOR	3068 1075 SERIES FLUSH	20GA. W/ TOP CAP
HASER	3	HINGES	BB1271 4 1/2"X4 1/2"	26D
MONARCH	1	EXIT DEVICE	14-R-L-CONTROL X DANE X 560	MAL/32D
SCHLAGE	1	MORTISE CYLINDER	20-001 1 1/4" 'C' SECTION	26D
NORTAN	1	CLOSER	CLP801BF	ALUM.
IVES	1	VIEWER	100B426D	ALUM.
HASER	1	DOOR SWEEP	T56SAV	36"
HASER	1	THRESHOLD	412SA	36"
HASER	1	WEATHERSTRIP	T26S	17"
HASER	1	RAINSPR	810SA	40"
PRECISION	1	LOCK GUARD	1621NL	PRIME PAINT

SET "B"

MARK :	RESTROOM DOOR	3068 F	WOOD X HM	1 3/4"
CURRIES	1	FRAME	3068 1"X1" SERIES 5 3/8"	16 GA. KNOCKDOWN
CURRIES	1	DOOR	3068 SOLID PARTICLEBOARD CORE 1 3/4" FLUSH	
HASER	3	HINGES	BB1271 4 1/2"X4 1/2"	26D
SCHLAGE	1	PRIVACY SET	AL40S8SATURNX2 3/4"X4 1/2"	26D
NORTAN	1	CLOSER	8501BF	ALUM.
HASER	1	STOP WALL - 256W OR FLOOR - 241F		26D

SET "C"

MARK :	OFFICE DOOR	3068 F	WOOD X HM	1 3/4"
CURRIES	1	FRAME	3068 1"X1" SERIES 5 3/8"	16 GA. KNOCKDOWN
CURRIES	1	DOOR	3068 SOLID PARTICLEBOARD CORE 1 3/4" FLUSH	
HASER	3	HINGES	BB1271 4 1/2"X4 1/2"	26D
SCHLAGE	1	LOCKSET	AL58FDX5ATURNX2 3/4"X4 1/2"	26D
NORTAN	1	CLOSER	8501BF	ALUM.
HASER	1	STOP WALL - 256W OR FLOOR - 241F		26D

SET "D"

MARK :	FRONT DOOR	PAIR (OR SINGLE)	3068 F6	ALUM X ALUM	1 3/4"
SCHLAGE	1	MORTISE CYLINDER	20-001 1 1/4"XCYL. RING		
			FINISH TO MATCH ALUMINUM DOORS.		

BALANCE BY DOOR SUPPLIER TO INCLUDE

- HINGES/PIVOTS 2 EA. CLOSERS
1 FR. FLUSH BOLTS 2 EA. PUSH/PULLS
1 MORTISE T-TURN 1 EA. THRESHOLD
1 SET WEATHER STRIP

NOTE :

ALL HARD WARE TO MEET LOCAL AND A.D.A. CODES.
PROVIDE TWO CHANGE KEYS PER LOCK/CYL. AND 3 MASTER KEYS

ALL HARDWARE IS AVAILABLE FROM CONSTRUCTION HARDWARE, INC.

1800 COBALT DRIVE - LOUISVILLE, KY. 40299-2414

PHONE : (502)-267-0444

FAX : (502)-267-0446

CONTACT : JIM DELOZIER

NOTE :

ALL HARDWARE COMPLIES W/ SEC.1114 OF THE N.C.S.B.C.G.

ALL HARDWARE COMPLIES W/ SEC. 1017.4 OF THE 1993 B.O.C.A. CODE.

GENERAL NOTES:

- DIMENSIONS ARE DRYWALL - TO - DRYWALL OR DRYWALL - TO - MASONRY.
- GENERAL CONTRACTOR SHALL INSTALL ALL REQUIRED BLOCKING FOR ALL EQUIPMENT, HANGERS, ETC.
- ALL WORK SHALL CONFORM TO ALL LOCAL AND STATE CODES AND REGULATIONS.
- ALL PARTY WALLS SHALL BE 35 SJ 20 GAUGE MINIMUM STEEL STUDS SPACED 16" O.C. AND EXTENDED FROM SLAB TO ROOF.
- PARTY WALLS SHALL BE FACED BOTH SIDES WITH 1/2" FIRE CODE DRYWALL FULL HEIGHT TO ROOF STRUCTURE TO CREATE A ONE-HOUR FIRE RATED PARTITION. (UL DESIGN # 1468) OR 2 HOUR RATED PER UL 411.
- PARTY WALLS SHALL HAVE 3" THICK SOUND ATTENUATION BLANKET INSTALL FULL HEIGHT.
- ALL INTERIOR DRYWALL PARTITIONS SHALL BE 35 SJ 20 GAUGE STEEL STUDS SPACED 16" O.C. TO 9'-6" CEILING UNLESS NOTED OTHERWISE.
- INTERIOR PARTITIONS SHALL BE FACED BOTH SIDES WITH 1/2" STANDARD DRYWALL.
- ALL MASONRY WALLS SHALL RECEIVE 1 1/2" METAL "Z" FURRING AT 24" O.C. AND 1 1/2" STYROFOAM INSULATION WITH 1/2" STANDARD DRYWALL TO 9'-6" HEIGHT.
- GENERAL CONTRACTOR TO INSTALL PLYWOOD BACKING BEHIND ALL SHELVING AND SINKS AS NEEDED TO SUPPORT SUCH ITEMS. PLY WOOD BACKING IS TO BE INSTALLED BEHIND ITEMS 16, 28, 37, 51, & OFFICE CABINET. SEE SHEET A-2 FOR ITEM LOCATIONS.
- GENERAL CONTRACTOR TO RUN EXTERIOR EXPOSED PHONE LINE THRU STEEL CONDUIT.
- GENERAL CONTRACTOR SHALL FURNISH AND INSTALL THE FOLLOWING
BATH ACCESSORIES: BY BOBRICK 800-853-4331 - SHAWN STONE
A. PAPER TOWEL DISPENSER = BOBRICK B-262
B. LIQUID SOAP DISPENSER = BOBRICK B-412
C. TOILET PAPER HOLDER = BOBRICK B-2140
D. 18"X21" STAINLESS STEEL FRAMED MIRROR = BOBRICK B-145
E. DOOR MOUNTED ROSE HOOK
F. WALL MOUNTED GRAB BAR = BOBRICK B-6106 36" & 48"
G. HANDICAP RESTROOM REQ'D. EQUIPMENT PER LOCAL CODES

NOTE :
ALL NEW WALLS
SHOWN SHADED

NOTE :
ALL EXIST. WALLS
SHOWN HATCHED

NOTE :
ALL WALLS TO BE
REMOVED SHOWN
DASHED


CONTRACTOR OR OWNER
TO VERIFY ALL DIMENSIONS
AND CONDITIONS, PRIOR TO
ERECTING WALLS AND
STARTING CONSTRUCTION.

NEW PAPA JOHN'S PIZZA STORE :
WEST PARKER ROAD
PLANO, TX.

COPYRIGHT © BAYUS-EVOLA ARCHITECTS
1994 - ALL RIGHTS RESERVED

EQUIPMENT/FLOOR PLAN

SCALE : 1/4"=1'-0"

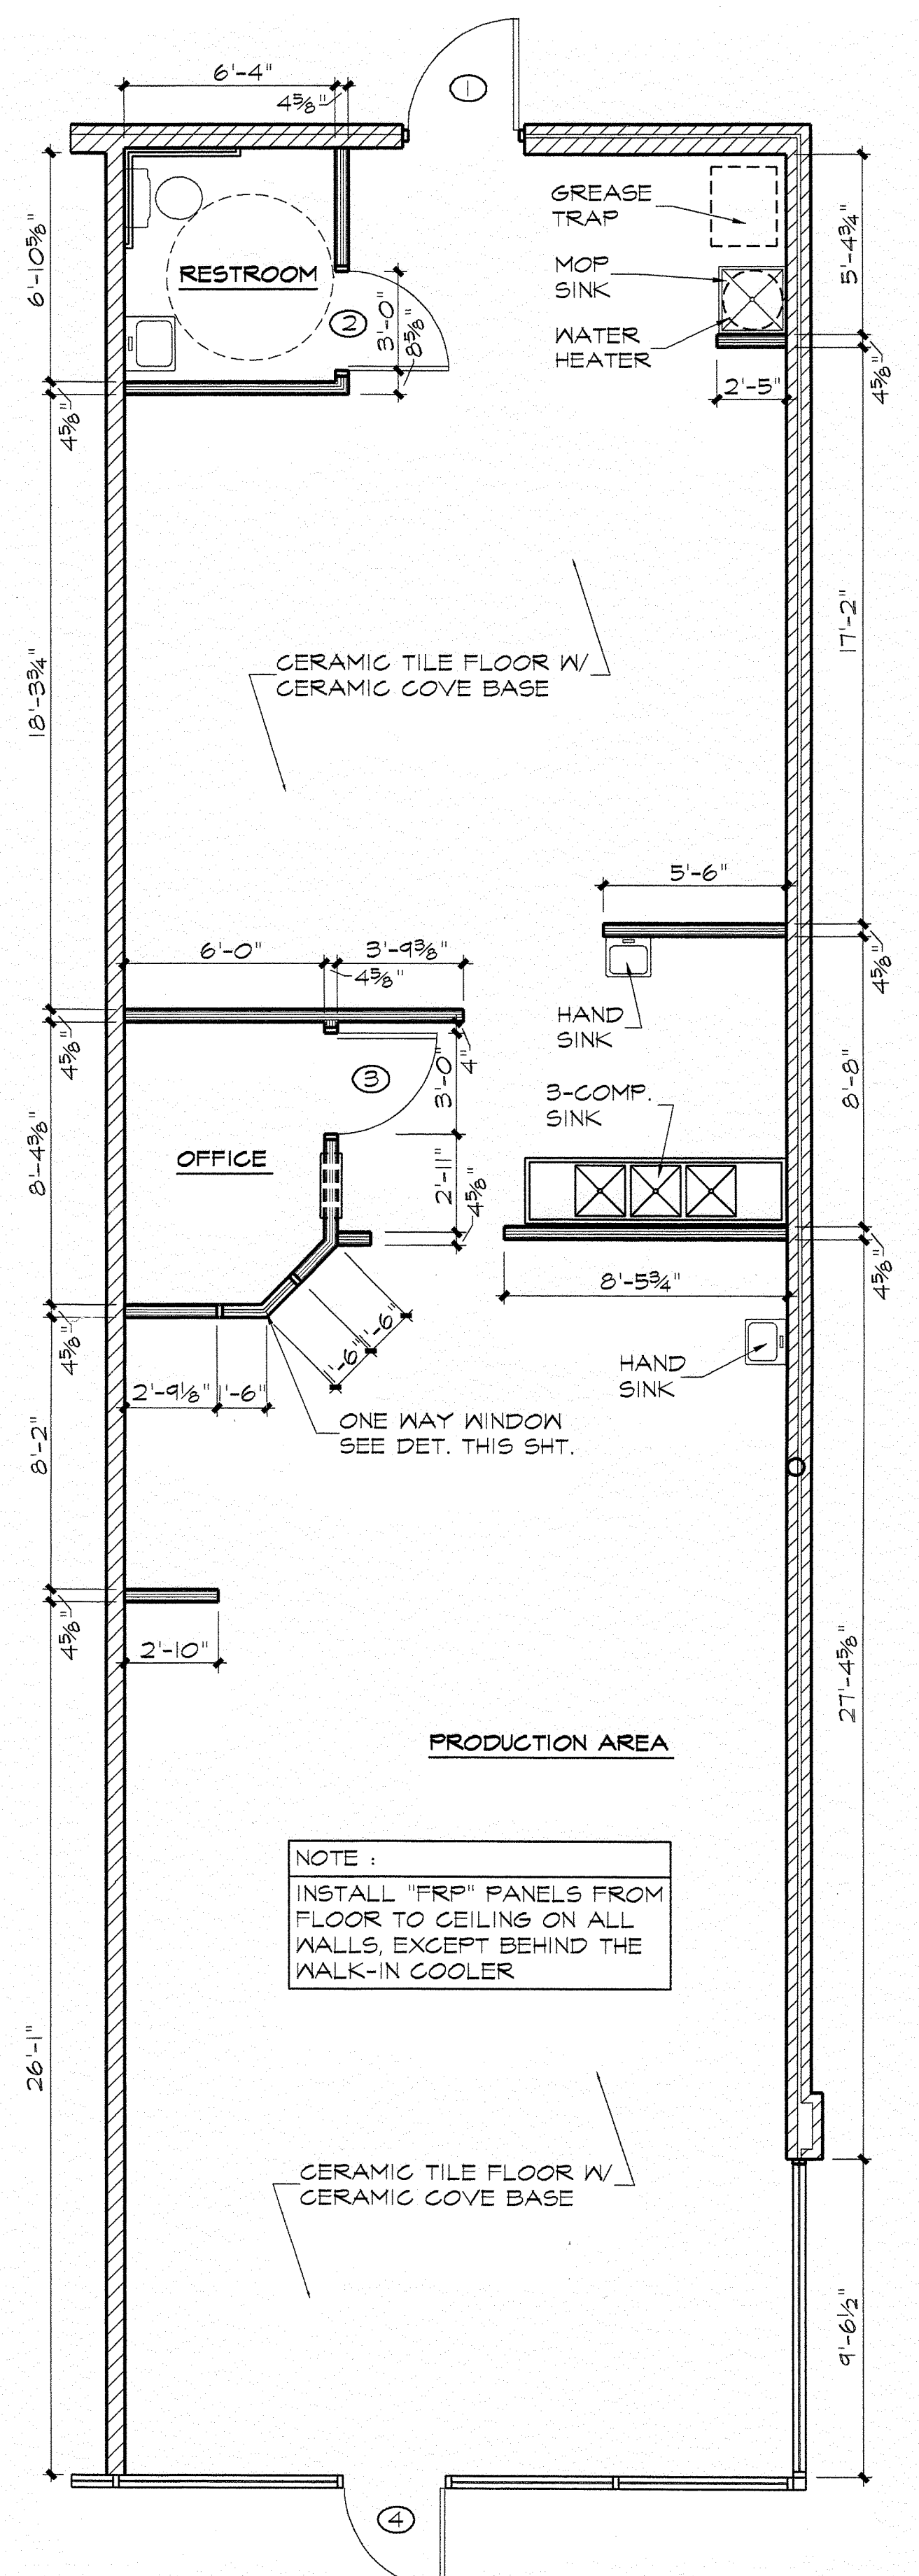


NOTE :
INSTALL "FRP" PANELS FROM
FLOOR TO CEILING ON ALL
WALLS, EXCEPT BEHIND THE
WALK-IN COOLER

99-422-1093

PROJECT NUMBER

PAPA JOHN'S
Better Ingredients.
Better Pizza.

PAPA JOHN'S INTERNATIONAL, INC.
11492 BLUEGRASS PARKWAY
LOUISVILLE, KENTUCKY 40299

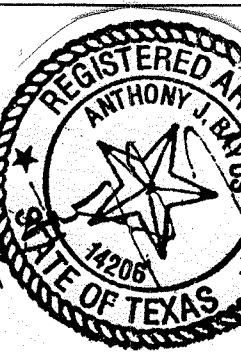

BAYUS
EVOLA

ARCHITECTS

SUITE 140
661 SOUTH HURSTBOURNE LANE
LOUISVILLE, KENTUCKY 40222
(502) 426-8020

NEW PAPA JOHN'S PIZZA STORE :
WEST PARKER ROAD
PLANO, TX.

DATE: 2 / 15 / 99

DATE REVISED

SHEET TITLE

EQUIPMENT/FLOOR PLAN
SCHEDULE
NOTES

SHEET NUMBER

A-1

EQUIPMENT SCHEDULE


NO.	DESCRIPTION OF ITEM	FURN.	INST.	REMARKS
1A	MIDDLEBY MARSHALL MODEL PS-360 PIZZA OVEN	ASI/SSJ	ASI/SSJ	SEE NOTE # 1
1B	MIDDLEBY MARSHALL MODEL PS-360MB PIZZA OVEN	ASI/SSJ	ASI/SSJ	
1C	MIDDLEBY MARSHALL MODEL PS-360MBTO PIZZA OVEN	ASI/SSJ	ASI/SSJ	
1D	MIDDLEBY MARSHALL MODEL PS-360CMB PIZZA OVEN	ASI/SSJ	ASI/SSJ	
2	OVEN HOOD			
3	MAKELINE - VICTORY PT - 80 - S - PJ	ASI/SSJ	ASI/SSJ	SEE NOTE # 2
4A	48"X96" CUTTING/BOX TABLE W/ (2) HEAT SHELVES	ASI/SSJ	ASI/SSJ	SEE NOTE # 3
4B	48"X120" CUTTING/BOX TABLE W/ (2) HEAT SHELVES	ASI/SSJ	ASI/SSJ	SEE NOTE # 3
5	TELEPHONE COUNTER W/ ADJUSTABLE SHELVES	ASI/SSJ	ASI/SSJ	SEE DETAIL THIS SHT.
6	FRONT CORIAN SERVING SHELF	ASI/SSJ	ASI/SSJ	SEE DETAIL THIS SHT.
7	48"30 STAINLESS STEEL TABLE W/ S.S. SHELF	ASI/SSJ	ASI/SSJ	
8	60"30 STAINLESS STEEL TABLE W/ S.S. SHELF	ASI/SSJ	ASI/SSJ	
9A	84"30 S.S. TABLE W/ SAFE CUT OUT IN S.S. SHELF	ASI/SSJ	ASI/SSJ	
9B	96"30 S.S. TABLE W/ SAFE CUT OUT IN S.S. SHELF	ASI/SSJ	ASI/SSJ	
9C	96"30 STAINLESS STEEL TABLE W/ S.S. SHELF	ASI/SSJ	ASI/SSJ	
10A	12"30 STAINLESS STEEL TABLE W/ S.S. SHELF	ASI/SSJ	ASI/SSJ	
10B	12"30 S.S. TABLE W/ SAFE CUT OUT IN S.S. SHELF	ASI/SSJ	ASI/SSJ	
11	CLIP BOARD / DELI TICKET HOLDER	ASI/SSJ	ASI/SSJ	
12	WALK-IN COOLER (SEE PLAN FOR SIZE)	ASI/SSJ	ASI/SSJ	SEE NOTE # 6 & # 7
13	KOLD PACK SPLIT SYSTEM	ASI/SSJ	ASI/SSJ	SEE NOTE # 6 & # 7
14	RED 44 GAL. "RUBBERMAID" GARBAGE CAN W/ LID	ASI/SSJ	ASI/SSJ	SEE DETAIL THIS SHT.
15	24" X 48" FLAT ALUMINUM DUNNAGE RACK	ASI/SSJ	ASI/SSJ	
16	46" (3) COMPARTMENT STAINLESS STEEL SINK	ASI/SSJ	ASI/SSJ	
17	GREASE TRAP - ZURN MODEL # 2-1170-R, 46PM, 8LB	FC	FC	SEE NOTE # 4
18	FLOOR SINK-FLAT MODEL MBS 2424 FIBERGLASS	FC	FC	SEE NOTE # 5
19	18" X 48" ALUMINUM DUNNAGE RACK	ASI/SSJ	ASI/SSJ	
20	18" X 48" - (4) SHELF PLASTIC STORAGE UNIT	ASI/SSJ	ASI/SSJ	
21	18" X 60" - (4) SHELF ZINK STORAGE UNIT	ASI/SSJ	ASI/SSJ	
22	25" X 35" X 41" HIGH MOBILE S.S. CANTACK TABLE	ASI/SSJ	ASI/SSJ	
23	48" 2"X2" FRP CORNER GUARDS	GC	GC	
24	PLASTIC LAMINATE DESK TOP	ASI/SSJ	ASI/SSJ	SEE DETAIL THIS SHT.
25	CUSTOMER TABLE - 30"X30" RED PLASTIC LAM.	ASI/SSJ	ASI/SSJ	METAL LEGS ON TABLE
26	CHROME LEGS, RED UPHOLSTERY CUSTOMER CHAIR	ASI/SSJ	ASI/SSJ	
27	CAN BEVERAGE COOLER AND DISPENSER	FRAN	FRAN	
28	(2) 18" X 48" ZINC WIRE SHELVES W/ BRACKETS	ASI/SSJ	GC	MOUNT 12" A.F.F.
29	6" X 40" X 3/4" COAT HOOK STRIP W/ 7 HOOKS	ASI/SSJ	ASI/SSJ	MOUNT 60" A.F.F.
30	1" X 3" BRED PLASTIC LAMINATE CHAIR RAIL	ASI/SSJ	ASI/SSJ	MOUNT 30" A.F.F.
31	TELEPHONE SYSTEM	VENDOR	VENDOR	INSTALL PER JTS SPECS.
32	(2) - DRAWER LETTER SIZE FILE CABINETS	FRAN	FRAN	BEIGE COLOR
33	PLASTIC LAMINATE DRIVER'S DROP BOX HOLDER	ASI/SSJ	ASI/SSJ	
34	LOCKING CASH DRAWER	ASI/SSJ	ASI/SSJ	UNDER FRONT COUNTER
35	15 LBS. DRAY CHEMICAL FIRE EXTINGUISHER	ASI/SSJ	ASI/SSJ	COMPLETE W/ BRACKET
36	FLOOR MOUNTED TIME DELAY SAFE	ASI/SSJ	GC	
37	HAND SINK WALL MOUNTED	ASI/SSJ	FC	
38	BUBBLE FORD HOLDER	ASI/SSJ	ASI/SSJ	
39	MENUBOARD 60" X 21 1/2" X 3/8"	ASI/SSJ	GC	SEE DETAIL THIS SHT.
40	STAINLESS STEEL POT HOLDER	ASI/SSJ	ASI/SSJ	
41	3/4" X 12" RED PLASTIC LAM. SHELF W/ BRACKETS	GC	GC	MOUNT 12" A.F.F.
42	COOLER LIGHT	ASI/SSJ	ASI/SSJ	
43	ONE WAY WINDOW FROM OFFICE	GC	GC	
44	DRIVERS TELEPHONE	VENDOR	VENDOR	
45	CLOCK	ASI/SSJ	ASI/SSJ	
46	FLOUR SHIELD	ASI/SSJ	ASI/SSJ	
47	2" GAS LINE	FC	FC	
48	SPLASH GUARD	ASI	GC	
49	COMMISSARY COMMUNICATION HOLDER	ASI/SSJ	ASI/SSJ	
50	EMPLOYMENT APPLICATION DEPOSIT	ASI/SSJ	ASI/SSJ	
51	COMPUTER MONITOR SHLEF	ASI/SSJ	ASI/SSJ	6" OF MONITOR @ 60" A.F.F.
52	VEGGIE SINK	ASI/SSJ	FC	
53	CHEESE RACK	ASI/SSJ	ASI/SSJ	

AIR SYSTEM, INC. WILL FURNISH & INSTALL THE FOLLOWING PLASTIC LAMINATE ITEMS.


- 5-TELEPHONE COUNTER COMPLETE WITH ADJUSTABLE SHELVES, FRONT PANEL WITH VINYL BASEBOARD, BACK SPLASH PANEL AND FLOUR SHIELD, FRONT TRIM, BACK, SHELVES AND TELEPHONE TOP COUNTER AND FLOUR SHIELD TO BE WILSONART "REGIMENTAL RED 12-6" WITH FRONT TO BE WILSONART "BRUSHED METAL".
- 6-FRONT SERVING SHELF WITH 1" THICK "CORIAN GLASIER WHITE" WITH 1/2" RED ACCENT STRIP.
- 24-OFFICE DESK TOP TO BE WILSONART "REGIMENTAL RED 12-6" WITH SELF-EDGE AND 3" BACK AND END SPLASH. TOP TO BE COMPLETE WITH WALL SUPPORT BRACKETS. 30" A.F.F.
- 25-CUSTOMER TABLE - 30"X30" WILSONART "REGIMENTAL RED 12-6" TOP AND EDGES. TABLES TO HAVE BLACK METAL LEGS.
- 41-3/4"X12" SHELF WITH WILSONART "REGIMENTAL RED 12-6" ON ALL FACES. SHELF TO BE INSTALLED 12" ABOVE FINISH FLOOR WHERE SHOWN ON PLANS. FURNISH ALL REQUIRED MOUNTING BRACKETS.
- 29-3/4"X6"X40" COAT HOOK STRIP WITH WILSONART "REGIMENTAL RED 12-6" ON FACE AND ALL EDGES. ATTACH 7 ALUMINUM COAT HOOKS SPACED EVENLY AND MOUNT 60" A.F.F.
- 30-1"X3" CHAIR RAIL WITH WILSONART "REGIMENTAL RED 12-6" ON FACE AND BOTH EDGES. CUT TO LENGTH AND INSTALL 30" ABOVE FINISH FLOOR WHERE SHOWN ON PLANS.
- 11-1"X6"X40" LONG CLIP BOARD STRIP WITH WILSONART "REGIMENTAL RED 12-6" ON FACE AND ALL EDGES. INSTALL 60" ABOVE FINISH FLOOR ON OFFICE WALL.
- 33-DRIVER'S DROP BOX HOLDER WITH WILSONART "REGIMENTAL RED 12-6" ON ALL FACES EXCEPT BOTTOM AND BACK.
- 34-16"X18"X4 1/2" CASH DRAWER, FURNISH ALL HARDWARE AND INSTALL UNDER FRONT STEEL WORK TABLE.

NOTES :


1. PIZZA OVEN TO BE MODEL PS-360 GAS FIRED CONVEYOR TYPE AS MANUFACTURED BY MIDDLEBY MARSHALL. OVENS ARE TO BE COMPLETE WITH EXHAUST CANOPY DUCTED TO ROOF MOUNTED EXHAUST FAN. DUCT TO BE INSULATED 16 GA. STEEL. PLUMBING CONTRACTOR TO FURNISH 2" GAS SUPPLY LINE TO OVENS WITH 3/4" GAS VALVES. ASI/JTS TO FURNISH AND INSTALL OVEN EXHAUST HOOD ONTO OVENS. GAS METER - 600 CU. FT. - OVENS MAX. CAP. + H.V.A.C. (FURNACE) + HOT WATER HEATER. ELECTRIC - 200 AMP - SINGLE PHASE SERVICE.
2. MAKELINE TO BE MODEL PTA 30 - SHE COMPLETE WITH PREPARATION RACK PANS, SLIDE RACK, BUN PANS, INSTRUCTIONAL/TICKET TAKER HOLDER AND CASTERS AS MANUFACTURED BY GLENCO STAR.
3. PIZZA CUTTING AND BOXING TABLE TO BE 48"X96" STAINLESS STEEL COMPLETE WITH DBL. OVER SHELVES, TWO HEATED SHELVES, PAN HOLDER AND CASTERS. TABLE TO BE MANUFACTURED BY AIR SYSTEMS, INC.
4. GREASE INTERCEPTOR SEE SHEET P-1
5. FLOOR SINK TO BE 24"X24" FIBERGLASS MODEL 2424 AS MANUFACTURED BY FLAT, INC. SINK SHALL HAVE MODEL 830 - AA FAUCET AND 889 - COMOP STRAINER DRAIN.
6. PLUMBING CONTRACTOR TO MAKE ALL CONDENSATE DRAIN LINE CONNECTIONS FOR WALK-IN COOLER AND DROP-IN "KOLD PACK" REFRIGERATION UNIT.
7. ELECTRICAL CONTRACTOR TO MAKE ALL REQUIRED ELECTRICAL CONNECTIONS FOR WALK-IN COOLER LIGHTING AND REFRIGERATION UNIT. ALSO DBL. HEAT UNIT ON CUT TABLE RESPONSIBILITY:
ASI - DENOTES AIR SYSTEMS, INC.
JTS - DENOTES J-TOWN RESTAURANT SUPPLY COMPANY
GC - DENOTES GENERAL CONTRACTOR
EC - DENOTES ELECTRICAL CONTRACTOR
FC - DENOTES PLUMBING CONTRACTOR
FRAN - DENOTES FRANCHISEE
VENDOR - DENOTES LOCAL SUPPLIER

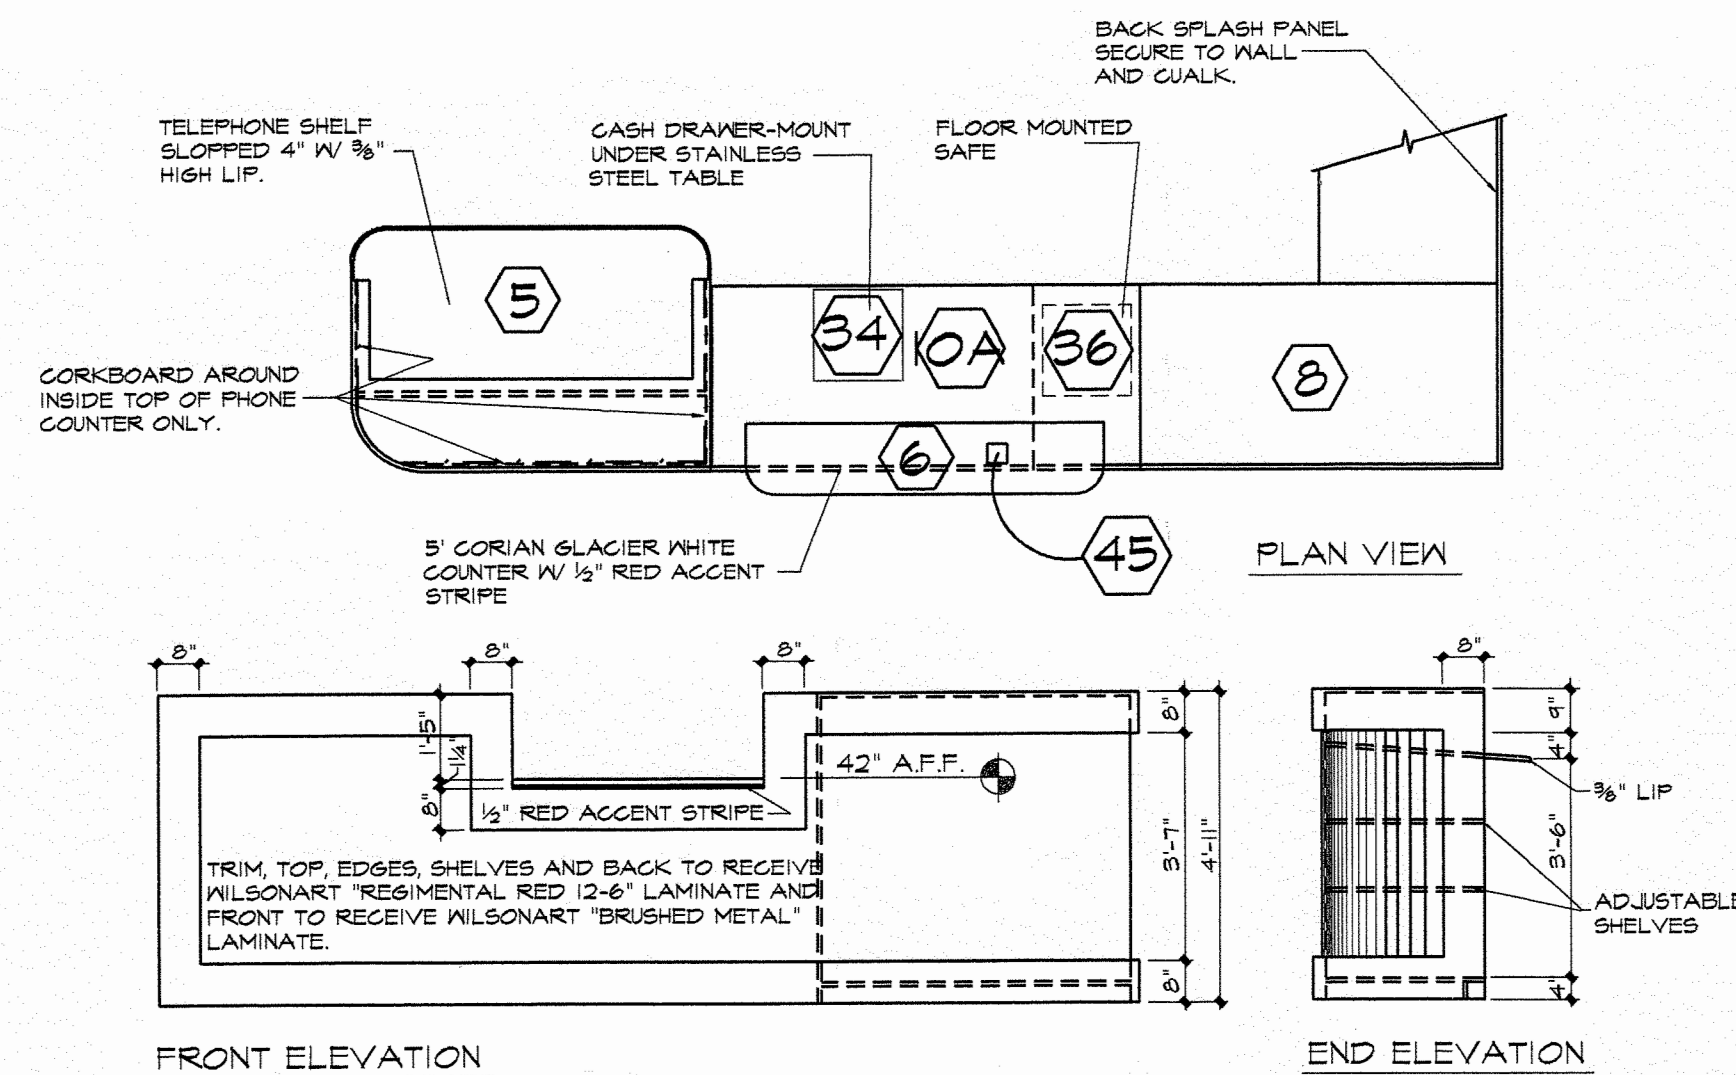


FRONT COUNTER & TELEPHONE DETAILS

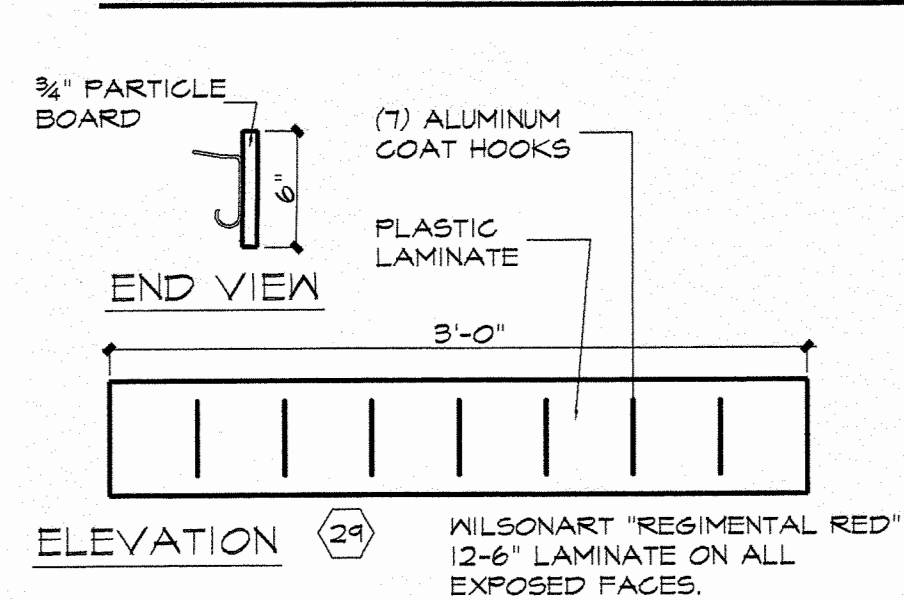

COAT HOOK STRIP

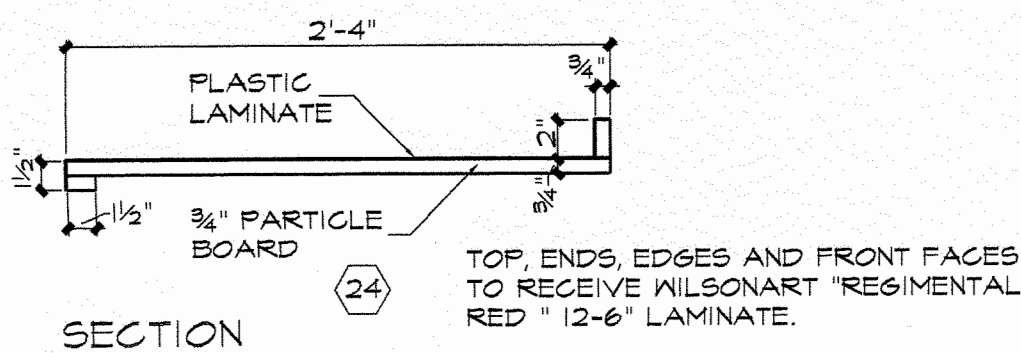


OFFICE DESK TOP

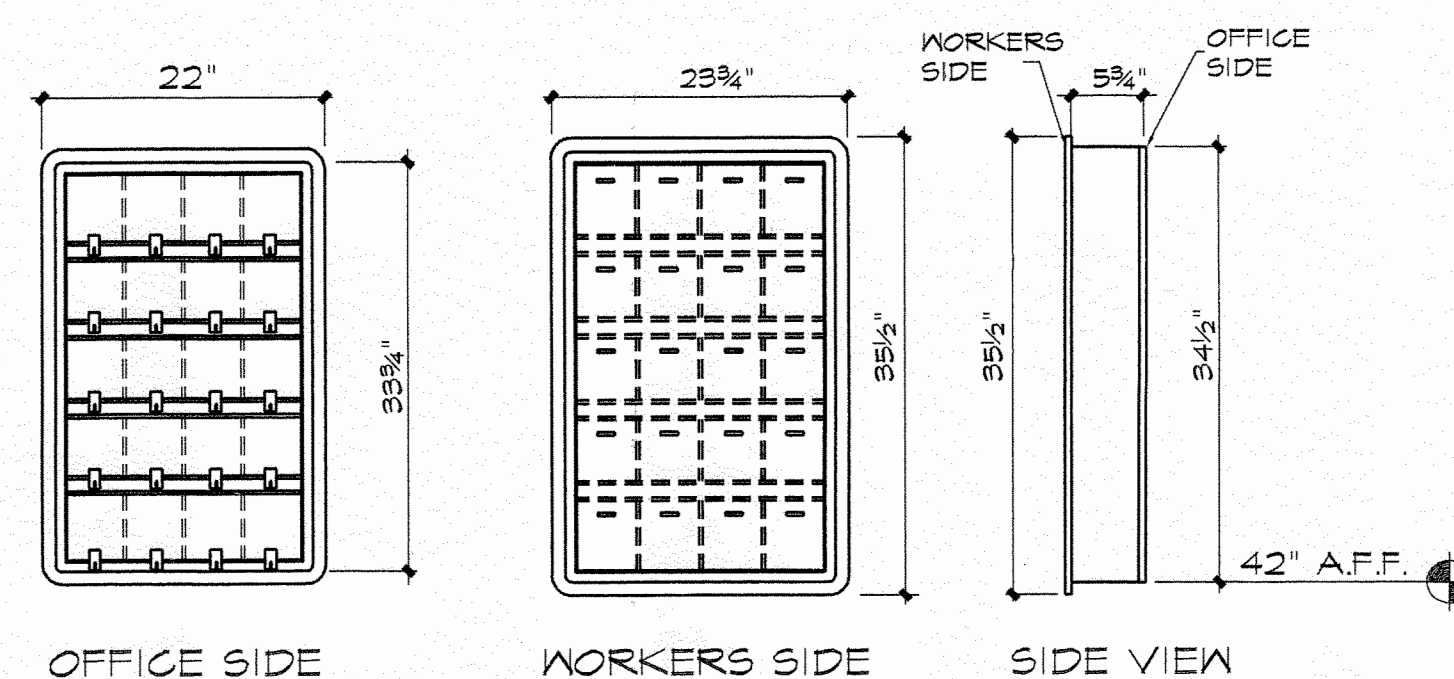

DRIVER'S DROP BOX HOLDER

OFFICE SIDE IS MDF FACE AND DOORS PAINTED REGIMENTAL RED. WORKERS SIDE IS PARTICLE BOARD LAMINATED REGIMENTAL RED ALL WHITE MELAMINE INTERIOR.

CUT OUT FOR DROP BOX IS TO BE 22 3/4" X 34 1/2".

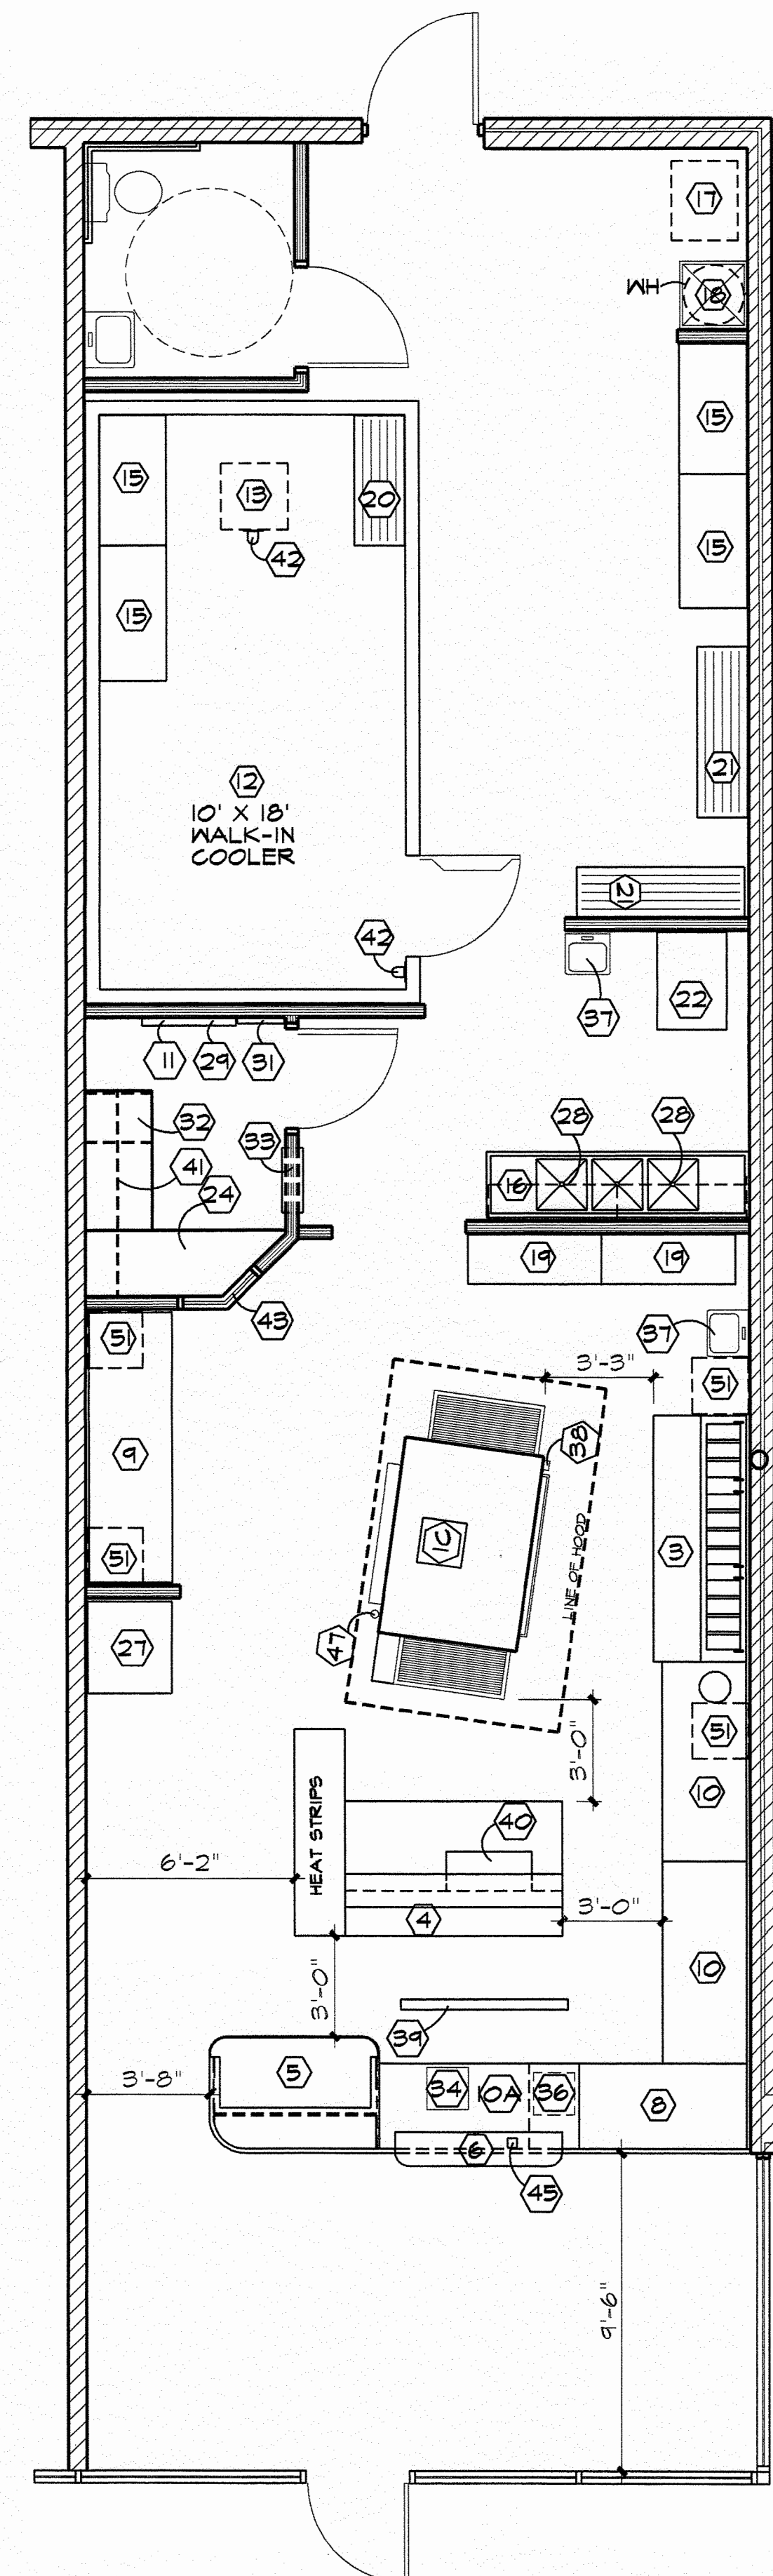

EQUIPMENT FLOOR PLAN

SCALE: 1/4" = 1'-0"


PJP #
99-1093

NEW PAPA JOHN'S PIZZA STORE :
WEST PARKER ROAD
PLANO, TX.
COPYRIGHT © BAYUS-EVOLA ARCHITECTS
1994 - ALL RIGHTS RESERVED

99-422-1093

PROJECT NUMBER

PAPA JOHN'S INTERNATIONAL, INC.
11492 BLUEGRASS PARKWAY
LOUISVILLE, KENTUCKY 40299

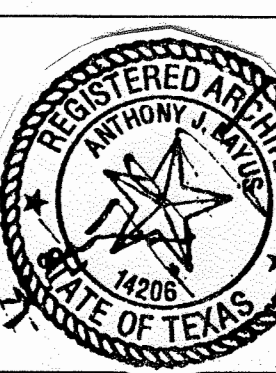

BAYUS EVOLA
ARCHITECTS

SUITE 140
661 SOUTH HURSTBOURNE LANE
LOUISVILLE, KENTUCKY 40222
(502) 426-8020

NEW PAPA JOHN'S PIZZA STORE :
WEST PARKER ROAD
PLANO, TX.

DATE: 2 / 15 / 99


DATE REVISD

SHEET TITLE

EQUIPMENT PLAN
SCHEDULE
NOTES

SHEET NUMBER

A-2

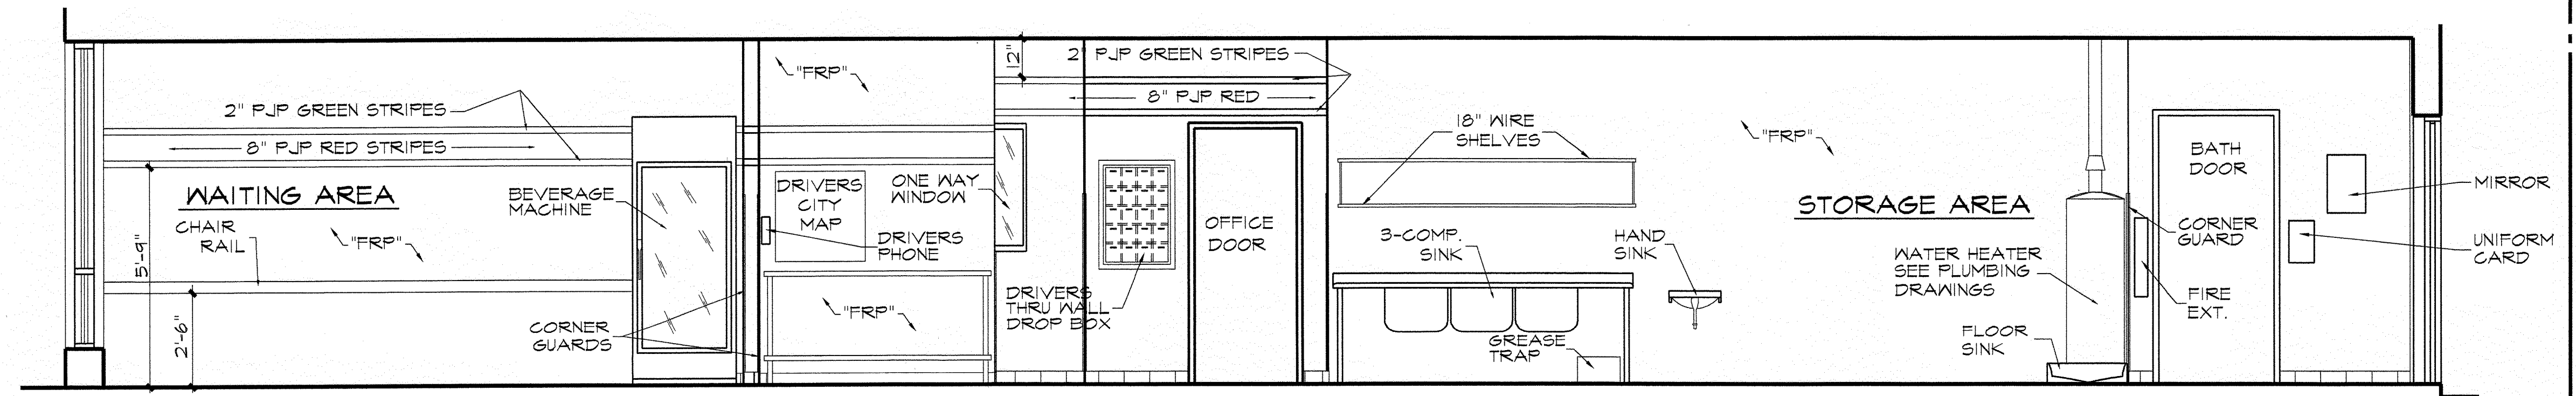

INTERIOR ELEVATION

SCALE : $\frac{3}{8}$ " = 1'-0"

INSTRUCTIONS FOR STRIPE INSTALLATION :

FOR STORES WITH CEILING OVER 9'-0", STRIPE IS TO START AT FRONT WALL 5'-4" A.F.F. STRIPE CONTINUES TO REAR OF STORE. AT A LOCATION OVER THE DOUGH SLAP, STRIPE IS TO BREAK AT A 45 DEGREE ANGLE TOWARDS THE CEILING. 12" BELOW CEILING, TOP OF STRIPE TO BREAK AT 45 DEGREE ANGLE TO REAR OF STORE. THE STRIPE ON OPPOSITE WALL FROM DOUGH SLAP SHOULD BREAK OVER THE OFFICE WINDOW, BUT MAY BREAK AT SOME OTHER POINT DUE TO STORE LAYOUT. BOTH SIDES OF STRIPE TO MEET BEHIND THE OVEN AT 12" BELOW CEILING.

FOR STORES WITH CEILING HEIGHTS BELOW 9'-0" THE STRIPE IS TO START AT 60" A.F.F. AND BREAK TO 6" BELOW CEILING.

STRIPE ARE TO BE FROM BOTTOM UP 2" OF GREEN, 8" OF RED, & 2" OF GREEN.

PAINT COLORS :

ALL PAINT MANUFACTURED BY SHERWIN WILLIAMS.
 WHITE : B33 W 201-200 OIL BASE EGGSHELL
 RED : B54R39 (SAFTY RED) + VIOLET 4/32 + BLUE 4/32
 GREEN : B54 T 104 + BLACK 11/32 + 1/64 + 1/128
 + BLUE 7/32 + 1/64
 + GREEN 6 oz. 25/32
 + WHITE 56/32


NOTE : SPECIAL GREEN TAPE MAY USED IN PLACE OF PAINT FOR STRIPE.

TAPE CAN BE ORDERD FROM UNITEX, INC. (MUST BE PAID BY CREDIT CARD WHEN ORDERING)

INDIANAPOLIS, IN. (800)-843-6236
 FLORIDA (954)-463-0890
 RHODE ISLAND (401)-946-6300
 CALIFORNIA (818)-962-6282


NOTE :

THIS SHEET IS FOR REFERENCE
 OF THE PAINTED STRIPE ONLY, IT IS
 NOT INTENDED TO PORTRAY ANY
 ONE FLOOR PLAN, IT IS A TYPICAL
 PLAN.

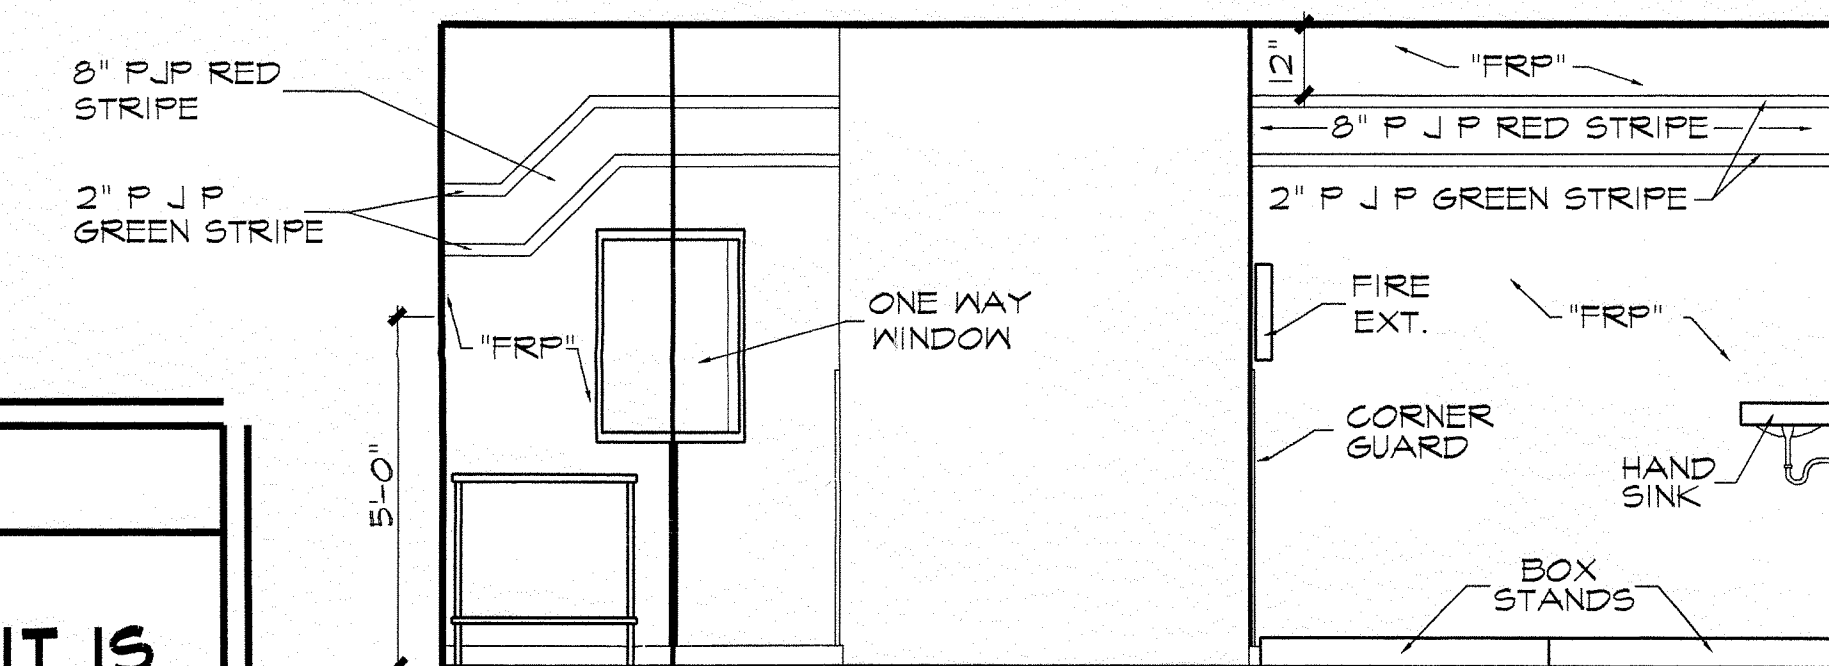

INTERIOR ELEVATION

SCALE : $\frac{3}{8}$ " = 1'-0"

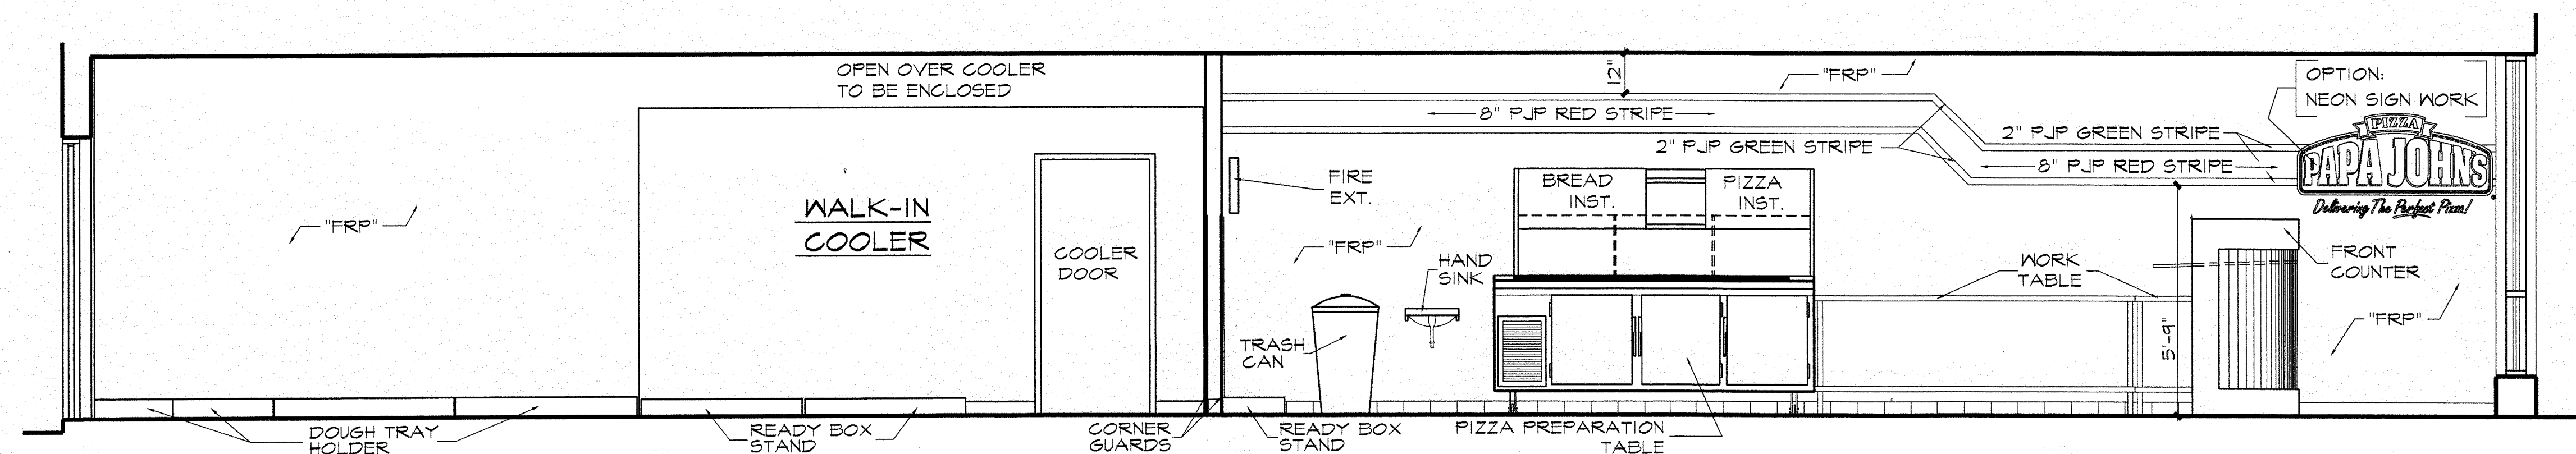

INTERIOR ELEVATION

SCALE : $\frac{3}{8}$ " = 1'-0"

NEW PAPA JOHN'S PIZZA STORE :

TYPICAL INTERIOR STRIPE
 INSTALLATION ELEVATION

COPYRIGHT © BAYUS-EVOLA ARCHITECTS
 1999 - ALL RIGHTS RESERVED

PROJECT NUMBER



PAPA JOHN'S INTERNATIONAL, INC.

11492 BLUEGRASS PARKWAY
 LOUISVILLE, KENTUCKY 40294



**BAYUS-
 EVOLA**

ARCHITECTS

SUITE 140
 661 SOUTH HURSTBOURNE LANE
 LOUISVILLE, KENTUCKY 40222
 (502) 426-8020

NEW PAPA JOHN'S PIZZA STORE :
 TYPICAL INTERIOR STRIPE
 INSTALLATION ELEVATION

DATE : 1/1/99


DATE REVISED

SHEET TITLE

INTERIOR ELEVATIONS


SHEET NUMBER

STR-1

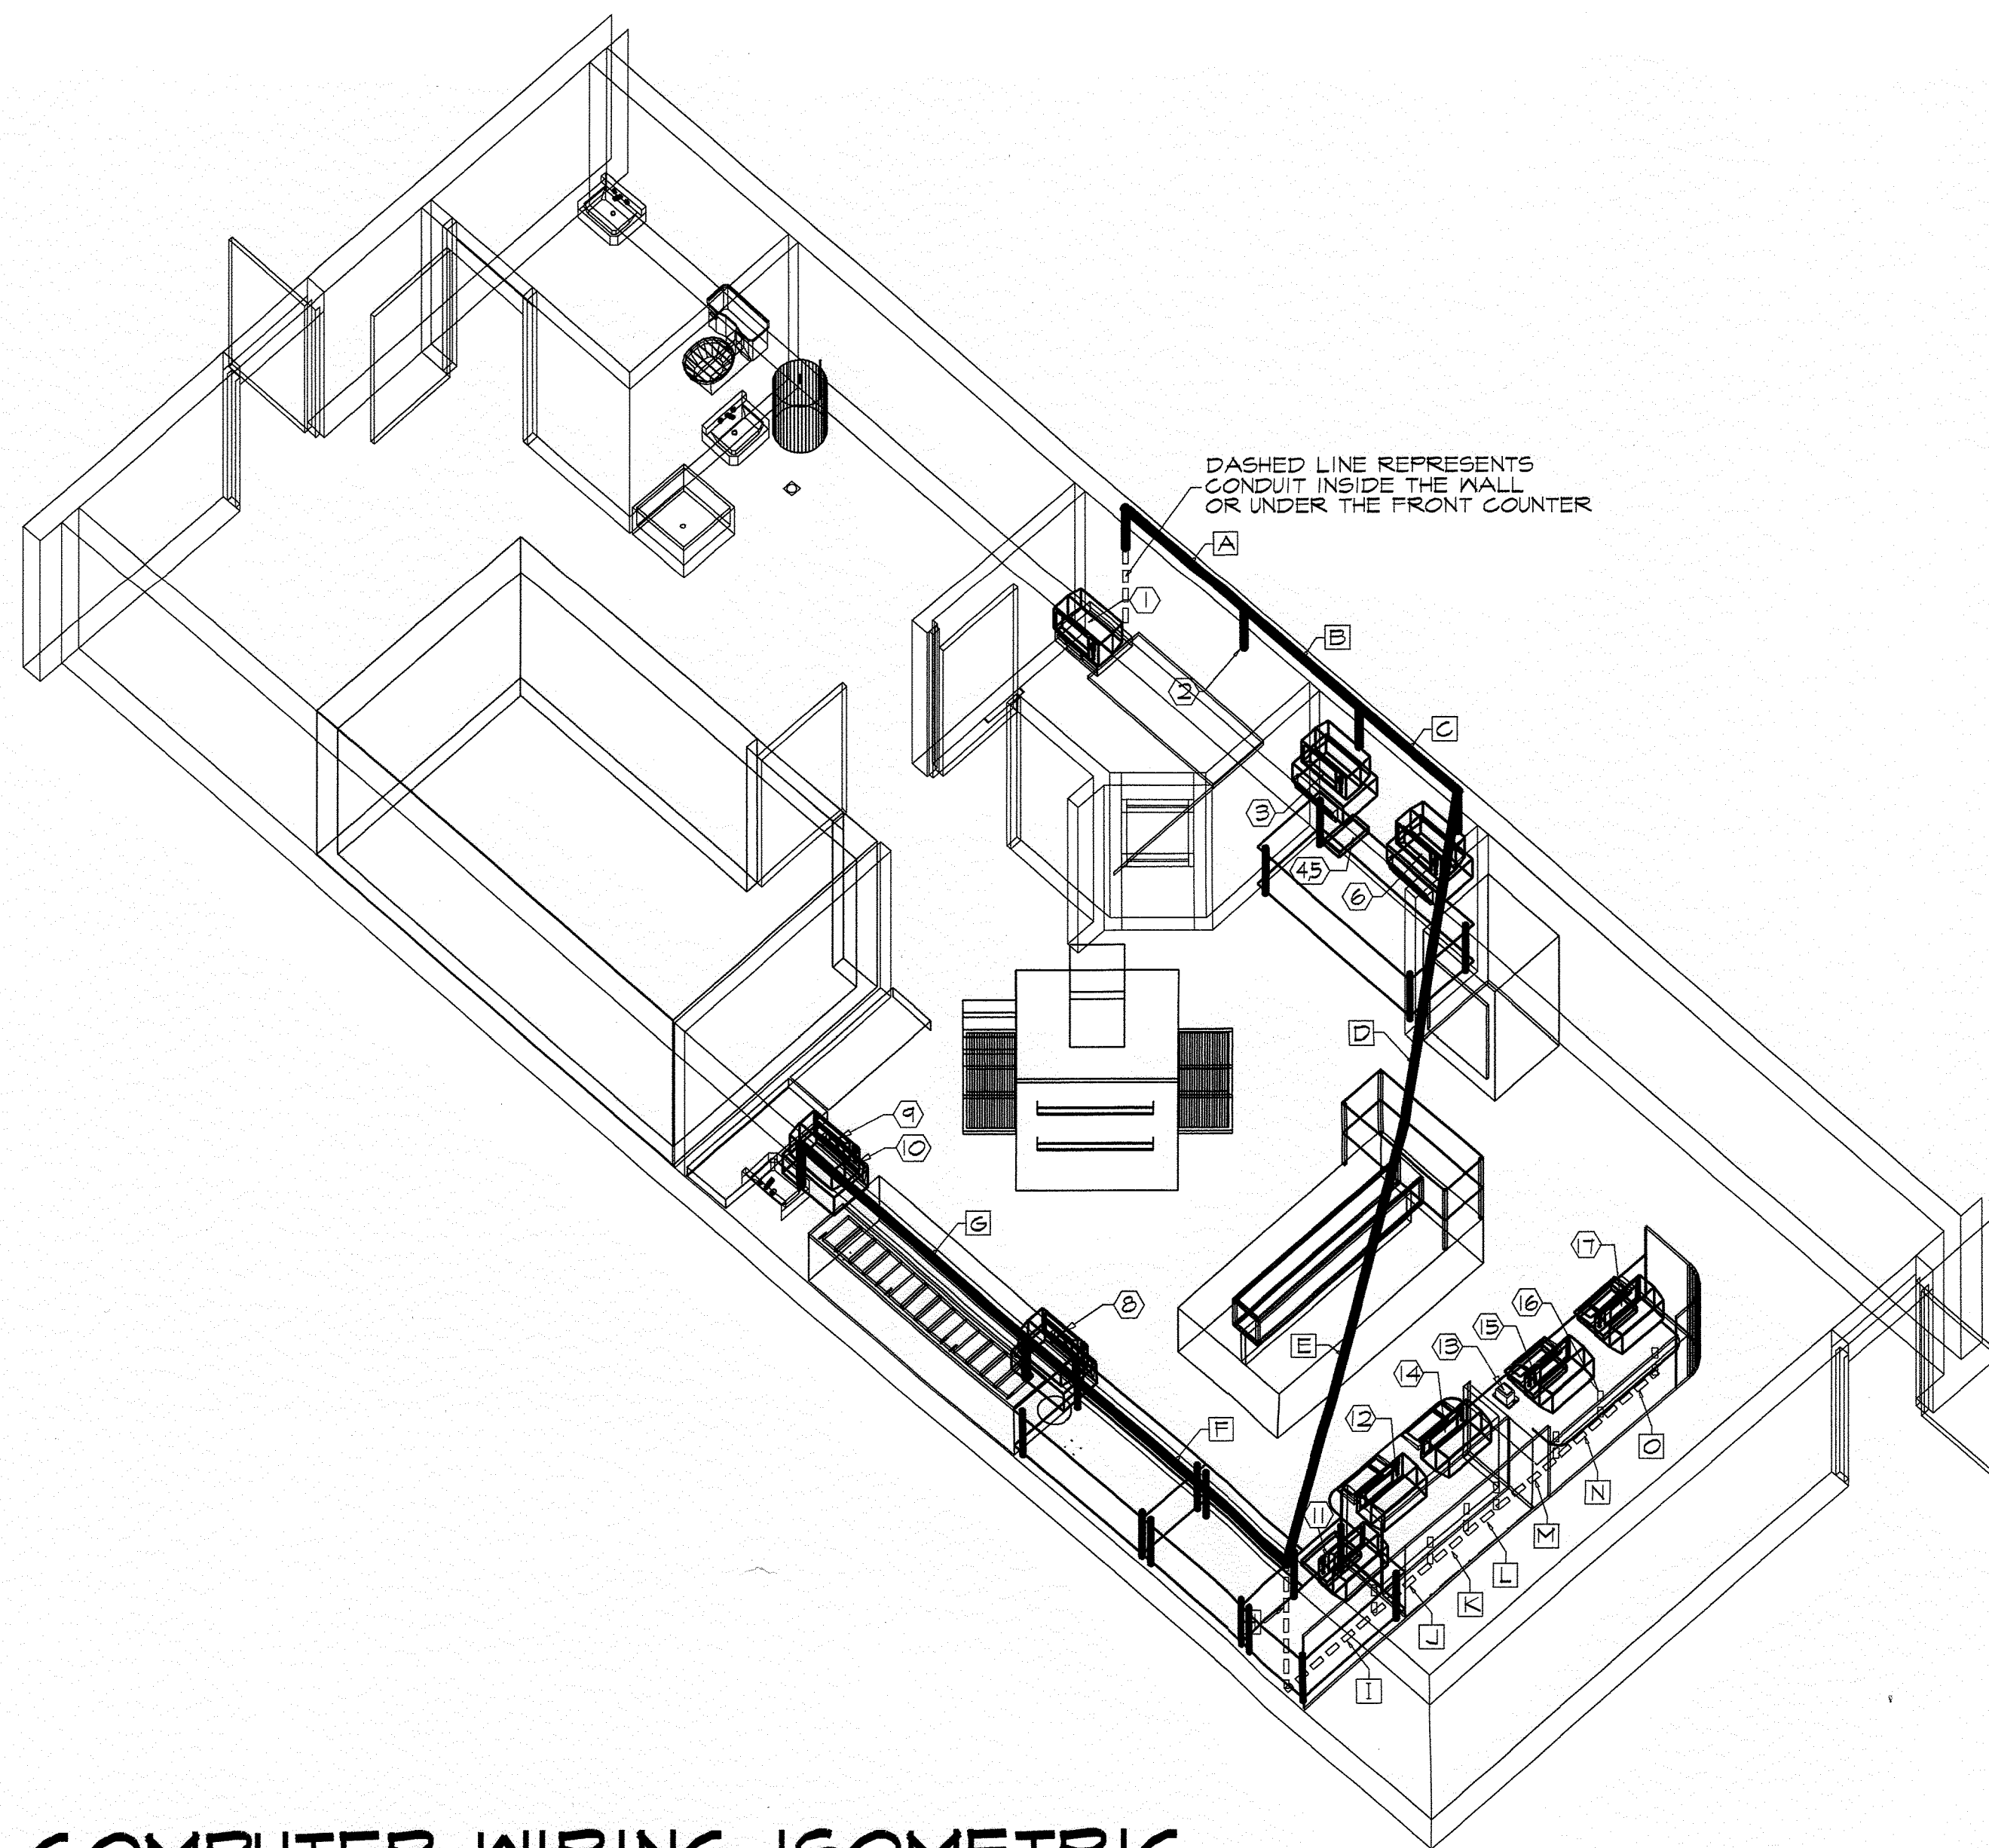


COMPUTER WIRING ISOMETRIC

SCALE : 1/4" = 1'-0"

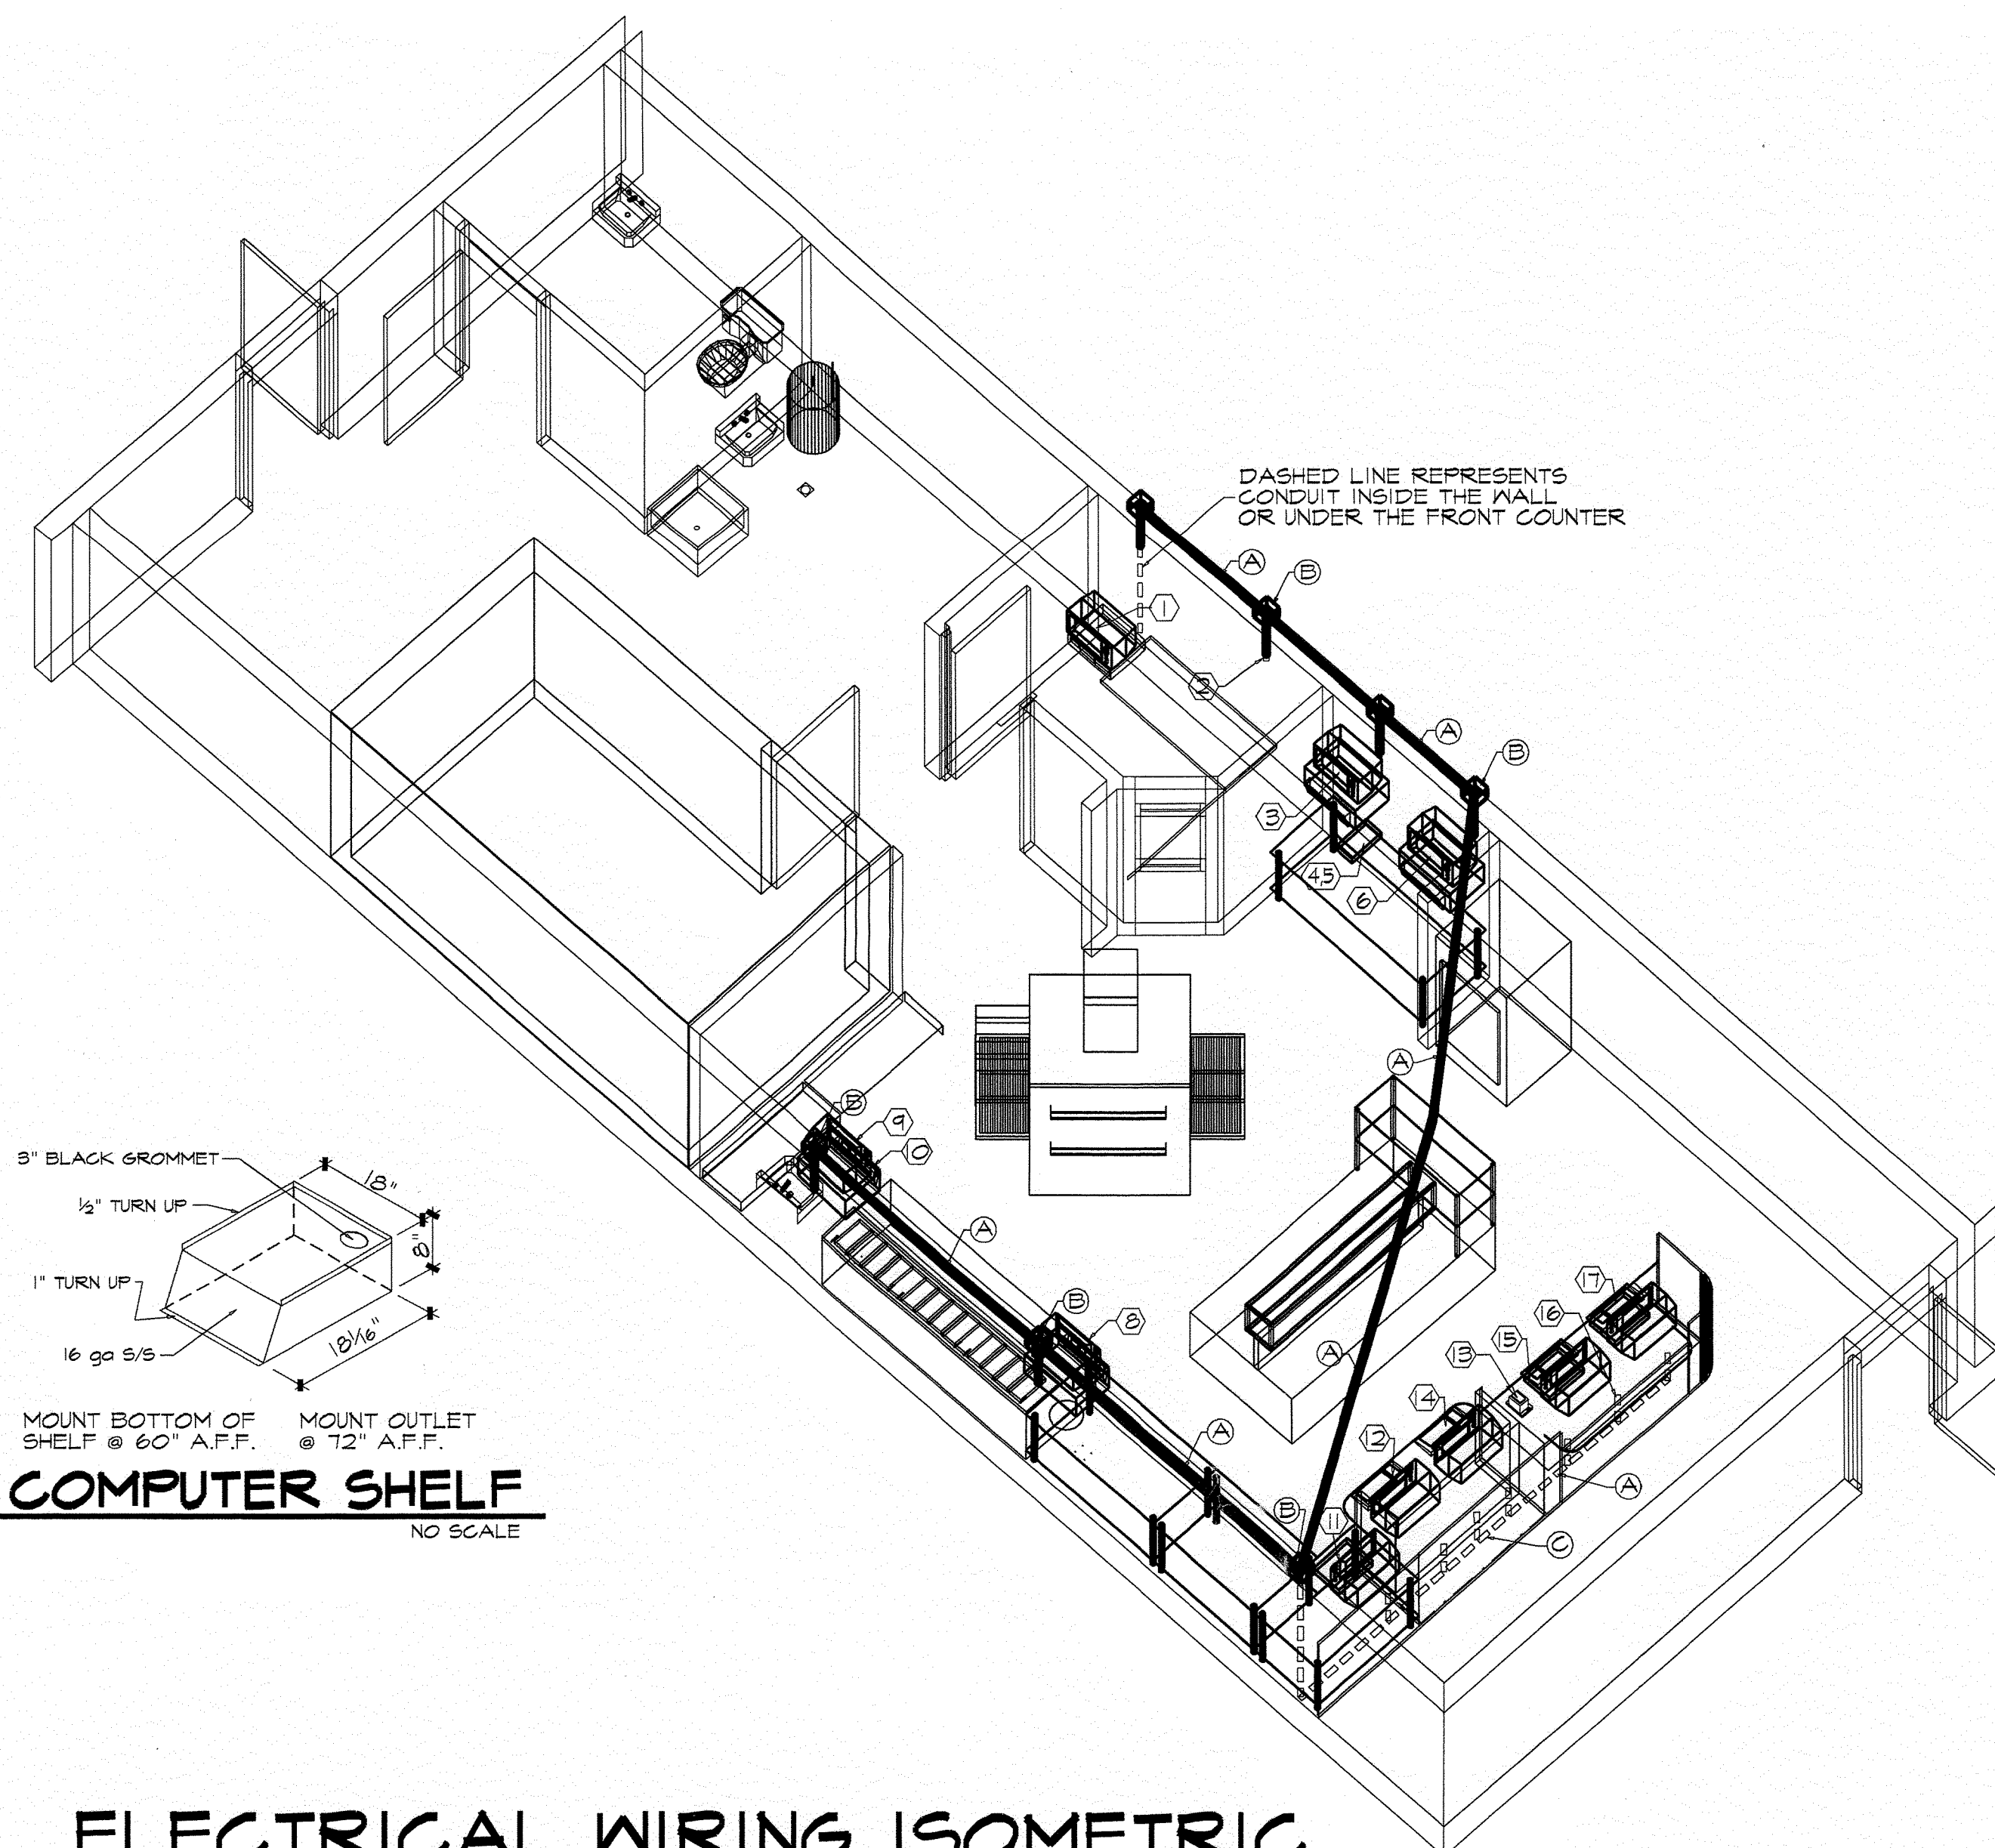

ELECTRICAL WIRING ISOMETRIC

SCALE : 1/4" = 1'-0"

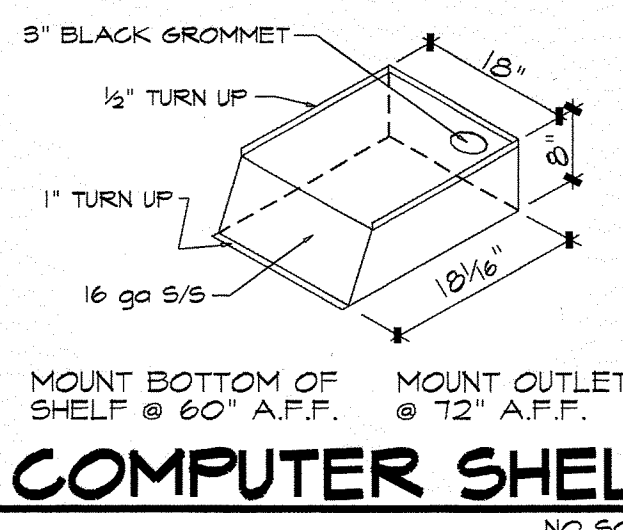

COMPUTER SHELF

NO SCALE

GENERAL COMPUTER NOTES

- EACH DEVICE IS CONNECTED TO THE OFFICE COMPUTER BY MEANS OF A "HOME RUN" OF SILVER SATIN, 6-CONDUCTOR FLAT TELEPHONE-TYPE CABLE.
- DEVICES ARE POLARITY SENSITIVE, PLEASE REFER TO THE PIN OUT SPECIFICATION WHICH ACCOMPANY EACH SPOOL OF CABLE AND SUPPLY OF RJ-12 MODULAR CONNECTORS.
- WIRES MUST BE NUMBERED (NUMBERS SUPPLIED WITH SPOOL) & RJ-12 CONNECTORS MUST BE INSTALLED ON EACH END AND CHECKED FOR CONTINUITY ON ALL 6 CONDUCTORS. DISCONTINUOUS RUNS MUST BE REPAIRED OR REPLACED. SPLICED RUNS ARE UNACCEPTABLE.
- ALL DATA CABLE IS TO BE RUN THROUGH 1/2" CONDUIT CONTINUOUS TO ITS DEVICE (ALONG WALLS, TABLES AND CEILING) INSTALL ELBOWS AT ALL TURNS. (CONDUIT MAY DOWNSIZE TO 3/4" AS WIRES DROP OUT)
- ALL SILVER SATIN CABLE IS TO RUN CONTINUOUSLY FROM THE OFFICE TO THE DEVICE THROUGH 1/2" P.V.C. PIPE.
- ELECTRICAL CONTRACTOR WILL SUPPLY THE SILVER SATIN CABLE, SIX CONDUCTOR, FLAT, GRAY BAR PART #D6BUCU 28 S.S. (502) 469-2971
- THE ELECTRICAL CONTRACTOR IS TO SUPPLY AND INSTALL THE CONDUIT AND PULL THE SILVER SATIN CABLE CONTINUOUSLY TO EACH DEVICE LOCATION. SIX FEET OF CABLE MUST BE EXPOSED AT EACH ENDING POINT.
- ALL CONDUIT IS TO BE RUN INSIDE OF WALLS AND ALONG THE TABLE SHELVES. WHERE CONDUIT CAN'T BE RUN INSIDE WALLS IT MUST BE PAINTED TO MATCH WALL COLORS.
- IF DATA CABLE "HOME RUNS" ARE CONTAINED WITHIN THE WALL, IT IS SUGGESTED THAT THEY EXIT THE WALL THROUGH A J-BOX, AT APPROXIMATELY THE SAME HEIGHT AS THE 110V DEDICATED LINE OUTLET, BUT AT LEAST ONE FOOT HORIZONTALLY FROM THAT OUTLET. SIX FEET OF WIRE LENGTH FOR EACH CABLE MUST PROTRUDE FROM THE J-BOX.

- ALL DEVICE OUTLETS MUST BE WIRED TO A DEDICATED, ISOLATED GROUND CIRCUIT. THESE OUTLETS SHOULD BE IDENTIFIED WITH STANDARD 3- PRONG GROUNDED, ORANGE DUAL-GANG (TWO OUTLET) WALL RECEPTICLE. ONE DUAL-GANG OUTLET PER DEVICE (I.E. ONE FOR EACH MONITOR OR PRINTER) THE OUTLET FOR THE OFFICE NEEDS ONLY ONE DUAL-GANG OUTLET, AS THE ACTUAL EQUIPMENT WILL BE CONNECTED TO AN UNINTERRUPTIBLE POWER SUPPLY (UPS) AND SURGE PROTECTED POWER STRIP.
- 110V OUTLETS SHOULD BE MOUNTED JUST UNDER THE MONITOR SHELVES OR UNDER THE TABLES AND PHONE COUNTER.
- INSTALLATIONS THAT HAVE THE STRIP PRINTER INSTALL ON A CENTER ISLAND STYLE CUT TABLE, THE OUTLET WILL BE MOUNTED FLUSH IN THE CEILING.
- INSTALLATIONS THAT HAVE THE MAKE TABLE PRODUCTION MONITOR WALL MOUNTED THE MIDDLE OF THE MONITOR WILL BE 660" A.F.F.
- THIS PROJECT SHOULD TAKE ABOUT 8 HRS. INCLUDING INSTALLATION OF THE DEDICATED ELECTRICAL CIRCUIT. IF THERE ARE ANY QUESTIONS PLEASE CALL THE STORE SYSTEMS HELP LINE 1-800-755-1907
- INSTALL FLYWOOD BACKING BEHIND MONITOR SHELF

PIPE WIRE RUNS

- A WIRES 2, 3, 4, 5, 6, 8, 9, 10, 11, 12, 13, 14, 15, 16, 17 WILL RUN THROUGH "A"
- B WIRES 3, 4, 5, 6, 8, 9, 10, 11, 12, 13, 14, 15, 16, 17 WILL RUN THROUGH "B"
- C WIRES 6, 8, 9, 10, 11, 12, 13, 14, 15, 16, 17 WILL RUN THROUGH "C"
- D WIRES 8, 9, 10, 11, 12, 13, 14, 15, 16, 17 WILL RUN THROUGH "D"
- E WIRES 8, 9, 10, 11, 12, 13, 14, 15, 16, 17 WILL RUN THROUGH "E"
- F WIRES 8, 9, 10 WILL RUN THROUGH "F"
- G WIRE 9, 10 WILL RUN THROUGH "G"
- H WIRES 11, 12, 13, 14, 15, 16, 17 WILL RUN THROUGH "H"
- I WIRES 11, 12, 13, 14, 15, 16, 17 WILL RUN THROUGH "I"
- J WIRES 12, 13, 14, 15, 16, 17 WILL RUN THROUGH "J"
- K WIRES 13, 14, 15, 16, 17 WILL RUN THROUGH "K"
- L WIRES 14, 15, 16, 17 WILL RUN THROUGH "L"
- M WIRES 15, 16, 17 WILL RUN THROUGH "M"
- N WIRES 16, 17 WILL RUN THROUGH "N"
- O WIRE 17 WILL RUN THROUGH "O"

WIRE LEGEND

- 1 MAIN STORE COMPUTER SYSTEM
- 2 FUTURE OFFICE STATION
- 3 DRIVER STATION SYSTEM #1
- 4 STAR PRINTER
- 5 STAR PRINTER
- 6 DRIVERS STATION SYSTEM #2
- 7 NOT USED
- 8 MIRROR MAKE LINE
- 9 MAKE LINE
- 10 SPLIT MAKE LINE
- 11 OPTIONAL 5TH FRONT COUNTER UNIT
- 12 PHONE COUNTER SYSTEM #1
- 13 FRONT COUNTER PRINTER
- 14 PHONE COUNTER SYSTEM #2
- 15 CUSTOMER COUNTER SYSTEM #1
- 16 CASH DRAWER CABLE
- 17 CUSTOMER COUNTER SYSTEM #2


NOTES :

- A 1/2" CONDUIT BY ELEC. CONTRACTOR. CONDUIT MAY DROP IN SIZE AS WIRES DROP OUT.
 - B J-BOX ABOVE CEILING
 - C ELEC. TO FRONT COUNTER
 - D ELEC. TO CUT TABLE PRINTERS, SEE NOTE 13 OF GENERAL NOTES.
- NOTE :
COMPUTER SYSTEM IS TO RUN BACK TO ELEC. PANEL. SYSTEMS NUMBER 1, 2, 3, 4, 5, 6, 7, 8, 9, 10. TO BE ON A SEPERATE 20 AMP CIRCUIT. SYSTEMS NUMBER 11, 12, 13, 14, 15, 16, 17 TO BE ON A 20 AMP CIRCUIT.

PJP #
94-000000


NEW PAPA JOHN'S PIZZA STORE :
IDEAL COMPUTER PAGE

COPYRIGHT © PAPA JOHN'S INTERNATIONAL, INC.
COPYRIGHT © BAYUS - EVOLA ARCHITECTS
1995 - ALL RIGHTS RESERVED

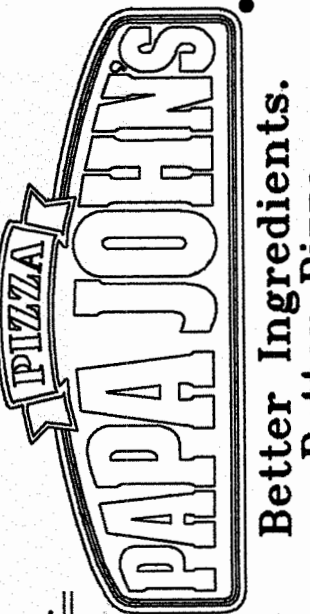

PAPA JOHN'S INTERNATIONAL, INC.

11492 BLUEGRASS PARKWAY
LOUISVILLE, KENTUCKY 40294

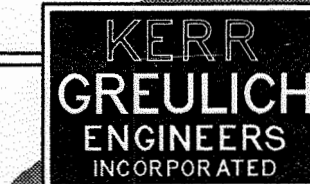

KERR - GREULICH
ENGINEERS, INC.
1534 ORMSBY STATION CT.
LOUISVILLE, KY 40223
PHONE (502) 426-9457
FAX (502) 426-2945

NEW PAPA JOHN'S PIZZA STORE :

6200 W. PARKER RD.
PLANO TX.

DATE: 2/15/99

DATE REVISED

SHEET TITLE

WATER & GAS PIPING
SOIL, WASTE, & VENT
SCHEDULE
NOTES

SHEET NUMBER

GREASE TRAP CALCULATION USING ASPE FORMAT.

GIVEN - GREASE FOR RESTAURANT IS LIMITED TO THE CLEANING OF CONTAINERS THAT HOLD REFRIGERATED PEPPERONI, SAUSAGE PIECES, CHEESE & VEGETABLE OILS. ALL OF THE ARTICLES ARE OF SMALL SIZE & TRACE QUANTITIES. THERE IS ONE THREE COMPARTMENT SINK, EACH SINK BASIN IS 16" X 20" X 14". THIS IS A GROSS VOLUME 58.1 GALLONS. THERE IS ONE MOP SINK. THE BASIN IS 24"x24"x10". THIS IS A GROSS VOLUME 24.9 GALLONS.

CALCULATION :
1. - DRAINAGE LOAD = 58.1 GALLON @ 60% FULL FOR 3CS. (THIS INCLUDES UTENSIL DISPLACEMENT) = 34.9 GAL
DRAINAGE LOAD= 24.9 GALLOS @ 60% FULL FOR MOP SINK.
2. - FLOW RATE = 34.9 GAL + 14.9 GAL = 49.8 GPM
2 MIN. DISCHARGE MAX FLOW = 24.9
3. - GREASE TRAP = $V = \frac{QP}{V} = \frac{(49.8)(1)}{7.48} = 6.66^3\text{FT.}$


PLUMBING FIXTURE SCHEDULE

(BY PLUMBING CONTRACTOR)

FIXTURE	DESCRIPTION
WATER CLOSET - "C"	AMERICAN STANDARD 2216.143 17" HIGH FOR HANDICAPPED WITH TANK LINER AND CHURCH 9500 OPEN FRONT ELONGATED WHITE SEAT LESS LID.
LAVATORY - "L"	AMERICAN STANDARD #4300.117 "LEDGEMERE" W/ WALL CARRIER AND HERMITAGE FAUCET AND POP-UP DRAIN, MOUNT AT HANDICAP HEIGHT.
HAND SINK - "L-1"	15 1/2" X 16 1/2" STAINLESS STEEL HANDSINK PROVIDED BY A.S.I.
MOP SINK - "MS"	FIAT MSB 2424 FIBERGLASS BASIN W/830-AA FAUCET W/ VACUUM BREAKER AND 889- CC. MOP HANGER.
THREE COMPARTMENT SINK - "3CS"	24" X 94" STAINLESS STEEL W/ 3- 16"x20"x14" DEEP SINKS AND DOUBLE DRAIN BOARDS- CUSTOM FABRICATED. PROVIDED BY A.S.I.
FLOOR DRAIN - "FD"	3" ZURN # ZN-415 PROVIDE TRAP PRIMER.
GREASE INTERCEPTOR - "GT"	EQUAL TO A ZURN MODEL Z-1170 SIZE 700 RATED AT 35 GPM, 70LB. GREASE CAPACITY WITH EXTERNAL AIR RELIEF BYPASS. BRONZE CLEANOUT PLUG WITH VISIBLE DOUBLE WALL TRAP SEAL. REMOVABLE PRESSURE EQUALIZING/FLOW DIFFUSING BAFFLE AND SEDIMENT CONTAINER. UNIT TO BE RECESSED IN FLOOR AND SET FLUSH WITH FINISHED FLOOR UNLESS NOTED OTHERWISE WITH 4" INLET AND OUTLET.
WATER HEATER - "WH"	A.O. SMITH F50T-50 W/ DRAFT DIVERTER. PRESSURE RELIEF AND OTHER ACCESSORIES. 48 GAL. CAP. 61.4 GAL. REC./HR. @ 90° RISE. 60,000 BTU/H.
FLOOR SINK - "FS"	EQUAL TO ZURN MODEL Z-1900-3
BACKFLOW PREVENTER	EQUAL TO WATTS NO. 0090T; CONFIRM MODEL # IS APPROVED BY LOCAL AUTHORITY PRIOR TO INSTALLATION.


PLUMBING GENERAL NOTES

- A. PLUMBING CONTRACTOR IS TO FURNISH AND INSTALL ALL PLUMBING FIXTURES COMPLETE AS LISTED IN "PLUMBING FIXTURE SCHEDULE".
- B. PLUMBING CONTRACTOR MAY USE SCHEDULE 40 OR 80 TYPE 1, GRADE 1, POLYVINYL CHLORIDE PIPE FOR ALL SOIL, WASTE AND VENT PIPING WHERE PERMITTED BY LOCAL CODES. WHERE PVC PIPING IS NOT PERMITTED BY LOCAL CODES, USE STANDARD WEIGHT CAST IRON PIPING. ALL PIPING ABOVE GRADE MAY HAVE HUBLESS FITTINGS. PLASTIC PIPING SHALL NOT BE USED IN A RETURN AIR PLENUM. COORDINATE THIS REQUIREMENT WITH H.V.A.C. CONTRACTOR. PRIOR TO INSTALLATION.
- C. PROVIDE SHUT-OFF GATE VALVES ON ALL EQUIPMENT AND STOP COCKS IN HOT AND COLD WATER PIPING TO ALL PLUMBING FIXTURES.
- D. ALL WATER PIPING BELOW GRADE SHALL BE TYPE "1" SOFT TEMPERED COPPER AND ALL WATER PIPING ABOVE GRADE SHALL BE TYPE "L" HARD TEMPERED COPPER.
- E. INSTALL 1" FOAM RUBBER INSULATION ON ALL HOT AND COLD WATER PIPING BELOW AND ABOVE GRADE. ALL JOINTS IN INSULATION ARE TO BE TAPED.
- F. ELEVATION OF ALL FLOOR DRAINS SHALL BE HELD 1/2" BELOW FINISH FLOOR TILE.
- G. PROVIDE ALL GAS PIPING COMPLETE WITH ALL REQUIRED FITTINGS, STRAPS, HANGERS, SUPPORTS, ETC. OBTAIN ALL REQUIRED INSPECTIONS AND APPROVALS. ALL GAS PIPING SHALL BE SCHEDULE 40 BLACK IRON AND SHALL BE INSTALLED IN ACCORDANCE WITH THE LATEST EDITION OF NFPA AND ANY APPLICABLE STATE OR LOCAL CODES OR REGULATIONS.
- H. PAINT ALL GAS PIPING EXPOSED TO WEATHER WITH (2) COATS OF "RUSTOLEUM" OR EQUAL PAINT, COLOR TO BE SELECTED BY ARCHITECT OR GENERAL CONTRACTOR.
- I. CONTRACTOR SHALL COORDINATE INSTALLATION OF GAS METER WITH LOCAL GAS CO. REQUIREMENTS PRIOR TO INSTALLATION.
- J. CONTRACTOR SHALL FIELD VERIFY INVERT ELEVATIONS OF ALL NEW AND EXISTING SANITARY SEWERS PRIOR TO ROUGH-IN.
- K. PLUMBING CONTRACTOR TO MAKE FINAL CONNECTION TO ALL GAS-FIRED EQUIPMENT PROVIDE GAS SHUT-OFF VALVE AND DIRT LEG AT EACH CONNECTION.
- L. ALL CLEANOUTS SHALL BE INSTALLED FLUSH WITH FINISHED GRADE/ FINISHED FLOORS.
- M. ALL PLUMBING HOSE BIBBS OR VALVES WITH THREADED CONNECTIONS SHALL BE PROVIDED WITH VACUUM BREAKERS AND APPROVED MEANS OF BACKFLOW PREVENTION AS REQUIRED BY STATE AND LOCAL CODES.
- N. ALL HANDICAP PLUMBING FIXTURES SHALL BE INSTALLED TO COMPLY WITH STATE AND LOCAL CODES.
- O. HOLD ALL PLUMBING VENTS A MINIMUM OF 10'-0" FROM OUTSIDE AIR INTAKES ON HVAC EQUIPMENT. COORDINATE LOCATION WITH MECHANICAL CONTRACTOR.
- P. WHERE A RENOVATION IS TO OCCUR: THE PLUMBING CONTRACTOR SHALL VISIT THE SITE TO DETERMINE THE EXTENT OF DEMOLITION REQUIRED. THIS SHALL BE DONE PRIOR TO SUBMITTING BID.
- Q. PLUMBING CONTRACTOR SHALL PROVIDE AS-BUILT DRAWINGS TO THE GENERAL CONTRACTOR PRIOR TO FINAL PAYMENT.
- R. ALL DOMESTIC WATER PIPING SHALL BE DISINFECTED PRIOR TO USE BY BUILDING OCCUPANT. PLUMBING CONTRACTOR SHALL DISINFECT PER REQMTS OF LOCAL HEALTH DEPT., STATE AND LOCAL PLBG. CODE.
- S. PLUMBING CONTRACTOR SHALL PROVIDE DI-ELECTRIC UNIONS AT ALL PIPING CONNECTIONS WHERE DISSIMILAR PIPING IS JOINED.
- T. ALL GAS PIPING SHALL BE STANDARD WEIGHT SCHEDULE 40 BLACK STEEL PIPE. PIPE SHALL BE THREADED OR WELDED AS DIRECTED BY LOCAL GAS CO. AND STATE/LOCAL PLBG. CODES.
- U. ALL GAS PIPING, WHERE ROUTED ON ROOF: SHALL BE SUPPORTED BY 4"x4" TREATED WOOD BLOCKING 10'-0" O.C.. PROVIDE PIPE CLAMPS ON WOOD BLOCKING TO SECURE PIPING.
- V. ALL WORK SHALL BE INSTALLED TO COMPLY WITH LOCAL AND STATE PLBG. CODE REQUIREMENTS, AND PER LOCAL HEALTH DEPARTMENT REQUIREMENTS.

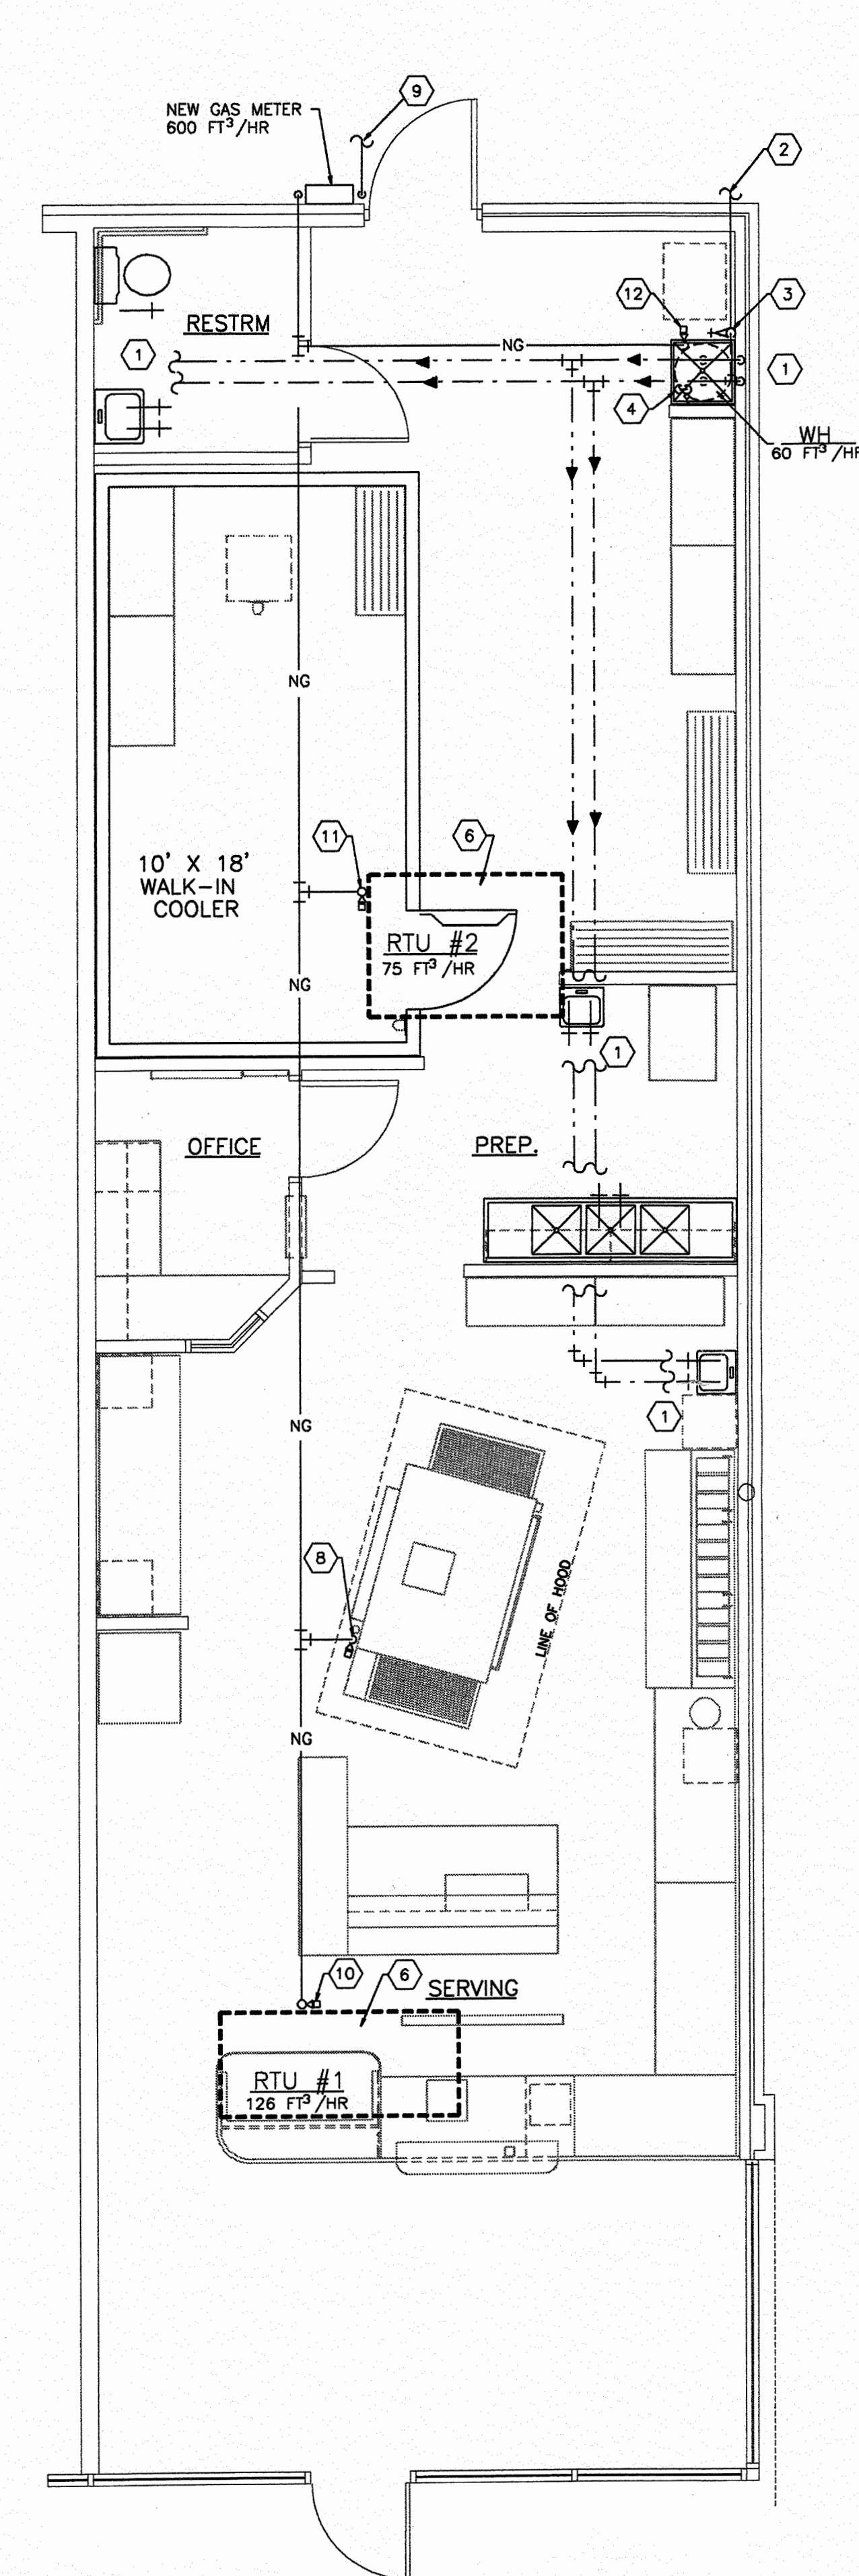

WATER AND GAS PIPING PLAN

SCALE : 1/4" = 1'-0"

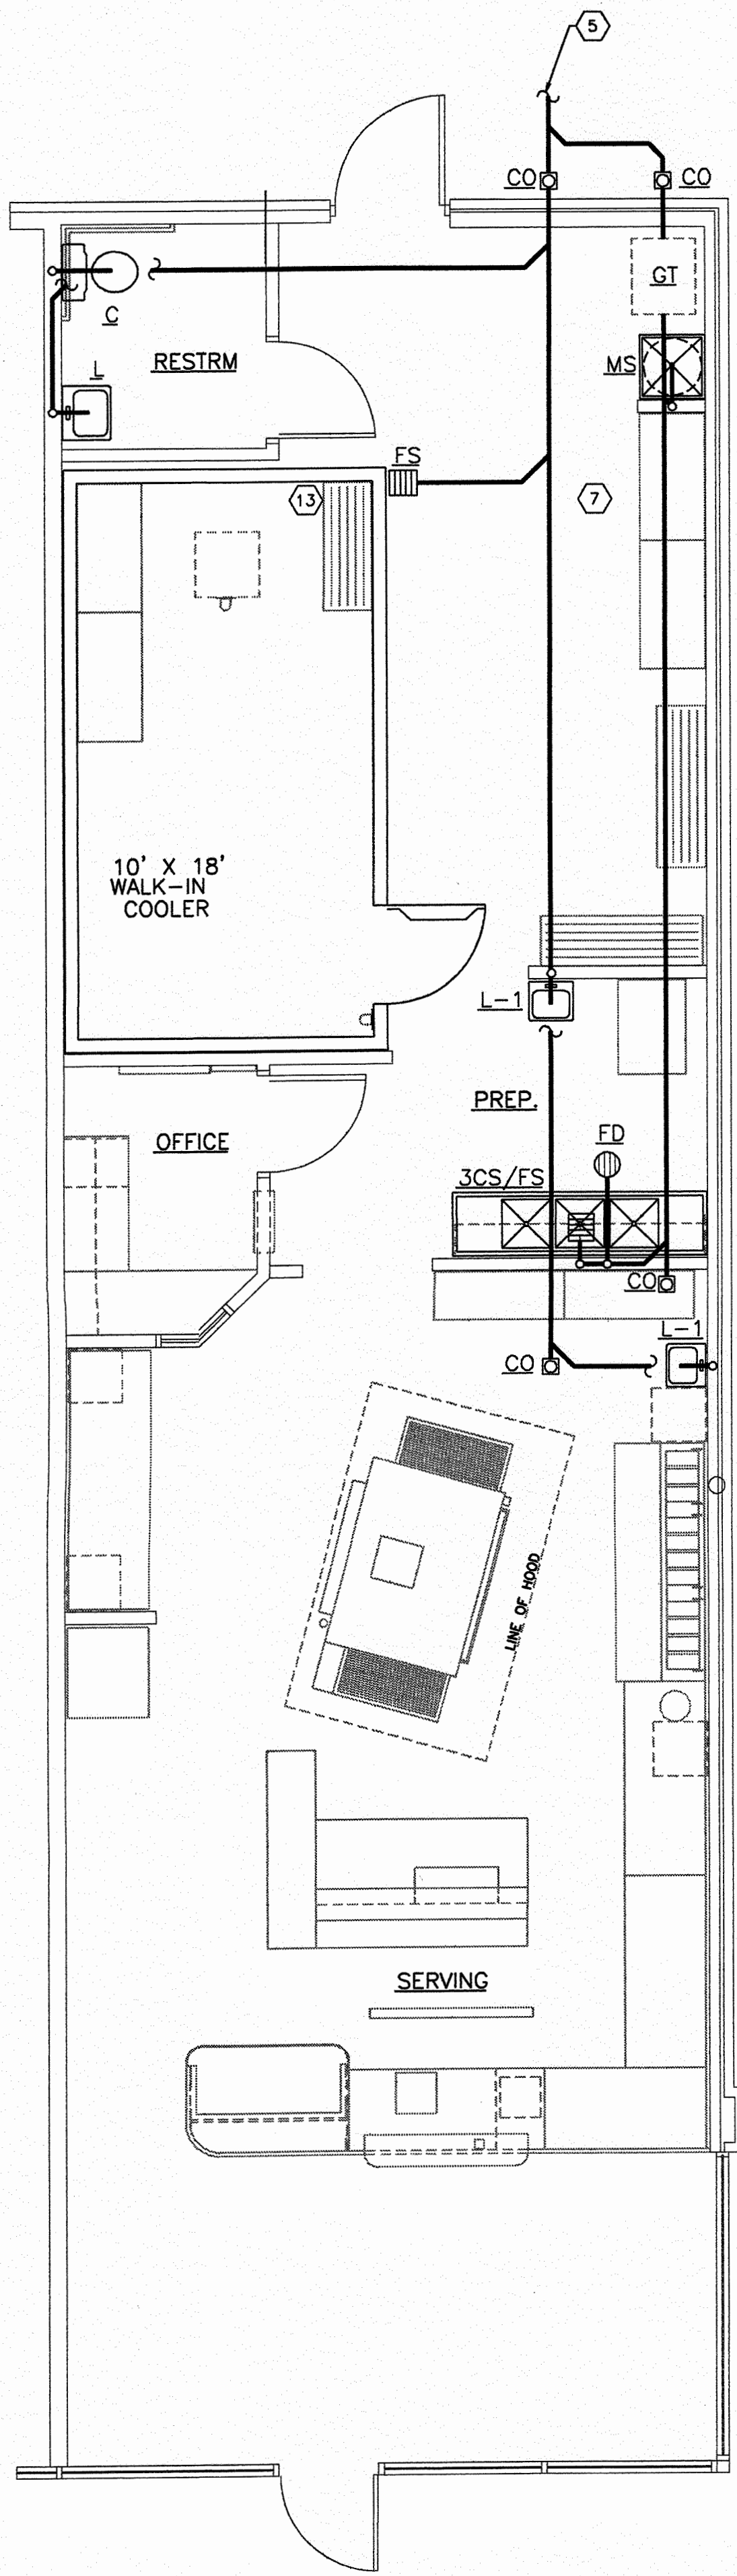

SANITARY PLAN

SCALE : 1/4" = 1'-0"


PLUMBING KEY NOTES

1. HW/CW TO FIXTURE AND CONNECT. REFERENCE WATER RISER DIAGRAM FOR PIPE SIZES.
2. 1" WATER LINE OUT TO EXISTING AND CONNECT.
3. NEW MAIN COLD WATER SHUT-OFF AND BACKFLOW PREVENTER.
4. T & P RELIEF VALVE AND DRAIN LINE. EXTEND DRAIN LINE TO MOP SINK AND SPILL.
5. CONNECT NEW WASTE TO EXISTING. FIELD VERIFY LOCATION PRIOR TO ROUGH-IN.
6. ROOFTOP HVAC UNIT BY M.C. ; FINAL GAS CONNECTION BY P.C.
7. REFERENCE RISER DIAGRAMS FOR WATER AND WASTE PIPE SIZES.
8. DROP 2" GAS LINE TO (2) PIZZA OVENS. 135 MBH EACH FOR P2360 OVENS OR 170 MBH EACH FOR P5570 OVENS.
9. NEW GAS LINE OUT TO EXISTING AND CONNECT. FIELD VERIFY LOCATION. COORDINATE PRESSURE AVAILABLE WITH LOCAL GAS CO. MINIMUM GAS METER SIZE SHALL BE 600 CUBIC FEET PER HOUR.
10. 1" NG UP TO RTU #1 AND CONNECT. PROVIDE SHUT-OFF VALVE AND DIRT LEG.
11. 1" NG UP TO RTU #2 AND CONNECT. PROVIDE SHUT-OFF VALVE AND DIRT LEG.
12. 3/4" NG TO WATER HEATER AND CONNECT; PROVIDE SHUT-OFF VALVE AND DIRT LEG.
13. EXTEND CONDENSATE DRAIN FROM COOLER TO FLOOR SINK AND SPILL. COORDINATE LOCATION OF DRAIN CONNECTION WITH COOLER SUPPLIER.

PJP #
99-1093



NEW STORE LOCATION
6200 W. PARKER RD.
PLANO TX.

COPYRIGHT © PAPA JOHN'S INTERNATIONAL, INC.
1999 - ALL RIGHTS RESERVED

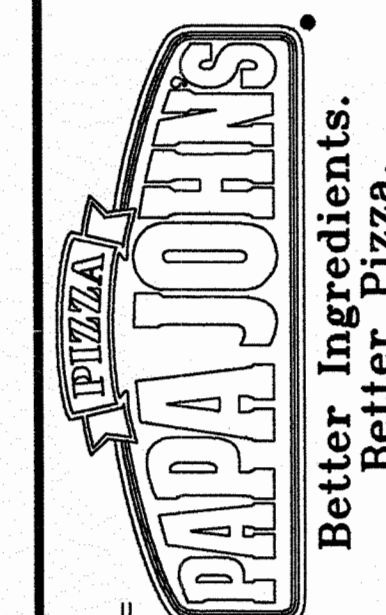

PAPA JOHN'S INTERNATIONAL, INC.

1492 BLUEGRASS PARKWAY
QUINCY KY 40299

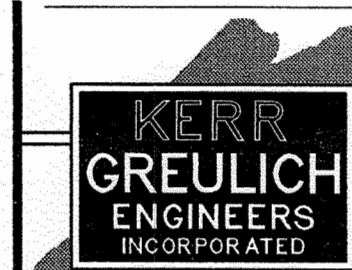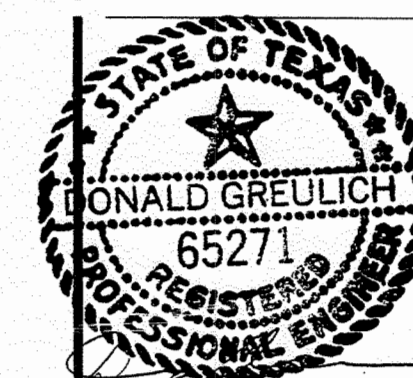

**KERR - GREULICH
ENGINEERS, INC.**
1534 ORMSBY STATION C
LOUISVILLE, KY 40223
PHONE:(502)426-9457
FAX:(502)426-2945

NEW PAPA JOHN'S PIZZA STORE :
6200 W. PARKER RD.
PLANO TX.

DATE: 2/15/99





DATE REVISED _____

■ SHEET TITLE

WATER & GAS PIPING
SOIL, WASTE, & VENT
SCHEDULE
NOTES

SHEET NUMBER


P-2
OF: 2

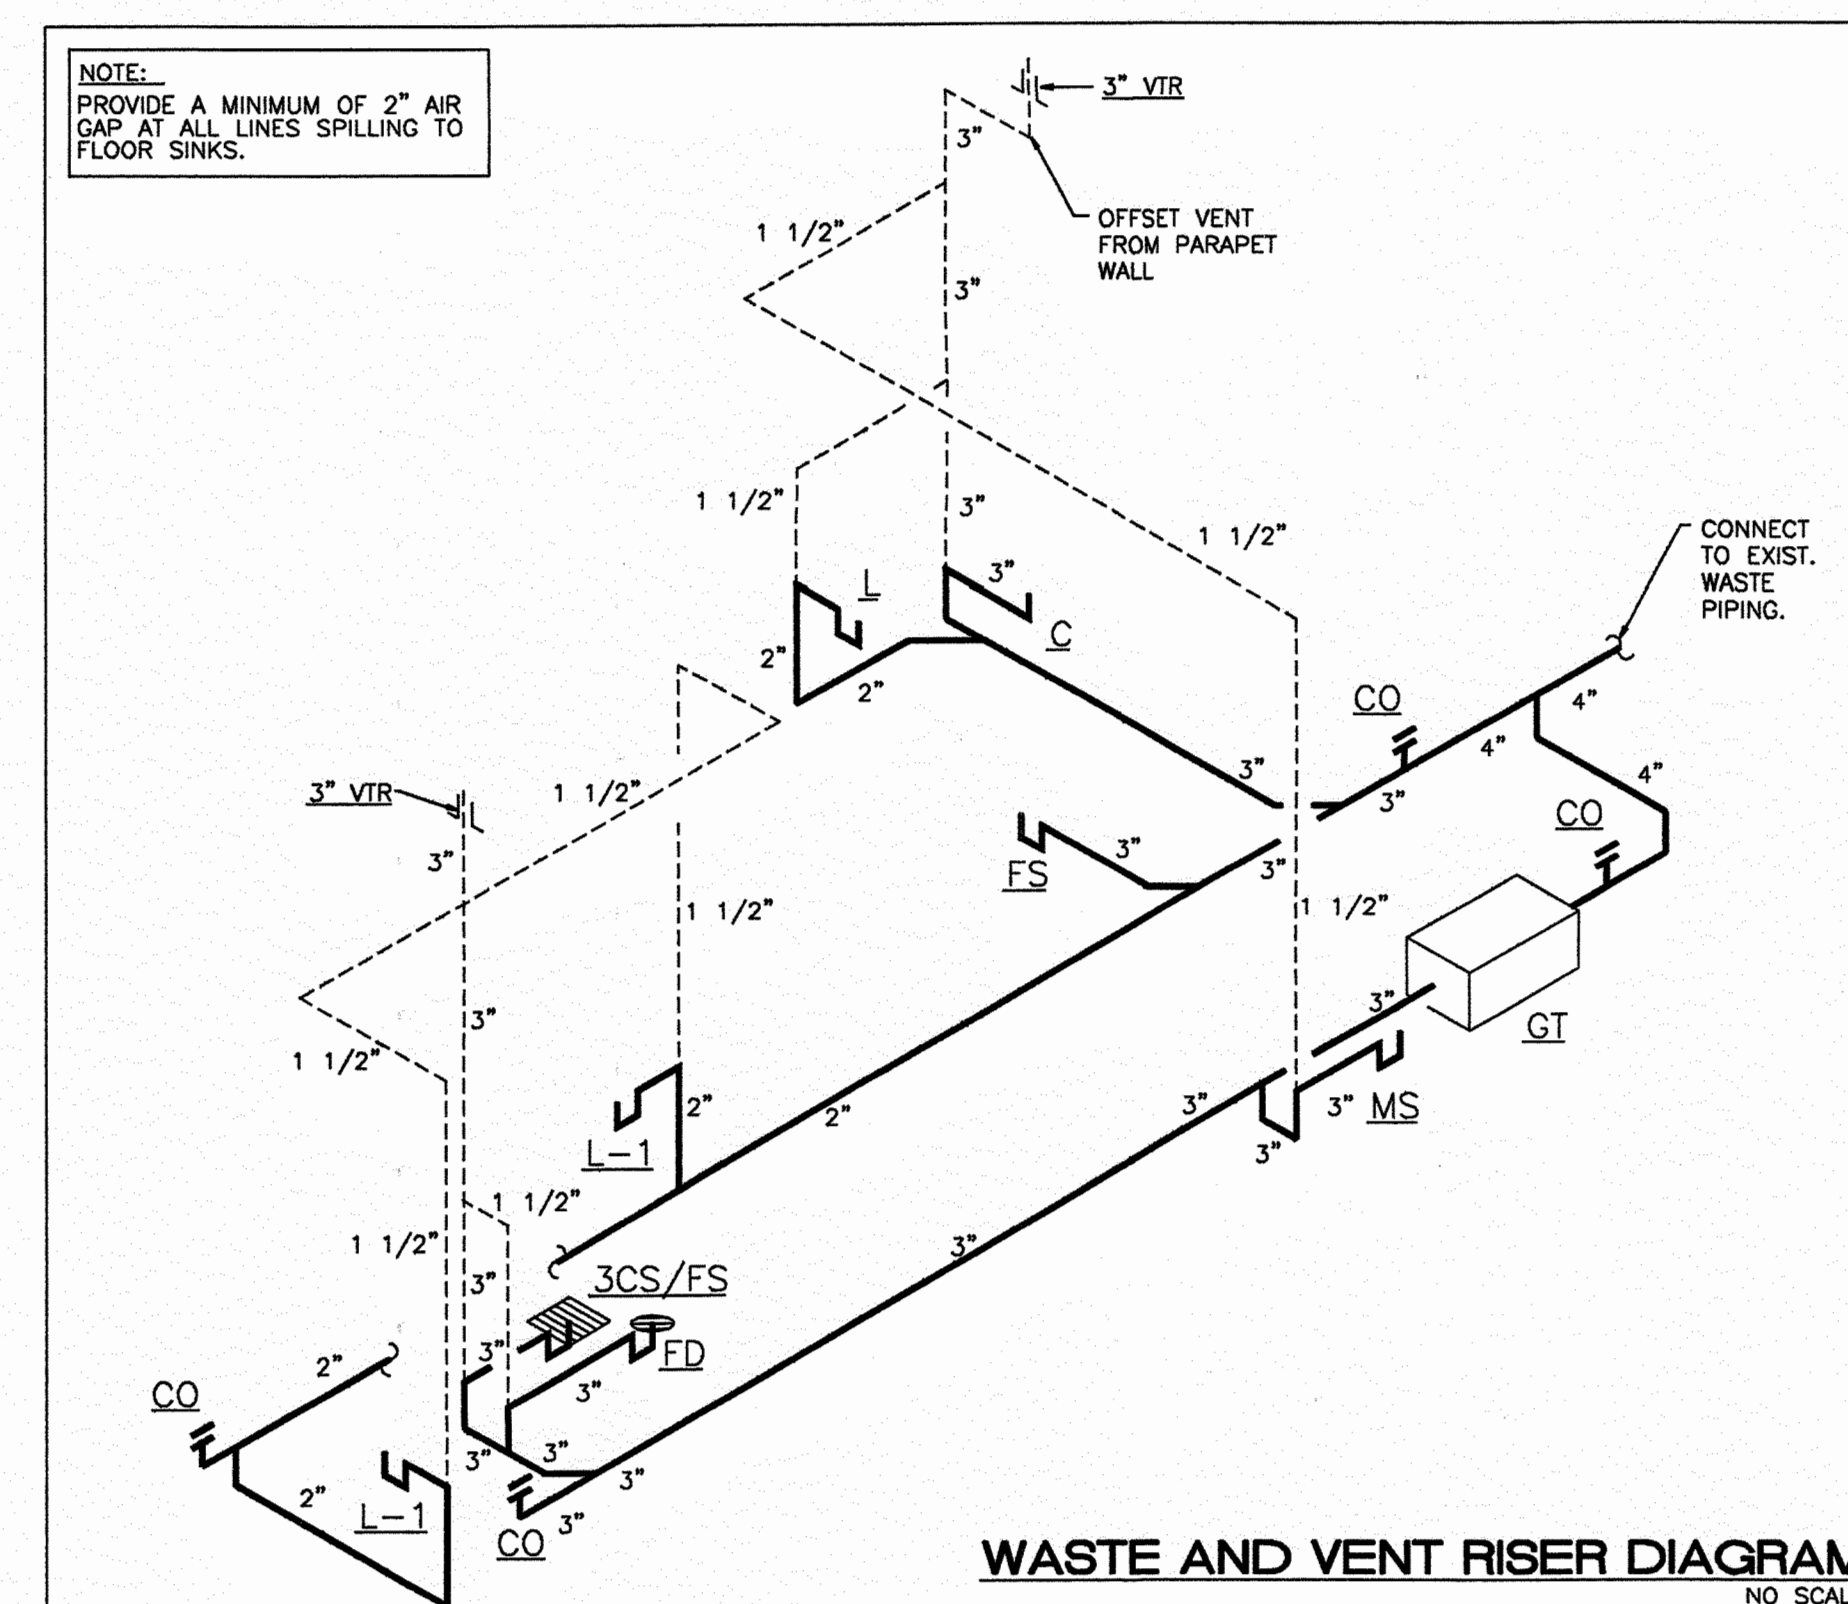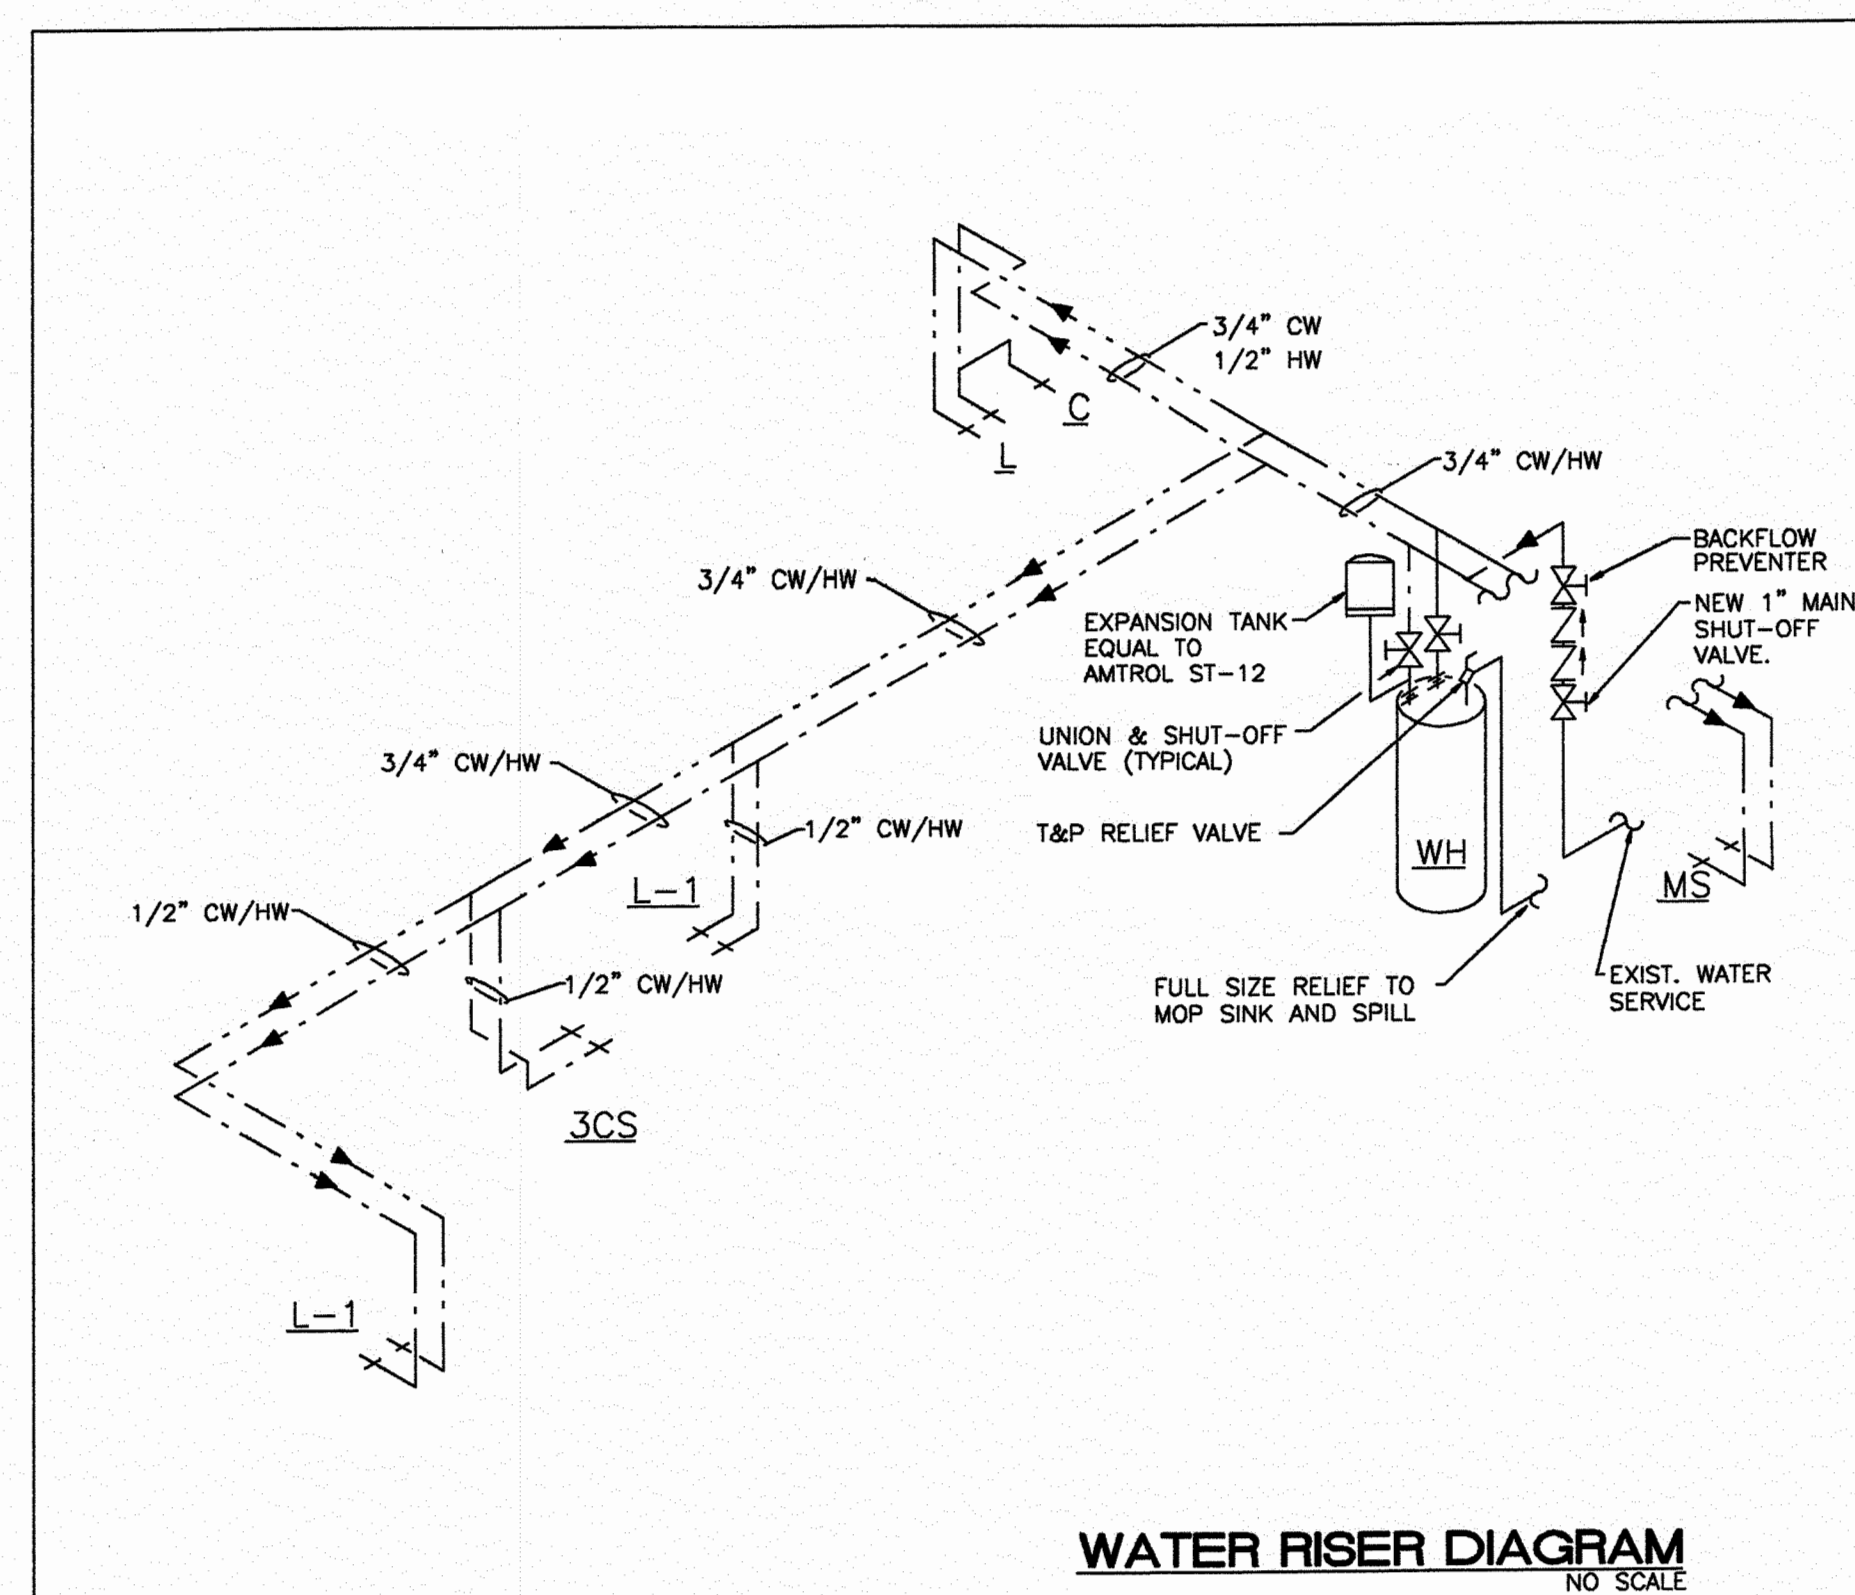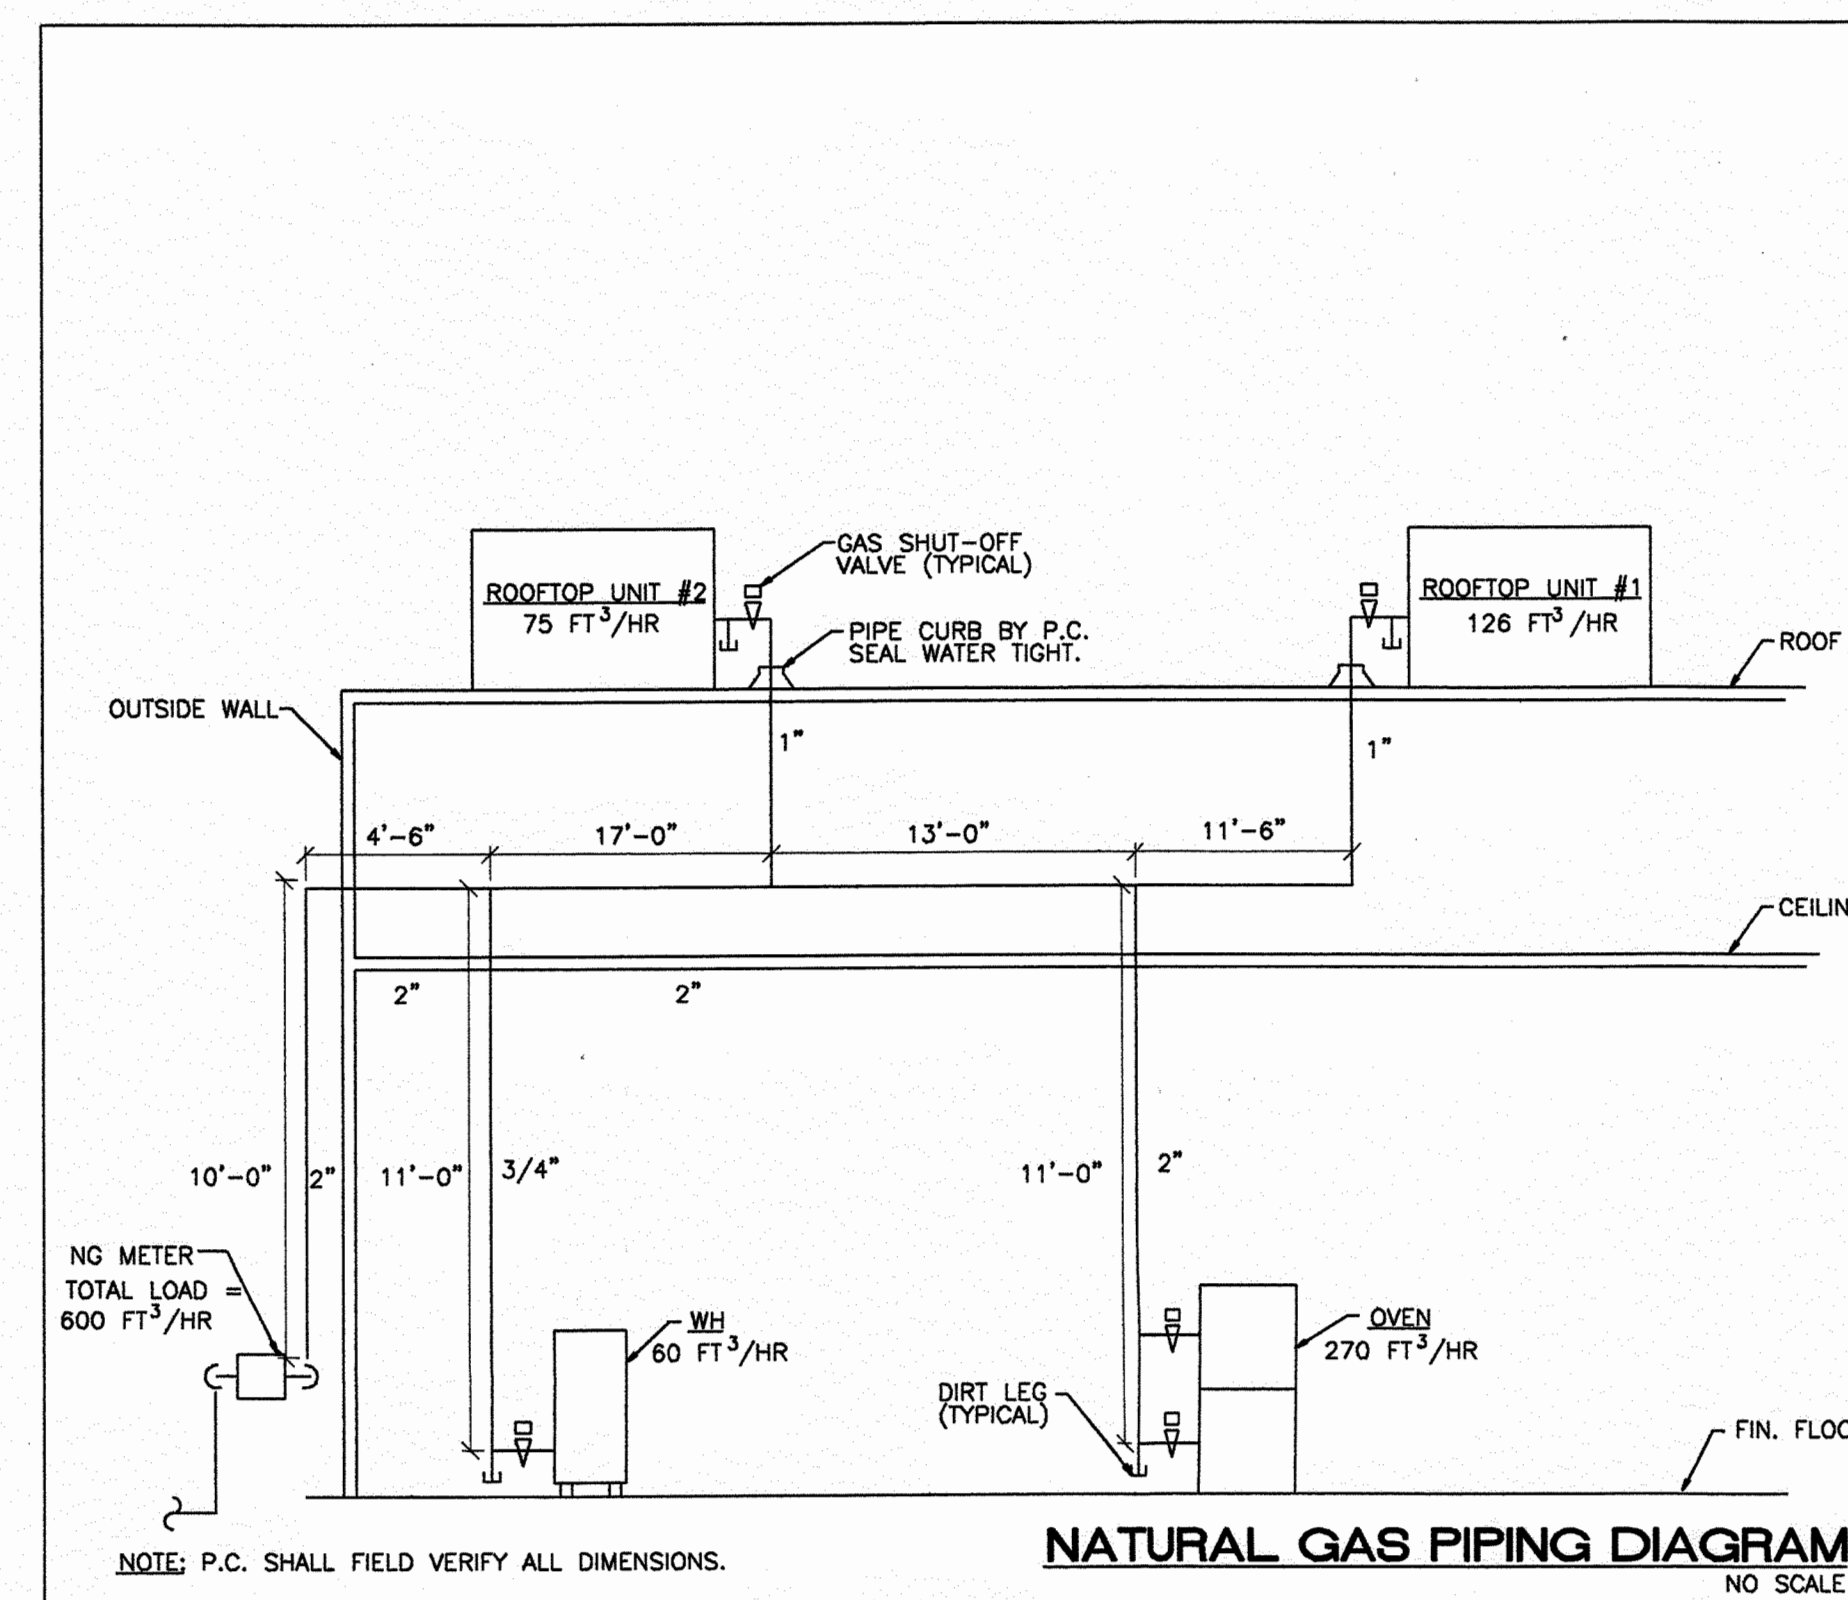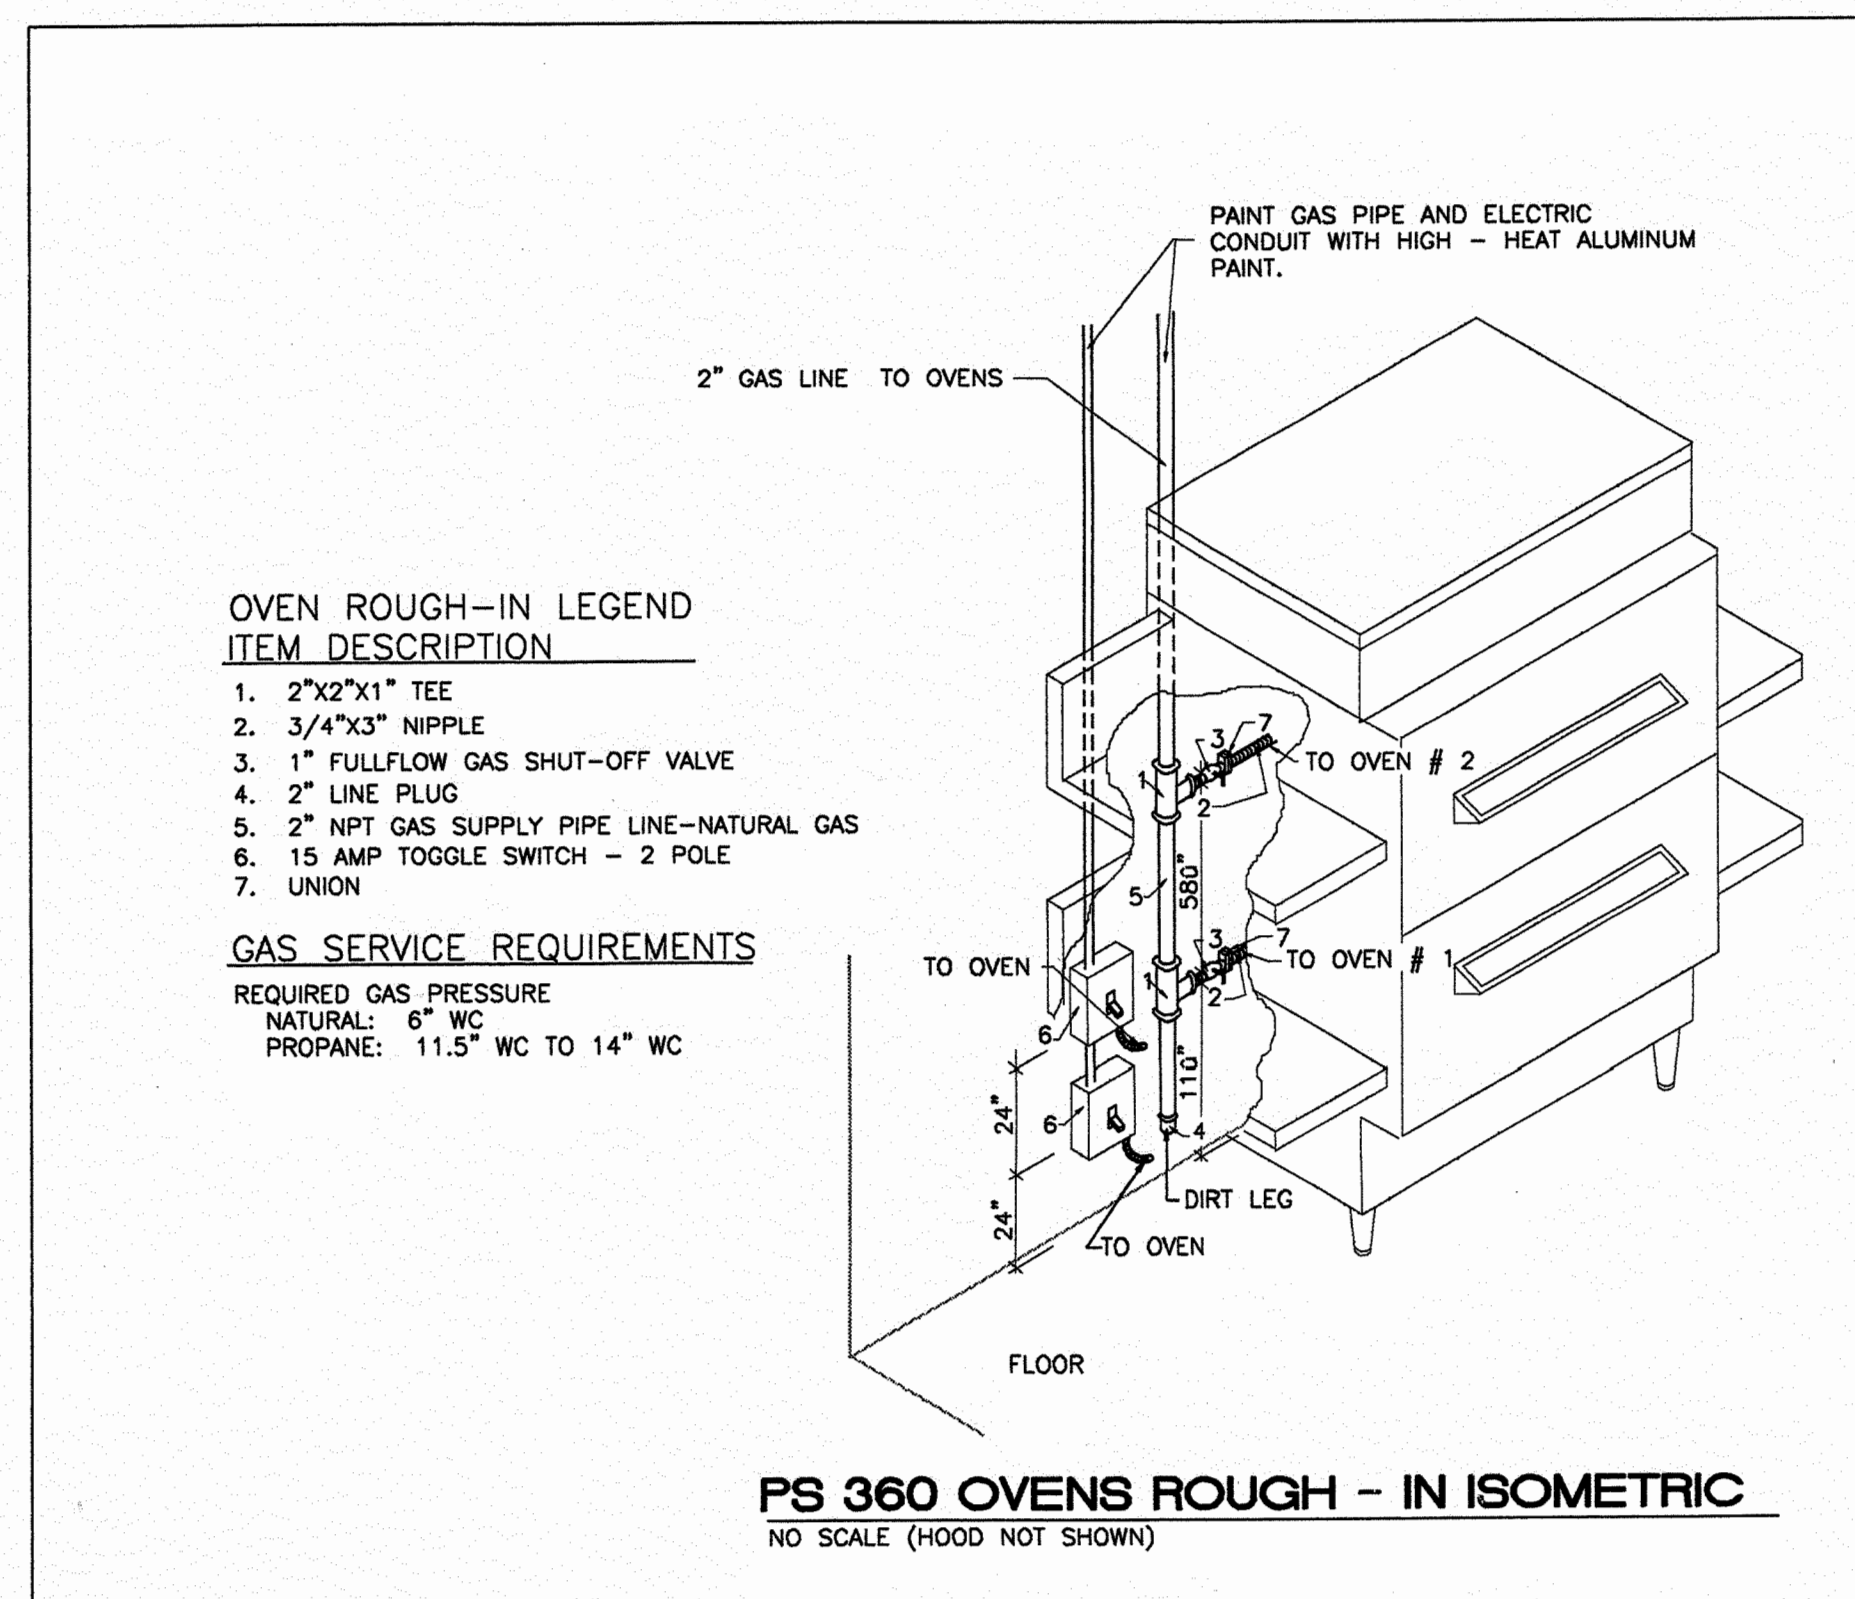


PJP #
99-1093

NEW STORE LOCATION
6200 W. PARKER RD.
PLANO TX.

COPYRIGHT © PAPA JOHN'S INTERNATIONAL, INC
1999 - ALL RIGHTS RESERVED

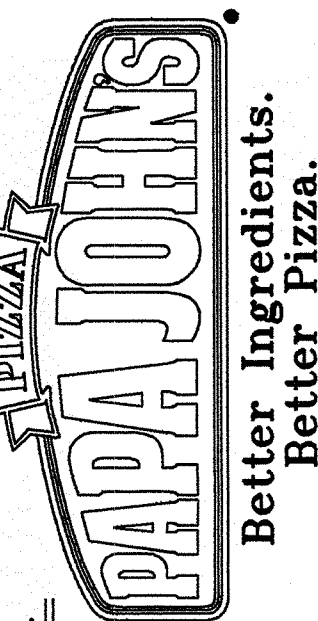

PAPA JOHN'S INTERNATIONAL, INC.
11492 BLUEGRASS PARKWAY
LOUISVILLE, KENTUCKY 40299

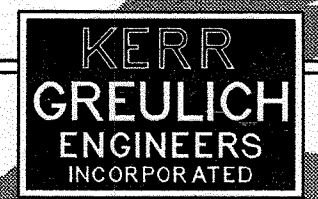

KERR - GREULICH
ENGINEERS, INC.
1534 ORMSBY STATION CT.
LOUISVILLE, KY 40223
PHONE: (502) 426-9457
FAX: (502) 426-2945

NEW PAPA JOHN'S PIZZA STORE :

6200 W. PARKER RD.
PLANO TX.

DATE: 2/15/99

DATE REVISED


SHEET TITLE

H.V.A.C. PLAN
SCHEDULE
NOTES

SHEET NUMBER


M-1
OF: 2

H.V.A.C. SYMBOLS LEGEND

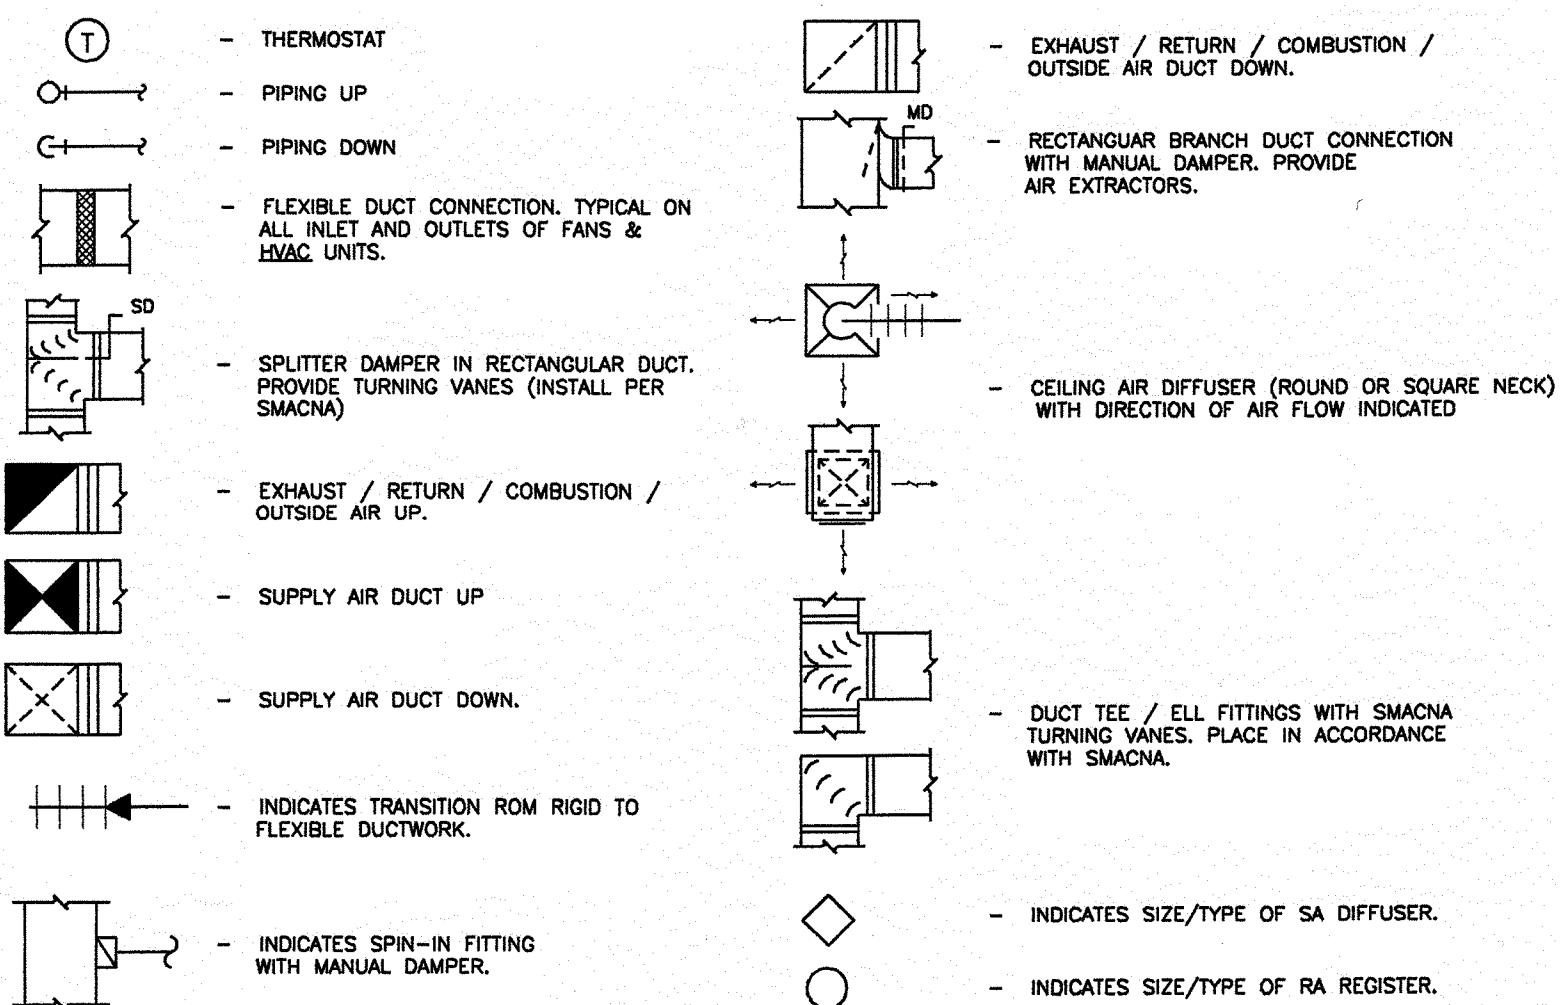

NOTE :

PAPA JOHN'S PIZZA MAINTAINS A NATIONAL ACCOUNT RELATIONSHIP WITH LENNOX INDUSTRIES, INC. AND USES LENNOX HVAC EQUIPMENT. HVAC CONTRACTORS ARE TO CONTACT THE LENNOX NATIONAL ACCOUNT EXECUTIVE: MR. ADAM SMROKOWSKI, PHONE (630) 769-0355, FAX (630) 769-0354, VOICE MAIL 1-800-323-3356. PAPA JOHN'S PIZZA NATIONAL ACCOUNT NUMBER IS A 499.

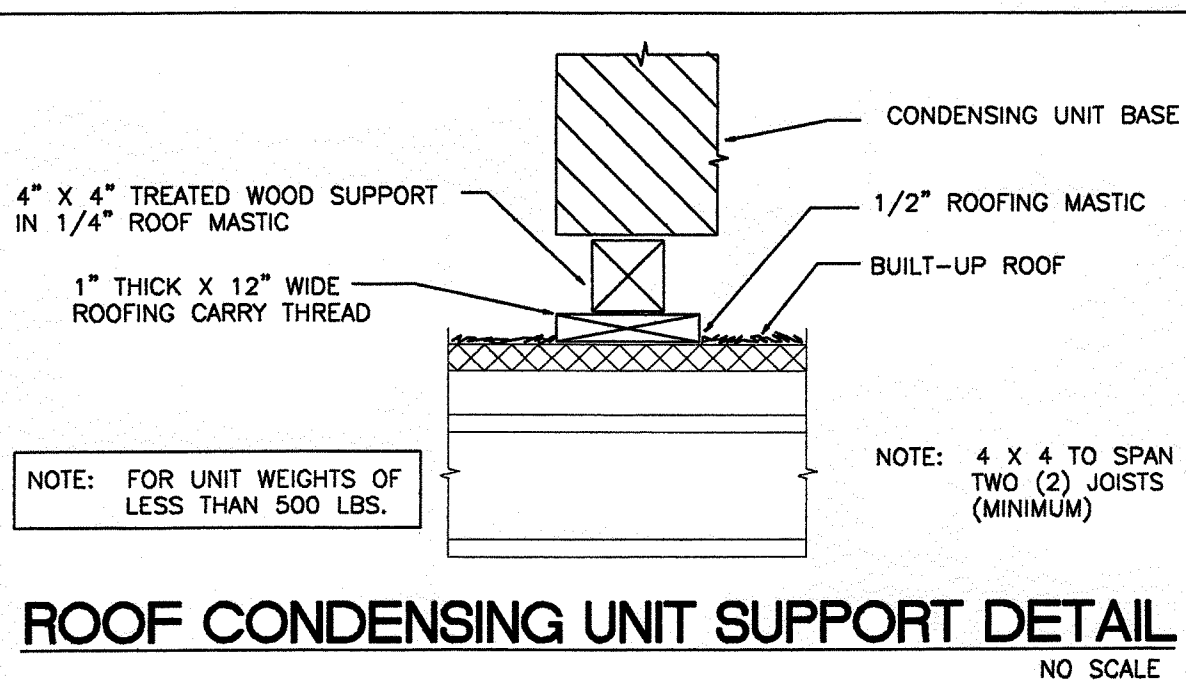


ROOFTOP H.V.A.C. UNIT SCHEDULE

	RTU#1 LENNOX	RTU#2 LENNOX
MANUFACTURER	GCS24-953	GCS16-413
MODEL NO.	126,000	75,000
BTUH INPUT(HEAT)	98,000	57,000
BTUH OUTPUT(HEAT)	88,000	35,900
TOTAL COOLING CAPACITY	68,640	280,000
SENSIBLE COOLING CAPACITY	208/36/60	208/36/60
LINE VOLTAGE	3000	1200
SUPPLY AIR CFM	2250	900
RETURN AIR CFM	750	300
OUTSIDE AIR CFM	.5"	.5"
E.S.P.		

H.V.A.C. GENERAL NOTES :

- HVAC UNITS TO HAVE MANUAL OUTSIDE AIR DAMPER
- ALL SUPPLY DUCTS AND OUTSIDE AIR DUCTS INSIDE BUILDING SHALL BE INSULATED EXTERNALLY WITH 1 1/2" THICK FIBERGLASS OF DENSITY OF 1.5 POUNDS PER CUBIC FOOT AND BE COMPLETE WITH VAPOR BARRIER JACKET. ALL DUCT INSULATION, TAPE COVERINGS, AND FLEXIBLE CONNECTORS SHALL HAVE A FLAME SPREAD RATING OF 25 OR LESS AND A SMOKE DEVELOPED RATING OF 50 OR LESS IN ACCORDANCE WITH ASTM E84.
- ALL FLEXIBLE DUCTS SHALL BE METAL FLEX CLASS 1 TYPE 500 AIR DUCT AND SHALL BE U.L. LISTED AND HAVE 1" THICK FIBERGLASS INSULATION ENCASED IN A VAPOR BARRIER OF SEAMLESS, NON-COMBUSTIBLE, CO-POLYMER PLASTIC.
- ALL FLEXIBLE DUCTS SHALL BE CONNECTED TO TRUNK OR BRANCH DUCTS WITH A MINIMUM OF THREE SHEET METAL SCREWS AT EACH CONNECTION AND BE TAPED TO PROVIDE AN AIR TIGHT SEAL. MAXIMUM LENGTH OF FLEXIBLE DUCT SHALL BE 5'-0".
- FLEXIBLE DUCT HANGERS STRIPS SHALL BE MINIMUM 2" WIDE BY 22 GAUGE GALVANIZED METAL.
- ALL DUCTWORK SHALL BE INSTALLED IN ACCORDANCE WITH THE MOST RECENT PUBLISHED SMACNA STANDARDS FOR LOW-VELOCITY, LOW-PRESSURE DUCTS.
- ALL CONTROL WIRING SHALL BE FURNISHED AND INSTALLED BY H.V.A.C. CONTRACTOR.
- THERMOSTATS SHALL BE HONEYWELL T-7300/07300 B1008 OR EQUAL WITH SHIELDED CABLE. ALL THERMOSTATS SHALL BE FURNISHED AND INSTALLED BY M.C.
- ROOF MOUNTED EXHAUST AND MAKE-UP AIR UNITS SHALL BE FURNISHED WITH BIRD SCREENS. DISCONNECT SWITCHES AND HINGED BASE ON EXHAUST FAN.
- WATER HEATER VENT SHALL BE CLASS "B". PROVIDE PROTECTION OF ADJACENT COMBUSTIBLE MATERIALS TO MEET STATE AND LOCAL CODES. HOLD WATER HEATER VENT A MINIMUM OF 10'-0" FROM OUTSIDE AIR INTAKE ON H.V.A.C. UNITS.
- H.V.A.C. CONTRACTOR SHALL INSTALL EXHAUST FAN AND FURNISH AND INSTALL COMPLETE EXHAUST DUCT SYSTEM. DUCTS SHALL BE INSULATED WITH MINERAL WOOL AND COVERED WITH 20 GA. STAINLESS STEEL COVER WHERE EXPOSED. EXHAUST DUCTWORK SHALL BE CONSTRUCTED OF 20 GAUGE SHEET METAL.
- J-TOWN EQUIPMENT TO FURNISH MAKE-UP AIR FAN AND CURB. MECHANICAL CONTRACTOR TO INSTALL MAKE-UP AIR FAN, CURB, AND DUCT SYSTEM COMPLETE.
- PROVIDE NEOPRENE FLEXIBLE CONNECTIONS AT SUPPLY AND RETURN DUCT CONNECTIONS ON H.V.A.C. UNITS.
- H.V.A.C. CONTRACTOR SHALL BALANCE H.V.A.C. SYSTEM TO AIR QUANTITIES INDICATED. PROVIDE TYPED WRITTEN REPORT TO OWNER UPON COMPLETION.
- CONTRACTOR SHALL VISIT SITE PRIOR TO SUBMITTING BID TO VERIFY ALL EXISTING CONDITIONS.
- CONTRACTOR SHALL FIELD VERIFY DUCT CLEARANCE/ SPACE FOR ROUTING DUCTS PRIOR TO SUBMITTING BID. CONTRACTOR MAY ALTER DUCT SIZING TO ACCOMMODATE CLEARANCES ABOVE CEILINGS, BUT MUST MAINTAIN SAME EFFECTIVE DUCT AREA.
- ALL WORK SHALL BE FURNISHED AND INSTALLED TO COMPLY WITH ALL STATE AND LOCAL CODES.
- M.C. SHALL PROVIDE ALL REQUIRED DUCT TRANSITIONS FROM PIZZA OVEN HOOD CONNECTIONS TO SUPPLY AIR AND EXHAUST AIR DUCT SIZES INDICATED.
- MECHANICAL CONTRACTOR SHALL PROVIDE AS-BUILT DRAWINGS TO GENERAL CONTRACTOR PRIOR TO FINAL PAYMENT.
- SMOKE DETECTORS FOR FAN SHUT-DOWN WHERE REQUIRED BY MECHANICAL CODE SHALL BE FURNISHED AND INSTALLED BY THE ELECTRICAL CONTRACTOR. REFER TO ELECTRICAL DRAWINGS.

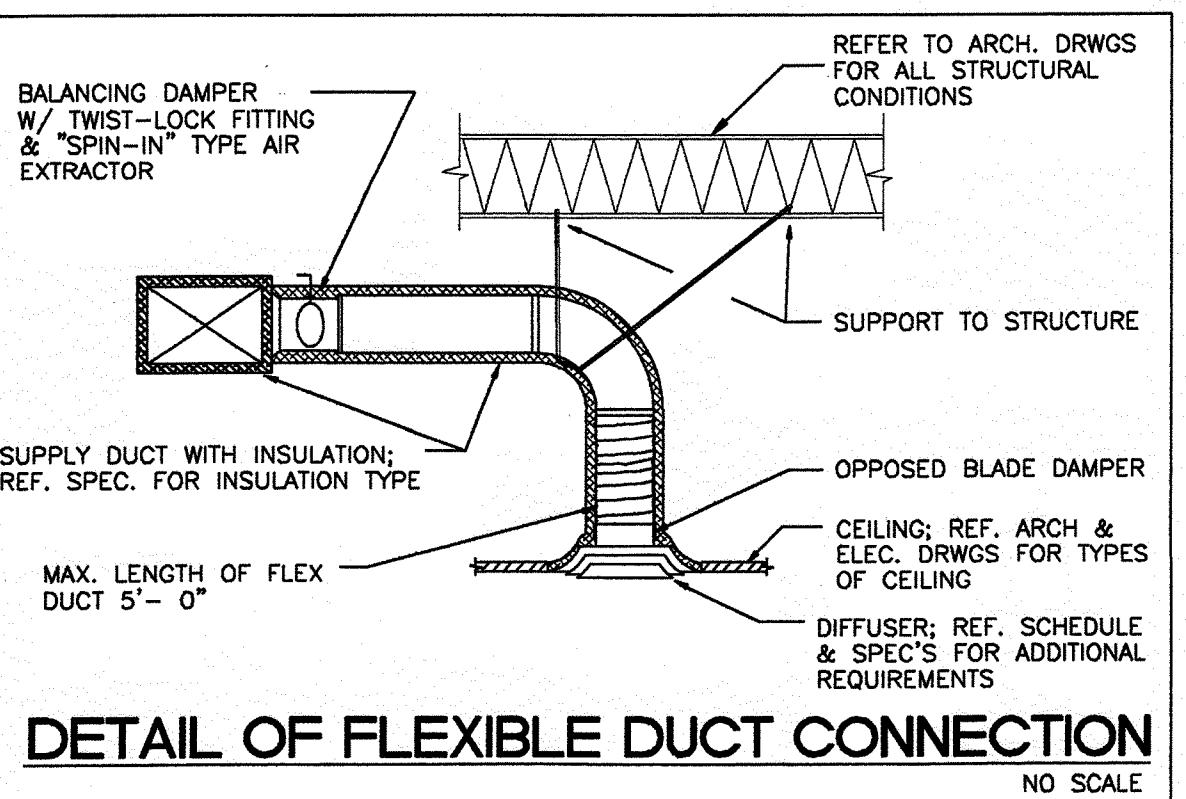

AIR BALANCE SCHEDULE

ITEM	O.A.	R.A.	S.A.	E.A.	PRESSURE
RTU-1	750	2250	3000	----	+750
RTU-2	300	900	1200	----	+300
SF - 1	1800	----	1800	----	+1800
EF - 1	----	----	----	-100	-100
EF - 2	----	----	----	-2650	-2650
TOTALS	2850	3150	6000	-2750	+100

RETURN AND SUPPLY AIR DIFFUSER SCHEDULE



ITEM	MFR.	TYPE	MODEL	SIZE	NECK SIZE
A	TITUS	SUPPLY	300RL	10" X 6"	REF. DRAWING
B	TITUS	SUPPLY	TMS	24" X 24"	8"
C	TITUS	SUPPLY	TMS	24" X 24"	10"
D	TITUS	SUPPLY	TMS	24" X 24"	12"
E	TITUS	SUPPLY	TMS	24" X 24"	14"
F	TITUS	SUPPLY	250	16" X 12"	REF. DRAWING
1	TITUS	RETURN	26 RL 6	12" X 12"	-
2	TITUS	RETURN	26 RL 6	24" X 24"	-
3	TITUS	RETURN	26 RL 6	24" X 36"	-
4	TITUS	RETURN	26 RL 6	24" X 48"	-

NOTE :

- DIFFUSERS SHALL HAVE OPPOSED BLADE DAMPERS.
- DIFFUSERS SHALL FIT 24" X 24" LAY - IN CEILING GRID.
- DIFFUSERS SHALL BE LOUVER FACE TYPE, WITH BAKED ENAMEL FINISH.
- DIFFUSERS/ GRILLES SHALL BE EQUAL TO ANEMOSTAT, CARNES, METALAIR, TITUS
- RA GRILLES TO BE ALUMINUM, EGG-CRATE TYPE, 1/2"x1/2" SPACING WITH WHITE FINISH.

H.V.A.C. KEY NOTES

- PROVIDE RETURN AIR FILTER GRILLES IN CEILING; PROVIDE DUCT TRANSITION FROM R.A. AT RTU TO SHEET METAL R.A. PLENUM. (TYPICAL OF RTU#1 AND RTU#2.)
- CONDENSING UNIT ON ROOF FOR WALK-IN COOLER. UNIT TO BE MOUNTED ON 4"x4" PRESSURE TREATED EQUIPMENT RAILS; RAILS BY M.C.
- EXTEND REFRIGERANT LINES DOWN THRU PIPE CURB AND CONNECT TO COOLER EVAPORATOR . PIPE CURB BY M.C. ; REFERENCE DETAIL.
- CONDENSATE DRAIN TO SPLASH BLOCK ON ROOF BY M.C. (TYPICAL).
- 8"x4" EXHAUST DUCT UP THRU 12" HIGH ROOF CURB TO EXHAUST DISCHARGE HOOD.
- 4" HWH VENT THRU ROOF (TYPE "B").
- 14"x16" UP TO EF-2 ON ROOF. HOLD 10'-0" FROM O.A. INTAKES
- 16"x12" S.A. DUCT FROM MAKE-UP AIR UNIT ON ROOF. EXTEND DUCT TO HOOD & CONNECT.
- DASHED LINE INDICATES EXHAUST FAN/MAKE-UP AIR UNIT ON ROOF. REF. DRWG M-2 FOR ADDITIONAL INFORMATION.
- INTAKE TO BE A MINIMUM OF 10'-0" FROM EXHAUST.
- THE EXHAUST OUTLET SHALL ALWAYS BE LOCATED AT THE REAR OF THE HOOD AND THE SUPPLY AIR INLET SHALL BE LOCATED AT THE FRONT OF THE HOOD. THE MAKE-UP AIR UNIT SHALL BE ROTATED ON THE ROOF AS REQUIRED TO ACCOMMODATE THIS. CONTRACTOR SHALL PROVIDE OFFSETS IN THE MAKE UP AIR DUCT WHERE REQUIRED.

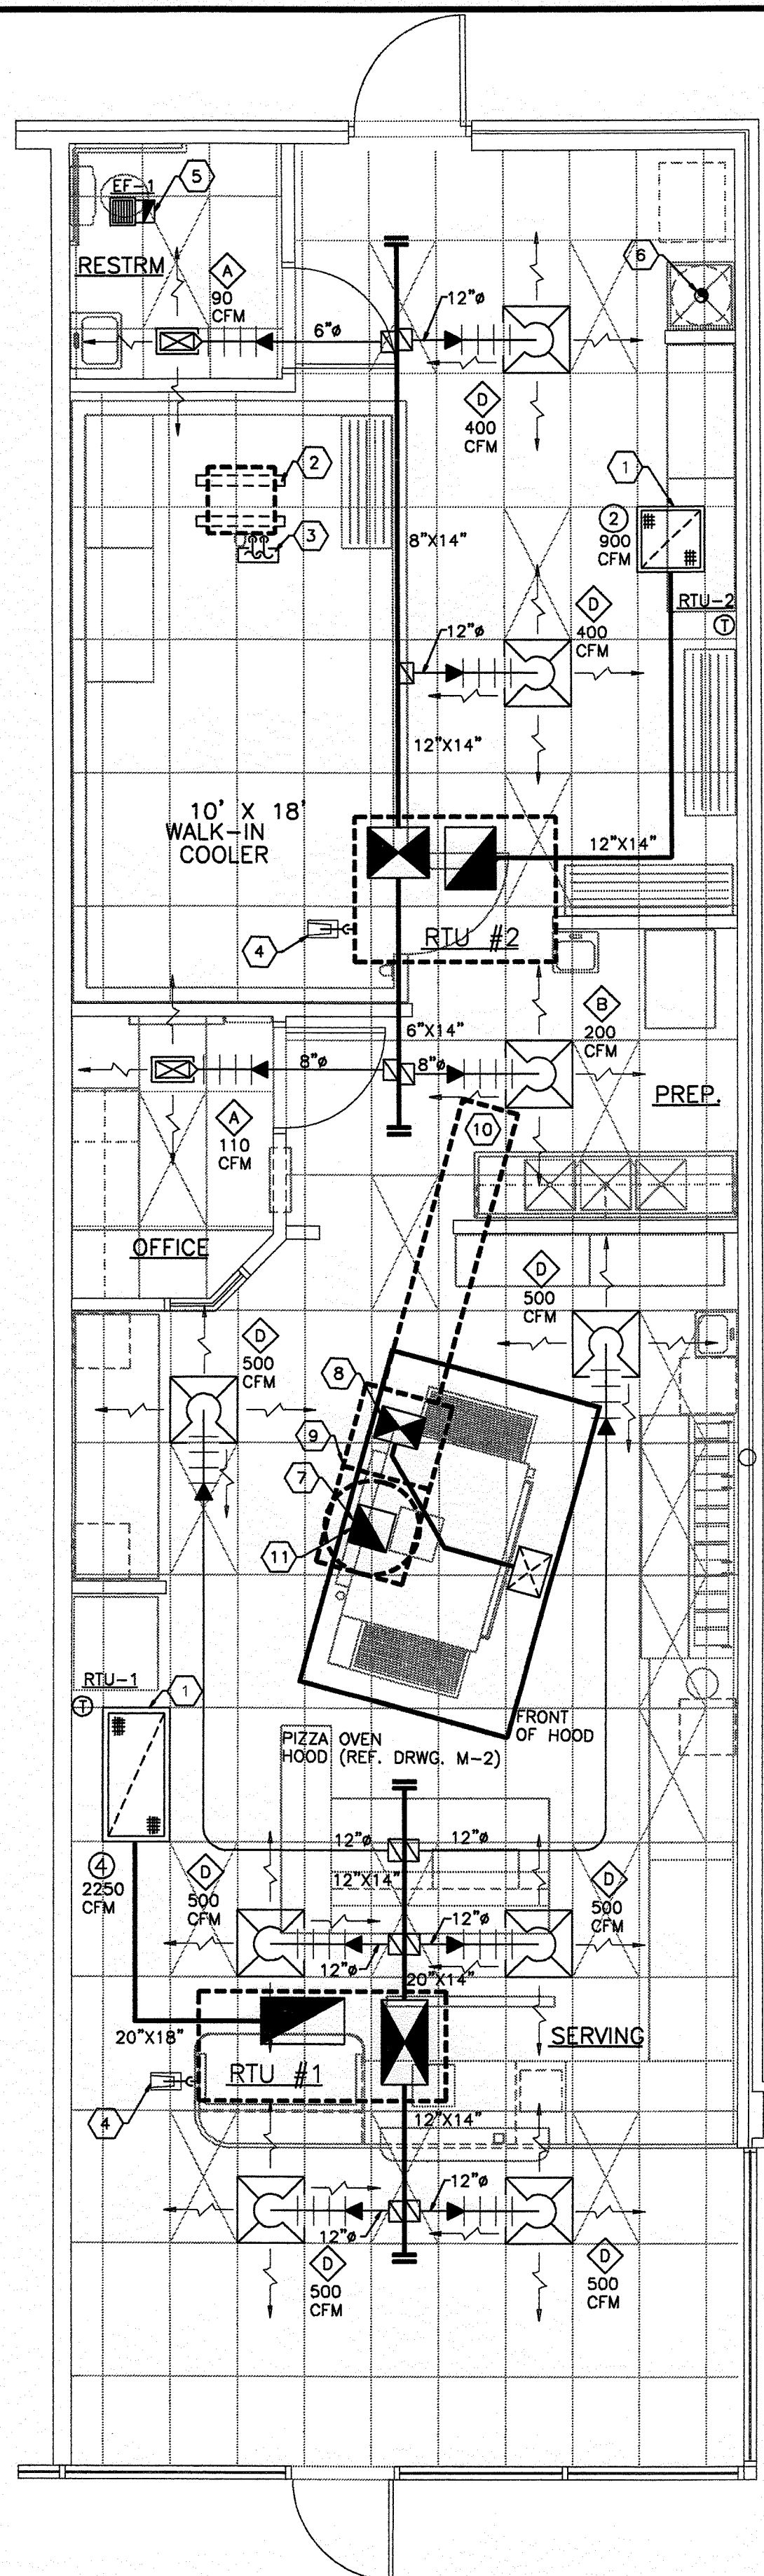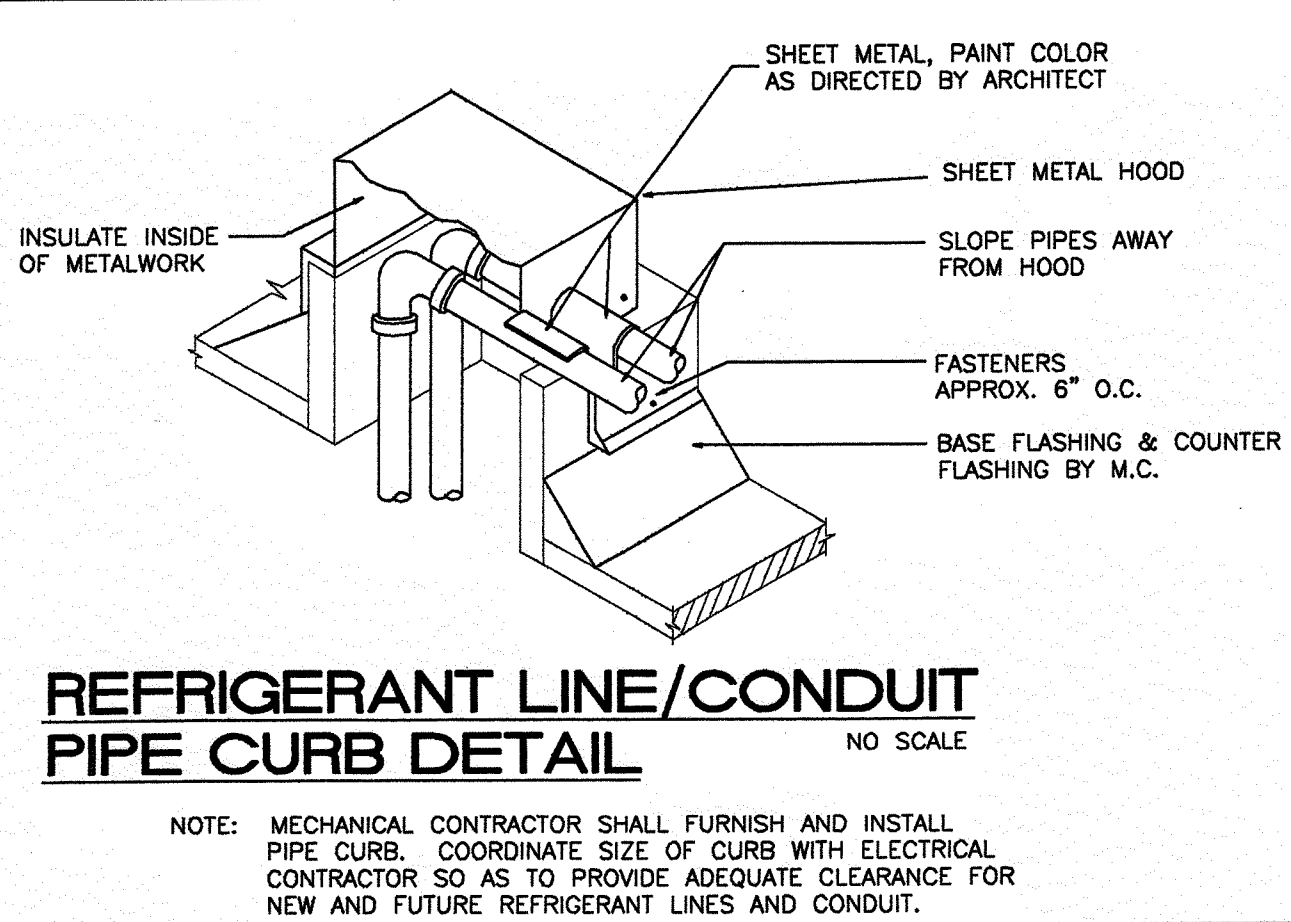


H.V.A.C. PLAN

SCALE : 1/4" = 1'-0"

PJP #
99-1093


NEW STORE LOCATION
6200 W. PARKER RD.
PLANO TX.

COPYRIGHT © PAPA JOHN'S INTERNATIONAL, INC.
1999 - ALL RIGHTS RESERVED

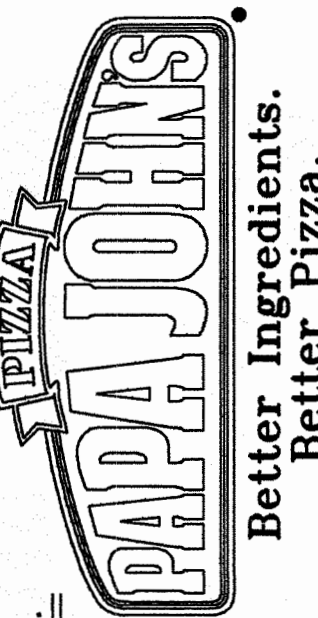

PAPA JOHN'S INTERNATIONAL, INC.

11442 BLUEGRASS PARKWAY
LOUISVILLE, KENTUCKY 40299

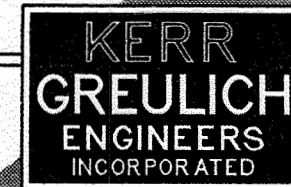

KERR - GREULICH
ENGINEERS, INC.
1534 CHERRY STATION CT.
LOUISVILLE, KY 40223
PHONE: (502) 426-9457
FAX: (502) 426-2945







NEW PAPA JOHN'S PIZZA STORE :
6200 W. PARKER RD.
PLANO TX.

DATE: 2/15/99
DATE REVISED

SHEET TITLE

CANOPY HOOD
SCHEDULE
NOTES

SHEET NUMBER

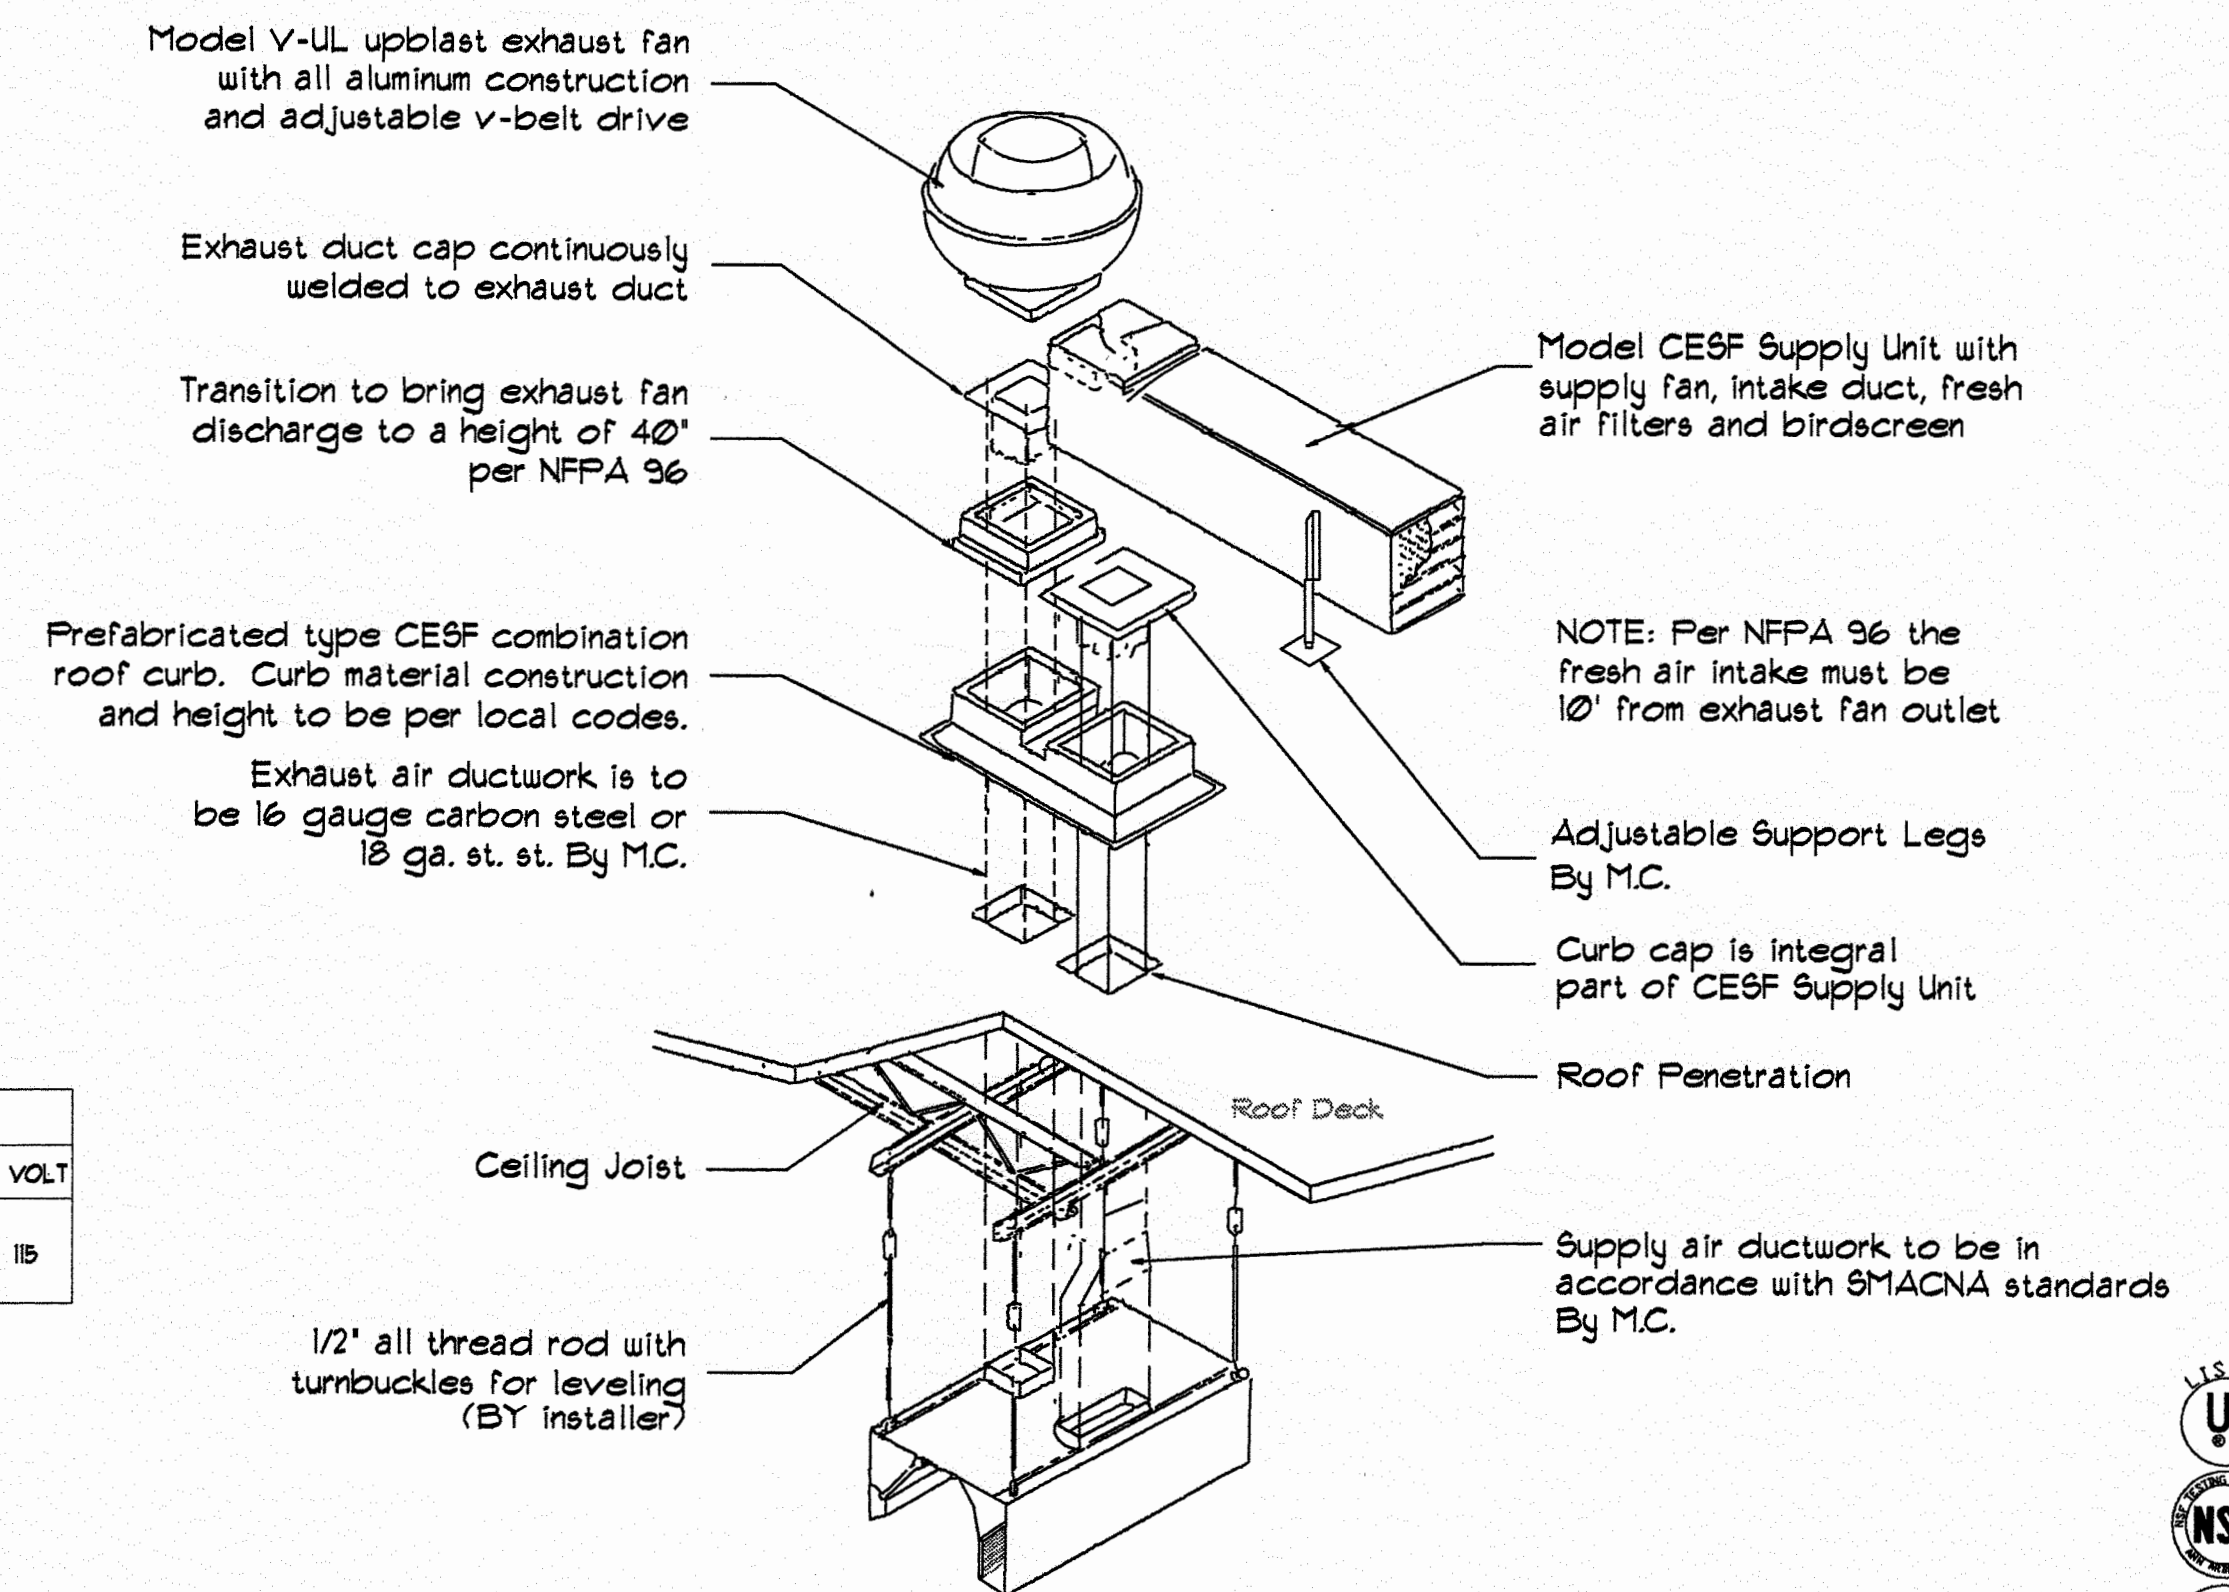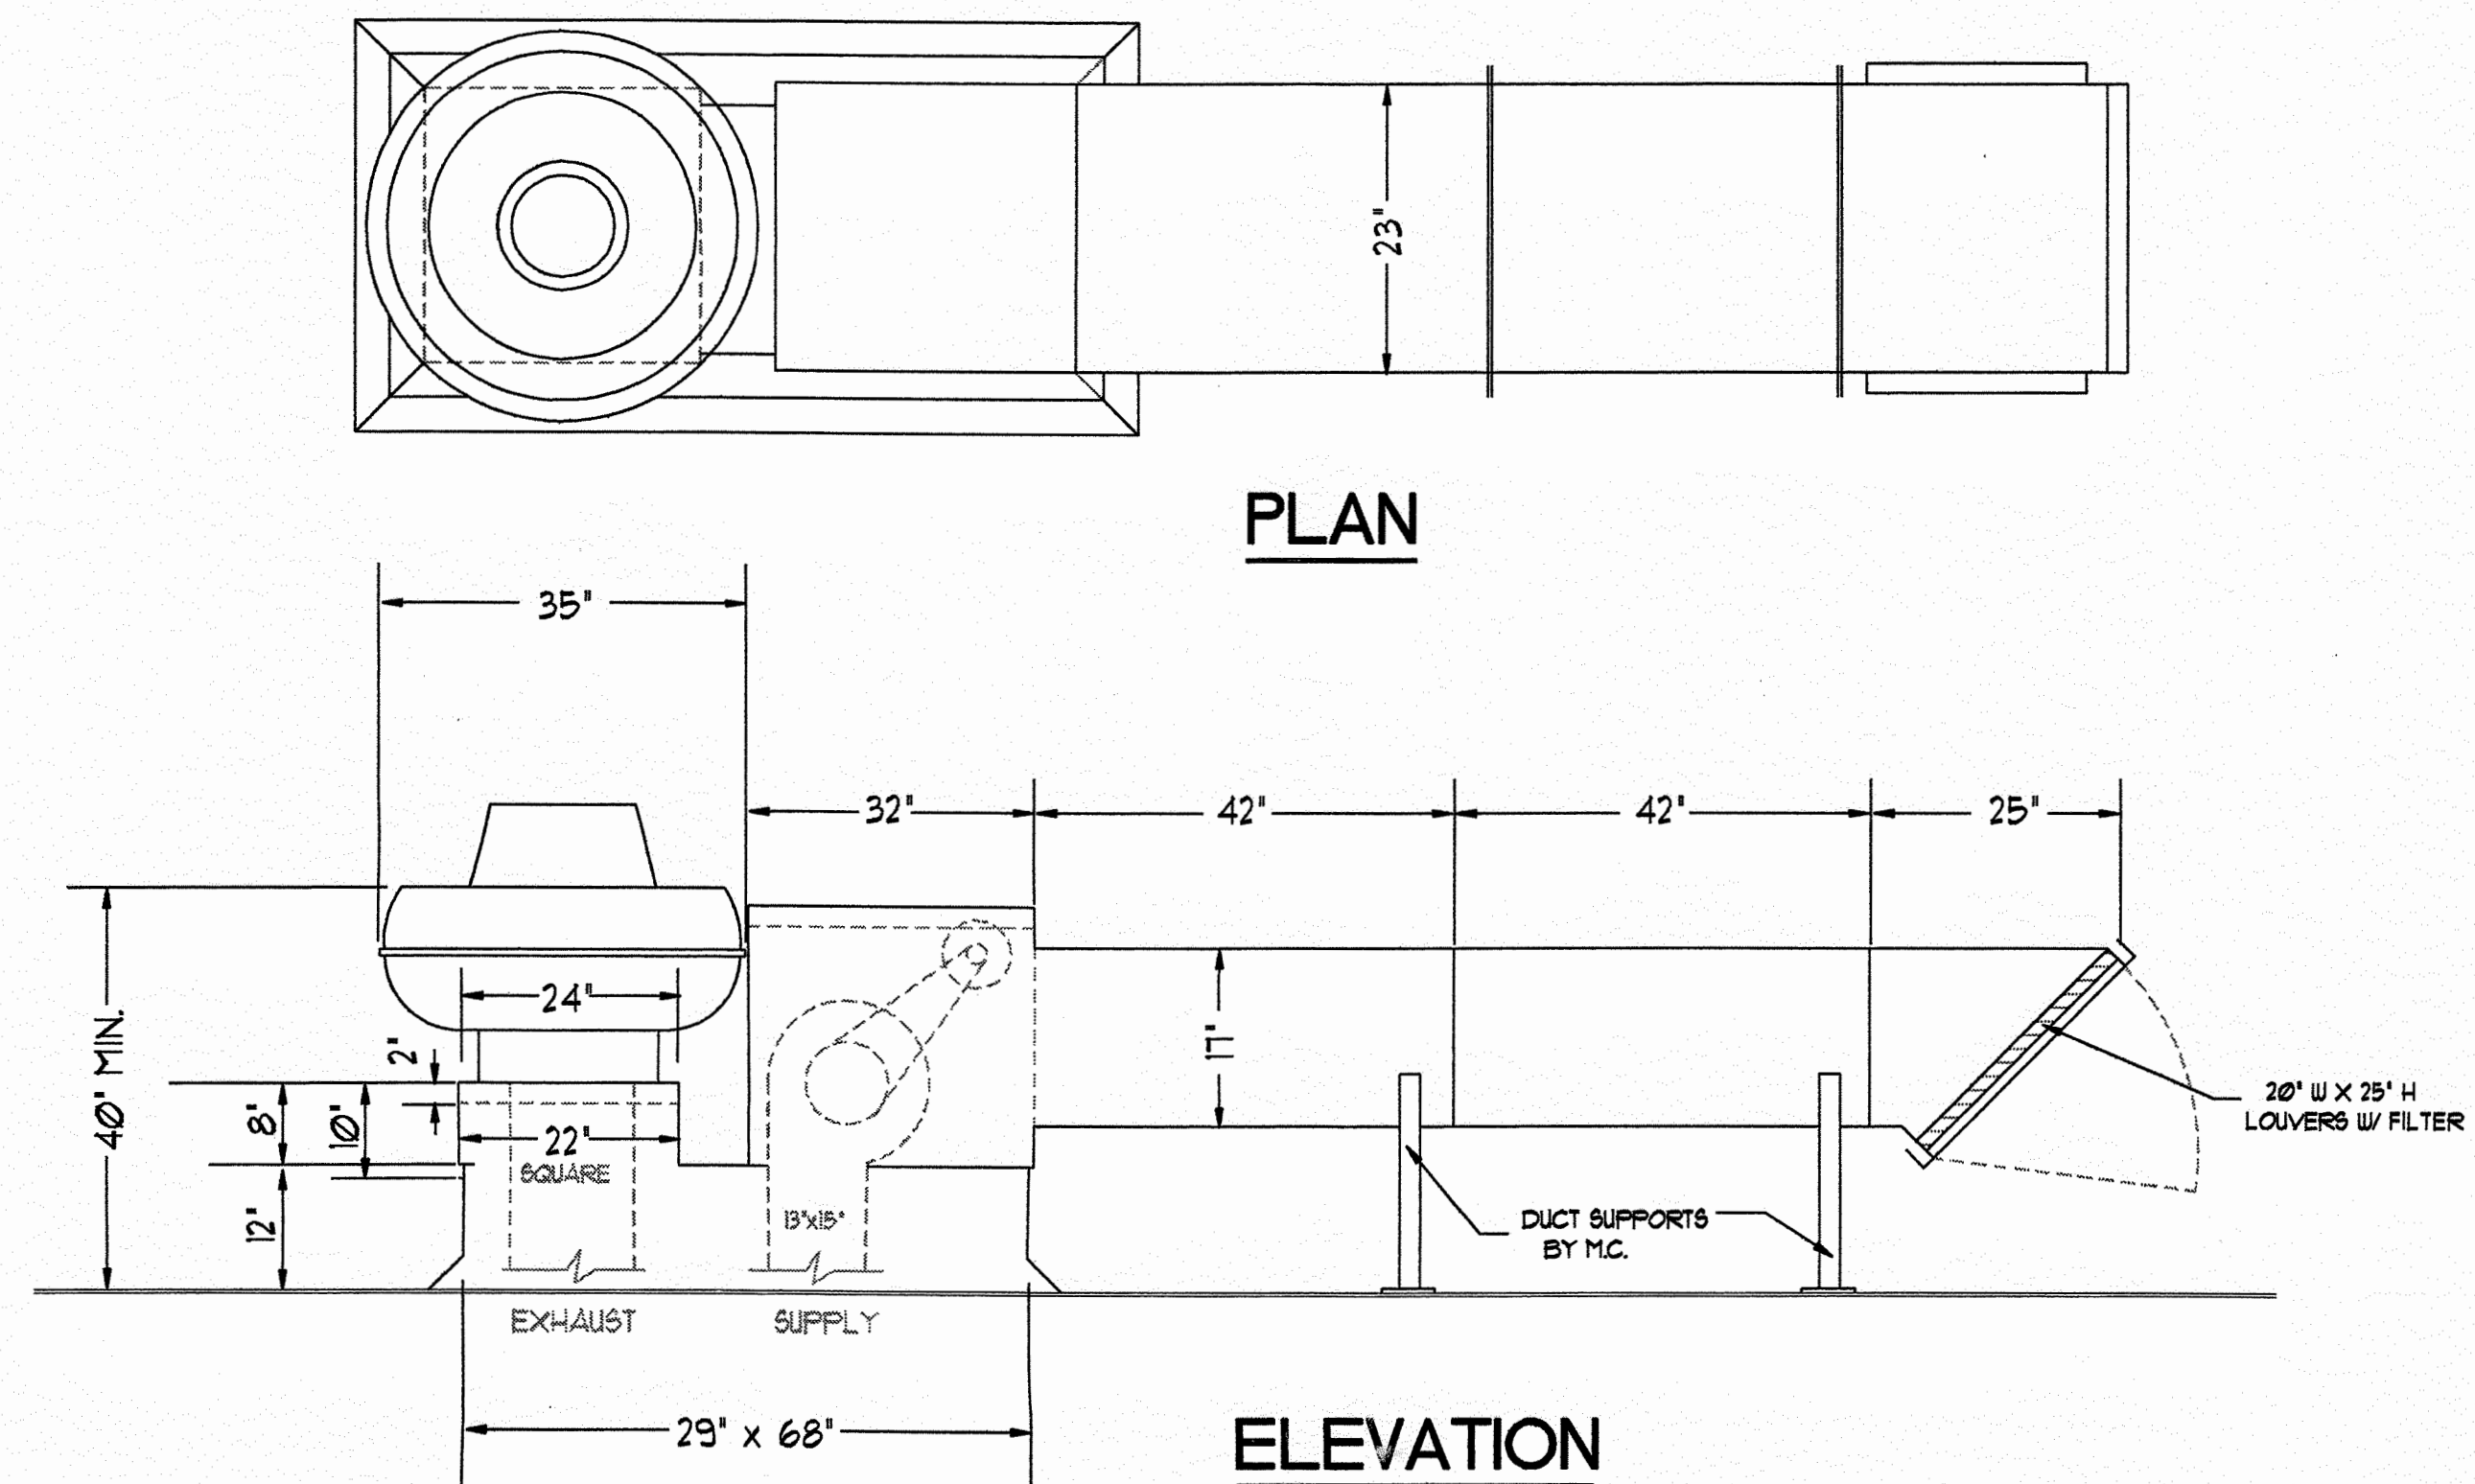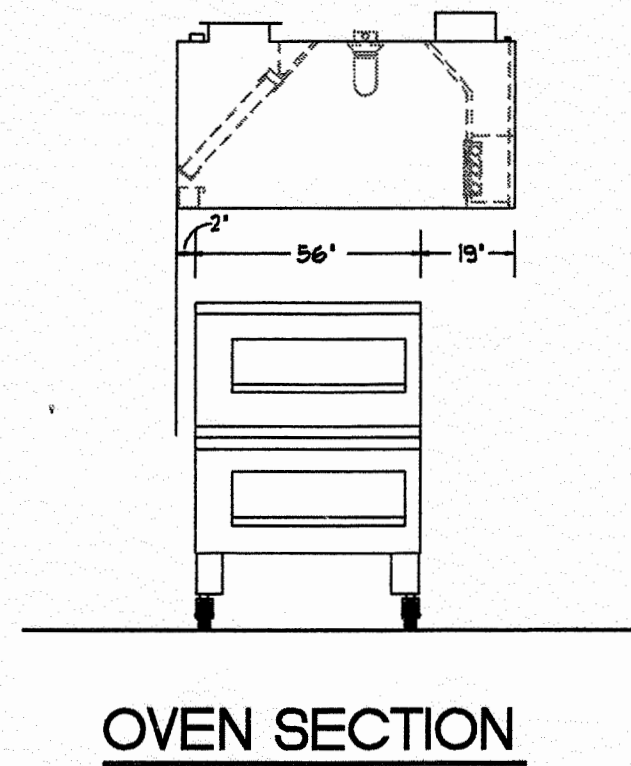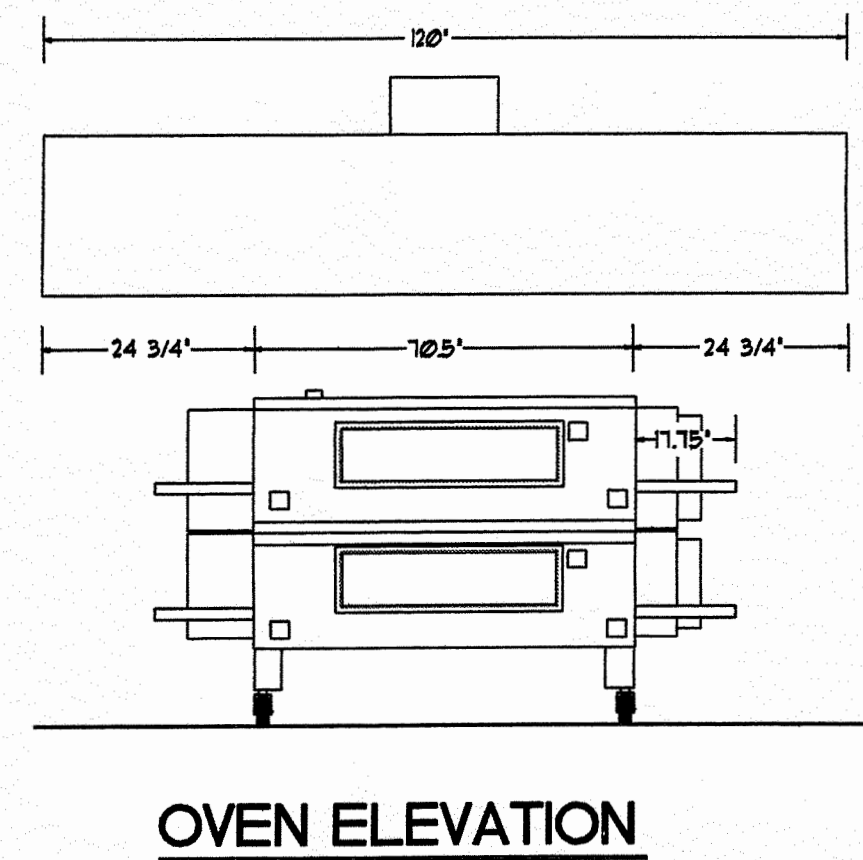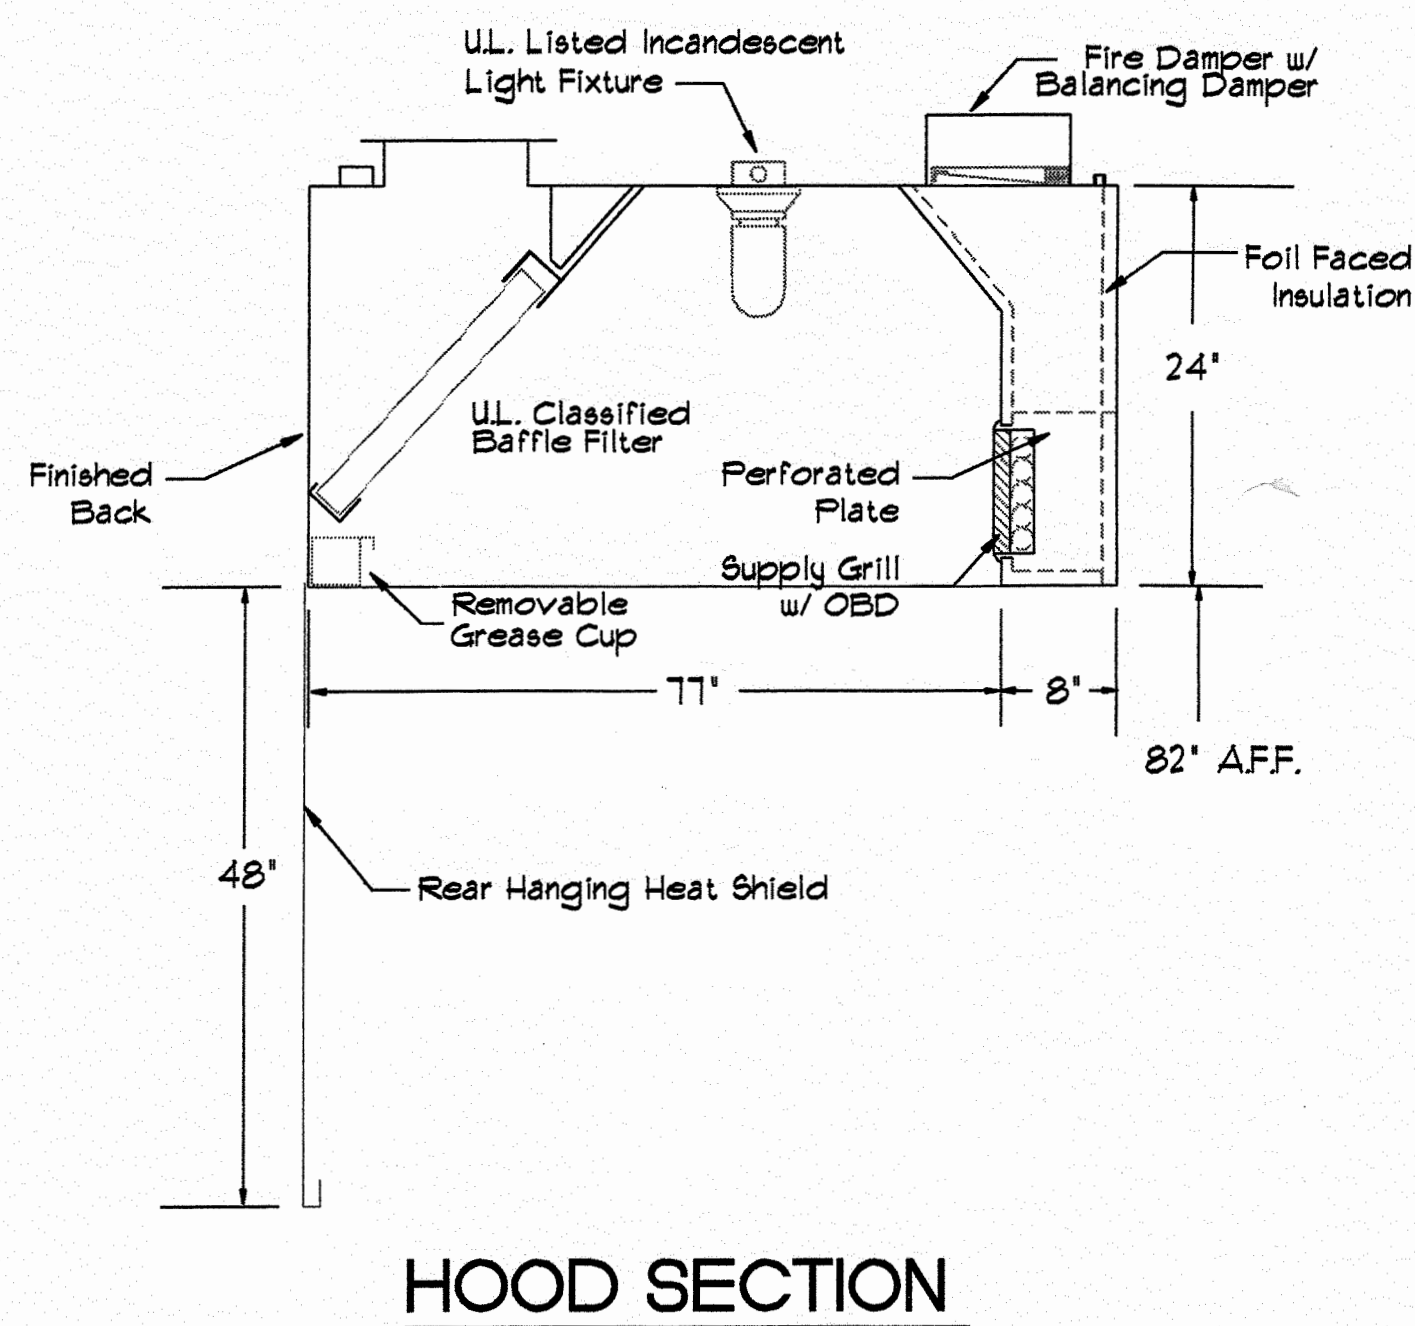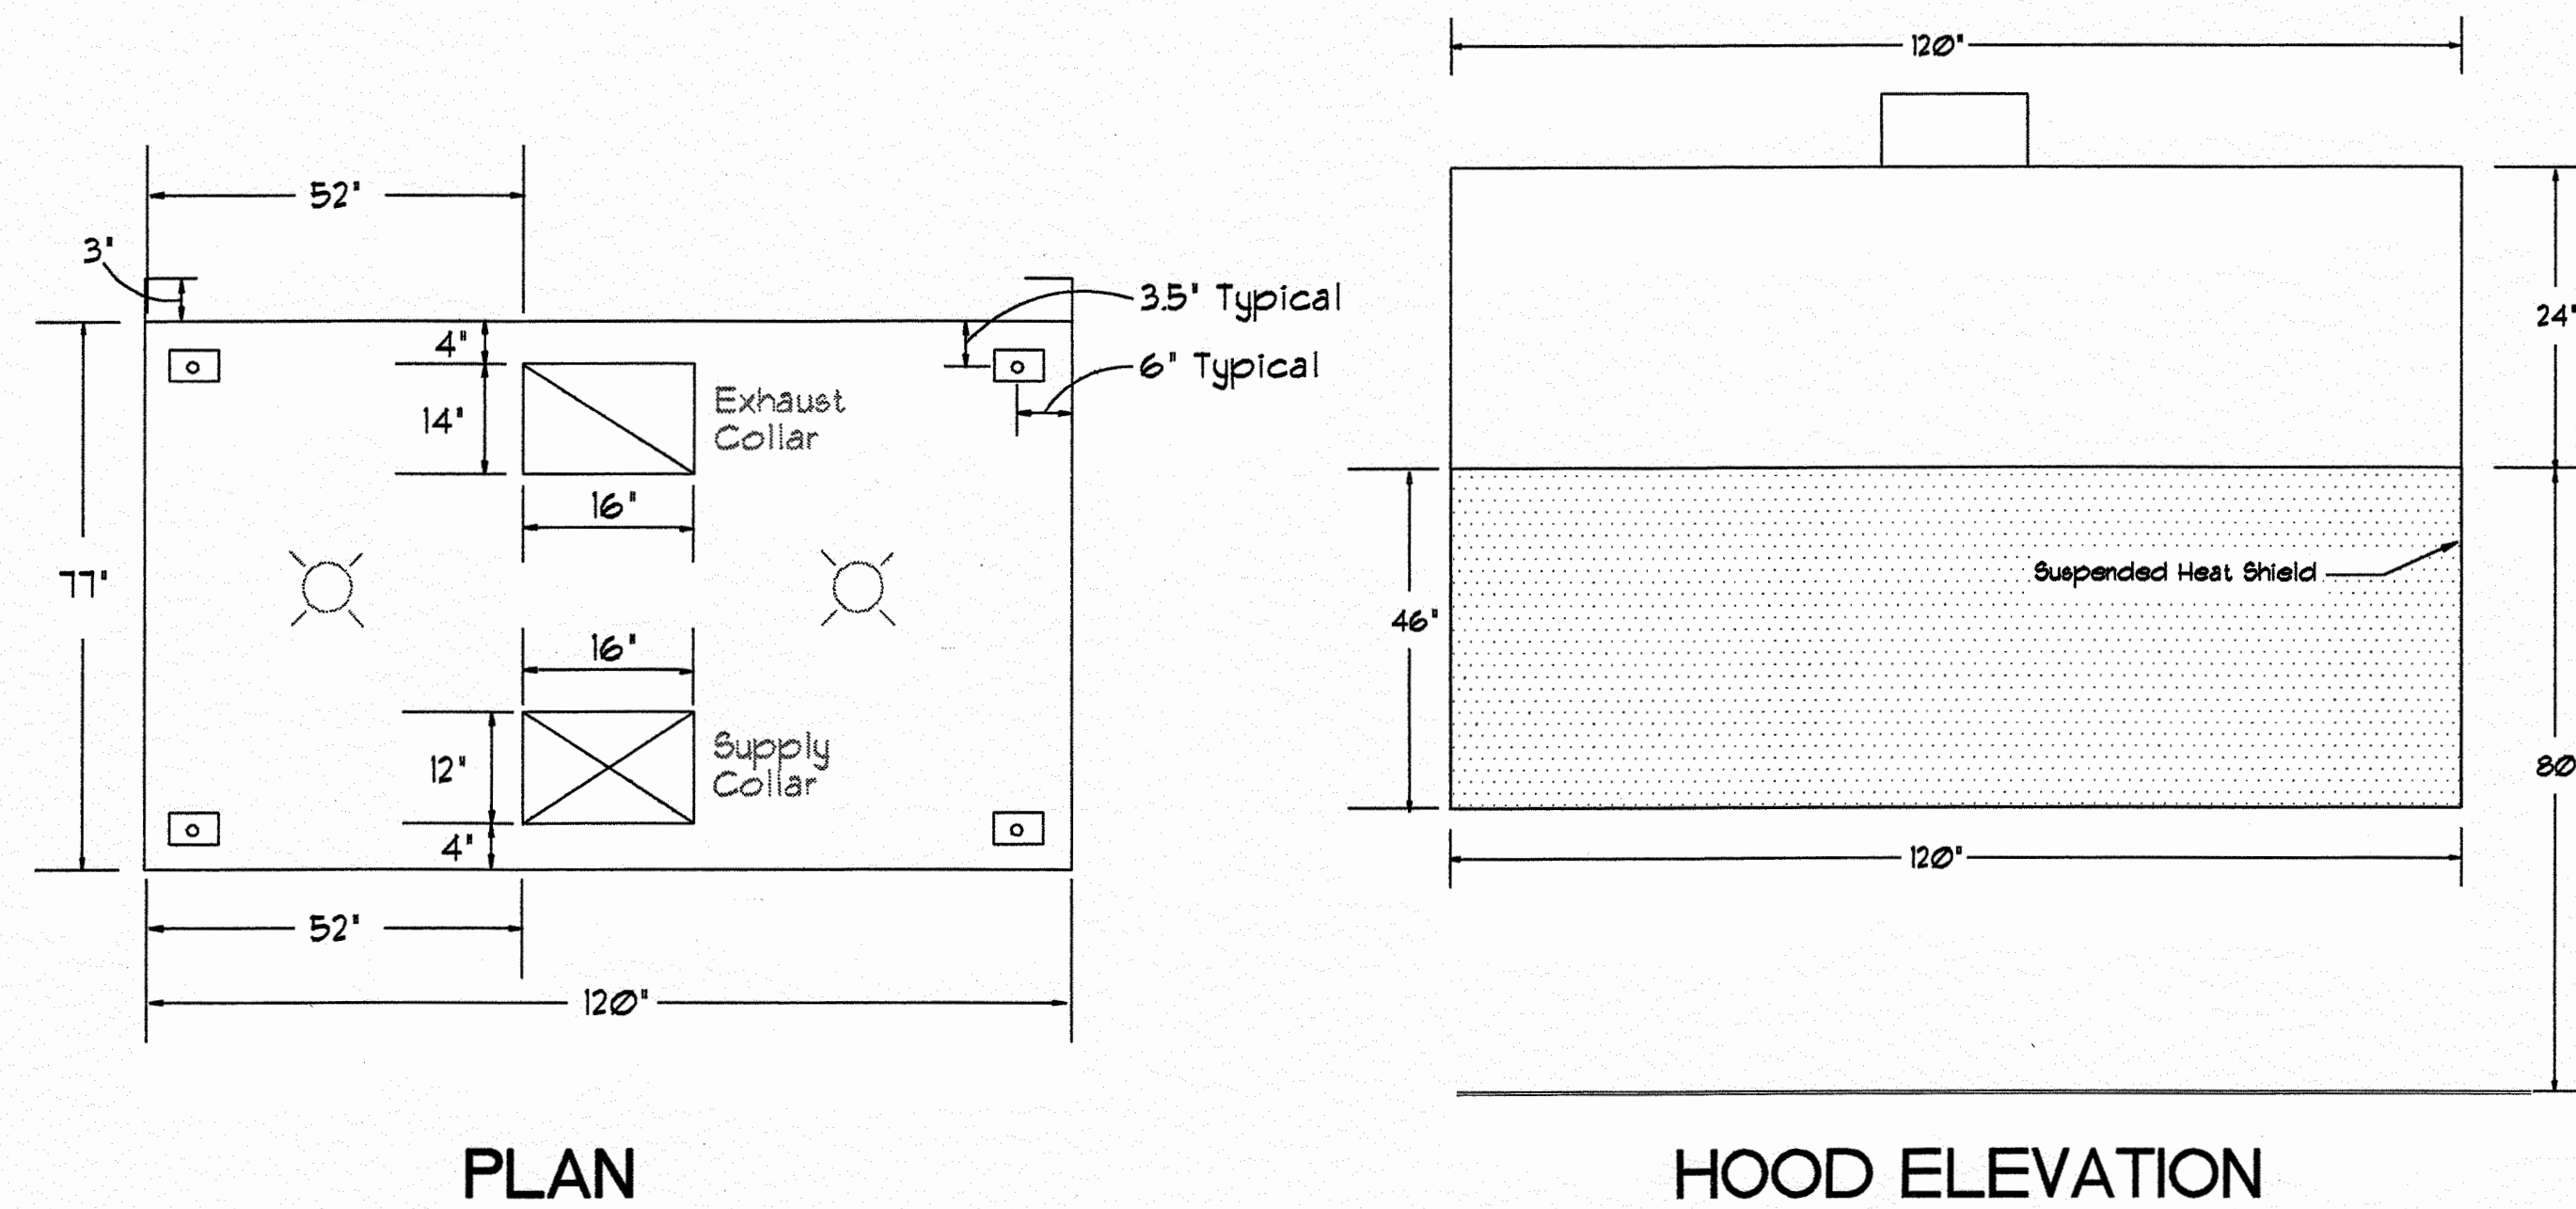

HOOD INFORMATION TABLE

HOOD NO.	MODEL	LENGTH	MAX. COOKING TEMP.	AIR REQUIREMENTS												HOOD CONSTRUCTION	
				EXHAUST RISER						SUPPLY RISER							
				QTY	SIZE		CFM/ RISER	S.P.	TOTAL EXH. CFM	QTY	SIZE		CFM/ RISER	S.P.	TOTAL SUP. CFM		
				W	L						W	L					
1	10' -HP	10' - 0'	400 DEG.	1	14'	16'	2650	.75	2650	1	12'	16'	1800	.50	1800		NFPA 96 18 GA. ST. ST.

HOOD INFORMATION TABLE

HOOD NO.	FIRE CABINET	FILTERS				LIGHTS			FIRE SYSTEM			HOOD WEIGHT
		QTY	HT	LEN	TYPE	QTY	TYPE	WIRE GUARD	TYPE	SIZE (GALLON)	LOCATION	
1	None	4	16	25	ALUM. BAFFLE	2	VAPOR PROOF	NO		BY M.C. AS REQ'D. BY STATE & LOCAL AUTHORITIES		930 POUNDS

FAN INFORMATION TABLE

FAN UNIT NUMBER	FAN UNIT MODEL NUMBER	EXHAUST FAN								SUPPLY FAN							
		MODEL	TAG	CFM	S.P.	RFM	H.P.	PHS	VOLT	BLOWER MODEL/ HOUSING MODEL	TAG	CFM	S.P.	RFM	H.P.	PHS	VOLT
EF-2	EVS COMBOFAN CESF-C	180V6B	1	2650	.75	1000	3/4	3	115	SF-1	1	1800	.50	750	1/3	1	115

CURB TABLE

FAN UNIT NUMBER	CURB SIZE	RAIL	TRUNKLINE	GREASE CUPS	HINGED CURB
1	25' x 68' x 12'	BY OTHERS	23' x 11' x 109'	YES	YES

APPROVALS

NSF #1520
UL MH 18000 (N) EVCW.
BOCCA #86-102
SBCCI #8518
NFPA 96 CONSTRUCTION

TYPICAL INSTALLATION
ACW WALL HOOD + CESF ROOF TOP PACKAGE

SCALE	NO SCALE
DRAWN	YALE
CHECKED	J.W.
DATE	08-13-97
ISSUED FOR	GENERAL USE
DATE	
REVISIONS	

MIDDLEBY MARSHALL OVEN VENTILATION SYSTEM
for #360 OVENS
10' HOOD




EVS SYSTEMS
SUITE 202
350 OLD WOODWARD
BIRMINGHAM, MI. 48009
248.258.5444 FAX 248.258.5898



PJP #
99-1093

NEW STORE LOCATION
6200 W. PARKER RD.
PLANO TX.

COPYRIGHT © PAPA JOHN'S INTERNATIONAL, INC.
1999 - ALL RIGHTS RESERVED

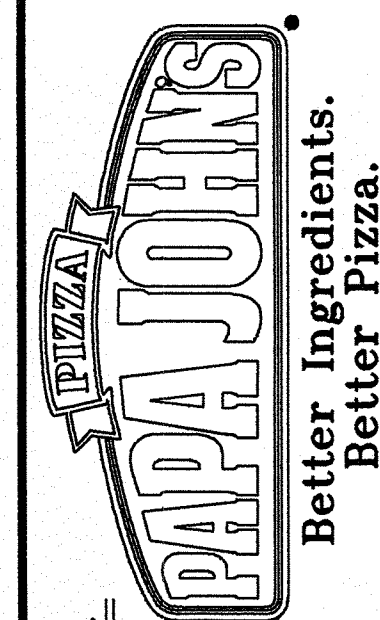

PAPA JOHN'S INTERNATIONAL, INC.

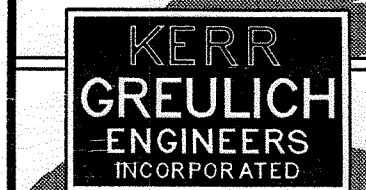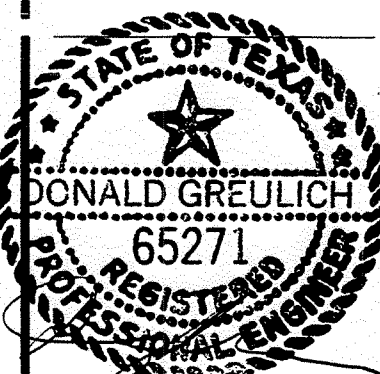11492 BLUEGRASS PARKWAY
LOUISVILLE, KENTUCKY 40294KERR - GREULICH
ENGINEERS, INC.
1534 ORMSBY STATION CT.
LOUISVILLE, KY 40223
PHONE: (502) 426-9467
FAX: (502) 426-2945NEW PAPA JOHN'S PIZZA STORE:
6200 W. PARKER RD.
PLANO TX.

DATE: 2/15/99

DATE REVISED

SHEET TITLE

LOWER LVL. ELEC. PLAN
UPPER LVL. ELEC. PLAN
SCHEDULE
NOTES

SHEET NUMBER

ELECTRICAL LEGEND

- ⊗ LIGHTING AND/OR APPLIANCE PANELBOARD - RECESS MOUNTED.
⊗ FLUORESCENT LIGHTING FIXTURE - LETTER REFERS TO FIXTURE TYPE REFER TO LIGHT FIXTURE SCHEDULE.
⊗ DISCONNECT SWITCH
⊗ MOTOR OUTLET
⊗ JUNCTION BOX OR OUTLET BOX CONCEALED ABOVE CEILING
⊗ WALL OR CEILING MOUNTED EMERGENCY EXIT LIGHTS
⊗ WALL MOUNTED EMERGENCY LIGHT FIXTURE
⊗ ELECTRIC SMOKE DETECTOR
⊗ DUCT MOUNTED PHOTOELECTRIC SMOKE DETECTOR, 120 VAC.
⊗ DUPLEX OUTLET 20 A. 125 VOLT RECEPTACLE. MOUNTING HEIGHT REFERS TO CENTER LINE OF BOX.
⊗ DOUBLE DUPLEX OUTLET. RECESSED IN CEILING
⊗ TELEPHONE OUTLET
⊗ BELL AND TRANSFORMER
⊗ DOOR BELL BUTTON
⊗ NUMBER IN HEX SYMBOL REFERS TO EQUIPMENT SPECIFIED IN EQUIPMENT SCHEDULE - SEE SHEET A-1.
⊗ 1P, 20AMP 125 VOLT MOTOR RATED TOGGLE SWITCH WITH WEATHER PROOF ENCLOSURE.
⊗ SINGLE POLE SWITCH
⊗ COMPUTER NETWORK OUTLET
⊗ SPECIAL RECEPTACLE
⊗ WP WEATHERPROOF
⊗ GFI GROUND FAULT INTERRUPTOR
⊗ IG ISOLATED GROUND
⊗ 42" MOUNTING HEIGHT ABOVE FINISH FLOOR
⊗ NL NIGHT LIGHT

INDICATES CONDUIT RUN CONCEALED IN WALLS OR ABOVE CEILING.
TICK MARKS INDICATE WIRES - LONG LINES INDICATE PHASE
CONDUCTORS. WIRE SIZES ARE #12 AWG UNLESS NOTED OTHERWISE.

CONDUIT BARS INDICATE CONDUCTORS

— PHASE (HOT)
— NEUTRAL (GROUND)
— EQUIPMENT GROUNDING

GENERAL NOTES:


- A. ELECTRICAL CONTRACTOR SHALL FURNISH AND INSTALL OVEN PLUGS, HUBBELL PLUGS (TWIST LOCKS)/RECEPTACLES COMPLETE. REFER TO INSTRUCTION MANUAL FOR DETAILS.
B. ALL LIGHTING AND SIGN CIRCUIT BREAKERS TO BE "SWITCH GRADE".
C. ELECTRICAL CONTRACTOR SHALL FURNISH AND INSTALL STARTERS FOR ROOF MOUNTED SUPPLY AND EXHAUST FANS (SF-1 AND EF-2) AND START-STOP SWITCH. BOTH SF-1 AND EF-2 SHALL RUN AND STOP TOGETHER AND ARE TO BE CONTROLLED FROM THE SAME SWITCH.
D. ELECTRICAL CONTRACTOR SHALL FURNISH AND INSTALL ALL REQUIRED DISCONNECT SWITCHES AND MOTOR STARTER TO ALL EQUIPMENT.
E. CONNECT GENERAL FLUORESCENT LIGHT FIXTURES TO BRANCH INDICATED. SWITCH LIGHT FIXTURES WITH CIRCUIT BREAKER AT PANELBOARD.
F. ALL ISOLATED GROUND RECEPTACLE CIRCUITS SHALL BE EQUIPPED WITH ISOLATED GROUND CONDUCTOR AND SEPARATE NEUTRAL WIRE.
G. NEUTRAL WIRES FOR ISOLATED GROUND CIRCUITS SHALL NOT BE SHARED WITH OTHER BRANCH CIRCUITS. PROVIDE SEPARATE NEUTRAL WIRE FOR EACH ISOLATED GROUND CIRCUIT.
H. ISOLATED GROUND CIRCUITS SHALL NOT BE ROUTED WITHIN SAME CONDUIT AS GENERAL BRANCH CIRCUIT WIRING. PROVIDE SEPARATE CONDUIT FOR SERVICE TO ISOLATED GROUND CIRCUITS.
I. ISOLATED GROUND RECEPTACLES SHALL UNDER NO CIRCUMSTANCE BE INSTALLED IN COMMON JUNCTION BOX WITH NON-ISOLATED GROUND TYPE RECEPTACLE.

GENERAL CONTRACTOR NOTE:

ELECTRICAL CONTRACTOR SHALL COORDINATE ELECTRICAL SERVICE FOR NEW STORE WITH LOCAL UTILITY COMPANY.

ELECTRICAL SHEET NOTES

- ① 2P, 30AMP, 240V, NEMA 3R FUSIBLE DISCONNECT SWITCH FOR CONNECTION TO COOLER COMPRESSOR, FUSE PER UNIT NAME PLATE.
② JUNCTION BOX WITH MOTOR RATED TOGGLE SWITCH IN WEATHER PROOF ENCLOSURE, FOR CONNECTION TO EVAPORATOR UNIT.
③ 3P, 30AMP, 240V, NEMA 3R FUSIBLE DISCONNECT SWITCH FOR CONNECTION TO ROOF TOP UNIT, FUSE PER UNIT NAME PLATE.
④ ONE (1) TWIST-LOCK OUTLET IN CEILING WITH TWIST-LOCK STRAIN-RELIEF DROP CORD TERMINATING 12" BELOW OUT TABLE HEIGHT IN A SINGLE STANDARD 3-PRONG GROUNDED OUTLET. OUTLET AND CORD SHALL BE PLACED AT THE SAME LOCATION AS THE OUTLETS FOR THE CUT-TABLE HEAT STRIPS.
⑤ MOUNT RECEPTACLE JUST BELOW SHELF HEIGHT. REFER TO ARCHITECT'S DRAWINGS FOR SHELF HEIGHT.
⑥ MOUNT RECEPTACLE UNDER COUNTER TOP.
⑦ NEW THREE PHASE METER SOCKET.
⑧ #2 AWG GROUNDING ELECTRODE BOND TO WATER SERVICE AND BUILDING STEEL PER SECTION 250 OF N.E.C.
⑨ (2) #10, #10 GRND IN 1" C. TO PYLON SIGN BASE.
⑩ (4) #3/0 IN 2" C.
⑪ ELECTRICAL CONTRACTOR SHALL FURNISH AND INSTALL NEW WEATHER HEAD. ELECTRICAL CONTRACTOR SHALL COORDINATE NEW ELECTRICAL SERVICE WITH LOCAL UTILITY COMPANY.
⑫ MOUNT ON UNIT.
⑬ TELEPHONE SYSTEM FURNISHED BY PHONE CONTRACTOR MOUNT ON 24" X 24" X 3/4" PLYWOOD BACK BOARD. BOTTOM OF BACKBOARD AT 72" A.F.F. BACK BOARD BY E.C.
⑭ (4) #12 DROP CORD TO PIZZA OVENS.
⑮ HUBBELL #2413 AND HUBBELL #2411.
⑯ JUNCTION BOX SUPPORTED ABOVE CEILING WITH STRESS RELIEVER AND COVER.
⑰ JUNCTION BOX FOR CONNECTION TO AWNING LIGHTING. FIELD VERIFY EXACT MOUNTING LOCATION AND CONNECTION REQUIREMENTS PRIOR TO ROUGH-IN.
⑱ JUNCTION BOX FOR CONNECTION TO PAPA JOHN'S SIGN. FIELD VERIFY EXACT MOUNTING LOCATION AND CONNECTION REQUIREMENTS PRIOR TO ROUGH-IN.
⑲ START AND STOP SWITCHES FOR EF-2 AND SF-1. PROVIDE WIRING AS REQUIRED.
⑳ DUPLEX RECEPTACLE INSTALLED FLUSH IN CEILING FOR WINDOW SIGNAGE. COORDINATE EXACT LOCATION WITH OWNER PRIOR TO ROUGH-IN.
㉑ DUPLEX RECEPTACLE INSTALLED FLUSH IN CEILING FOR CCTV MONITOR. COORDINATE EXACT LOCATION WITH OWNER PRIOR TO ROUGH-IN.
㉒ SIGNAGE/ LIGHTING TIME CLOCK SHALL BE FOUR POLE, 7 DAY TIMER WITH QUARTZ CARRY-OVER, PARAGON MODEL NO. 7617-56 OR EQUAL.
㉓ DUCT MOUNTED SMOKE DETECTOR INTERLOCK WITH FAN MOTOR TO SHUT-OFF FAN WHEN IN ALARM. SUPPLY REMOTE TEST SWITCH AND INDICATOR. FIELD VERIFY MOUNTING LOCATION.
㉔ 3P, 60AMP, 240V, NEMA 3R FUSIBLE DISCONNECT SWITCH FOR CONNECTION TO ROOF TOP UNIT, FUSE PER UNIT NAME PLATE.
㉕ ELECTRICAL CONTRACTOR SHALL INSTALL DUPLEX RECEPTACLE 6" BELOW LAY-IN CEILING AND 15" RADIUS MINIMUM FROM GAS-FIRED OVEN FOR CONNECTION TO CARBON MONOXIDE DETECTOR. GENERAL CONTRACTOR SHALL PROVIDE AND INSTALL DETECTOR.
㉖ VERIFY WITH OWNER EXACT LOCATION AND MOUNTING HEIGHT OF EMERGENCY EGRESS LIGHTING ABOVE DOOR AND PLATE GLASS.
㉗ SERVICE DISCONNECT SWITCH - 3P, 200 AMP, 240V SERVICE RATED SWITCH, NEMA 3R ENCLOSURE, PROVIDE WITH SET OF 200 AMP, RK1 FUSES.

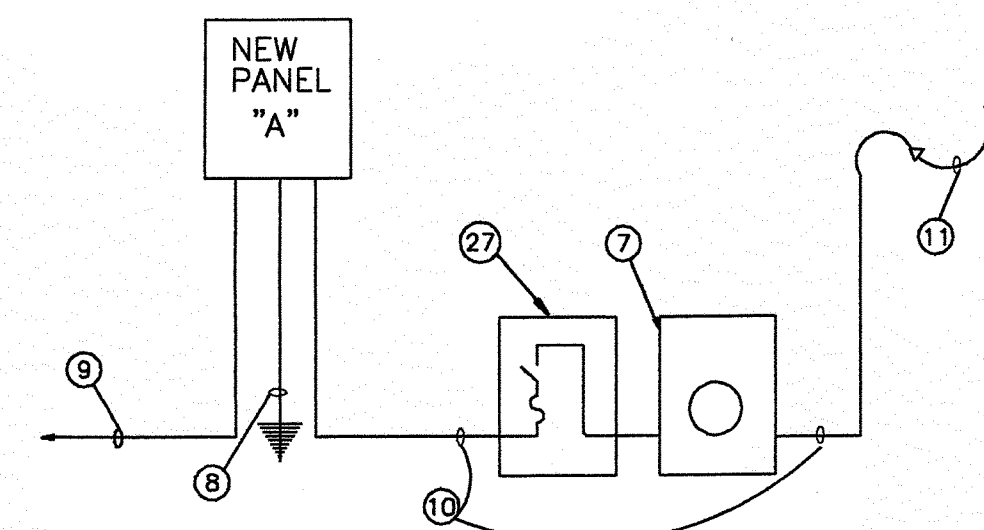

TYP. SERVICE RISER DIAGRAM

ELECTRICAL NOTE :

ELECTRICAL SERVICE AND SYSTEM DETAILED IS DESIGNED BASED ON 120 / 208 VOLT THREE PHASE SERVICE. ELECTRICAL CONTRACTOR TO VERIFY AVAILABLE SERVICE. MAKE NECESSARY MODIFICATIONS AS REQUIRED.

NOTE: AIC RATING FOR PANEL AND ALL BRANCH CIRCUIT BREAKERS. CONTRACTOR SHALL OBTAIN THE AVAILABLE FAULT CURRENT AT THE SERVICE POINT FROM THE LOCAL UTILITY. UPGRADE THE AIC RATING OF THE PANEL AS NECESSARY.

LIGHT FIXTURE SCHEDULE


MARK	DESCRIPTION	LAMP	MODEL NO.	MANUF.
A	2X4 LAY-IN FLUORESCENT	4 - 34W T 12 CW	2SPC-440QW-A12125-120-ES	LITHONIA
B	NOT USED.			
C	WALL MOUNTED BRACKET	1 - 60 WATT	WGCW601-120	LITHONIA
D	EMERGENCY EXIT LIGHT W/ BATTERY BACK-UP	2 - 7.2W AC, 6V DC	H2MSW1R120/277	LITHONIA
E	EMERGENCY DUAL LAMP W/BATTERY BACK-UP, INSTALL 84" A.F.F.	HIT 5.4W	ELM2	LITHONIA
E1	EMERGENCY DUAL LAMP W/BATTERY BACK-UP, REMOTE CAPABILITY FOR 24W/90 MIN. INSTALL 84" A.F.F.	HIT 7.2W	6ELM2P	LITHONIA
F	EMERGENCY EGRESS OUTDOOR REMOTE HEAD	1-9W HIT	ELAWXHQ806	LITHONIA

SERVICE LOAD CALCULATION (PANEL "A")				
TYPE LOAD	CONN. LOAD	DMD. FAC.	DMD. LOAD	
LIGHTING	8,476 VA	X	125%	10,595 KVA
GENERAL RECEPTACLE	(14,220-10,000)/2 + 10,000	X	100%	12,110 KVA
KITCHEN EQUIPMENT	11,374 VA	X	65%	7,393 KVA
MECHANICAL EQUIPMENT	23,490 VA	X	100%	23,490 KVA
				53,588 KVA
				120/208V, 3φ = 148.85 AMPS

PANEL A		VOLTS-120/208 3φ 4 WIRE MOUNTING-RECESSED		22,000 AIC(SEE NOTE) FEEDER SIZE - #3/0, 2" C.		MAIN CAPACITY - 225 AMPERES MAIN CONNECTION - MAIN BREAKER 200A	
CCT. NO.	ITEM FED	DIST. WATTS	WIRE SZ	CIRCUIT BREAKER	NEUTRAL	CIRCUIT BREAKER	NEUTRAL
1	COOLER COMPRESSOR	1165	12/20	2 QOB	A	2 20 12 832	PIZZA OVEN # 1
3	COOLER EVAP. UNIT	456	12/20	1	B	2 20 12 832	PIZZA OVEN # 2
7	HEAT STRIP	840	12/20	2	A	1 20 12 540	PREP TABLE
9	HEAT STRIP	840	12/20	2	C	1 20 12 500	BEVERAGE CASE
11	HEAT STRIP	840	12/20	2	C	1 20 10 1600	PYLON SIGN
13	LIGHTING	1600	12/20	1	A	1 20 12 1440	TELEPHONE SYSTEM
15	COOLER LIGHTS	200	12/20	1	B	1 20 12 1440	COMPUTER RECEPT.
17	COMPUTER RECEPT.	1440	12/20	1	C	1 20 12 1440	COMPUTER RECEPT.
19	COMPUTER RECEPT.	1440	12/20	1	B	1 20 12 1440	COMPUTER RECEPT.
21	COMPUTER RECEPT.	1440	12/20	1	A	1 20 12 1440	COMPUTER RECEPT.
23	NIGHT LIGHTING	800	12/20	1	C	3 30 10 1998	RECEPTACLES
25	LIGHTING	1600	12/20	1	A	1 20 12 1440	RECEPTACLES
27	LIGHTING	1500	12/20	1	B	1 20 12 1080	RECEPTACLES
29	AWNING LIGHTING	1600	12/20	1	C	1 20 12 1440	RECEPTACLES
31	PAPA JOHN'S SIGN	1176	12/20	1	A	1 20 12 1440	RECEPTACLES
33	WINDOW SIGNS	720	12/20	1	B	1 20 12 1440	RECEPTACLES
35	CCTV CAMERA	360	12/20	1	C	1 20 12 1440	RECEPTACLES
37	EF-2	1656	12/20	1	A	1 20 12 1440	RECEPTACLES
39	MUJAU-101	1656	12/20	1	B	1 20 12 1440	RECEPTACLES
41	SPARE		20/1		C	1 20	SPARE


- * ELECTRICAL CONTRACTOR TO PROVIDE BREAKER W/ "LOCK-ON" DEVICE.
** ROUTE BRANCH CIRCUITS THROUGH WALL MOUNTED TIME CLOCK FOR CONTROL
*** "SWITCH-DUTY" RATED CIRCUIT BREAKERS

NEW ELECTRIC METER AND OVERHEAD SERVICE MAST. REFER TO DIAGRAM.

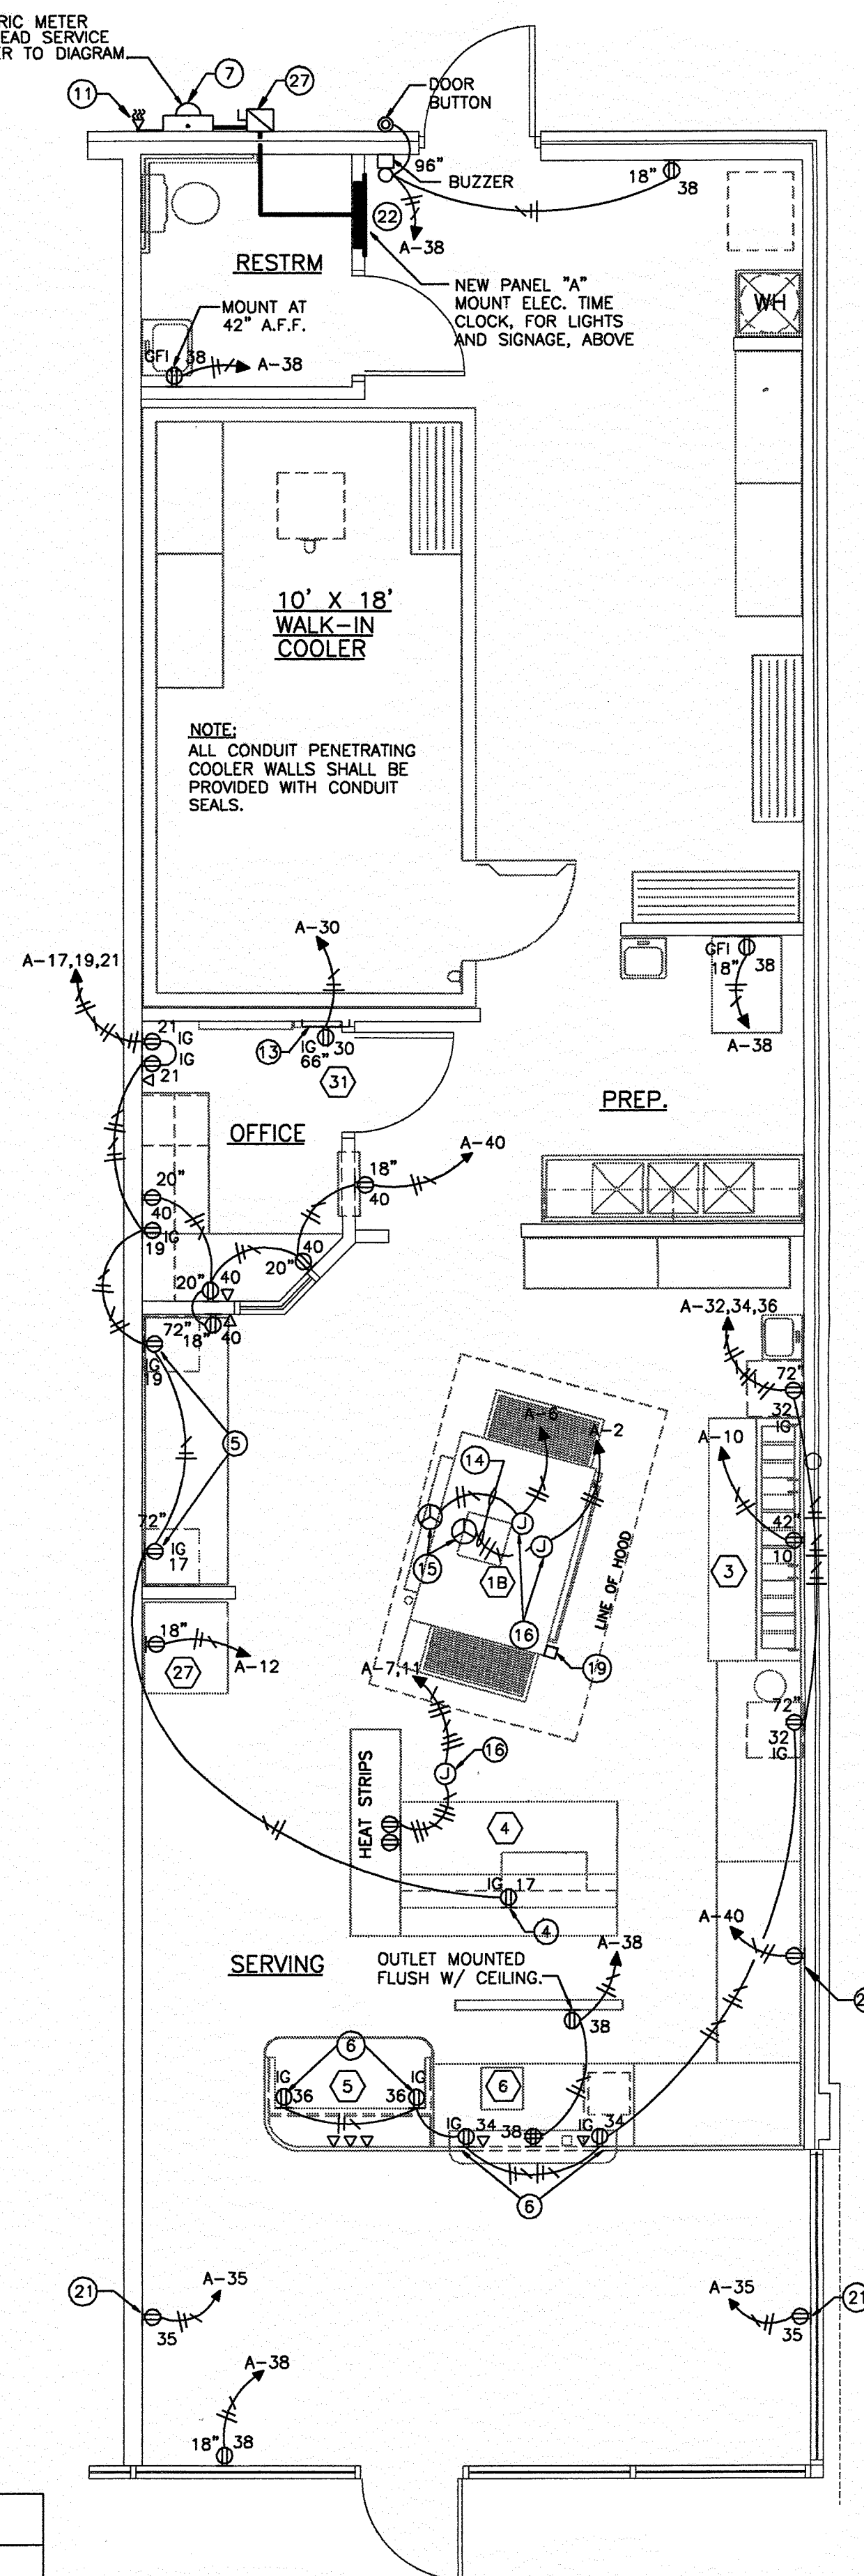

LOWER LEVEL ELEC. PLAN

SCALE: 1/4" = 1'-0"

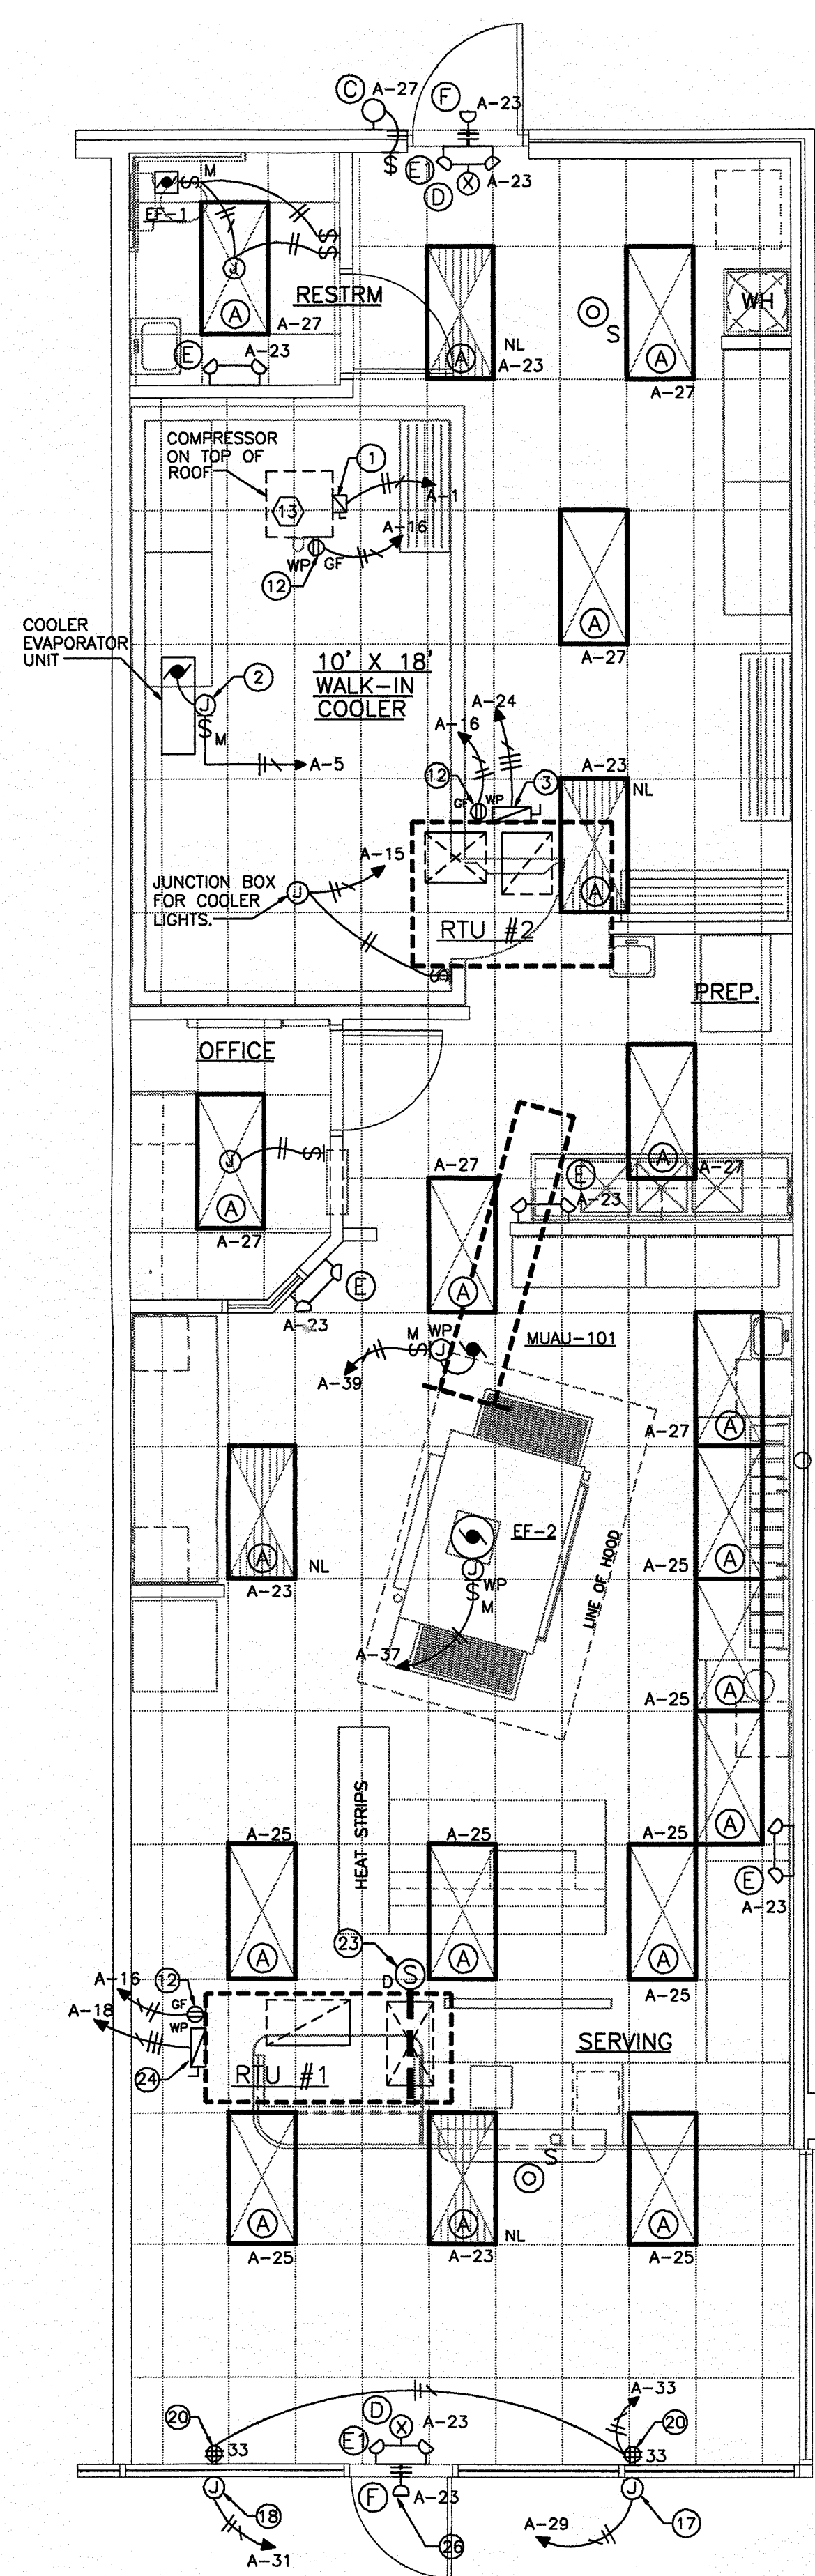ELECTRICAL DESIGN BASED UPON
1996 NATIONAL ELECTRICAL CODE

UPPER LEVEL ELEC. PLAN

SCALE: 1/4" = 1'-0"

PJP #
99-1093NEW STORE LOCATION
6200 W. PARKER RD.
PLANO TX.COPYRIGHT © PAPA JOHN'S INTERNATIONAL, INC.
1999 - ALL RIGHTS RESERVED