
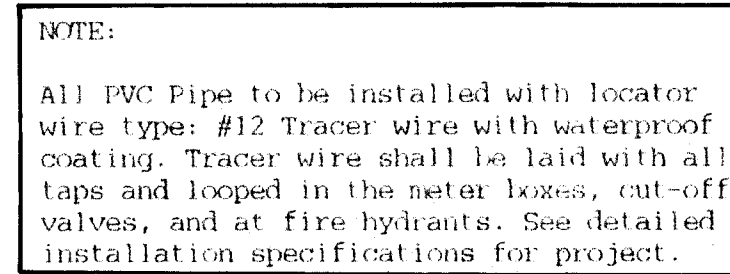



1. SEWER INSTALLATION TO BE DONE IN ACCORDANCE WITH STDS. & SPECS. OF THE CITY OF REIDSVILLE.
2. WATER INSTALLATION TO BE DONE IN ACCORDANCE WITH STDS. & SPECS. OF DAN RIVER WATER, INC.

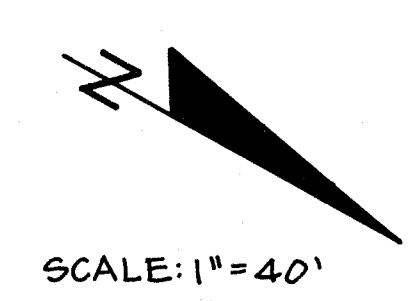

N.C. HWY. 14

JAMES F. FINCH

AS-BUILT 1-11-11

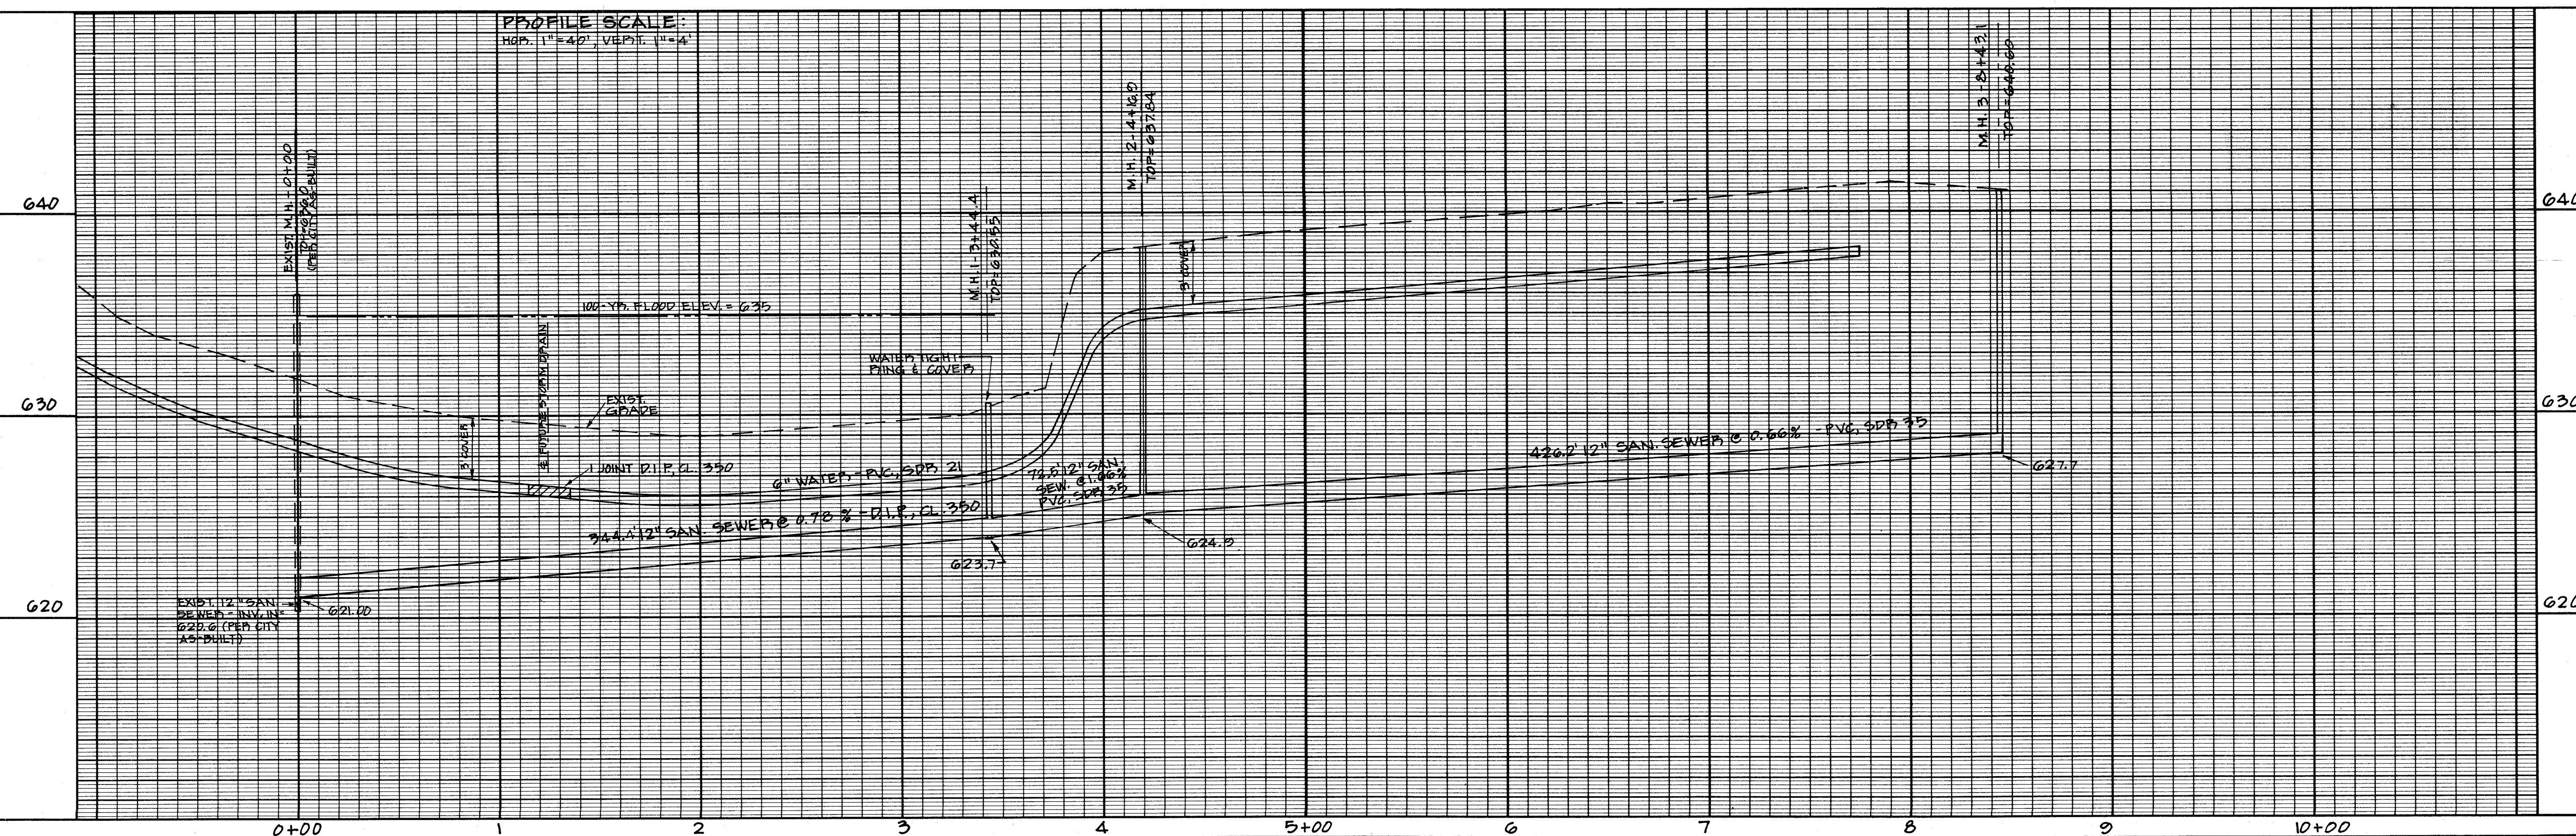

WILLIAM E. MITCHELL ASSOC.
CIVIL ENGINEERING • SURVEYING • LAND PLANNING
1903-C ASHWOOD COURT
GREENSBORO, NC 27455 (336) 540-0060

UTILITY PLAN - PROFILE
STALLINGS COLLISION CENTER OF REIDSVILLE
N. C. HWY. 14
REIDSVILLE TOWNSHIP
REIDSVILLE, NORTH CAROLINA - ROCKINGHAM COUNTY

Sheet No.

of 1 Sheets

1001