

(E) EXISTING TO REMAIN
SEC SECTION

~~✖~~ ELECTRICAL CONTRACTOR SHALL COMPLY AND PROVIDE REDUNDANT GROUND AND WIRING AS REQUIRED PER SECTION 517.13 NEC 2011 FOR PATIENT CARE ROOMS.

ALL RECEPTACLES IN EXAM/PATIENT CARE ROOMS SHALL BE HOSPITAL GRADE.

REMOVE ALL EXISTING LIGHT FIXTURES WHEN DIRECTED BY GENERAL CONTRACTOR. MAINTAIN EXISTING LIGHTING FOR CONSTRUCTION.

COORDINATE ADDITIONAL CONDUIT REQUIREMENT WITH CONSULTANT DRAWINGS.

~~11~~ ELECTRICAL CONTRACTOR SHALL COMPLY AND PROVIDE REDUNDANT GROUND AND WIRING AS REQUIRED PER SECTION 517.13 NEC 2011 FOR PATIENT CARE ROOMS.

ALL RECEPTACLES IN EXAM/PATIENT CARE ROOMS SHALL BE HOSPITAL GRADE.

REMOVE ALL EXISTING LIGHT FIXTURES WHEN DIRECTED BY GENERAL CONTRACTOR. MAINTAIN EXISTING LIGHTING FOR CONSTRUCTION.

COORDINATE ADDITIONAL CONDUIT REQUIREMENT WITH CONSULTANT DRAWINGS.

Applicable to this drawing only

- | | |
|---|---|
| 1 | PROVIDE FLUSH FLOOR POWER POKE THRU HUBBELL P775DBLA OR APPROVED EQUAL. SEAL ANNULAR SPACE WITH FIRE RATED CAULKING. PROVIDE ¾" CONDUIT IN CEILING SPACE TO NEAREST WALL. COORDINATE FLOOR FINISH WITH ARCHITECT. |
| 2 | PROVIDE FLUSH FLOOR TELE/DATE POKE THRU HUBBELL S184PRT1 OR APPROVED EQUAL. SEAL ANNULAR SPACE WITH FIRE RATED CAULKING. PROVIDE ¾" CONDUIT IN CEILING SPACE TO NEAREST WALL. COORDINATE FLOOR FINISH WITH ARCHITECT. |
| 3 | EXISTING TO REMAIN 208Y120V, 3PH, 4WIRE DOUBLE SECTION PANEL. REFER TO PANEL SCHEDULE AND RISER DIAGRAM FOR MORE INFORMATION. |

RESTAURANTS • RETAIL • RESIDENTIAL

Written dimensions on these drawings shall have precedence over scale dimensions. Contractors shall verify and be responsible for all dimensions and conditions on the job and this office must be notified of any variation from the dimensions and conditions shown by these drawings.

**SUPERSEDED INSPECTION PROJECT:
THE DESIGNER(S) OF RECORD HAVE
READ THE PRINCE WILLIAM COUNTY
COMMERCIAL PARTIAL PERMITTING
PROCESS FOR SHELL BUILDINGS
POLICY AND AGREE TO THE
CONDITIONS AND RESPONSIBILITIES
OF THE POLICY AS IT RELATES TO
PLANS AND PERMITS FOR SHELL AND
TENANT BUILD-OUTS FOR
SUPERSEDED PROJECTS.**

ISSUED SETS:

NO.	DATE	DESCRIPTION
	03/07/19	PERMIT SET

OWNER:

**WOODBRI
COMMONS, LLC**

AHMET AKSOYLU
703.335.6060

PROJECT:

**WOODBRI
THERAPY OFFICE**

DRAWING:

**POWER
PLAN
ELECTRICAL**

ARCHITECT:	DRAWN BY:
JHM	DA, RH, HG, DT


SCALE:
AS NOTED

DATE: _____
DATE: _____

PROJECT NO:
PROJ NO

[illegible]

E1.2

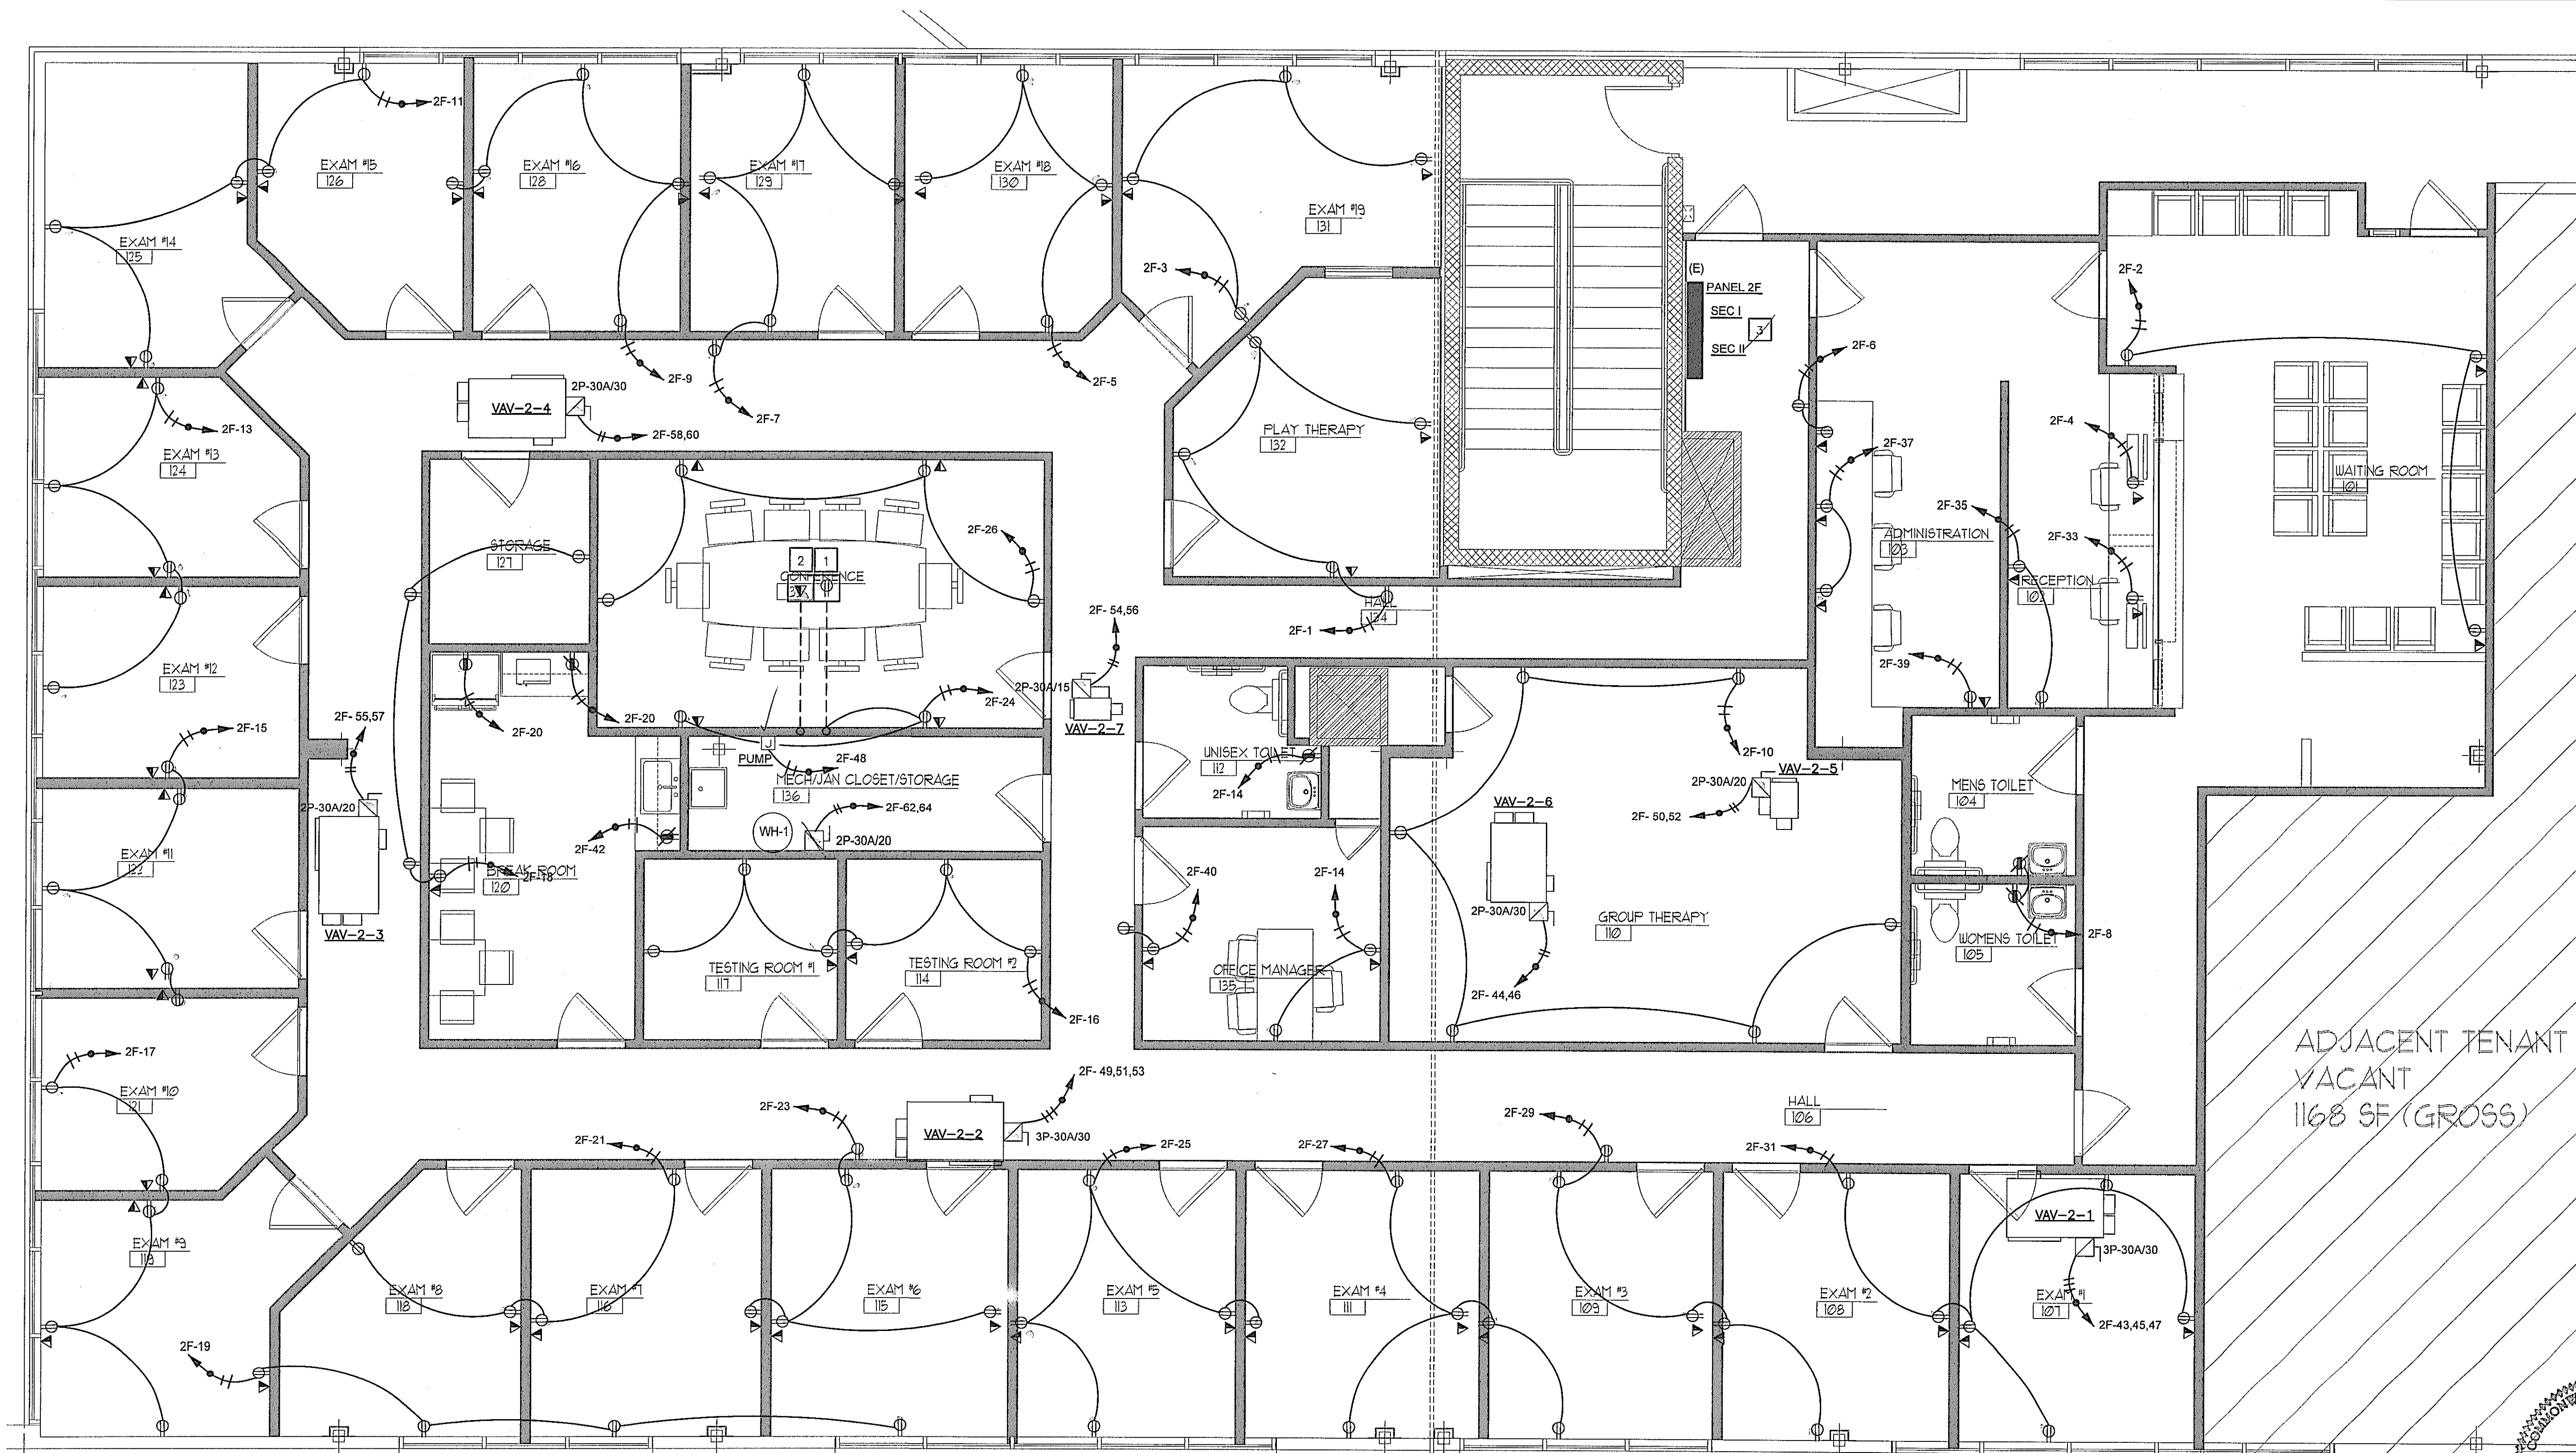

ADJACENT TENANT
VACANT
1168 SF (GROSS)

01 POWER PLAN - ELECTRICAL
1/4"=1'-0"

COUNTY OF PRINCE WILLIAM
REVIEWED
BUILDING DEVELOPMENT DIVISION

APR 29 2019

ELECTRICAL
ALL WORK SHALL COMPLY WITH 20
VA UNIFORM STATEWIDE BUILDING CODE



Gill Engineering Group

Gill Engineering Group Plc
Mechanical Electrical Plumbing
9161 Liberia Ave, Suite 204B
Manassas, Virginia 20110
703 688 2049 . www.gillengg.com

