

Project
REUNION RESTAURANT
639 Lorimer St
Brooklyn, 11211

Architects
OGAWA/DEPARDON ARCHITECTS
77 Chambers - 2nd Floor
New York, NY 10007
212.627.7390 / 212.627.9681

NOTES:
- MASTER SWITCH TO BE PROVIDED TO
CONTROL ALL THE KITCHEN LIGHTS.

- LEGEND:
- EXHAUST FAN (MIN. 50CFM)
 - FLOOR OUTLET
 - DUPLEX OUTLET
 - QUAD OUTLET
 - GROUND FAULT INTERRUPTER
 - DEDICATED APPLIANCE OUTLET
 - HANGING OUTLET (COILED)
 - DATA
 - TELEPHONE
 - FLOOR TELEPHONE OUTLET
 - TELEVISION POINT
 - HEAT DETECTOR
 - SMOKE DETECTOR/CARBON MONOXIDE MONITOR

3. ISSUED FOR FILING	2023.05.31
2. ISSUED FOR FILING	2023.05.23
1. ISSUED FOR FILING	2023.05.01


Project:
REUNION RESTAURANT
639 Lorimer St
Brooklyn, NY 11211

ELECTRICAL PLAN

DATE: 2023.05.05
PROJECT No.: 2209
SCALE: AS NOTED
DRAWING BY: M.K.
CHK BY: K.O. & G.D.
DWG No:

E-102.00

FILE No: Pg. 6 of 6

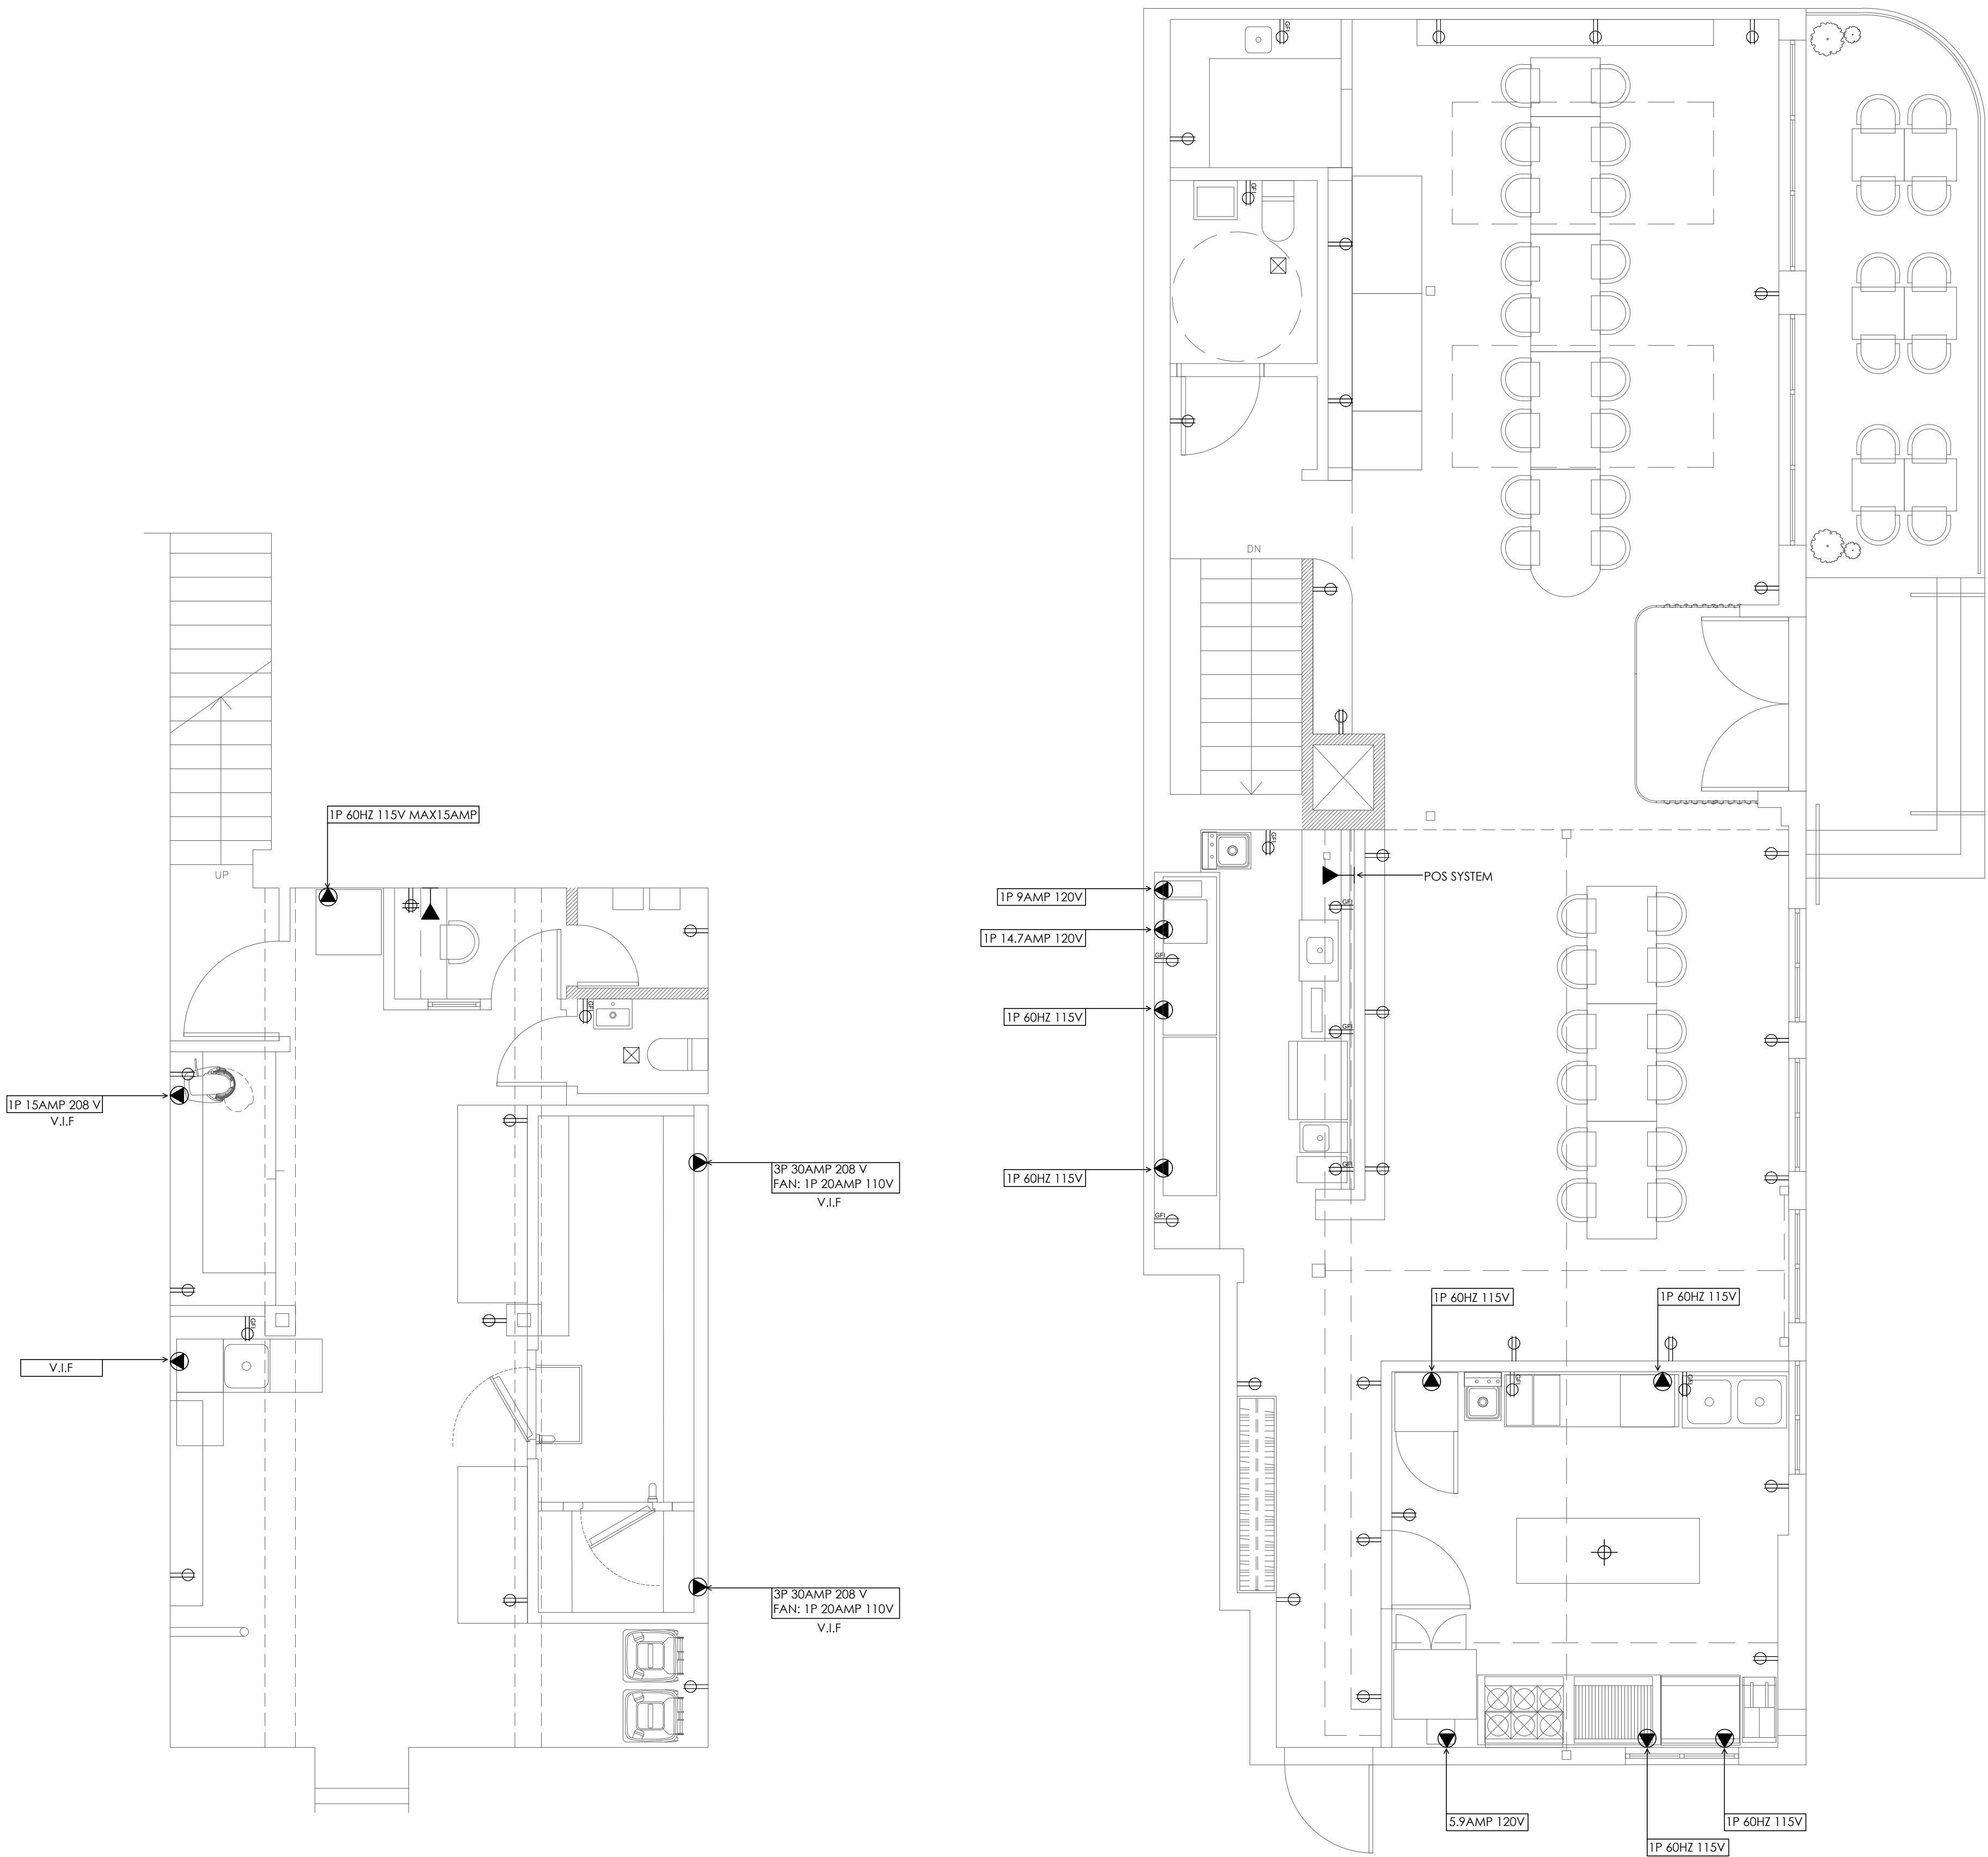

1 ELECTRICAL PLAN BASEMENT
SCALE: 1/4" = 1'-0"

2 ELECTRICAL PLAN GROUND FL
SCALE: 1/4" = 1'-0"