



ASHLEY HOMESTORE | ASHLEY OUTLET

ROSWELL, NM

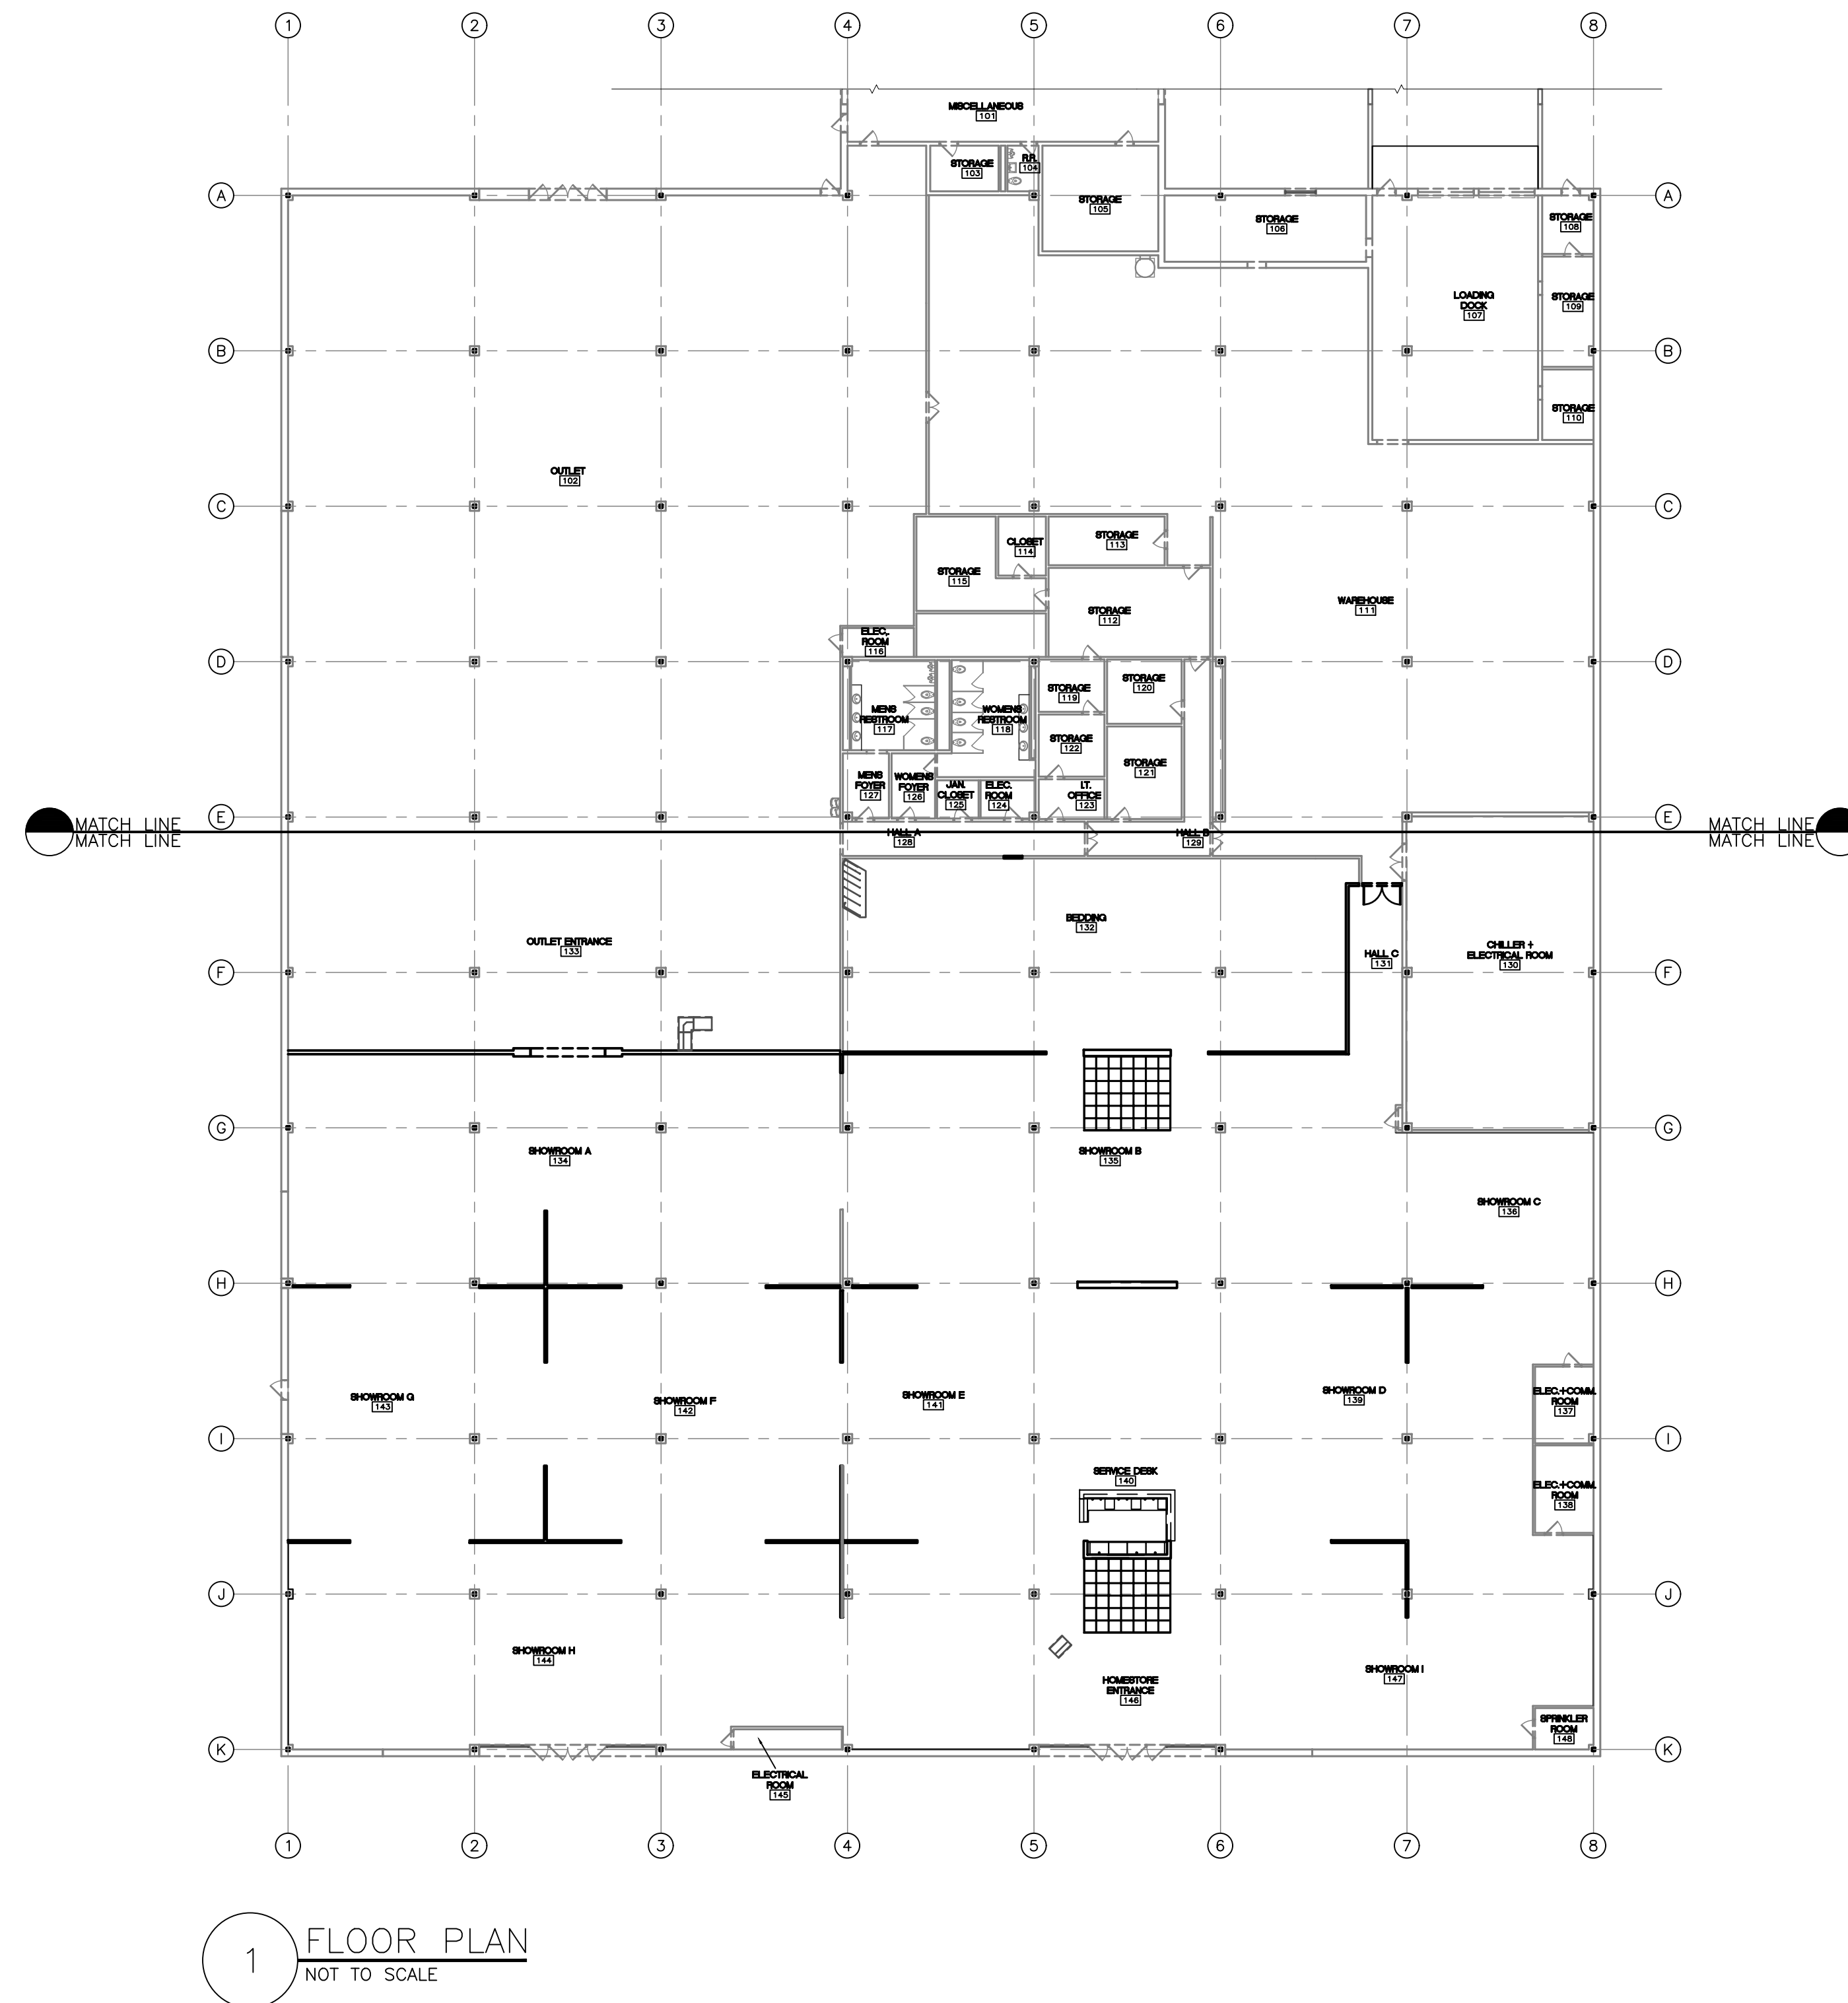

SHOWROOM DIAGRAM- FOR REFERENCE ONLY

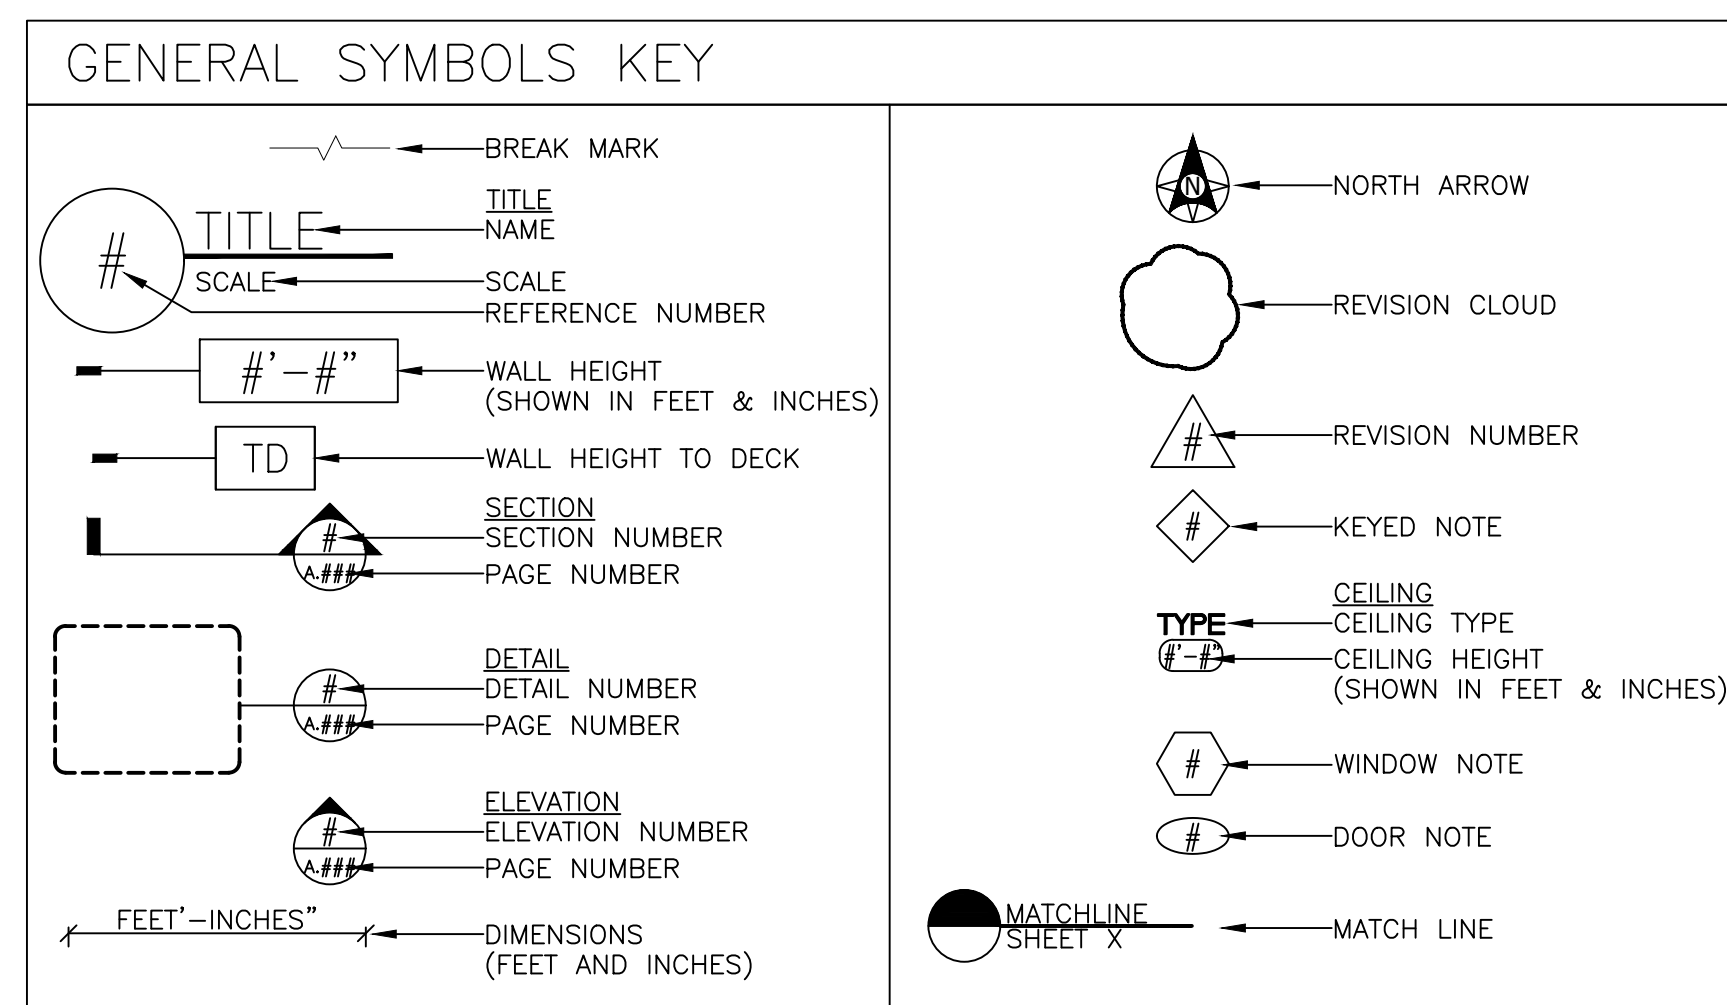

SHEET INDEX	
G-001	GENERAL INFORMATION
A-101	DEMOLITION PLAN
A-102	REFLECTED CEILING DEMOLITION PLAN
A-103	CONSTRUCTION PLAN
A-105	REFLECTED CEILING PLAN
A-106	
A-107	
A-108	
E-101	POWER PLAN AND ELEVATIONS
E-102	COMMUNICATIONS PLAN
E-103	LIGHTING PLAN
I-101	FLOORING PLAN
I-102	MOLDING PLAN
I-103	PRELIMINARY PAINT PLAN
L-701	MOLDING DETAILS
I-702	PRELIMINARY PAINT DETAILS
A-601	SCHEDULES
A-602	SCHEDULES
A-701	DETAILS/ELEVATIONS/SECTIONS
A-702	DETAILS/ELEVATIONS/SECTIONS

OWNER CONTACT INFORMATION	
OWNER:	JOE D. JENKINS
PHONE:	575-706-1112
EMAIL:	JAMCOINDUSTRIES@YAHOO.COM
GC:	CARL JOHNSON
PHONE:	817-874-0859
EMAIL:	CLJOHNSONTX@GMAIL.COM

DESIGN CONTACT INFORMATION	
CONSTRUCTION DESIGNER:	
JESSICA SLOWIAK	
PHONE:	608-323-1618
EMAIL:	JSLOWIAK@ASHLEYFURNITURE.COM
FAX:	608-323-3475
ADDRESS:	ASHLEY FURNITURE CHAPEL HILL ONE ASHLEY WAY ARCADIA, WI 54612
FACADE DESIGNER:	
MARK HERDT	
PHONE:	608-323-6828
EMAIL:	MHERDT@ASHLEYHOMESTORE.COM
FAX:	608-323-3475
ADDRESS:	ASHLEY FURNITURE CHAPEL HILL ONE ASHLEY WAY ARCADIA, WI 54612
MERCHANDISE DESIGNER:	
TINA SHARPE	
PHONE:	813-603-5488
EMAIL:	CSHARPE@ASHLEYFURNITURE.COM
ADDRESS:	ASHLEY FURNITURE 1670 E 8TH AVE. TAMPA, FL 33605

DRAWINGS NOT TO BE USED FOR CONSTRUCTION

[illegible]

GENERAL DEMOLITION NOTES

A. GENERAL CONTRACTOR SHALL BECOME FAMILIAR WITH THE BUILDING AND SHALL VERIFY ALL ITEMS TO BE REMOVED. THIS DRAWING IS PROVIDED FOR REFERENCE ONLY. THE OWNER AND THE GENERAL CONTRACTOR SHALL MEET TO VERIFY AND AGREE UPON THE FULL EXTENT OF DEMOLITION REQUIRED FOR NEW CONSTRUCTION AND REMODELING.

B. GENERAL CONTRACTOR SHALL SAVE AND STORE ITEMS INDICATED TO BE REMOVED IN AN ON-SITE OWNER-DESIGNATED LOCATION TO PREVENT DAMAGE.

C. GENERAL CONTRACTOR SHALL REMOVE ALL EXISTING FLOORING AS NOTED ON PLAN AND DISPOSE OF PROPERLY. REMOVE BOND BREAKERS: WAX, GREASE/OILS, ADHESIVES, AND OTHER RESIDUE/DEBRIS. REMOVE ALL MISCELLANEOUS OBSTRUCTIONS.

D. GENERAL CONTRACTOR SHALL DISPOSE OF ITEMS DESIGNATED HEREIN FOR SALVAGE BY THE OWNER THAT OWNER-IN-FACT DECIDES NOT TO RETAIN.


E. GENERAL CONTRACTOR SHALL BE RESPONSIBLE FOR EXT OF EXISTING MECHANICAL AND ELECTRICAL DEMOLITION WORK AND ALL WORK REQUIRED TO MAINTAIN THE BUILDING'S OPERATION.

F. GENERAL CONTRACTOR SHALL PREPARE EXISTING SURFACES FOR NEW FINISHES AND SHALL REMOVE ALL EXISTING FINISHES. REMOVAL AND PRODUCT REMOVAL ALL ROUGH, PROTRUDING, OR UNEVEN SURFACES SHALL BE LEVELLED TO MATCH SURROUNDING CONDITIONS.

G. GENERAL CONTRACTOR TO FIELD VERIFY ALL QUANTITIES AND MEASUREMENTS PRIOR TO BIDDING.

H. GENERAL CONTRACTOR TO REMOVE ALL UNUSED LOW VOLTAGE CABLEING IN THE CEILING, VERIFY EXISTING SPRINKLER HEAD LOCATIONS AND USE CAUTION DURING REMOVAL. VERIFY LIMITS OF EXISTING CEILING ON JOBSITE.

DEMOLITION KEYED NOTES	
1.	REMOVE EXISTING CARPET, VCT, AND/OR TILE FLOORING. REMOVE EXISTING BASE MOLDING AS NEEDED AND SALVAGE FOR RE-USE.
2.	REMOVE NONSTRUCTURAL WALLS, DOORS, WINDOWS, AND FIXTURES AS INDICATED ON PLAN.
3.	SAW CUT FLOOR TO RUN CONDUIT UNDERFLOOR. SEE PAGES E-101 TO COORDINATE FINAL LOCATIONS.

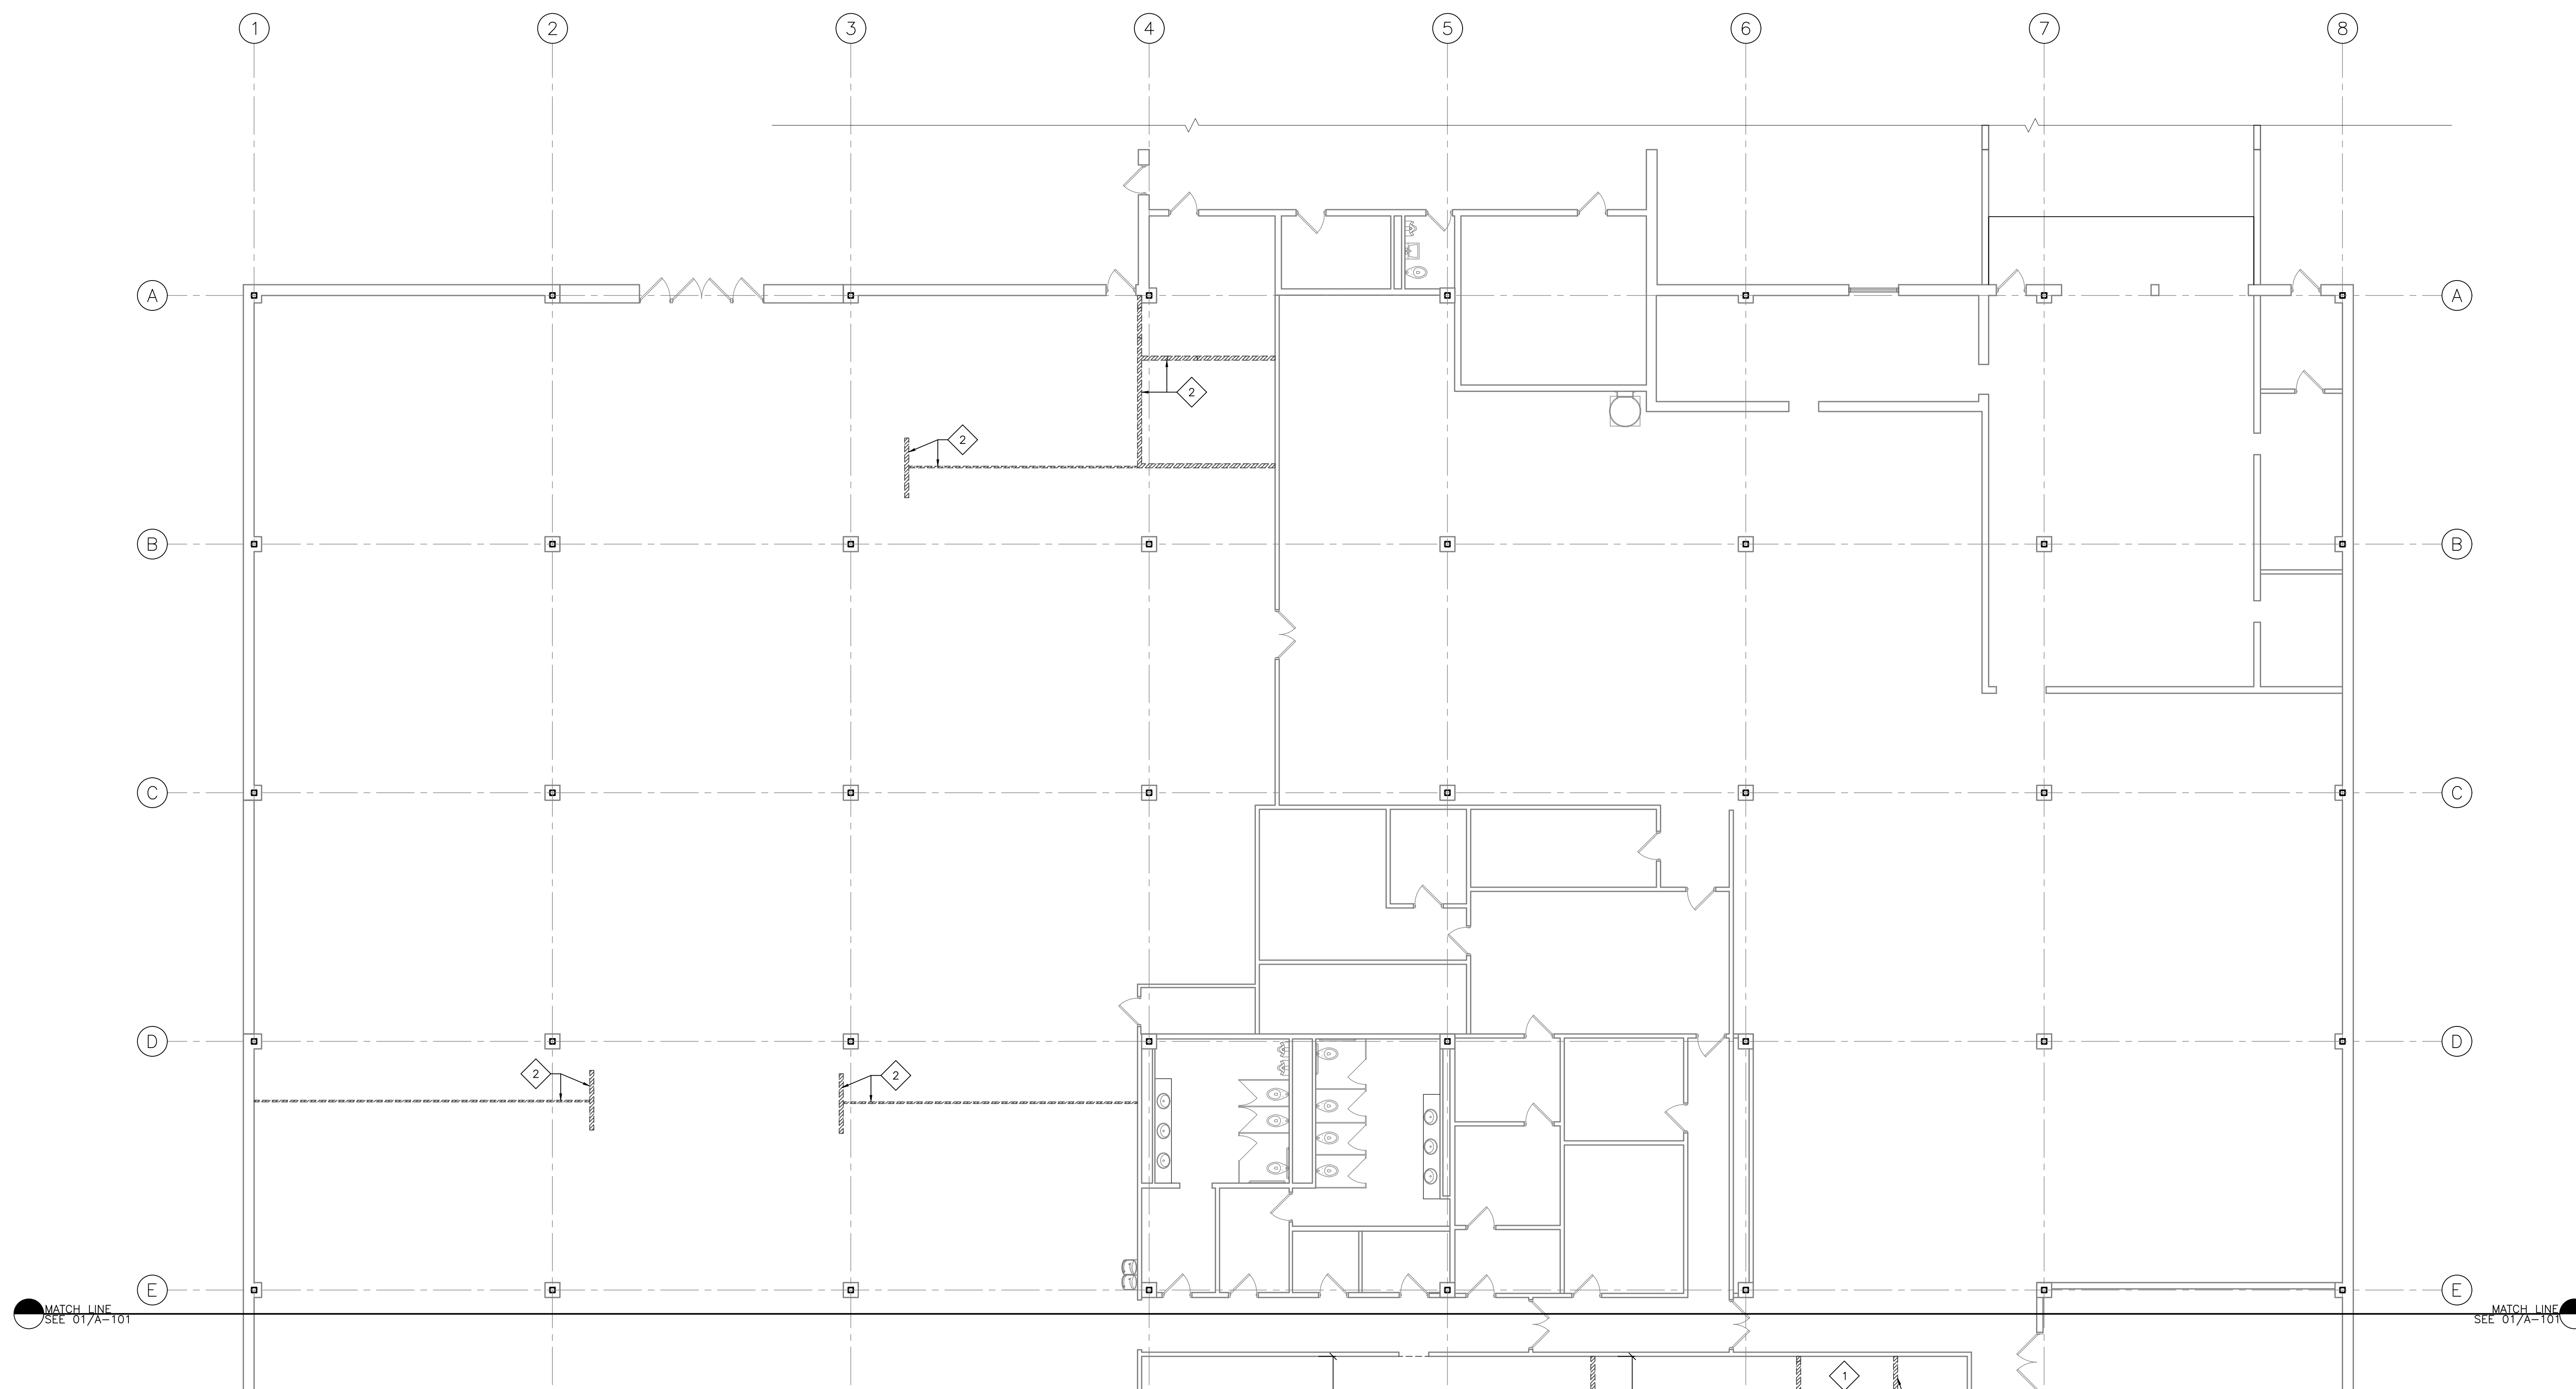

1 FLOOR PLAN
1/8"=1'-0"

DRAWINGS NOT TO BE USED FOR CONSTRUCTION

Ashley. outlet
HOMESTORE 

ASHLEY FURNITURE
TRANSFORMATION DEPARTMENTS:

ONE ASHLEY WAY
PO BOX 1232177 / #002.325.6187
1930 E 9TH AVE
DENVER, CO 80202
P 315.303.9900

[illegible]

DEMOLITION PLAN

**ROSWELL, NM
HOMESTORE & OUTLET**
1000 S. MAIN ST.
ROSWELL, NM 88203

SHOWROOM AREA
227 S.F. | 13,303 S.F.
RECEIVING AREA
79 S.F. (SHARED)
OTHER AREA
57 S.F. (SHARED)
TOTAL AREA
2,266 S.F.
NAME
SLOWIAK
DATE
1/13/18
SCALE
8" = 1'-0"
SHEET
A-102

Ashley. outlet
HOMESTORE 

ASHLEY FURNITURE
FURNITURE DESIGN DEPARTMENT
1000 N. WILSON AVE.
JACKSON, MI 48601
608.608.1328 / 1.800.325.3377 / F 608.252.6167
1910 E 9TH AVE
JACKSON, MI 48601
P 616.532.2600

A. GENERAL CONTRACTOR SHALL BECOME FAMILIAR WITH THE BUILDING AND SHALL VERIFY ALL ITEMS TO BE REMOVED. THIS DRAWING IS PROVIDED FOR REFERENCE ONLY. IT IS THE GENERAL CONTRACTOR'S RESPONSIBILITY TO VERIFY AND ACHIEVE THE FULL EXTENT OF DEMOLITION REQUIRED FOR NEW CONSTRUCTION AND REMODELING.

B. GENERAL CONTRACTOR SHALL REMOVE CEILINGS, CEILING ELEMENTS, AND LIGHT FIXTURES AS SHOWN ON PLAN, ANY UNUSED OR NON-FUNCTIONAL CEILING GRID, AND HANGING WIRING, AND FOR MECHANICAL EQUIPMENT SHALL ALSO BE REMOVED, VERIFY EXISTING SPRINKLER HEADS LOCATIONS AND USE CAUTION DURING CEILING REMOVAL. VERIFY LIMITS OF EXISTING CEILINGS ON SITE.

C. GENERAL CONTRACTOR SHALL SAVE AND STORE ITEMS INDICATED TO BE REMOVED IN AN DESIGNATED OWNER-DESIGNATED REMOVAL DAMAGE.

D. GENERAL CONTRACTOR SHALL REMOVE ALL ITEMS DESIGNATED HEREIN FOR SALVAGE BY THE OWNER THAT OWNER-IN-FACT DECIDES NOT TO RETAIN.

E. GENERAL CONTRACTOR SHALL BE RESPONSIBLE FOR EXTENT OF EXISTING MECHANICAL AND ELECTRICAL DEMOLITION WORK AND ALL WORK REQUIRED TO MAINTAIN THE BUILDING'S OPERATION.

F. GENERAL CONTRACTOR SHALL PREPARE EXISTING SURFACES FOR NEW FINISHES AT LOCATIONS OF ALL DEMOLITION, FINISH REMOVAL, AND PRODUCT REMOVAL.

G. GENERAL CONTRACTOR TO FIELD VERIFY ALL QUANTITIES AND MEASUREMENTS PRIOR TO BIDDING.

H. GENERAL CONTRACTOR TO REMOVE ALL DAMAGED, STAINED OR DISCOLORED EXISTING CEILING PANELS AND REPLACE WITH EQUAL, VERIFY EXISTING SPRINKLER HEAD LOCATIONS AND USE CAUTION DURING CEILING REMOVAL. VERIFY LIMITS OF EXISTING CEILING ON JOBSITE.


1. REMOVE CEILING INCLUDING ATTACHED LIGHTING. VERIFY SPRINKLER HEAD LOCATIONS AND USE CAUTION DURING CEILING REMOVAL.


[illegible]REFLECTED CEILING
DEMOLITION PLAN

**ROSSELL, NM
HOMESTORE & OUTLET**
1000 S. MAIN ST.
ROSSELL, NM 88203


SHOWROOM AREA 25,227 S.F. 13,303 S.F.
RECEIVING AREA 7,779 S.F. (SHARED)
OTHER AREA 6,957 S.F. (SHARED)
TOTAL AREA 53,266 S.F.
NAME J. SLOWIAK
DATE 11/13/18
SCALE 1/8" = 1'-0"
SHEET

DRAWINGS NOT TO BE USED FOR CONSTRUCTION

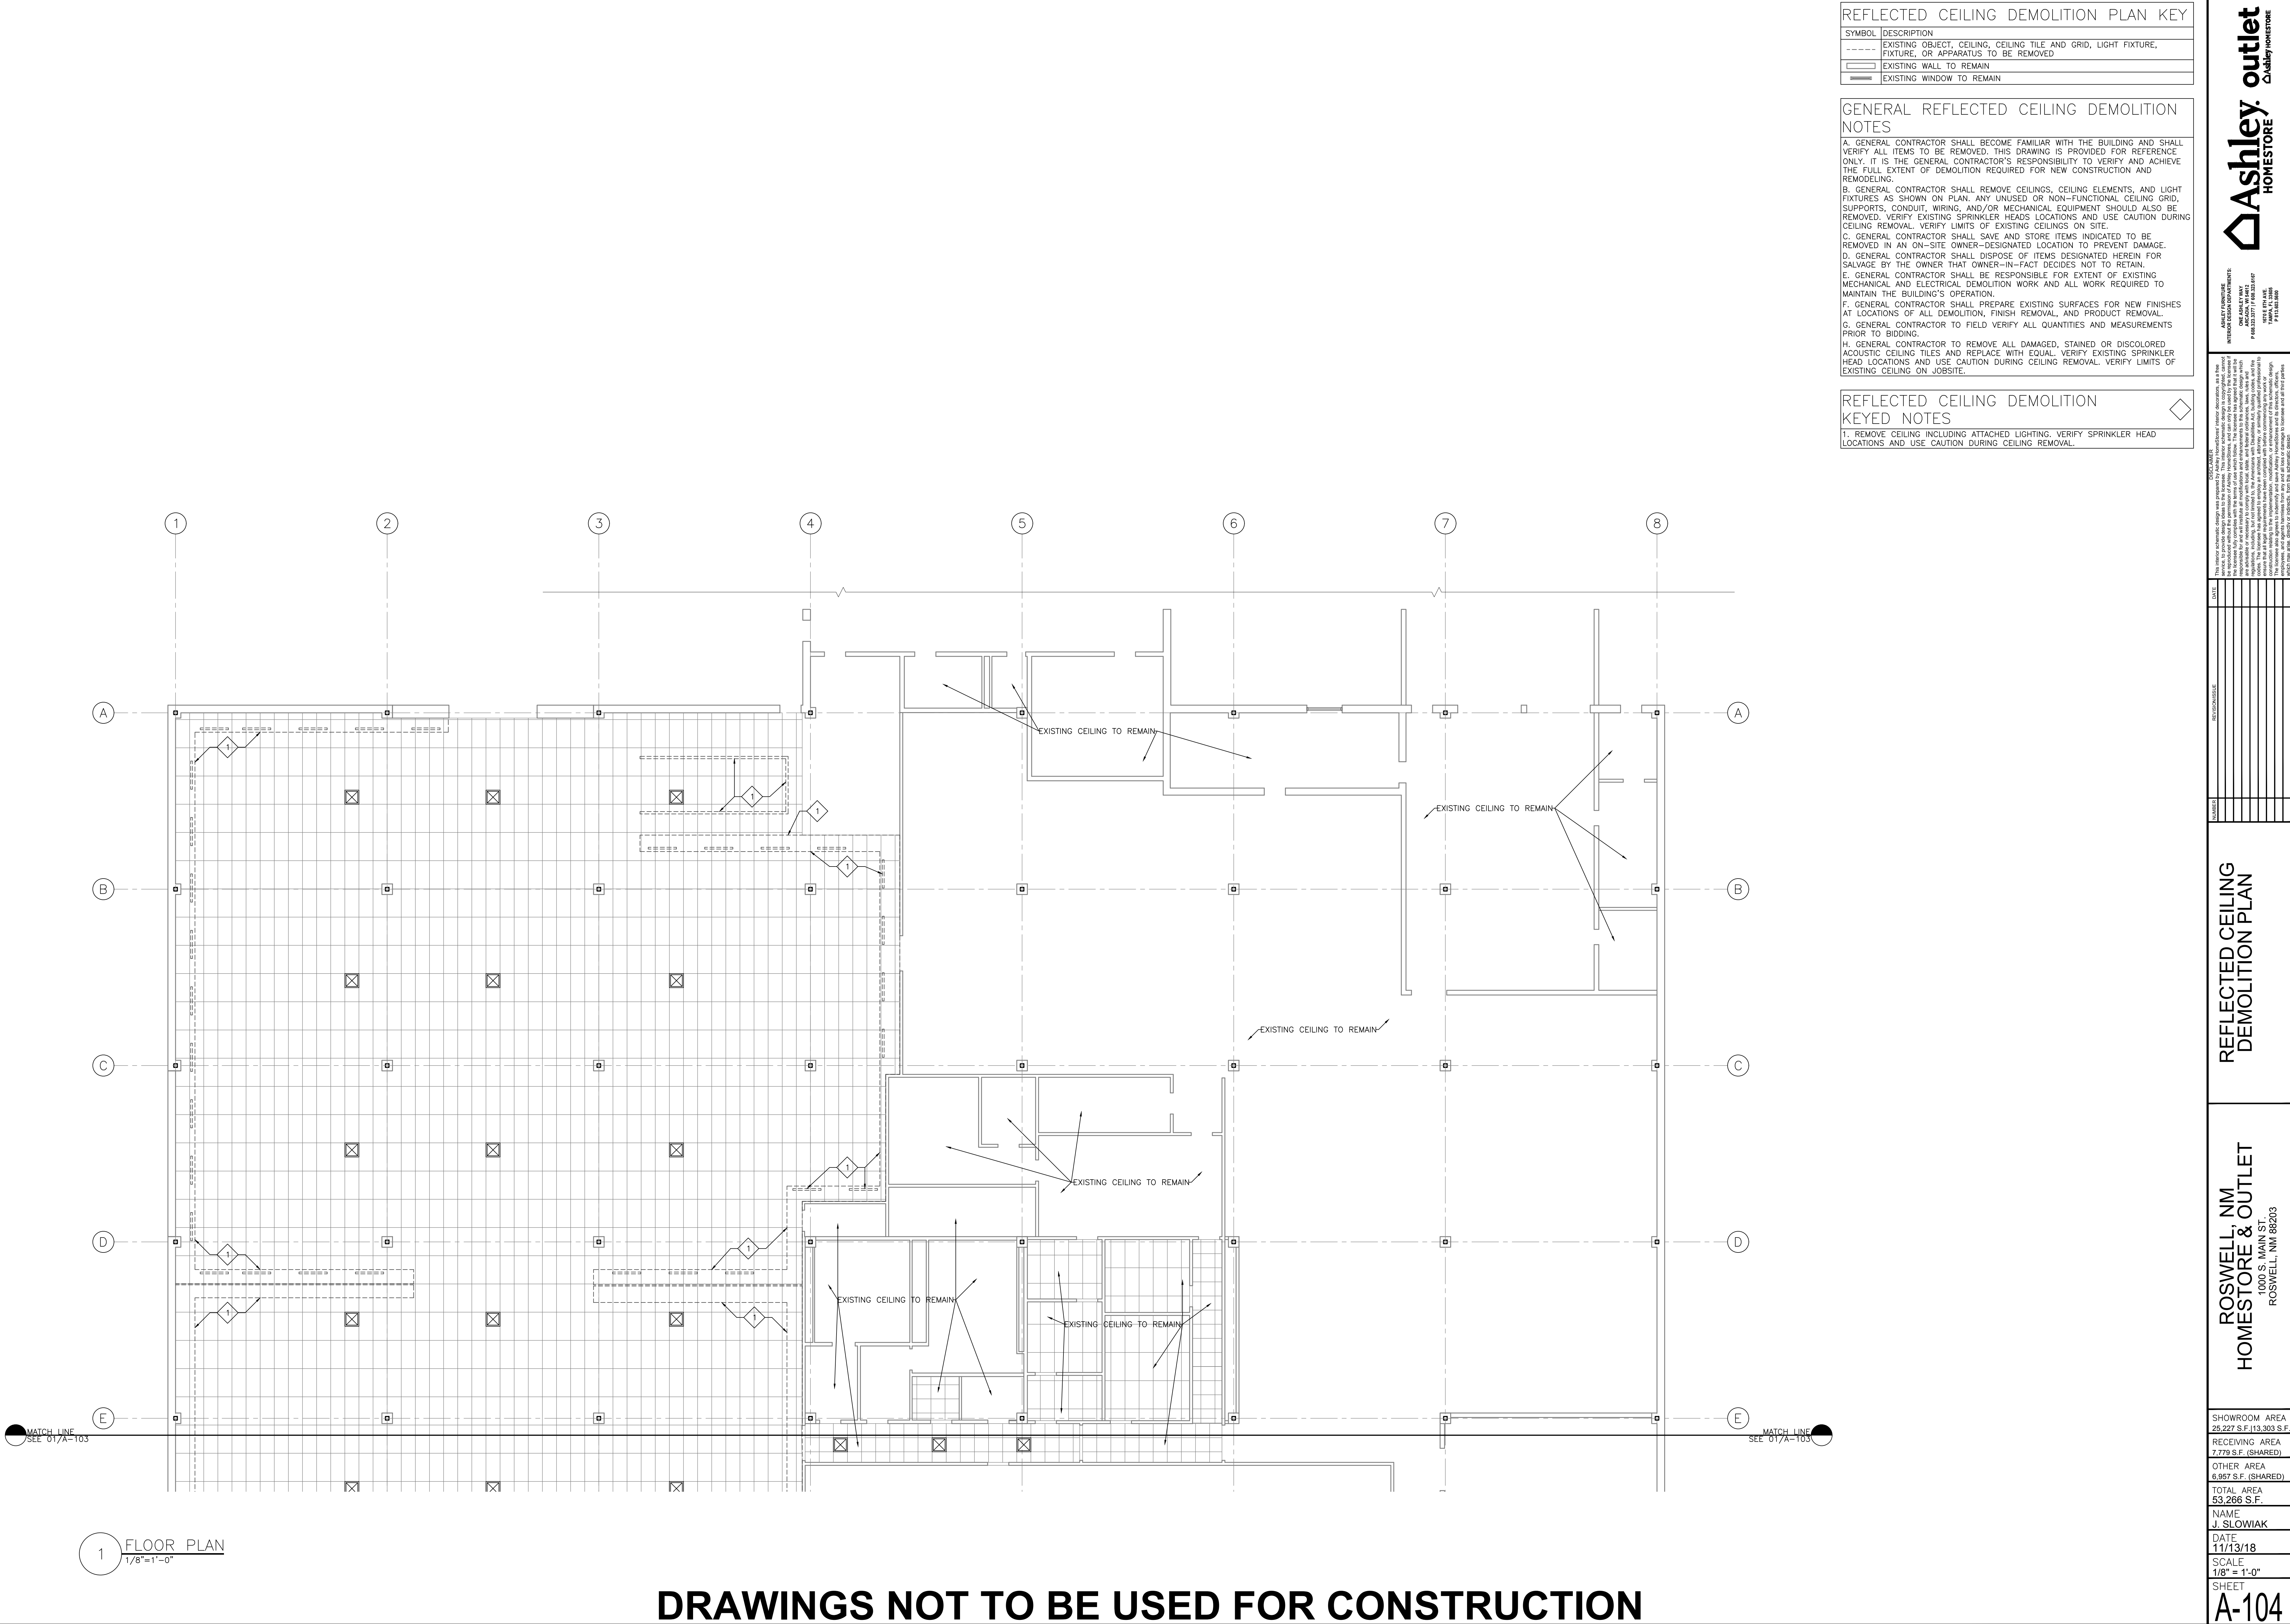

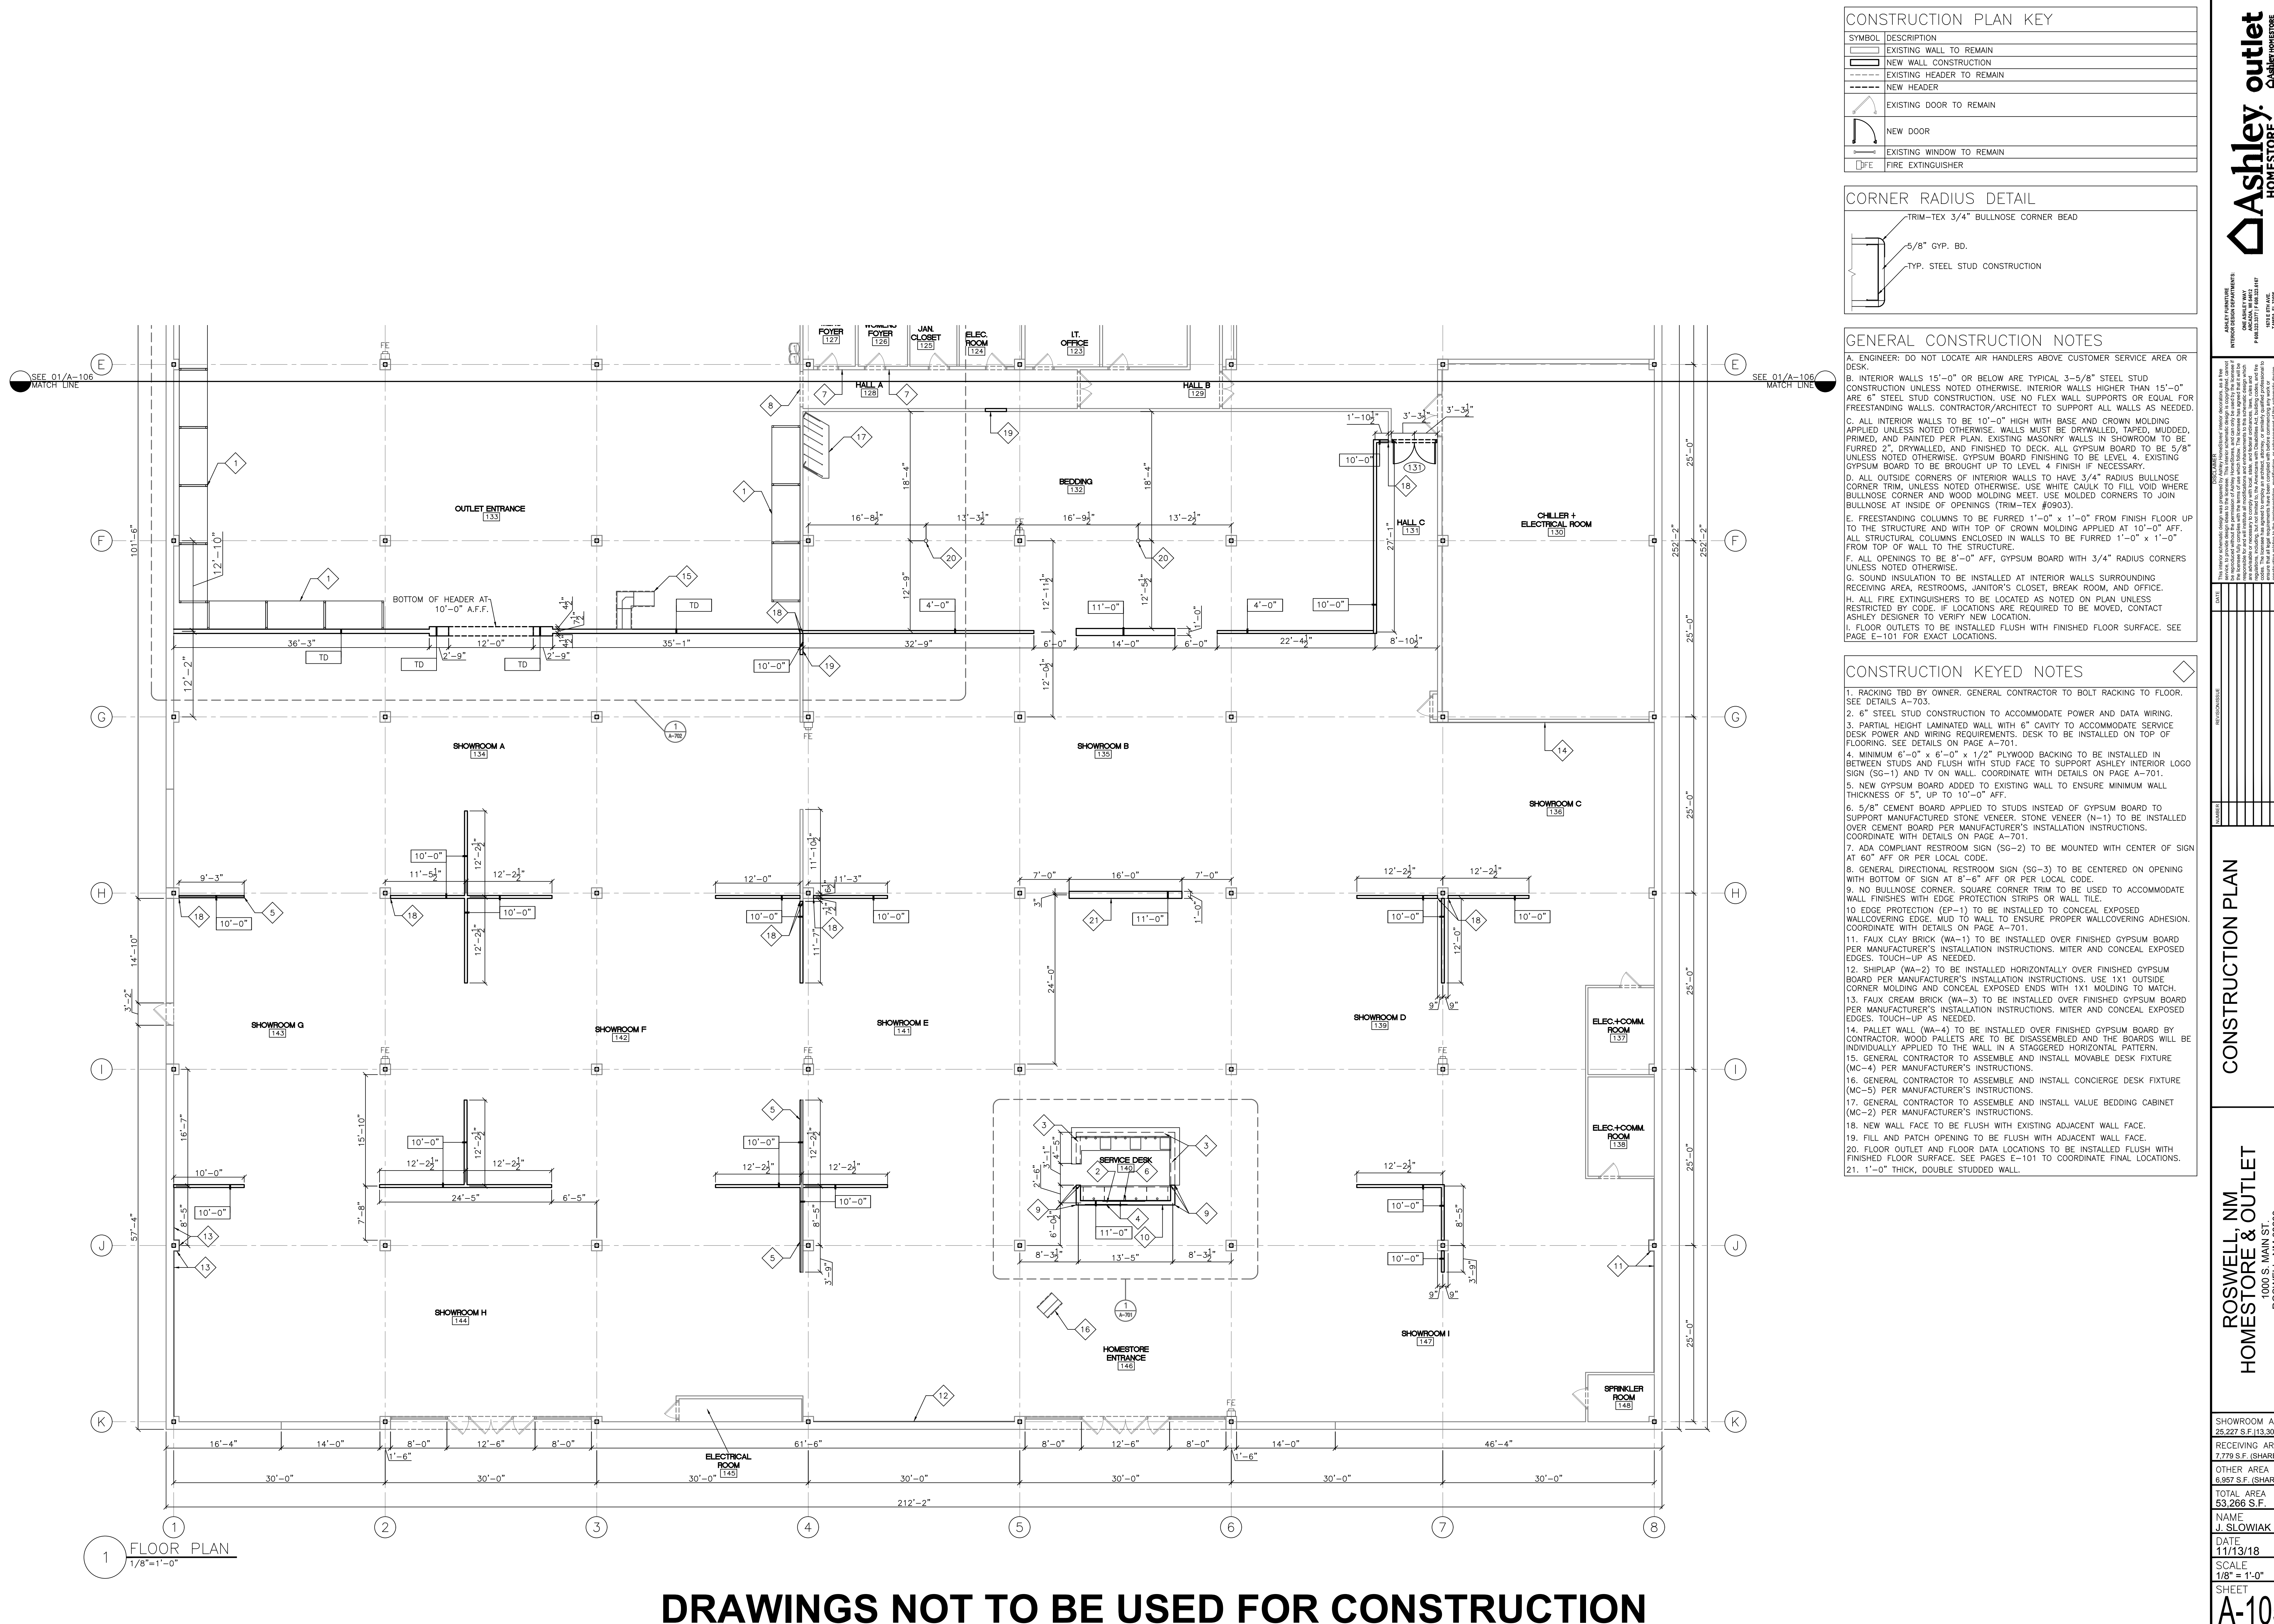

CONSTRUCTION PLAN KEY	
SYMBOL	DESCRIPTION
	EXISTING WALL TO REMAIN
	NEW WALL CONSTRUCTION
	EXISTING HEADER TO REMAIN
	NEW HEADER
	EXISTING DOOR TO REMAIN
	NEW DOOR
	EXISTING WINDOW TO REMAIN
	FIRE EXTINGUISHER

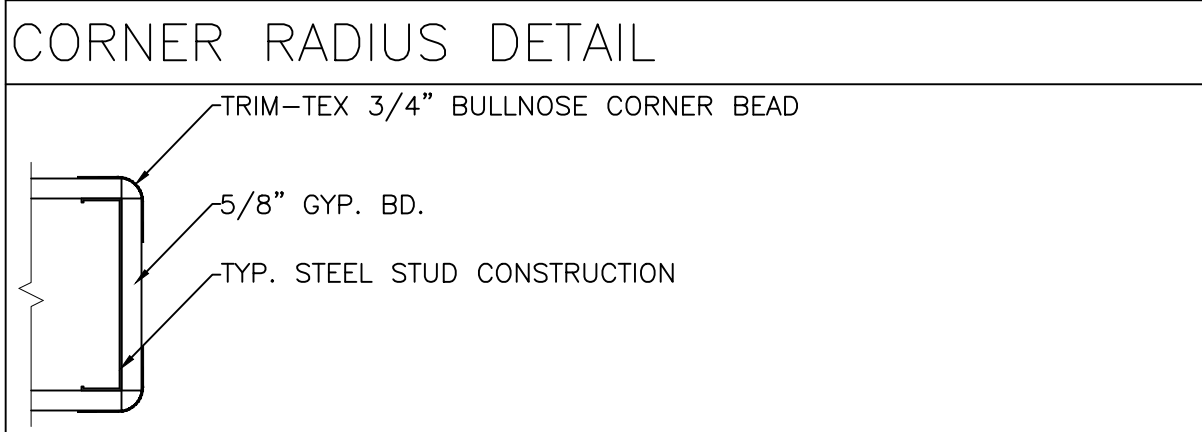

- GENERAL CONSTRUCTION NOTES
- A. ENGINEER: DO NOT LOCATE AIR HANDLERS ABOVE CUSTOMER SERVICE AREA OR DESK.
- B. INTERIOR WALLS 15'-0" OR BELOW ARE TYPICAL 3-5/8" STEEL STUD CONSTRUCTION UNLESS NOTED OTHERWISE. INTERIOR WALLS HIGHER THAN 15'-0" ARE 6" STEEL STUD CONSTRUCTION. USE NO FLEX WALL SUPPORTS OR EQUAL FOR FREESTANDING WALLS. CONTRACTOR/ARCHITECT TO SUPPORT ALL WALLS AS NEEDED.
- C. ALL INTERIOR WALLS TO BE 10'-0" HIGH WITH BASE AND CROWN MOLDING APPLIED UNLESS NOTED OTHERWISE. WALLS MUST BE DRYWALLED, TAPED, MUDD, PRIMED, AND PAINTED PER PLAN. EXISTING MASONRY WALLS IN SHOWROOM TO BE FURRED 2", DRYWALLED, AND FINISHED TO DECK. ALL GYPSUM BOARD TO BE 5/8" UNLESS NOTED OTHERWISE. GYPSUM BOARD FINISHING TO BE LEVEL 4. EXISTING GYPSUM BOARD TO BE BROUGHT UP TO LEVEL 4 FINISH IF NECESSARY.
- D. ALL OUTSIDE CORNERS OF INTERIOR WALLS TO HAVE 3/4" RADIUS BULLNOSE CORNER TRIM, UNLESS NOTED OTHERWISE. USE WHITE CAULK TO FILL VOID WHERE BULLNOSE CORNER AND WOOD MOLDING MEET. USE MOLDED CORNERS TO JOIN BULLNOSE AT INSIDE OF OPENINGS (TRIM-TEX #90903).
- E. FREESTANDING COLUMNS TO BE FURRED 1'-0" x 1'-0" FROM FINISH FLOOR UP TO THE STRUCTURE AND WITH TOP OF CROWN MOLDING APPLIED AT 10'-0" AFF. ALL STRUCTURAL COLUMNS ENCLOSED IN WALLS TO BE FURRED 1'-0" x 1'-0" FROM TOP OF WALL TO THE STRUCTURE.
- F. ALL OPENINGS TO BE 8'-0" AFF, GYPSUM BOARD WITH 3/4" RADIUS CORNERS UNLESS NOTED OTHERWISE.
- G. SOUND INSULATION TO BE INSTALLED AT INTERIOR WALLS SURROUNDING RECEIVING AREA, RESTROOMS, JANITOR'S CLOSET, BREAK ROOM, AND OFFICE.
- H. ALL FIRE EXTINGUISHERS TO BE LOCATED AS NOTED ON PLAN UNLESS RESTRICTED BY CODE. IF LOCATIONS ARE REQUIRED TO BE MOVED, CONTACT ASHLEY DESIGNER TO VERIFY NEW LOCATION.
- I. FLOOR OUTLETS TO BE INSTALLED FLUSH WITH FINISHED FLOOR SURFACE. SEE PAGE E-101 FOR EXACT LOCATIONS.

- CONSTRUCTION KEYED NOTES
1. RACKING TBD BY OWNER. GENERAL CONTRACTOR TO BOLT RACKING TO FLOOR. SEE DETAILS A-703.
2. 6" STEEL STUD CONSTRUCTION TO ACCOMMODATE POWER AND DATA WIRING.
3. PARTIAL HEIGHT LAMINATED WALL WITH 6" CAVITY TO ACCOMMODATE SERVICE DESK POWER AND DATA WIRING. DESK TO BE INSTALLED ON TOP OF FLOORING. SEE DETAILS ON PAGE A-701.
4. MINIMUM 6'-0" x 6'-0" x 1/2" PLYWOOD BACKING TO BE INSTALLED IN BETWEEN STUDS AND FLUSH WITH STUD FACE TO SUPPORT ASHLEY INTERIOR LOGO SIGN (SG-1) AND TV ON WALL. COORDINATE WITH DETAILS ON PAGE A-701.
5. NEW GYPSUM BOARD ADDED TO EXISTING WALL TO ENSURE MINIMUM WALL THICKNESS OF 5", UP TO 10'-0" AFF.
6. 5/8" CEMENT BOARD APPLIED TO STUDS INSTEAD OF GYPSUM BOARD TO SUPPORT MANUFACTURED STONE VENEER. STONE VENEER (N-1) TO BE INSTALLED OVER CEMENT BOARD PER MANUFACTURER'S INSTALLATION INSTRUCTIONS. COORDINATE WITH DETAILS ON PAGE A-701.
7. ADA COMPLIANT RESTROOM SIGN (SG-2) TO BE MOUNTED WITH CENTER OF SIGN AT 60" AFF OR PER LOCAL CODE.
8. GENERAL DIRECTIONAL RESTROOM SIGN (SG-3) TO BE CENTERED ON OPENING WITH BOTTOM OF SIGN AT 8'-6" AFF OR PER LOCAL CODE.
9. NO BULLNOSE CORNER. SQUARE CORNER TRIM TO BE USED TO ACCOMMODATE WALL FINISHES WITH EDGE PROTECTION STRIPS OR WALL TILE.
10. EDGE PROTECTION (EP-1) TO BE INSTALLED TO CONCEAL EXPOSED WALLCOVERING EDGE. MUD TO WALL TO ENSURE PROPER WALLCOVERING ADHESION. COORDINATE WITH DETAILS ON PAGE A-701.
11. FAUX CLAY BRICK (WA-1) TO BE INSTALLED OVER FINISHED GYPSUM BOARD PER MANUFACTURER'S INSTALLATION INSTRUCTIONS. MITER AND CONCEAL EXPOSED EDGES. TOUCH-UP AS NEEDED.
12. SHIPLAP (WA-2) TO BE INSTALLED HORIZONTALLY OVER FINISHED GYPSUM BOARD PER MANUFACTURER'S INSTALLATION INSTRUCTIONS. USE 1X1 OUTSIDE CORNER MOLDING AND CONCEAL EXPOSED ENDS WITH 1X1 MOLDING TO MATCH.
13. FAUX CREAM BRICK (WA-3) TO BE INSTALLED OVER FINISHED GYPSUM BOARD PER MANUFACTURER'S INSTALLATION INSTRUCTIONS. MITER AND CONCEAL EXPOSED EDGES. TOUCH-UP AS NEEDED.
14. PALLET WALL (WA-4) TO BE INSTALLED OVER FINISHED GYPSUM BOARD BY CONTRACTOR. WOOD PALLETS ARE TO BE DISASSEMBLED AND THE BOARDS WILL BE INDIVIDUALLY APPLIED TO THE WALL IN A STAGGERED HORIZONTAL PATTERN.
15. GENERAL CONTRACTOR TO ASSEMBLE AND INSTALL MOVABLE DESK FIXTURE (MC-4) PER MANUFACTURER'S INSTRUCTIONS.
16. GENERAL CONTRACTOR TO ASSEMBLE AND INSTALL CONCIERGE DESK FIXTURE (MC-5) PER MANUFACTURER'S INSTRUCTIONS.
17. GENERAL CONTRACTOR TO ASSEMBLE AND INSTALL VALUE BEDDING CABINET (MC-2) PER MANUFACTURER'S INSTRUCTIONS.
18. NEW WALL FACE TO BE FLUSH WITH EXISTING ADJACENT WALL FACE.
19. FILL AND PATCH OPENING TO BE FLUSH WITH ADJACENT WALL FACE.
20. FLOOR OUTLET AND FLOOR DATA LOCATIONS TO BE INSTALLED FLUSH WITH FINISHED FLOOR SURFACE. SEE PAGES E-101 TO COORDINATE FINAL LOCATIONS.
21. 1'-0" THICK, DOUBLE STUDDED WALL.

ASHLEY'S outlet
homestore

ASHLEY'S outlet
homestore
1000 S. MAIN ST.
ROSWELL, NM 88203

CONSTRUCTION PLAN

ROSWELL, NM
HOMESTORE & OUTLET
1000 S. MAIN ST.
ROSWELL, NM 88203

SHOWROOM AREA
25,227 S.F. (13,303 S.F.)

RECEIVING AREA
7,779 S.F. (SHARED)

OTHER AREA
6,957 S.F. (SHARED)

TOTAL AREA
53,266 S.F.

NAME
J. SLOWIAK

DATE
11/13/18

SCALE
1/8" = 1'-0"

SHEET
A-105

A. ENGINEER: DO NOT LOCATE AIR HANDLERS ABOVE CUSTOMER SERVICE AREA OR DECK.

B. INTERIOR WALLS 15'-0" OR BELOW ARE TYPICAL 3'-5/8" STEEL STUD WALL CONSTRUCTION. USES NOTED OTHERWISE. INTERIOR WALLS HIGHER THAN 15'-0" ARE 6" STEEL STUD CONSTRUCTION. USE NO FLEX WALL SUPPORTS OR EQUAL FOR FREESTANDING WALLS. CONTRACTOR/ARCHITECT TO SUPPORT ALL WALLS AS NEEDED.

C. ALL INTERIOR WALLS TO BE 10'-0" HIGH WITH BASE AND CROWN MOLDING. FINISHES: UNLESS NOTED OTHERWISE, WALLS MUST BE DRYWALLED, PAINTED, MUDD, PRIMED, AND FINISHED TO PERMANENTLY SMOOTH FINISH. GYPSUM BOARD TO BE FURRED 2", DRYWALLED, AND FINISHED TO DECK. ALL GYPSUM BOARD TO BE 5/8" UNLESS NOTED OTHERWISE. GYPSUM BOARD FINISHING TO BE LEVEL 4, EXISTING FINISHES TO BE BROKEN OUT AND REFINISHED TO LEVEL 4 FINISH.

D. ALL OUTSIDE CORNERS OF INTERIOR WALLS TO HAVE 3/4" RADIUS BUSHING CORNER TRIM, UNLESS NOTED OTHERWISE. USE WHITE CAULK TO FILL VOID WHERE TRIM MEETS WALL. PROVIDE 1/2" RADIUS WHITE CAULKED CORNERS TO JOIN BUSHING AT INSIDE OF OPENINGS (TRIM-TEX #9030).

E. FREESTANDING COLUMNS TO BE FURRED 1'-0" x 1'-0" FROM FINISH FLOOR UP TO THE STRUCTURE AND WITH TOP OF CROWN MOLDING APPLIED AT 10'-0" AFF. ALL STRUCTURAL COLUMNS ENCLOSED IN WALLS TO BE FURRED 1'-0" x 1'-0" FROM FINISH FLOOR TO TOP OF CROWN MOLDING.

 
F. ALL OPENINGS TO BE 8'-0" AFF, GYPSUM BOARD WITH 3/4" RADIUS CORNERS UNLESS NOTED OTHERWISE.

G. SOUND INSULATION TO BE INSTALLED AT INTERIOR WALLS SURROUNDING RESTROOMS, RESTROOMS, JANITOR'S CLOSET, BREAK ROOM, AND OFFICE.

H. ALL FIRE EXTINGUISHERS TO BE LOCATED AS NOTED ON PLAN UNLESS RESTRICTED BY CODE. IF LOCATIONS ARE REQUIRED TO BE MOVED, CONTACT ASHLEY DESIGNER TO VERIFY NEW LOCATION.

I. PROVIDE 1/2" RADIUS FLUSH FINISHED FLOOR SURFACE. SEE PAGE E-101, FOR EXACT LOCATIONS.

1. RACKING TIED BY OWNER, GENERAL CONTRACTOR TO BOLT RACKING TO FLOOR. SEE DETAILS A-703.
2. 6" STEEL STUD CONSTRUCTION TO ACCOMMODATE POWER AND DATA WIRING.
3. PARTIAL HEIGHT LAMINATED WALL WITH 6" CAVITY TO ACCOMMODATE SERVICE CABLE POWER AND WIRING. RECESSED DESK TO BE INSTALLED ON TOP OF FLOORING. SEE DETAILS ON PAGE A-701.
4. MINIMUM 6'-0" x 6'-0" x 1/2" PLYWOOD BACKING TO BE INSTALLED IN TOP OF STUD WALL. PROVIDE 1/2" CLOUD JOINTS TO SUPPORT ASHLEY INTERIOR LOGO SIGN (SG-1) AND TV ON WALL. COORDINATE WITH DETAILS ON PAGE A-701.
5. NEW GYPSUM BOARD ADDED TO EXISTING WALL TO ENSURE MINIMUM WALL THICKNESS OF 5", UP TO 10'-0" AFF.
6. 5/8" CEMENT BOARD APPLIED TO STUDS INSTEAD OF GYPSUM BOARD TO SUPPORT MANUFACTURED STONE VENEER. STONE VENEER (N-1) TO BE INSTALLED PER GYPSUM BOARD PER MANUFACTURER'S INSTALLATION INSTRUCTIONS. COORDINATE WITH DETAILS ON PAGE A-701.
7. ADA COMPLIANT RESTROOM SIGN (SG-2) TO BE MOUNTED WITH CENTER OF SIGN AT 60" AFF OR PER LOCAL CODE.
8. GENERAL DIRECTIONAL RESOLUTION SIGN (SG-3) TO BE CENTERED ON OPENING WITH BOTTOM OF SIGN AT 8'-6" AFF OR PER LOCAL CODE.
9. NO BULLNOSE CORNER. SQUARE CORNER TRIM TO BE USED TO ACCOMMODATE WALL FINISHES WITH EDGE PROTECTION STRIPS ON WALL TAIL.
10. EDGE PROTECTION (EP-1) TO BE INSTALLED TO PROTECT EXPOSED WALLCOVERING/EDGE. MUD TO WALL TO ENSURE PROPER WALLCOVERING ADHESION. COORDINATE WITH DETAILS ON PAGE A-701.
11. FAUX CLAY BRICK (WA-1) TO BE INSTALLED OVER FINISHED GYPSUM BOARD PER MANUFACTURER'S INSTALLATION INSTRUCTIONS. MITER AND CONCEAL EXPOSED EDGES. TOUCH-UP AS NEEDED.
12. SHIP/LAP (WA-2) TO BE INSTALLED HORIZONTALLY OVER FINISHED GYPSUM BOARD PER MANUFACTURER'S INSTALLATION INSTRUCTIONS. USE 1X1 OUTSIDE FINISHES. MITER AND CONCEAL EXPOSED EDGES. TOUCH-UP AS NEEDED.
13. FAUX CREAM BRICK (WA-3) TO BE INSTALLED OVER FINISHED GYPSUM BOARD PER MANUFACTURER'S INSTALLATION INSTRUCTIONS. MITER AND CONCEAL EXPOSED EDGES. TOUCH-UP AS NEEDED.
14. PANEL/TAIL WALL (WA-4) TO BE INSTALLED OVER FINISHED GYPSUM BOARD. PANEL/TAIL WALL TO BE DISASSEMBLED AND THE BOARDS WILL BE INDIVIDUALLY APPLIED TO THE WALL IN A STAGGERED HORIZONTAL PATTERN.
15. GENERAL CONTRACTOR TO ASSEMBLE AND INSTALL MOVABLE DESK FIXTURE PER MANUFACTURER'S INSTRUCTIONS.
16. GENERAL CONTRACTOR TO ASSEMBLE AND INSTALL CONCERGE DESK FIXTURE (MC-5) PER MANUFACTURER'S INSTRUCTIONS.
17. GENERAL CONTRACTOR TO ASSEMBLE AND INSTALL VALUE BEDDING CABINET (MC-2) PER MANUFACTURER'S INSTRUCTIONS.
18. NEW WALL FACE TO BE FLUSH WITH EXISTING ADJACENT WALL FACE.
19. FILL AND PATCH OPENING TO BE FLUSH WITH ADJACENT WALL FACE.
20. FLOORING AND FLOOR FINISH TO BE FLUSH TO BE INSTALLED FLUSH WITH FINISHED FLOOR SURFACE. SEE PAGES E-101, TO COORDINATE FINAL LOCATIONS.





Ashley **outlet**
HOMESTORE **ASHLEY HOMESTORE**

ASHLEY FURNITURE
INTERIOR DESIGN DEPARTMENT:
ONE ASHLEY WAY
ARCADIA, WA 98001
P 360.232.3377 | F 360.232.1167
4976 E 17TH AVE
TAMPA, FL 33605

ROSWELL, NM
HOMESTORE & OUTLET


SHOWROOM AREA	25,227 S.F. 13,303 S.F.
RECEIVING AREA	7,779 S.F. (SHARED)
OTHER AREA	6,957 S.F. (SHARED)
TOTAL AREA	53,266 S.F.
NAME	J. SLOWIAK
DATE	11/13/18
SCALE	1/8" = 1'-0"
SHEET	

A-106


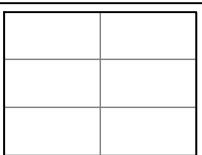
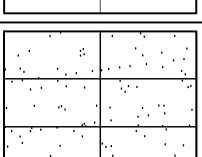
REFLECTED CEILING PLAN KEY	
SYMBOL	DESCRIPTION
	EXISTING CEILING TO REMAIN, OPEN CEILING
	EXISTING 2x4 ACT AND GRID CEILING
	NEW 2x4 ACT AND GRID CEILING

- A. GENERAL CONTRACTOR TO REMOVE ALL DAMAGED, STAINED OR DISCOLORED ACQUASOL CEILING TILES AND REPLACE WITH EQUAL. VERIFY EXISTING SPRINKLER HEADS ARE NOT IN LOCATION DURING CEILING REMOVE. VERIFY LIMITS OF EXISTING CEILING ON JOBSITE.
- B. CANTILEVERS MAY BE SUPPORTED BY STRUCTURAL STEEL OR AIRCRAFT CABLE. TO BE DETERMINED BY ARCHITECT. EXPANSION JOINT TO BE DETERMINED BY ARCHITECT.
- C. ALL DAMAGED OR MISSING CEILING TILES TO BE REPLACED WITH EQUAL.
- C. ALL SPRINKLER SYSTEMS MUST MEET LOCAL CODE. NO SIDEWALL SPRINKLERS ARE PERMITTED UNLESS REQUIRED BY LOCAL CODE AND APPROVED BY ASHLEY DESIGNER.
- D. ANY EXISTING SURFACES SHOULD BE CLEANED AND ANY EXISTING PAINT REMOVED AND/OR SANDED SMOOTH PRIOR TO RECEIVING NEW PAINT.
- E. ALL UNFINISHED EXPOSED CEILING MUST NOT HAVE ANY EXPOSED INSULATION. INSULATION MUST BE WRAPPED AND READY TO RECEIVE PAINT. SEE PAGE I-103 FOR CEILING PAINT COLORS.
- F. COORDINATE ALL REFLECTED CEILING PLANS WITH MECHANICAL AND ELECTRICAL. COORDINATE ALL WORK ON THE MECHANICAL AND ELECTRICAL DRAWINGS MAY NOT BE INDICATED ON THE REFLECTED CEILING PLANS. LOCATE ALL CEILING MOUNTED ITEMS IN ACCORDANCE WITH THE ARCHITECTURAL DRAWINGS. REFER TO CONSULTANT FOR COORDINATION.
- G. ANY ACCESS HATCHES NOT SHOWN ON CEILING PLAN BUT REQUIRED BY PLUMBING, MECHANICAL, OR ELECTRICAL SYSTEMS SHALL BE REVIEWED WITH ASHLEY DESIGNER FOR LOCATION.
- H. ALL EXISTING CEILING HEIGHTS SHOWN ARE APPROXIMATE. ALL NEW CEILINGS SHALL BE INSTALLED AT THE SAME HEIGHT UNLESS NOTED OTHERWISE.

1. OPEN CEILING GRID (CE-2 OR SEE DETAIL ON A-701 FOR ALTERNATIVE CONSTRUCTION DETAIL OPTION. OWNER TO DETERMINE IF GRID IS TO BE PURCHASED OR BUILT ON SITE) TO BE SUSPENDED FROM CEILING WITH VERTICAL AIRCRAFT CABLE TO SUPPORT 300 LBS. BOTTOM OF GRID AT 10'-0" AFF.
2. PROVIDE SUPPORT FOR 50 POUND ROUND SHADE PENDANT (LT-1).
3. LINE WHERE NEW CEILING AND EXISTING CEILING JOIN. FINISHED SURFACE OF NEW CEILING MUST BE FLUSH WITH EXISTING.

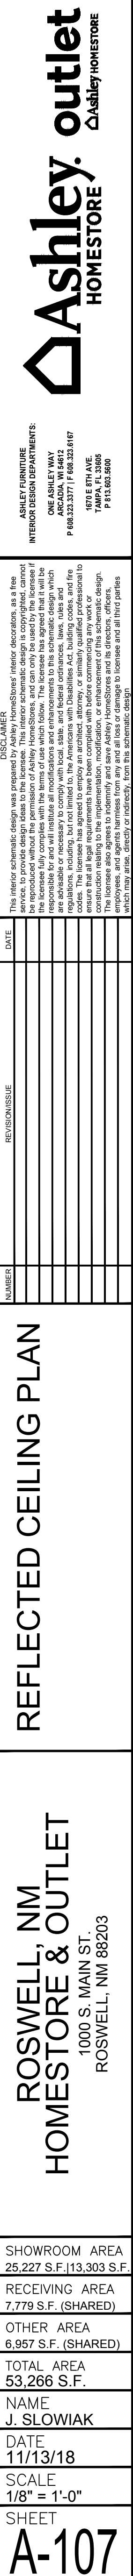

 DRAWINGS NOT TO BE USED FOR CONSTRUCTION

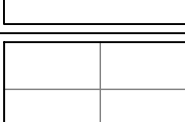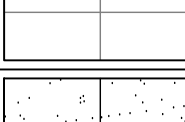REFLECTED CEILING PLAN KEY	
SYMBOL	DESCRIPTION
	EXISTING CEILING TO REMAIN, OPEN CEILING
	EXISTING 2x4 ACT AND GRID CEILING
	NEW 2x4 ACT AND GRID CEILING

A. GENERAL CONTRACTOR TO REMOVE ALL DAMAGED, STAINED OR DISCOLORED ACCELOSS CEILING TILES AND REPLACE WITH EQUAL. VERIFY EXISTING SPRINKLER HEAD LOCATIONS AND LOCATIONS DURING CEILING REMOVE. VERIFY LIMITS OF EXISTING CEILING ON JOBSITE.

B. CANTILEVERS MAY BE SUPPORTED BY STRUCTURAL STEEL OR AIRCRAFT CABLE. TO BE DETERMINED BY ARCHITECT. EXPANSION JOINT TO BE DETERMINED BY ARCHITECT.

C. ALL SPRINKLER SYSTEMS MUST MEET LOCAL CODE. NO SIDEWALL SPRINKLERS ARE PERMITTED UNLESS REQUIRED BY LOCAL CODE AND APPROVED BY ASHLEY DESIGNER.

D. ANY EXISTING SURFACES SHOULD BE CLEANED AND ANY EXISTING PAINT REMOVED AND/OR SANDED SMOOTH PRIOR TO RECEIVING NEW PAINT.

E. ALL UNFINISHED EXPOSED CEILINGS MUST NOT HAVE ANY EXPOSED INSULATION. INSULATION MUST BE WRAPPED AND READY TO RECEIVE PAINT. SEE PAGE 1-103 FOR CEILING PAINT COLORS.

F. COORDINATE ALL REFLECTED CEILING PLANS WITH MECHANICAL AND ELECTRICAL DRAWINGS. VERIFY ALL OF THE MECHANICAL AND ELECTRICAL DRAWINGS MAY NOT BE INDICATED ON THE REFLECTED CEILING PLANS. LOCATE ALL CEILING MOUNTED ITEMS IN ACCORDANCE WITH THE ARCHITECTURAL DRAWINGS. REFER TO CONSULTANT FOR INFORMATION.

G. ANY ACCESS HATCHES NOT SHOWN ON CEILING PLAN BUT REQUIRED BY PLUMBING, MECHANICAL, OR ELECTRICAL SYSTEMS SHALL BE REVIEWED WITH ASHLEY DESIGNER FOR LOCATION

H. ALL EXISTING CEILING HEIGHTS SHOWN ARE APPROXIMATE. ALL NEW CEILINGS THAT ADJOIN EXISTING CEILINGS MUST BE INSTALLED AT THE SAME HEIGHT UNLESS NOTED OTHERWISE.

1. OPEN CEILING GRID (CE-2 OR SEE DETAIL ON A-701 FOR ALTERNATIVE CONSTRUCTION DETAIL OPTION. OWNER TO DETERMINE IF GRID IS TO BE PURCHASED OR BUILT ON SITE) TO BE SUSPENDED FROM CEILING WITH VERTICAL AIRCRAFT CABLE TO SUPPORT 300 LBS. BOTTOM OF GRID AT 10'-0" AFF.
2. PROVIDE SUPPORT FOR 50 POUND DIRM SHADE PENDANT (LT-1).
3. LINE WHERE NEW CEILING AND EXISTING CEILING JOIN. FINISHED SURFACE OF NEW CEILING MUST BE FLUSH WITH EXISTING.



1 FLOOR PLAN
1/8" = 1'-0"

DRAWINGS NOT TO BE USED FOR CONSTRUCTION

Ashley outlet
HOMESTORE △ Ashley HOMESTORE

ASHLEY FURNITURE
OR DESIGN DEPARTMENTS

ONE ASHLEY WAY
ARCADIA, WI 54612
323.3377 / F 608.323.6167

1670 E 8TH AVE.
TAMPA, FL 33606

[illegible][illegible]

REFLECTED CEILING PLAN

**ROSWELL, NM
HOMESTORE & OUTLET**
1000 S. MAIN ST.
ROSWELL, NM 89203


SHOWROOM AREA	25,227 S.F. (13,303)
RECEIVING AREA	7,779 S.F. (SHARE)
OTHER AREA	6,957 S.F. (SHARE)
TOTAL AREA	53,266 S.F.
NAME	J. SLOWIAK
DATE	11/13/18
SCALE	1/8" = 1'-0"
SHEET	

A-108



1. COORDINATE OUTLET WITH ACCESS PANEL IN MILLWORK. SEE DETAILS ON PAGE A-701.
2. POWER AND DATA OUTLETS AND COVERS IN THE SERVICE DESK TO BE BLACK IN COLOR.
3. WIRING FOR TECHNOLOGY VENDOR.
4. WIRING FOR POINT OF SALE STATION (P.O.S.).
5. WIRING FOR MOVABLE DESK STATION.

E-102

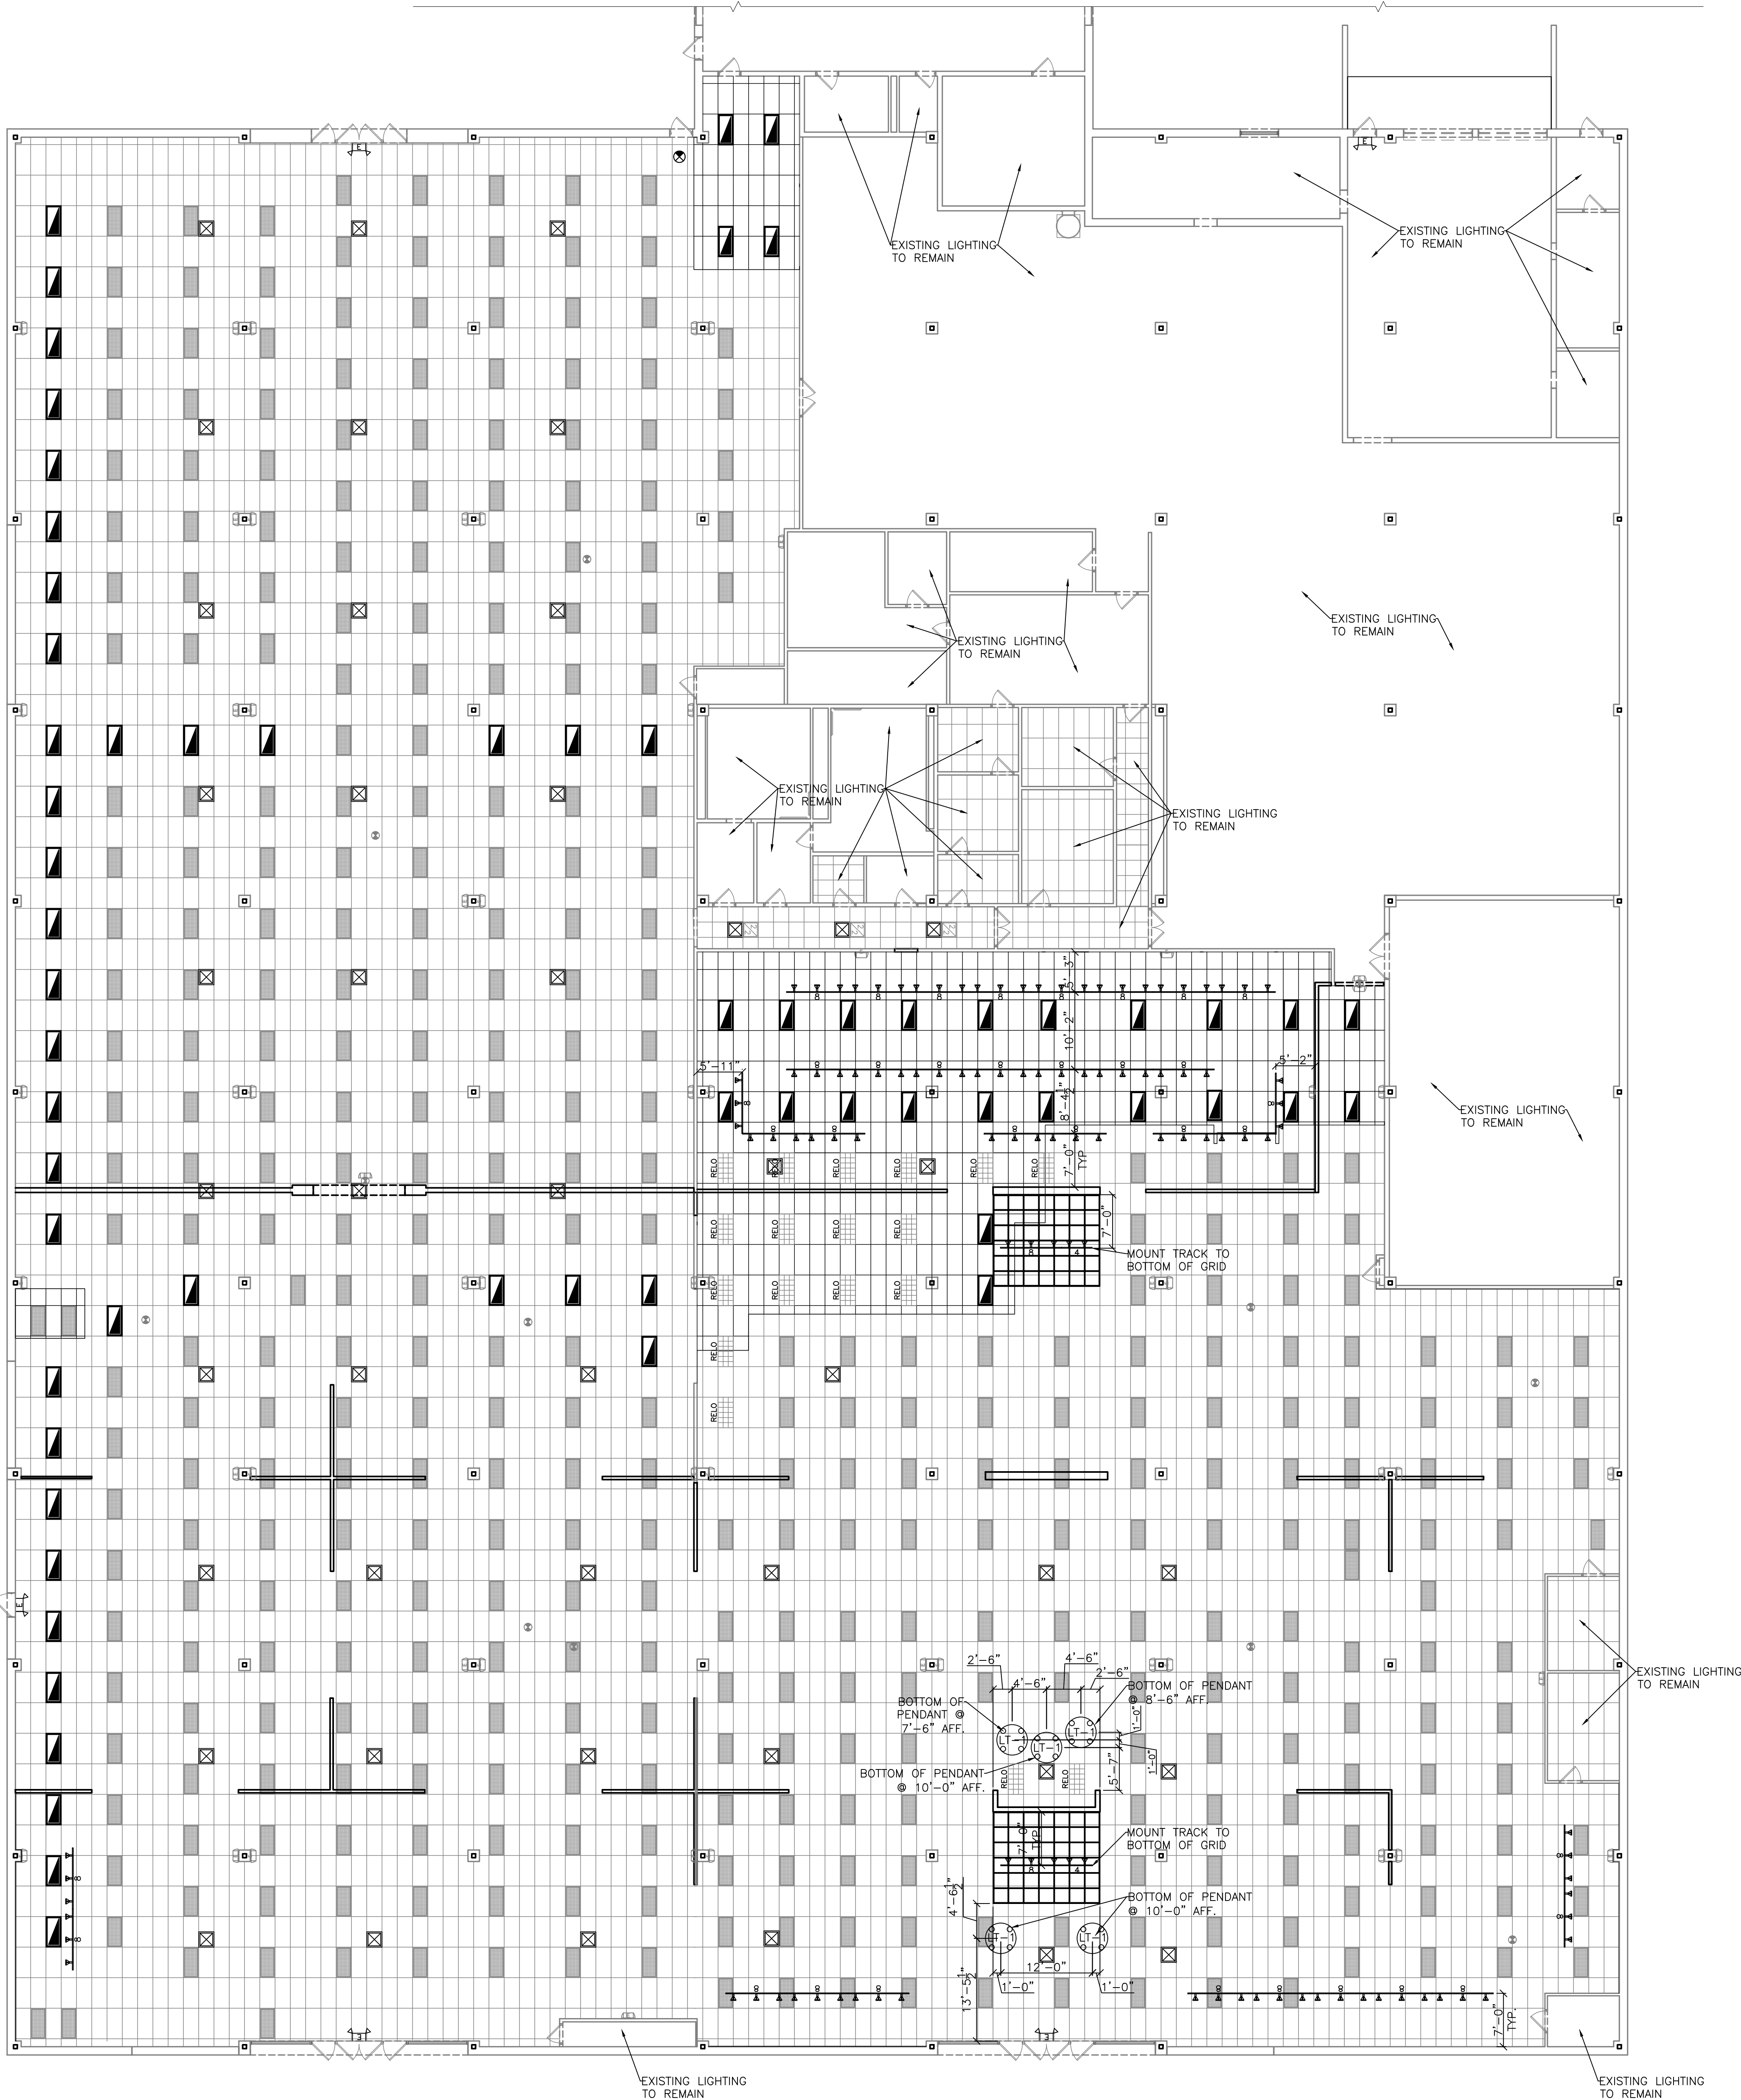

- GENERAL LIGHTING NOTES**
- A. THIS DRAWING IS FOR DESIGN INTENT ONLY AND SHALL NOT BE USED AS A CONSTRUCTION DOCUMENT. INPUT VOLTAGE AND OTHER REQUIREMENTS TO BE SPECIFIED BY THE PROJECT ARCHITECT/ENGINEER. ALL DIMENSIONS AND DETAIL INFORMATION SHALL BE VERIFIED AGAINST EXISTING SITE CONDITIONS TO DETERMINE CONFLICTS OR APPRECIABLE DIFFERENCES.
- B. ALL EXIT AND EMERGENCY LIGHTING FIXTURES ARE TO BE LOCATED AS NOTED ON PLAN UNLESS RESTRICTED BY CODE. EMERGENCY FIXTURES TO BE MOUNTED AT 10'-6" AFF TO C.L.; OR 8'-9" AFF IF WALL IS UNDER 11'-0" HIGH. CEILING HUNG EXIT FIXTURES TO BE MOUNTED TO CEILING. WALL MOUNTED EXIT FIXTURES TO BE INSTALLED WITH BOTTOM AT 10'-6" AFF UNLESS RESTRICTED BY CODE OR NOTED OTHERWISE. NO EXIT OR EMERGENCY LIGHTING FIXTURES ARE TO BE MOUNTED ON THE FACE OF THE CANTILEVERS OR FEATURE WALLS. IF LOCATIONS ARE REQUESTED TO BE MOVED, CONTACT THE ASHLEY DESIGNER TO VERIFY NEW LOCATION.
- C. HORN STROBES TO BE PENDANT MOUNTED AT CEILING.
- D. IF ADDITIONAL EMERGENCY AND/OR EXIT LIGHTING IS REQUIRED BY THE MUNICIPALITY, IT IS TO BE SUPPLIED AND INSTALLED BY THE CONTRACTOR.
- E. TRACK LIGHTING SYSTEM:
- a. TRACK SHALL BE MOUNTED TO CEILING UNLESS OTHERWISE NOTED.
 - b. ELECTRICAL CONTRACTOR TO INSTALL TRACK HEADS. THE TRACK LIGHTING FIXTURES AS SHOWN ON PLAN ARE THE EXACT NUMBER OF FIXTURES THAT WILL BE INSTALLED - THREE PER 8'-0" LENGTH AND TWO PER 4'-0" LENGTH OF TRACK.
 - c. THE CONTRACTOR SHALL WRITE THE NUMERICAL DATE (e.g. 3-23-08) WHEN THE TRACK LIGHT BULBS ARE PUT INTO SERVICE NEATLY ON THE STEM OF THE BULB WITH A MEDIUM TIP, BLACK "SHARPIE" MARKER.
- F. THE TOP OF ALL SWITCHES TO BE INSTALLED A MAXIMUM OF 48" AFF UNLESS NOTED OTHERWISE. SWITCH PLATES MUST BE PROVIDED AND BE WHITE IN COLOR.
- G. MANUAL OVERRIDE SWITCHING IN SERVICE DESK AREA TO CONTROL THE FOLLOWING ELECTRICAL COMPONENTS:
- a. SHOWROOM FRONT BAY TRACK LIGHTS AND DRUM SHADE PENDANTS
 - b. SHOWROOM GENERAL LIGHTING (OVERHEAD LIGHTING)
 - c. SERVICE DESK AREA LIGHTS
 - d. ALL SHOWROOM WALL RECEPTACLES AT 18" AFF UNLESS NOTED OTHERWISE
 - e. OVERHEAD SHOWROOM JUNCTION BOXES
- H. ALL FIXTURE MOUNTING AND SUSPENSION HARDWARE TBD OWNER/CONTRACTOR AND SUPPLIED BY CONTRACTOR.
- I. SUPPLIERS LISTED FOR FIXTURES ARE SUGGESTED BASED ON PREFERRED SPECIFICATION AND PRICE. SUPPLIER IS TBD BY OWNER.


ASHLEY HOMESTORE LIGHTING FIXTURE SCHEDULE					
SYMBOL	TYPE	MANUFACTURER	SUPPLIER	MODEL NUMBER	VOLTS MAX WATTS
LT-1	DRUM SHADE PENDANT 48"	MOSS RETAIL	MOSS RETAIL	934112, 48" WIDE x 20" HIGH, POLY FLAX SIDES, 17W A-LAMP LED PHILIPS #432187 LAMPS INCLUDED, PROVIDE SUPPORT FOR 50 LBS. BOTTOM TO BE MOUNTED AT HEIGHTS AS SHOWN IN PLAN. P.O. INCLUDED.	120 60-W (4)
	TYPE M, 2'-0" x 4'-0", RECESSED MOUNTED	TO MATCH EXISTING	TBD BY OWNER	LAMPS TO MATCH EXISTING 2x4 FIXTURES.	
	TYPE EM, DUAL HEAD LED EMERGENCY LIGHT	BEST	SPECIALTY LIGHTING	LEDR-1, THERMOPLASTIC LED EMERGENCY LIGHTING UNIT WITH BATTERY PACK. SEE GENERAL NOTES FOR MOUNTING HEIGHTS.	120/277 1.5
	TYPE EX, LED EXIT SIGN	ASTRALITE	SPECIALTY LIGHTING	TPURWEM, SINGLE OR DOUBLE FACE, THERMOPLASTIC LED EXIT LIGHT WITH BATTERY PACK. SEE GENERAL NOTES FOR MOUNTING HEIGHTS.	120/277 2.5
	TYPE EX-2, LED EXIT SIGN	BEST	SPECIALTY LIGHTING	CXTEU2RW-RC, THERMOPLASTIC LED EXIT & LED LAMPS LIGHT WITH BATTERY BACKUP. SEE GENERAL NOTES FOR MOUNTING HEIGHTS.	120/277 5.4
	TYPE S, WHITE, PAR38 GIMBAL RING, TRACK HEAD	CON-TECH LIGHTING	SPECIALTY LIGHTING	CTL838/ZE-60-P, LAMP WITH 1 PHILIPS 46776 13.5PAR38/AMB/F25/830/DIM ULW (50000 HOUR LAMP).	120
	TYPE T4, WHITE	CON-TECH LIGHTING	SPECIALTY LIGHTING	LT-4-P, 4'-0" SINGLE CIRCUIT SURFACE TRACK. TO BE MOUNTED AT 11'-0" AFF UNLESS NOTED OTHERWISE.	120
	TYPE T8, WHITE	CON-TECH LIGHTING	SPECIALTY LIGHTING	LT-8-P, 8'-0" SINGLE CIRCUIT SURFACE TRACK. TO BE MOUNTED AT 11'-0" AFF UNLESS NOTED OTHERWISE.	120
	LAMP FOR TYPE S	PHILIPS	VOSS LIGHTING	PHILIPS 46776 13.5PAR38/AMB/F25/830/DIM ULW (50,000 HOUR LAMP).	13.5
	EXISTING TO REMAIN	EXISTING TO REMAIN		ALL NON-OPERATIONAL FIXTURES AND/OR LAMPS MUST BE REPLACED WITH EQUAL.	
	EXISTING TO REMAIN	EXISTING TO REMAIN		ALL NON-OPERATIONAL FIXTURES AND/OR LAMPS MUST BE REPLACED WITH EQUAL.	
	EXISTING TO REMAIN	EXISTING TO REMAIN		ALL NON-OPERATIONAL FIXTURES AND/OR LAMPS MUST BE REPLACED WITH EQUAL.	
	EXISTING TO REMAIN	EXISTING TO REMAIN		ALL NON-OPERATIONAL FIXTURES AND/OR LAMPS MUST BE REPLACED WITH EQUAL.	
	EXISTING RELOCATED	EXISTING RELOCATED PER PLAN		ALL NON-OPERATIONAL FIXTURES AND/OR LAMPS MUST BE REPLACED WITH EQUAL.	



GENERAL FLOORING NOTES

- A. INSTALLATION: INSTALL PER FLOORING PLAN
 - a. PATCH, LEVEL, AND/OR SKIM ALL DAMAGED, LOOSE OR UNEVEN AREAS.
 - b. PREP FLOOR ACCORDING TO MANUFACTURER'S INSTRUCTIONS.
 - c. FLOORING TRANSITION AT DOORWAYS TO BE CENTERED ON DOOR PANEL WHEN DOOR IS CLOSED.
 - d. FLOORING TRANSITIONS AT OTHER OPENINGS TO BE LOCATED AS SHOWN ON PLAN.
 - e. ALL TRANSITION STRIPS TO BE CTC BRONZE UNLESS NOTED OTHERWISE.
 - f. ALL FLOORING ANGLES TO BE 90° AND/OR 45° ANGLES UNLESS NOTED OTHERWISE.
 - g. SHAW CARPET AND LUXURY VINYL TILE TO BE INSTALLED ACCORDING TO THE MANUFACTURER'S REQUIREMENTS.
 - D. ALL FLOORING QUANTITIES TO BE MEASURED AND VERIFIED BY THE OWNER AND/OR THE FLOORING CONTRACTOR PRIOR TO INSTALLATION.
- E. J + J INVINISION CARPET TO BE INSTALLED ACCORDING TO THE MANUFACTURER'S REQUIREMENTS.
 - a. REQUIRED CARPET ADHESIVE:
 - J + J INVINISION COMMERCEON 600 PREMIUM CARPET ADHESIVE.
 - COVERAGE RATE IS 40 YDS/PAIL FOR NEW INSTALL. 32 YDS/PAIL FOR EXISTING FLOORING.
 - b. REQUIRED CARPET SEAM SEALER:
 - J + J INVINISION COMMERCEON PREMIUM CARPET SEAM SEALER.
 - COVERAGE RATE IS 600 YD²/QUART.
 - c. REQUIRED TROWEL SIZE FOR J + J INVINISION CARPET:
 - THE MINIMUM TROWEL SIZE TO BE USED FOR THE INSTALLATION OF PREMIERBAC PLUS, ENDURE PLUS, AND TITANBAC PLUS IS A U-NOTCH 1/8" W X 1/8" D X 1/8" S. FLOOR CONDITIONS MAY REQUIRE A TROWEL WITH DEEPER NOTCHES.
 - d. J + J INVINISION ADHESIVE AND SEAM SEALER ARE REQUIRED TO ENSURE PROPER INSTALLATION TO SECURE THE BEST QUALIFIED LABOR, CONTACT A CFI CERTIFIED INSTALLER WITH A C-2 CLASSIFICATION, TO LOCATE A CFI INSTALLER GO TO CFINSTALLERS.COM.
- F. USF CONTRACT ENGINEERED LVT TO BE INSTALLED ACCORDING TO THE MANUFACTURER'S REQUIREMENTS.
- G. CONTACTS:
 - a. CTC: LOCAL DEALER
 - b. SHAW CONTRACT GROUP: BRAD RYAN 608-345-4149
 - c. J+J INVINISION: CARRIE PERCY 800-241-4586 EXT. 8616

		FLOORING PLAN	
		ROSSELL, NM HOMESTORE & OUTLET	
		1000 S. MAIN ST. ROSSELL, NM 88203	
SHOWROOM AREA 25,827 S.F.		AREA 113,303 S.F.	
RECEIVING AREA 7,779 S.F. (SHARED)			
OTHER AREA 6,957 S.F. (SHARED)			
TOTAL AREA 53,266 S.F.			
NAME J. SLOWIAK			
DATE 11/13/18			
SCALE 3/32"=1'-0"			
SHEET I-101			

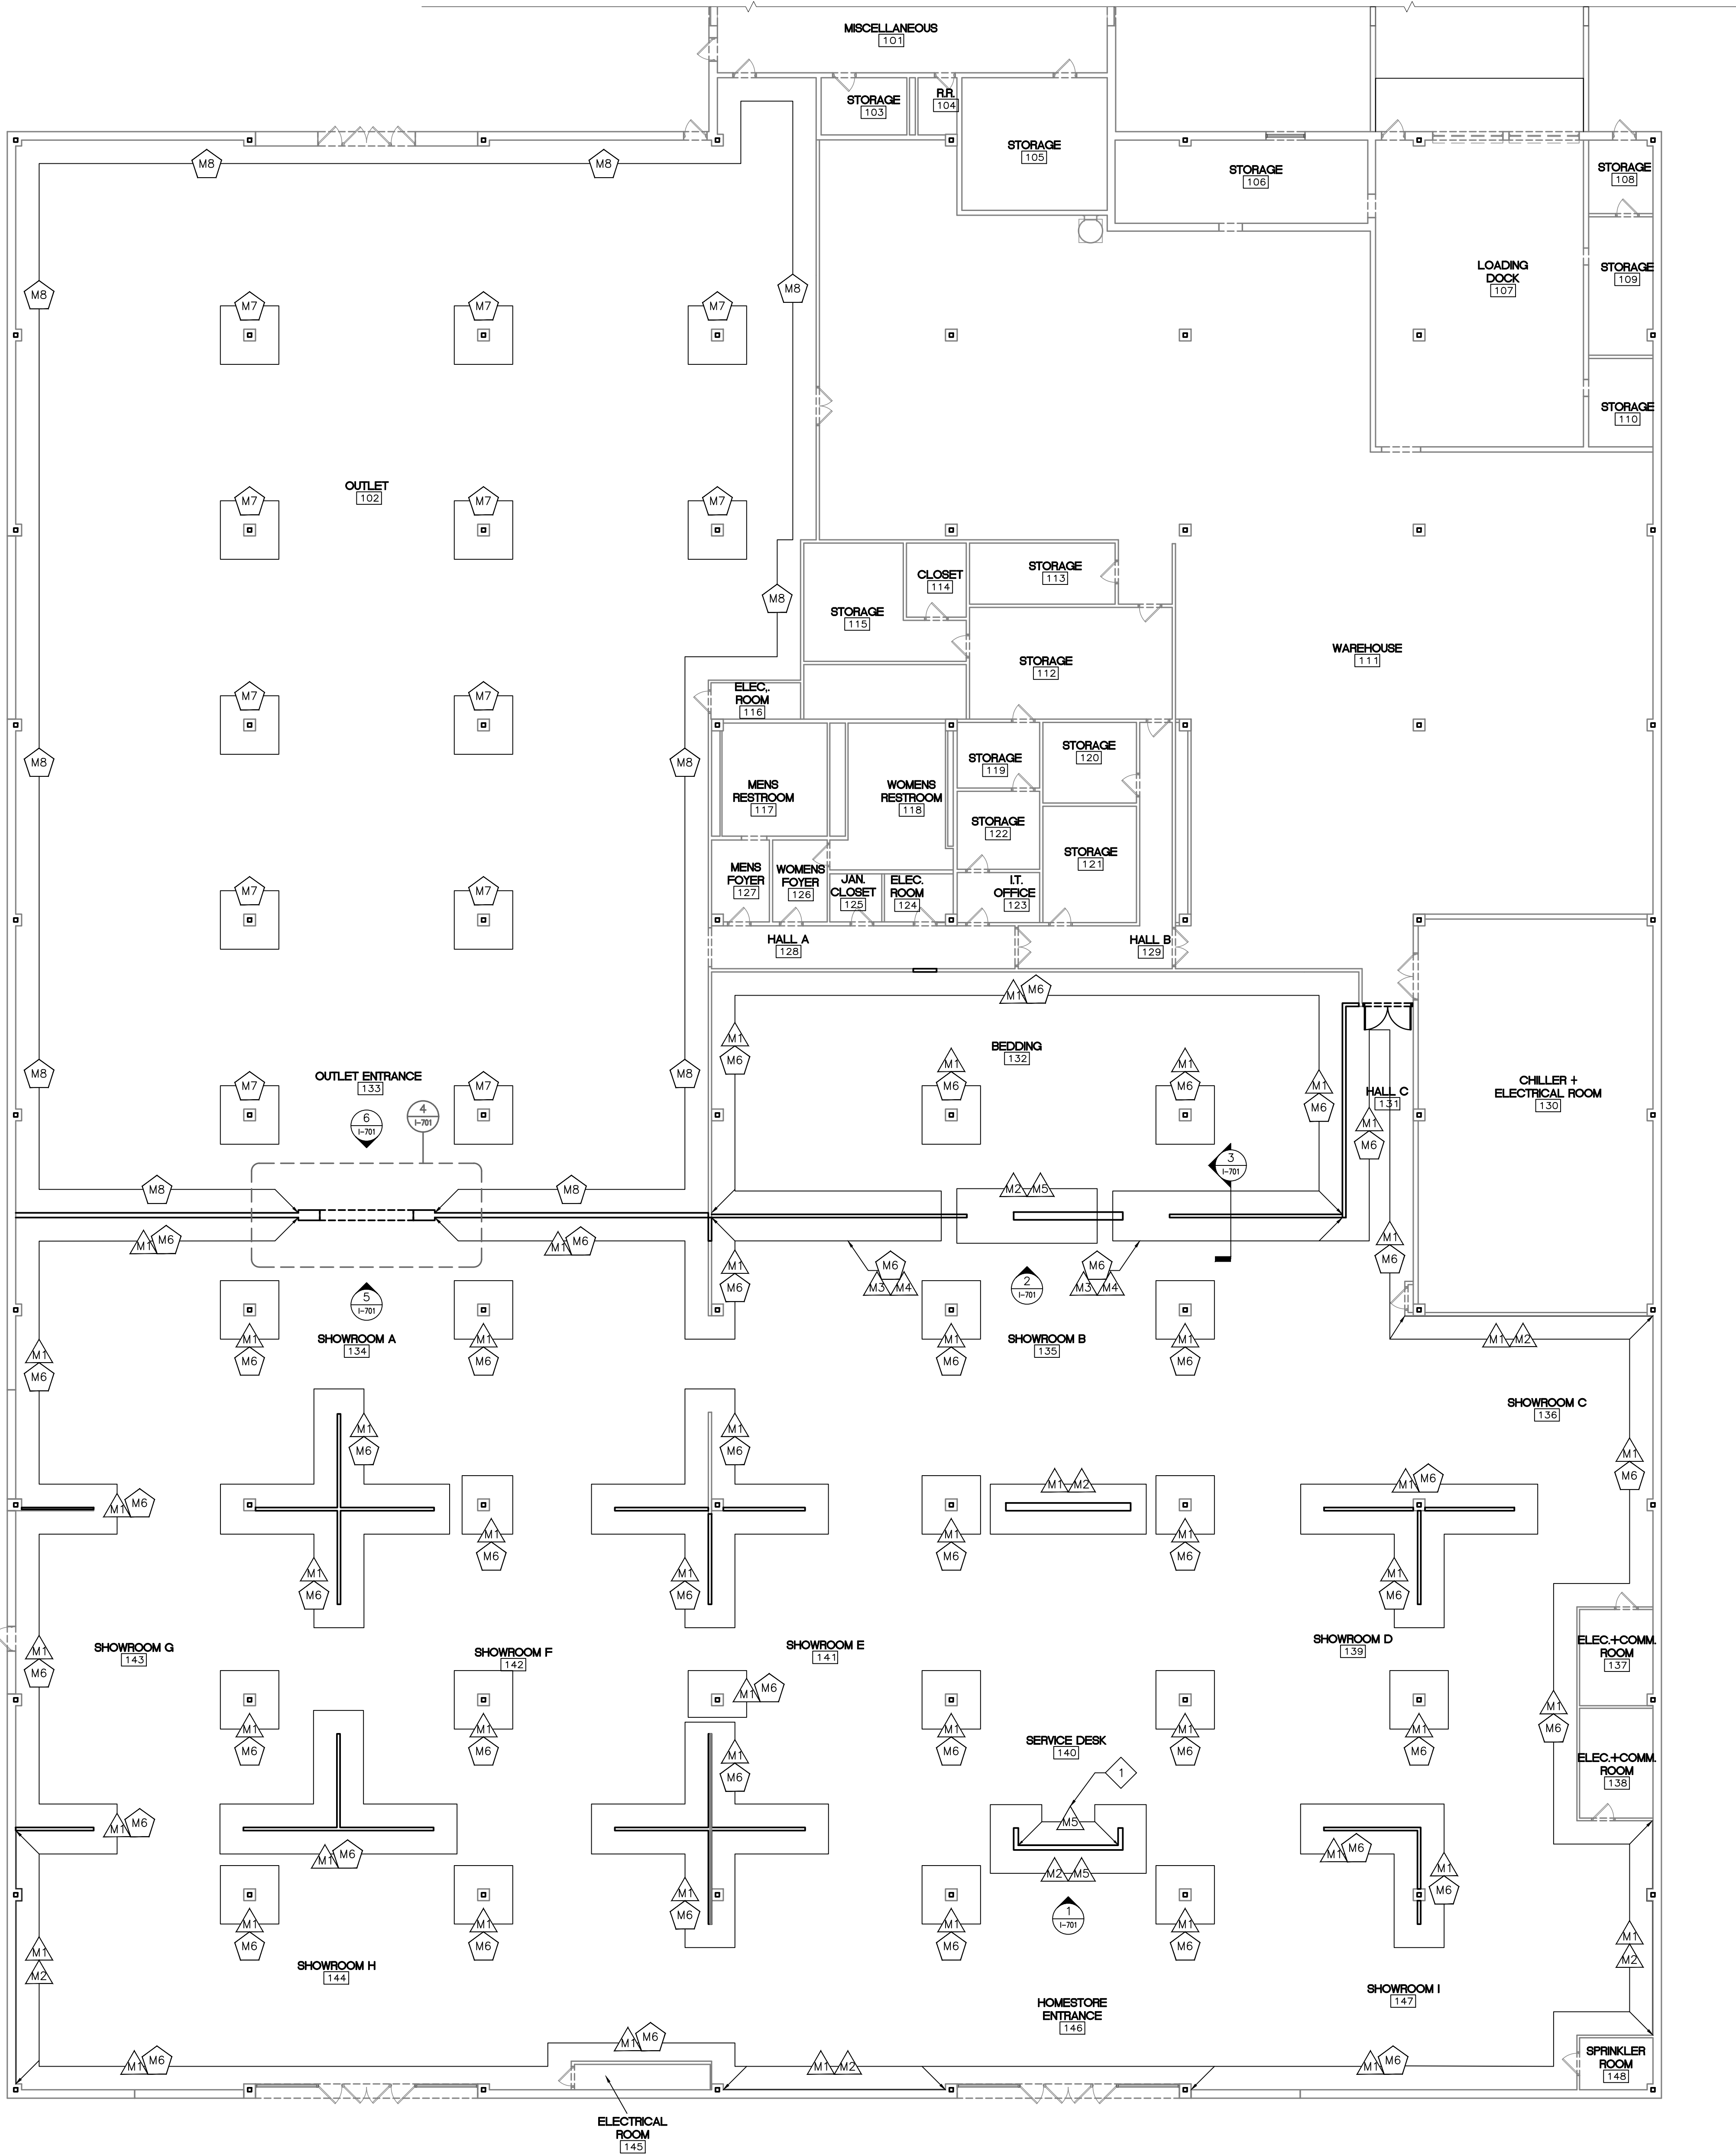

MOLDING PLAN KEY	
SYMBOL	DESCRIPTION
	WOOD BASE OR CROWN (PAINT GRADE)
	RUBBER BASE
	MOLDING SYMBOL CODES: M = MOLDING; # = TYPE

MOLDING PROFILE DIAGRAM	
BASE MOLDING PROFILE	CROWN MOLDING PROFILE

GENERAL MOLDING NOTES

A. REFER TO MOLDING FINISH SCHEDULE FOR INDIVIDUAL FINISH CODES.

B. ALL MOLDING TO BE PAINT GRADE WOOD PAINTED SW7006 EXTRA WHITE, SEMI-GLOSS FINISH, UNLESS NOTED OTHERWISE.

C. PLACE TOP OF CROWN MOLDING AT TOP OF ALL INTERIOR WALLS AND AT 10'-0\" AFF ON ALL PERIMETER WALLS OF THE SHOWROOM UNLESS NOTED OTHERWISE.

D. FREESTANDING COLUMNS TO BE FURRED OUT TO STRUCTURE AND 1'-0\" WIDE WITH TOP OF CROWN MOLDING APPLIED AT 10'-0\" AFF, UNLESS NOTED OTHERWISE.

MOLDING KEYED NOTES	
1. COORDINATE BASE MOLDING WITH MILLWORK DETAILS ON PAGE A-701.	

ASHLEY HOMESTORE MOLDING FINISH SCHEDULE				
CODE	PRODUCT	MANUFACTURER/SUPPLIER	STYLE/COLOR	LOCATION
M-1	WOOD CROWN	TBD BY CONTRACTOR	1x6 MDF, EXTRA WHITE SW7006	MULTIPLE LOCATIONS
M-2	WOOD BASE	TBD BY CONTRACTOR	1x6 POPLAR/BASSWOOD, EXTRA WHITE SW7006	MULTIPLE LOCATIONS
M-3	WOOD MOLDING	TBD BY CONTRACTOR	1x4 MDF, EXTRA WHITE SW7006	BEDDING
M-4	WOOD CAP	TBD BY CONTRACTOR	1x POPLAR/BASSWOOD, EXTRA WHITE SW7006	BEDDING
M-5	WOOD CROWN	TBD BY CONTRACTOR	1x2 POPLAR/BASSWOOD, EXTRA WHITE SW7006	MULTIPLE LOCATIONS
M-6	RUBBER BASE	JOHNSONITE	#32 PEBBLE	MULTIPLE LOCATIONS
M-7	EXISTING BASE	TBD BY CONTRACTOR	N/A	OUTLET ENTRANCE & OUTLET SHOWROOM
M-8	BASE	TBD BY CONTRACTOR	TO MATCH EXISTING	OUTLET ENTRANCE & OUTLET SHOWROOM









1. 1/16" SPACES TO BE PAINTED SW6258 TRICORN BLACK. SEE DETAIL ON PAGE A-701.

2. OPEN CEILING GRID TO BE PAINTED SW7006 EXTRA WHITE, EGGSHELL FINISH. PAINT TO BE SPRAYED NOT BRUSHED. IF BUILT ON SITE, NOT PURCHASED.

3. RACKING UPRIGHTS AND BEAMS TO BE PAINTED OR POWDER COATED TO MATCH SW7025 BACKDROP.

ROSWELL, NM HOMESTORE, NM 1000 S. MAIN ST. ALBUQUERQUE, NM 87102		PRELIMINARY PAINT PLAN	
SHOWROOM A 55,227 S.F. (13,300)		RECEIVING AREA 7,779 S.F. (SHAR)	
OTHER AREA 6,957 S.F. (SHAR)		TOTAL AREA 53,266 S.F.	
NAME J. SLOWIAK		DATE 11/13/18	
SCALE 3/32"=1'-0"		SHEET I-103	

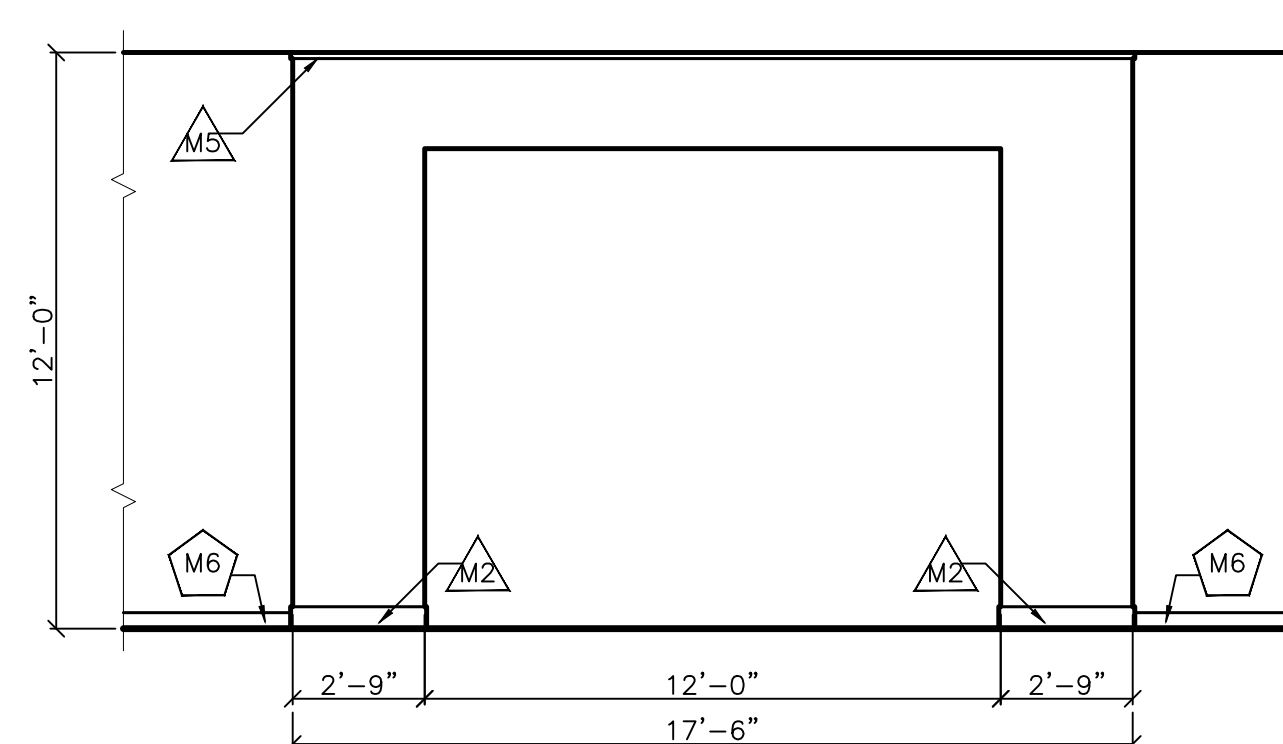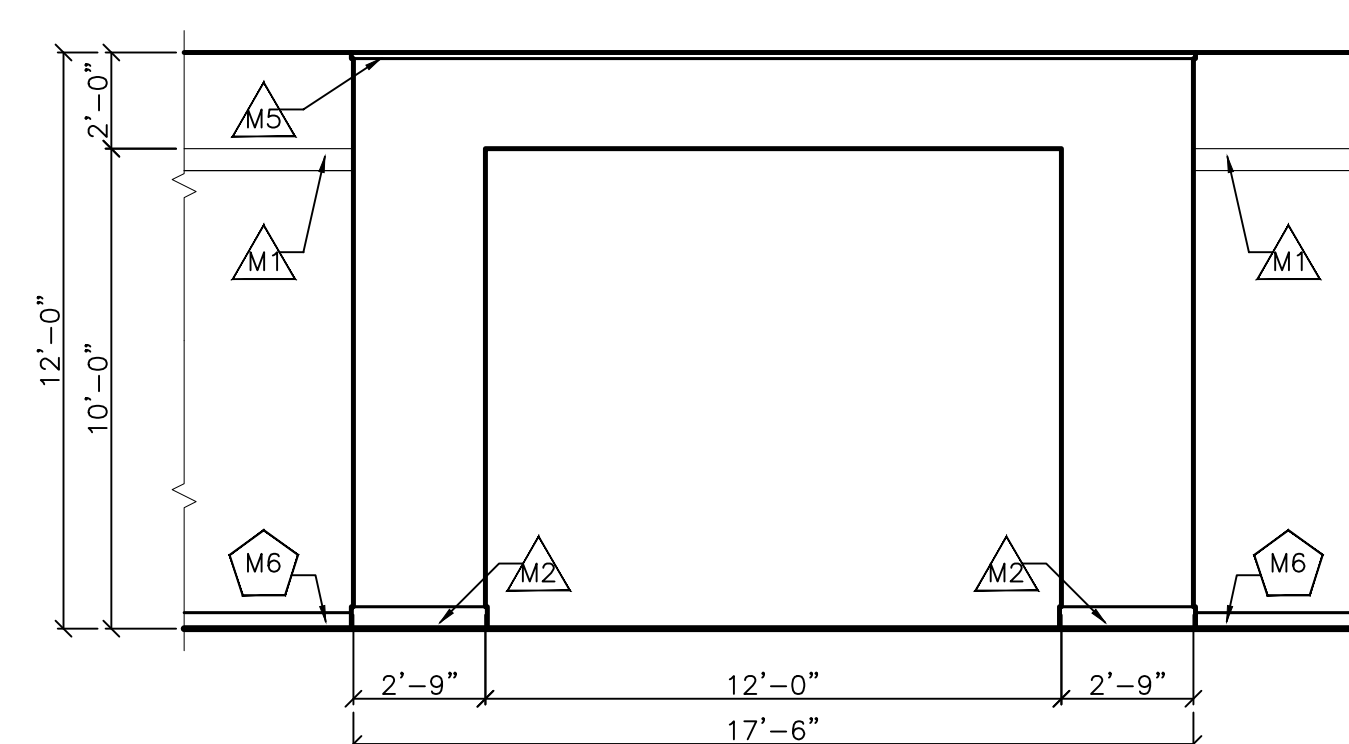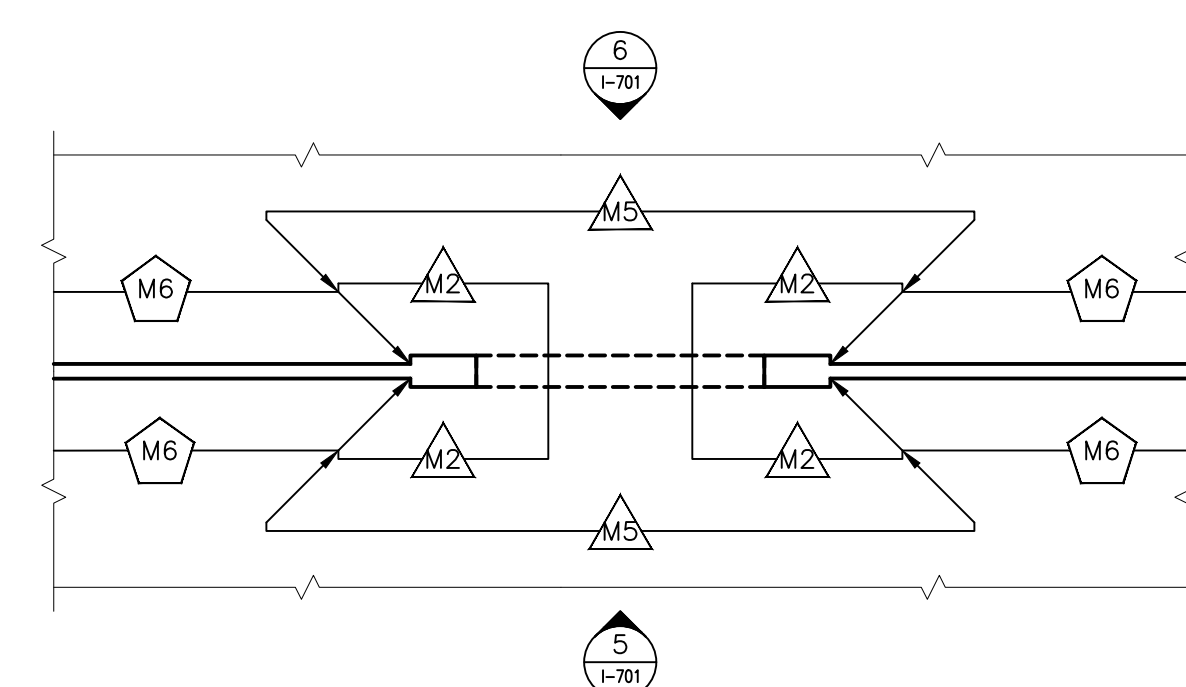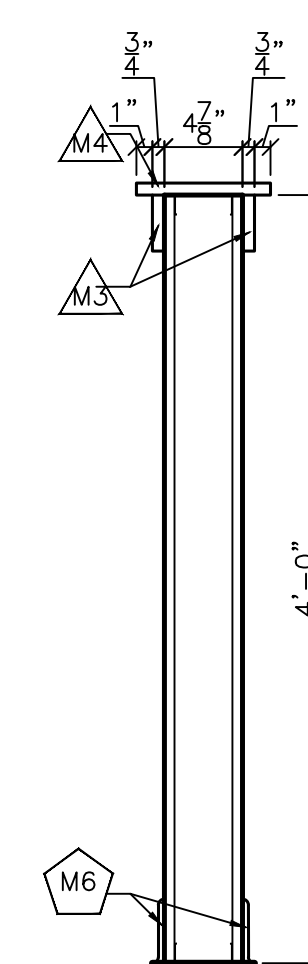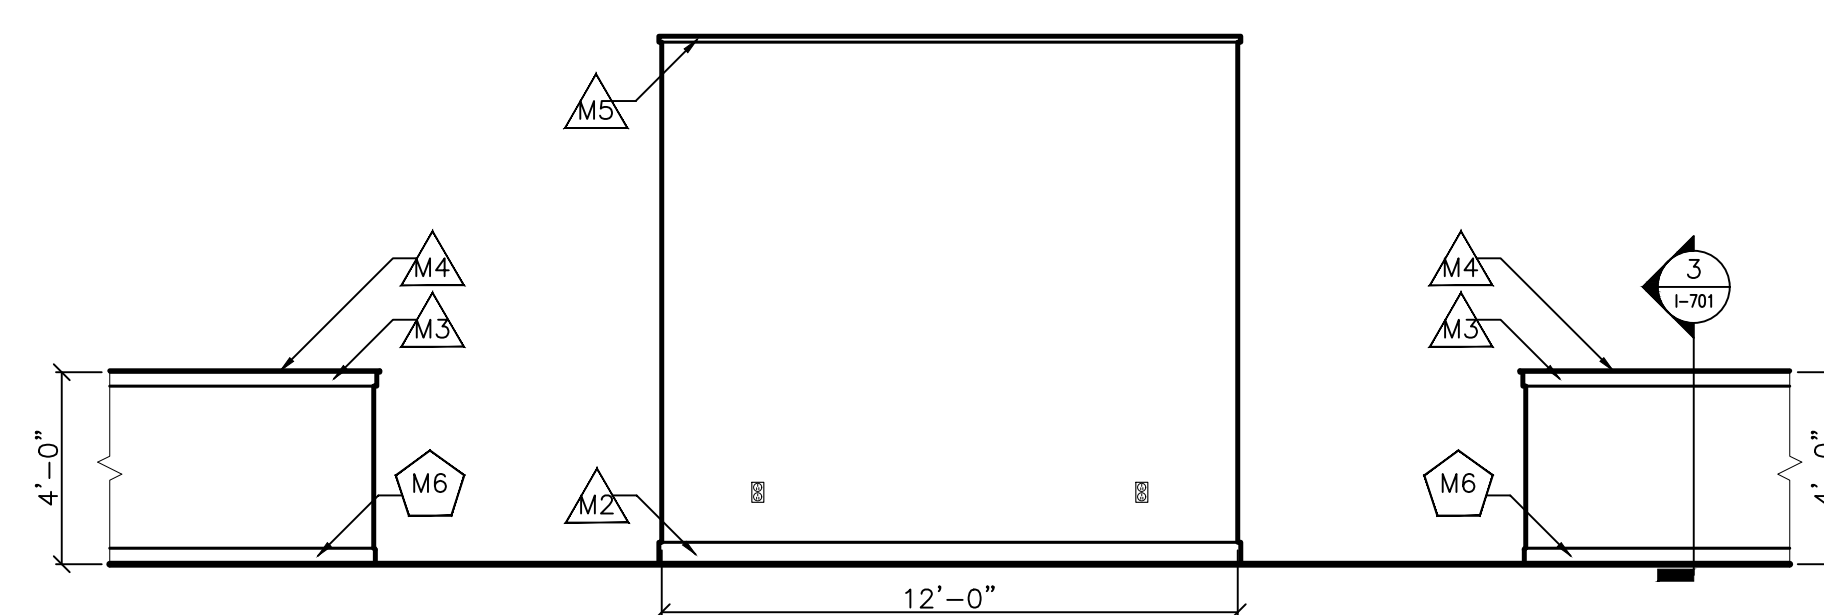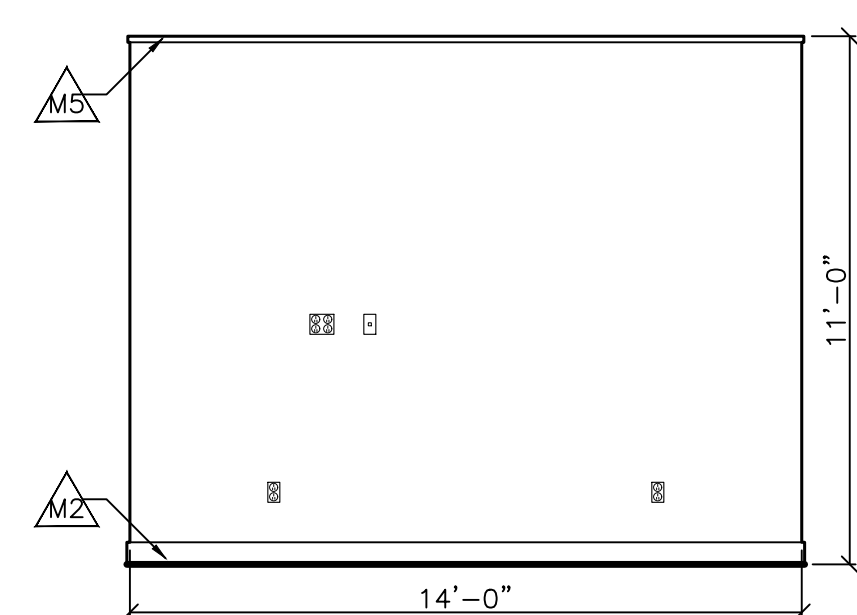

DRAWINGS NOT TO BE USED FOR CONSTRUCTION

[illegible][illegible]

MOLDING DETAILS

ROSWELL, NM
HOMESTORE & OUTLET
 1000 S. MAIN ST.
 ROSWELL, NM 88203

SHOWROOM AREA 25,227 S.F.	RECEIVING AREA 7,778 S.F. (SHARED)	OTHER AREA 6,957 S.F. (SHARED)	TOTAL AREA 53,266 S.F.
NAME J. SLOWIAK			
DATE 11/13/18			
SCALE VARIABLES			
SHEET I-701			

[illegible]

PRELIMINARY PAINT ELEVATIONS

DRAWINGS NOT TO BE USED FOR CONSTRUCTION