


Floor Plan
Scale: 3/32" = 1'-0"

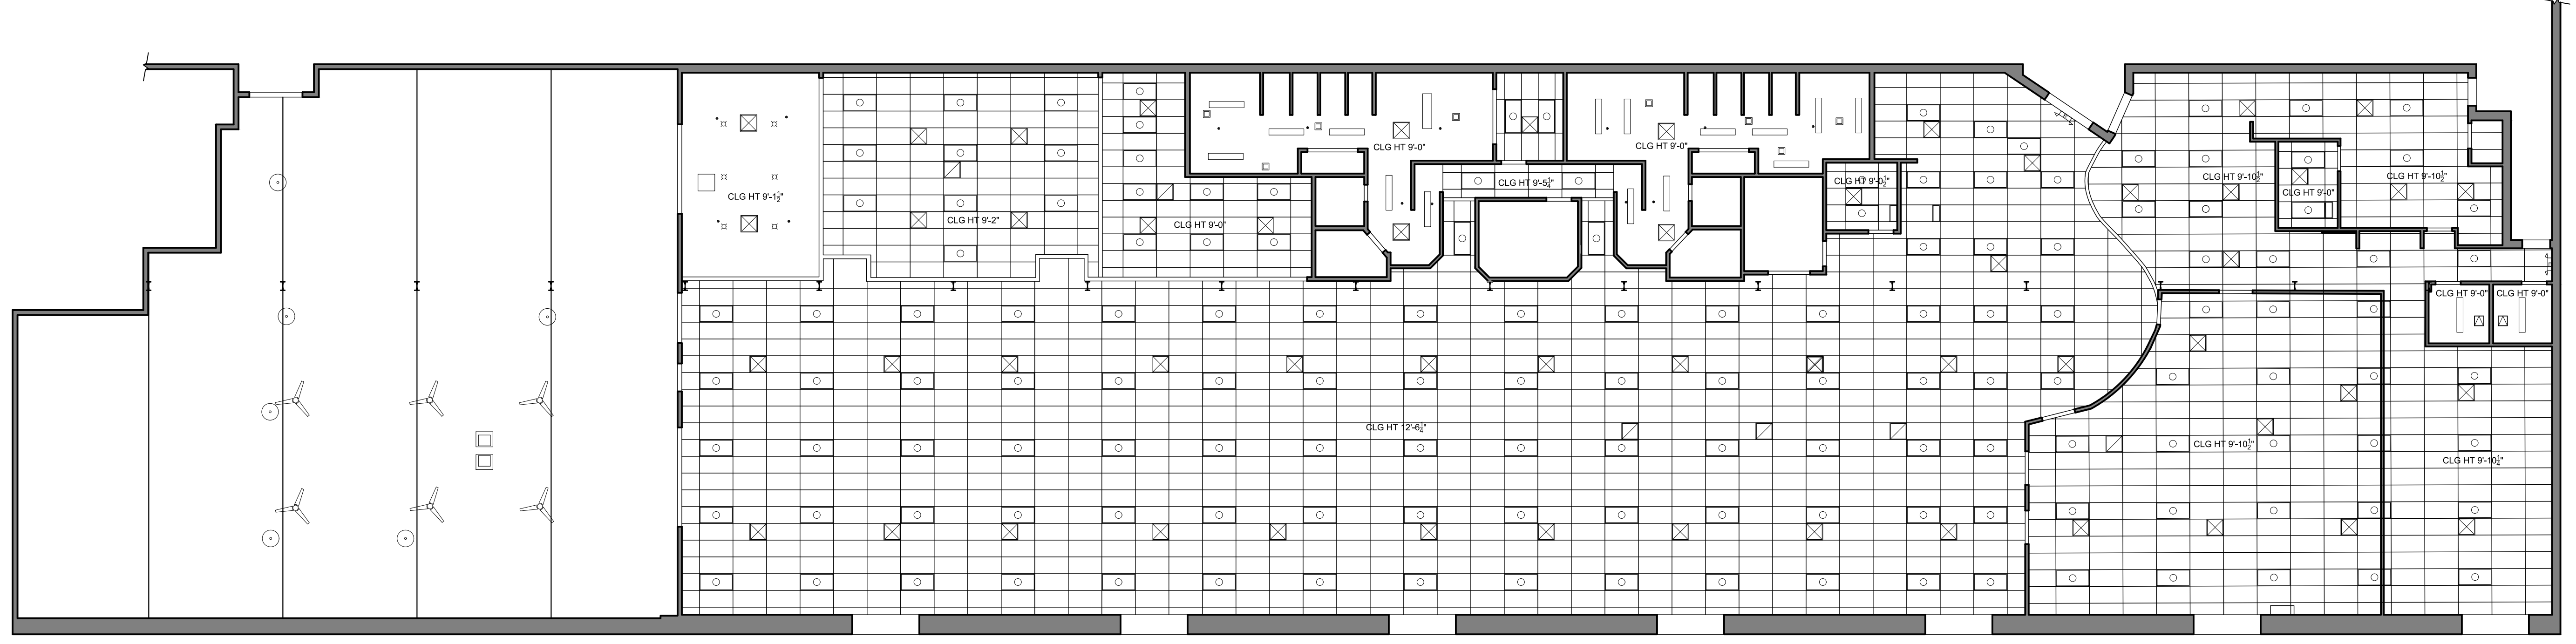

Reflected Ceiling Plan
Scale: 3/32" = 1'-0"

Sheet Information

EX1.0

Project Information

Sheet Issue Date: 02-05-2021
Current Revision Date:
Project Number: 21021
Plans

Professional Stamp

NOT FOR CONSTRUCTION

KEYSTONE COMMONS UNIT GYM

645ADDOCK AVE.,
BRADDOCK, PA 15104

Architects/Engineers/Consultants

cadnetics
measure | create | model | visualize
400 Holiday Drive, Suite 102
Pittsburgh, PA 15220
P: 412.642.2701
F: 412.642.2703
www.cadnetics.com