

CALC ENGINEERING
www.calceng.com
2000 NW 89th PL # 102
DORAL FL 33041
Phone: (305) 848-9995
ENGINEERING BUSINESS
CA CERTIFICATION:
32566
WASOOD HAJALI P.E.
LIC #B20298

REPARATION DUE TO FIRE FOR
AB UNITS @
2930 SW 30th AVE
Pembroke Park, FL 33009

[illegible]MECHANICAL
FLOOR PLAN


Date 03/06/2023

Project Number

M-102

Scale	Drawn By
As Shown	JLH

SW 30th Ave.
PARKING

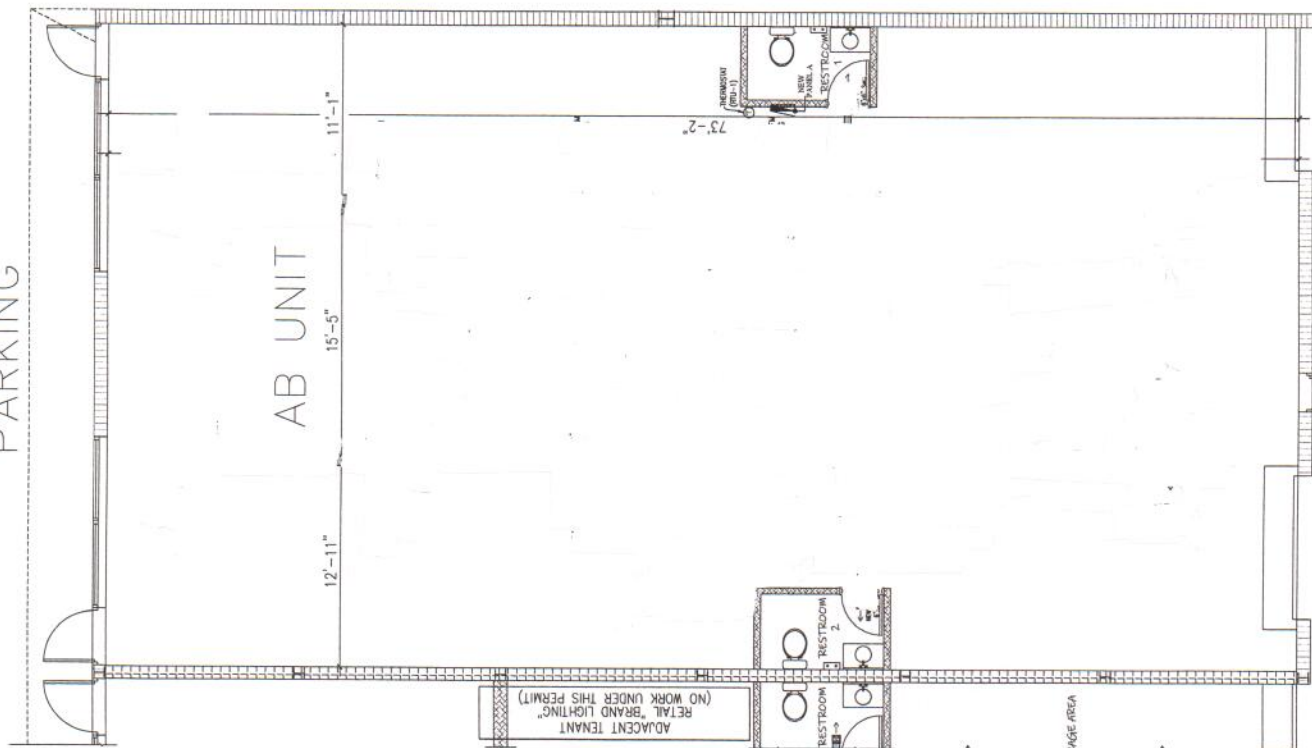


DESIGN IS BASED ON FBC 2020, 7TH EDITION

ALLEY

AB UNIT

AYE

5

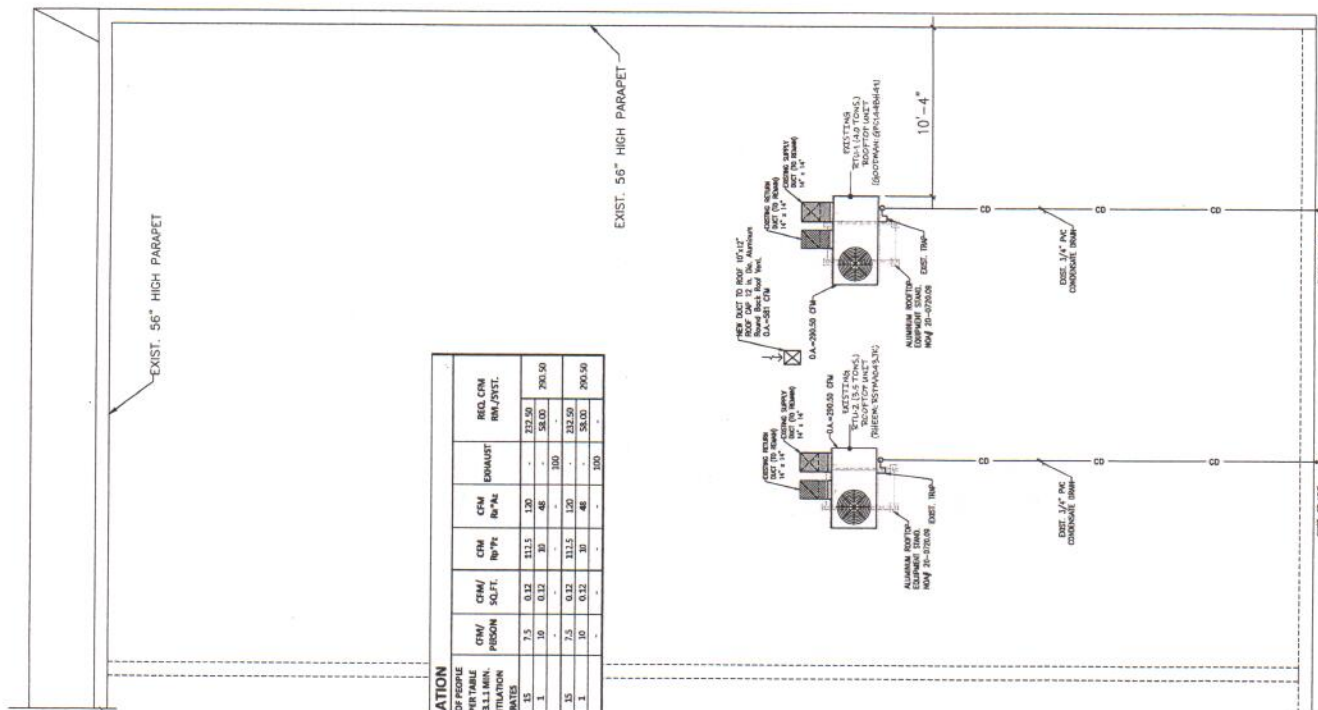[illegible]

MECHANICAL ROOF PLAN

SCALE: 1/4"=1'-0"