


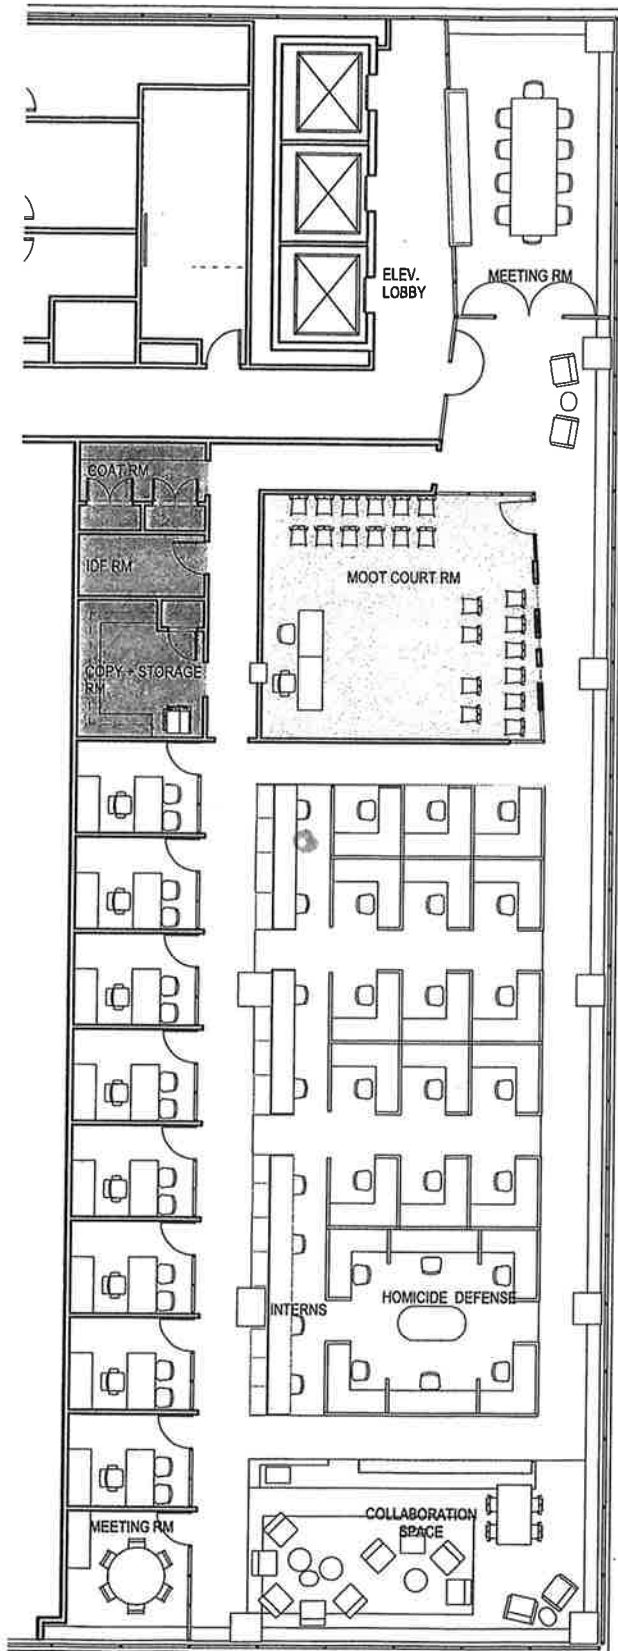

① **LEVEL 4 PLAN**
3/32" = 1'-0"



Project
NDS - 4TH FL
Think! Architecture + Design
1 MetroTech Center North, 6th Floor,
Brooklyn, NY 11201

Title
4TH FLOOR PLAN
317 Lenox Ave. 4th Floor,
New York, NY 10027

Date
07.14.2020
Drawing No.
SD-100