


REVISIONS	DESCRIPTION	
	NO.	DATE

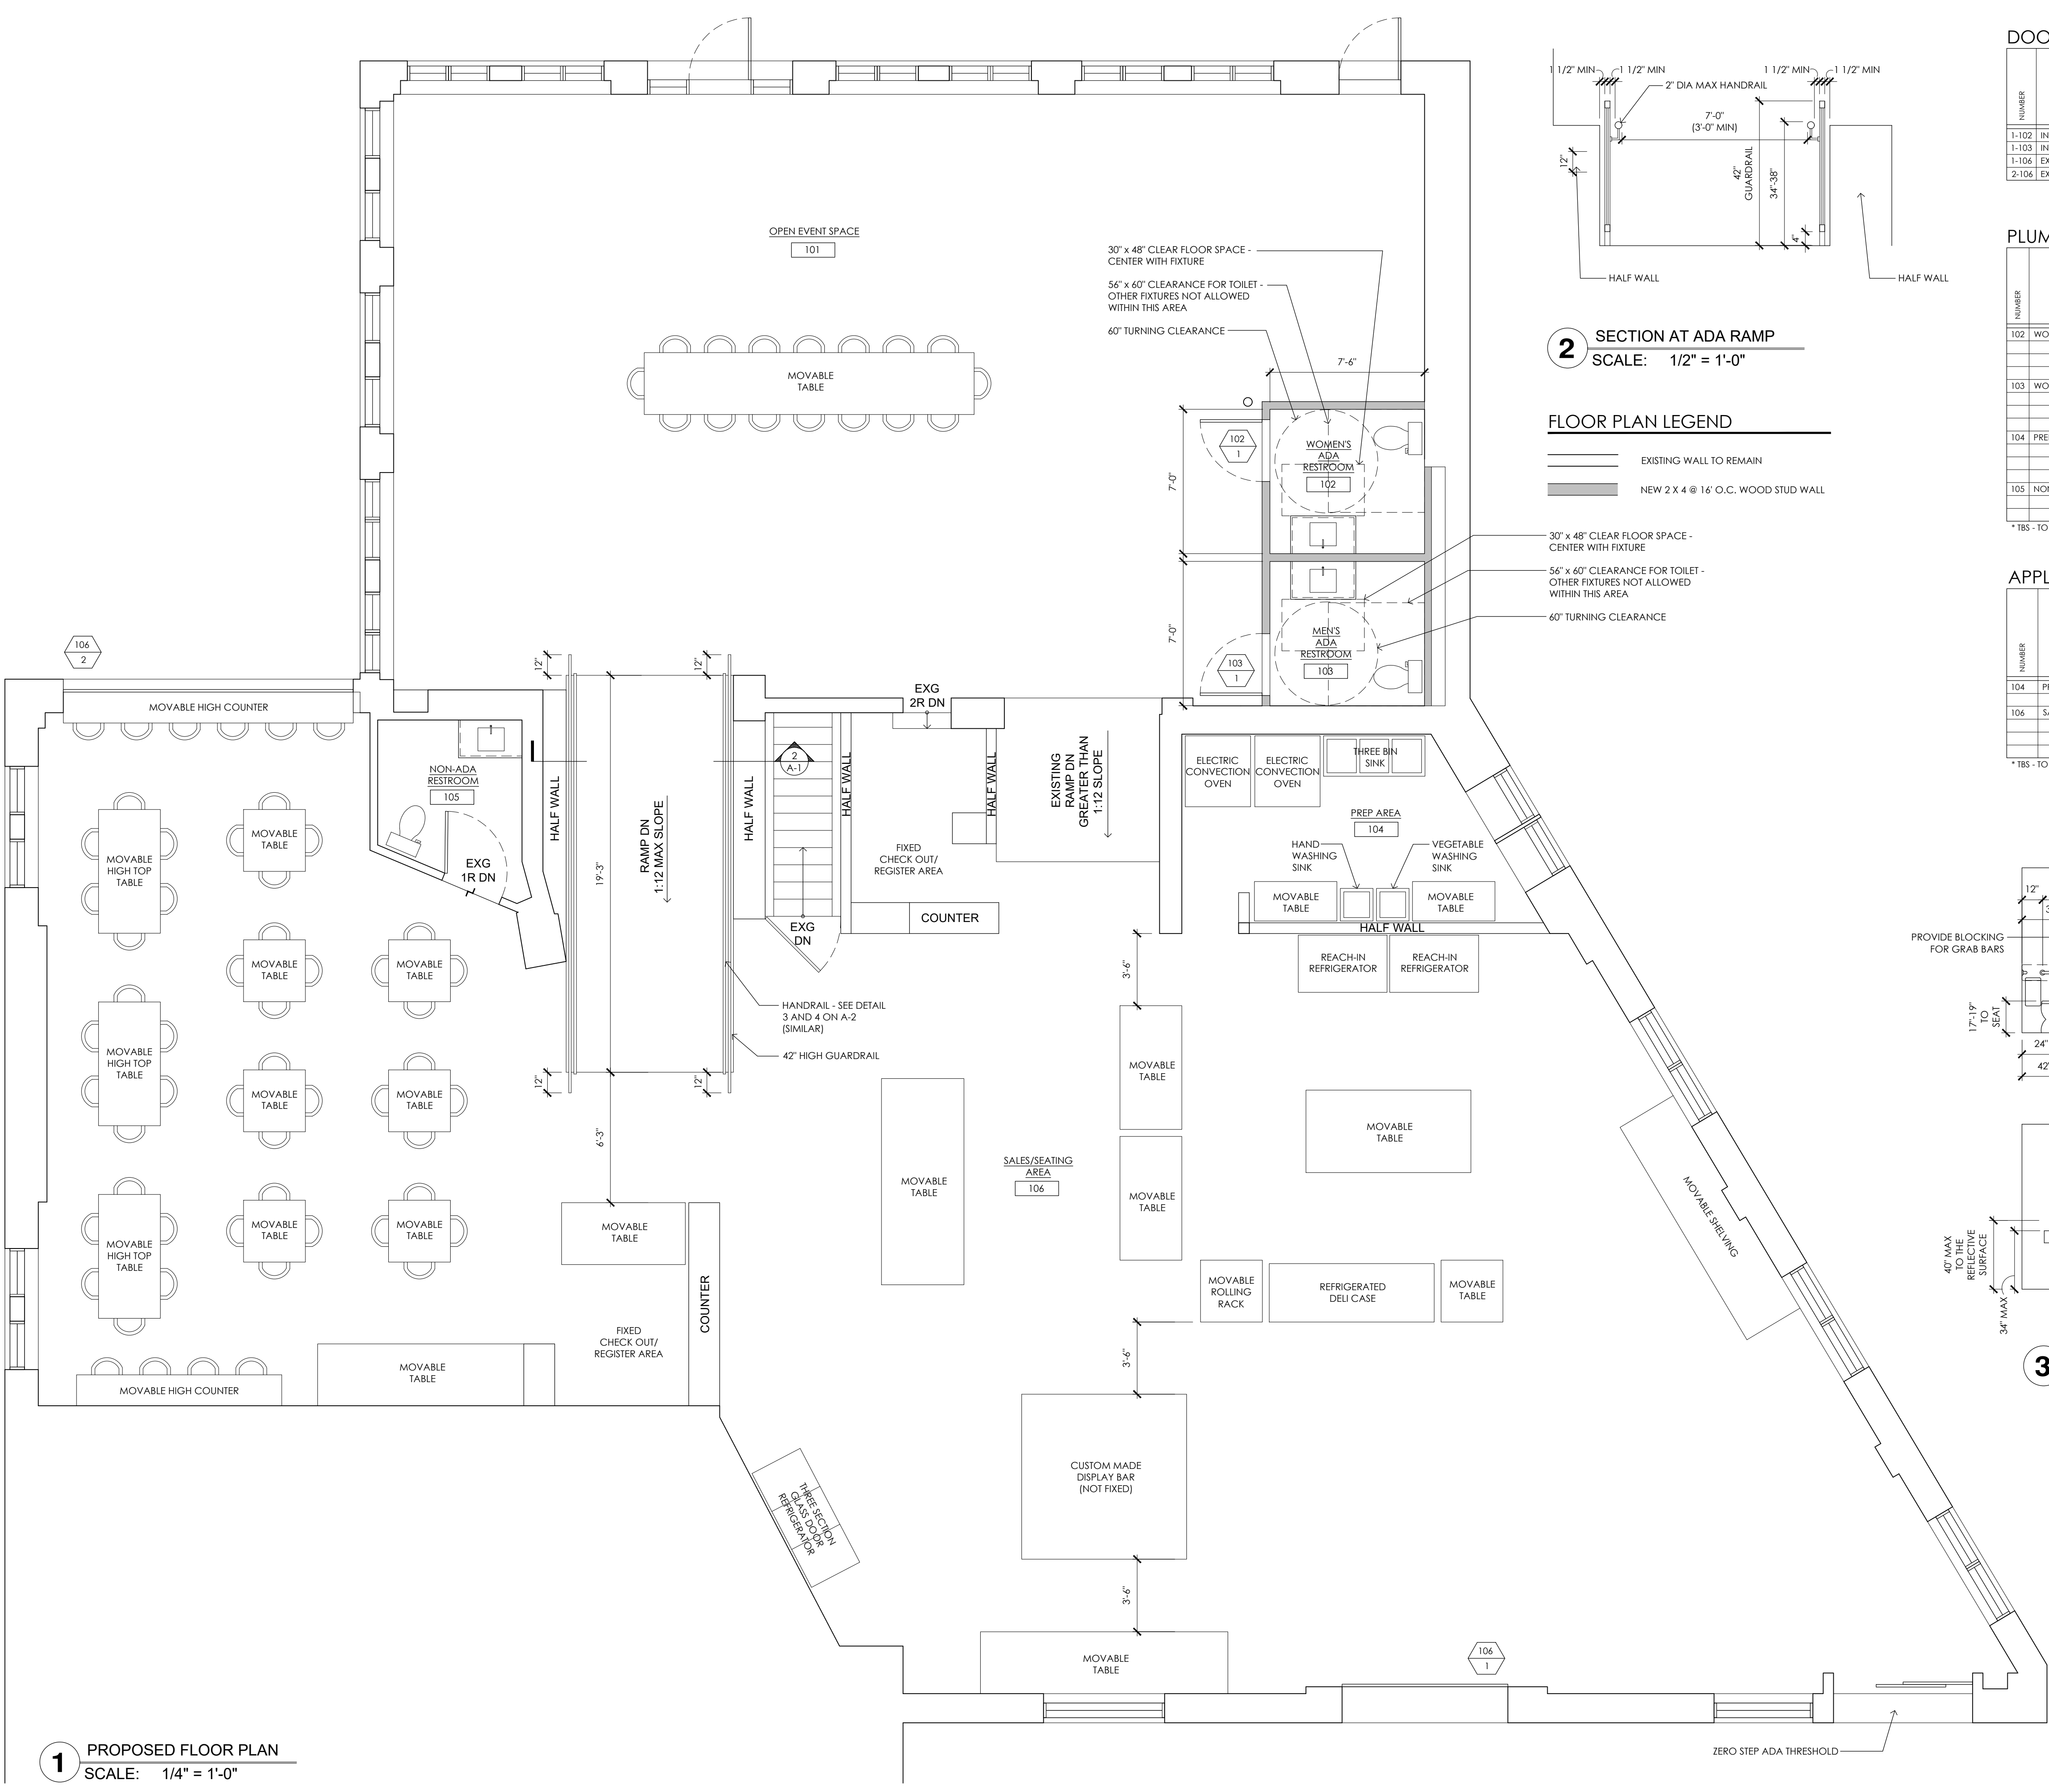


2 SECTION AT ADA RAMP
SCALE: 1/2" = 1'-0"

FLOOR PLAN LEGEND

- EXISTING WALL TO REMAIN
- ▬ NEW 2 X 4 @ 16" O.C. WOOD STUD WALL

3 MEN'S ADA RESTROOM DETAILS (WOMEN'S SIMILAR)
SCALE: 1/4" = 1'-0"

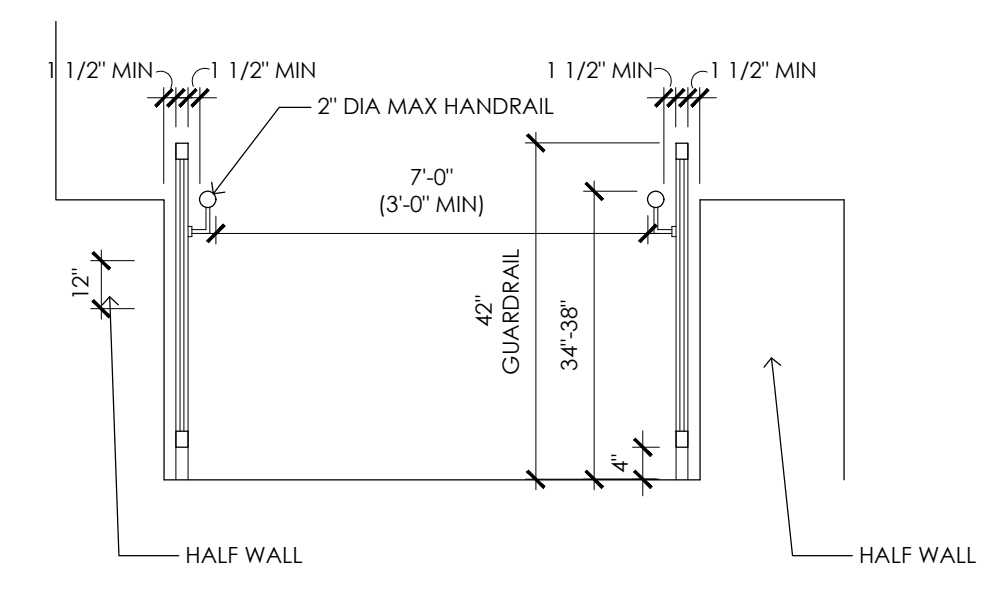

DOOR SCHEDULE

NUMBER	DOOR MAKE MANUFACTURER CATALOG NUMBER	DOOR LEAF SIZE			REMARKS
		WIDTH	HEIGHT	THICKNESS	
1-102	INTERIOR DOOR	3'-0"	6'-8"	1 3/8"	---
1-103	INTERIOR DOOR	3'-0"	6'-8"	1 3/8"	---
1-104	EXTERIOR DOOR	6'-0"	V.I.F.	1 3/4"	GLASS ROLLING DOOR
2-104	EXTERIOR DOOR	14'-0"	V.I.F.	1 3/4"	GLASS ROLLING DOOR

PLUMBING FIXTURE SCHEDULE


NUMBER	ROOM NAME	DESCRIPTION	MANUFACTURER	REMARKS
102	WOMEN'S ADA RESTROOM	SINK BOWL	* TBS	---
		SINK FAUCET	* TBS	---
		TOILET	* TBS	---
103	WOMEN'S ADA RESTROOM	SINK BOWL	* TBS	---
		SINK FAUCET	* TBS	---
		TOILET	* TBS	---
104	PREP AREA	THREE BIN UTILITY SINK	* TBS	---
		HAND WASHING SINK	* TBS	---
		VEGETABLE WASHING SINK	* TBS	---
105	NON-ADA RESTROOM	SINK BOWL	* TBS	---
		SINK FAUCET	* TBS	---
		TOILET	* TBS	---

* TBS - TO BE SELECTED BY OWNER

APPLIANCE SCHEDULE

NUMBER	ROOM NAME	DESCRIPTION	MANUFACTURER	MODEL NAME	MODEL NUMBER	REMARKS
104	PREP AREA	ELECTRIC CONVECTION OVENS	* TBS	* TBS	* TBS	---
104	SALES/SEATING AREA	REFRIGERATED DELI CASE	* TBS	* TBS	* TBS	---
		REACH-IN REFRIGERATOR	* TBS	* TBS	* TBS	---
		REACH-IN REFRIGERATOR	* TBS	* TBS	* TBS	---
		THREE DOOR GLASS DOOR REFRIGERATOR	* TBS	* TBS	* TBS	---

* TBS - TO BE SELECTED BY OWNER

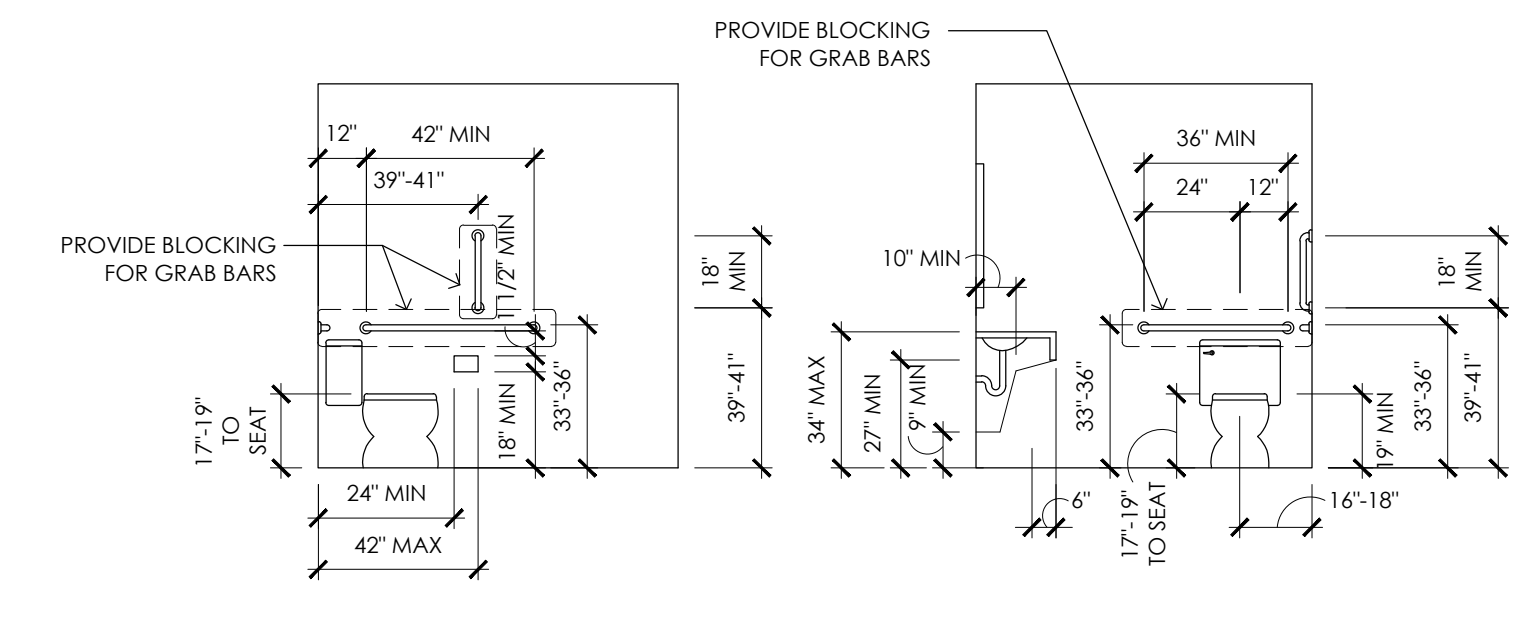

RESTROOM NOTES:
 PROVIDE ADA-APPROVED INSULATION ON ALL EXPOSED PIPING
 ALL OPERABLE SWITCHES AND RECEPTACLES TO MEET ADA-APPROVED HEIGHTS OFF FINISHED

BUILDING DESIGN OCCUPANT LOAD

MERCANTILE (GROUND FLOOR) - 30 GROSS	1,976 SF/30 = 66
ASSEMBLY - UNCONCENTRATED (TABLE AND CHAIRS) - 15 NET	2,242 SF/15 = 150
COMMERCIAL KITCHEN - 200 GROSS	145 SF/200 = 1
TOTAL OCCUPANT LOAD	217

1 PROPOSED FLOOR PLAN
SCALE: 1/4" = 1'-0"

ZERO STEP ADA THRESHOLD