

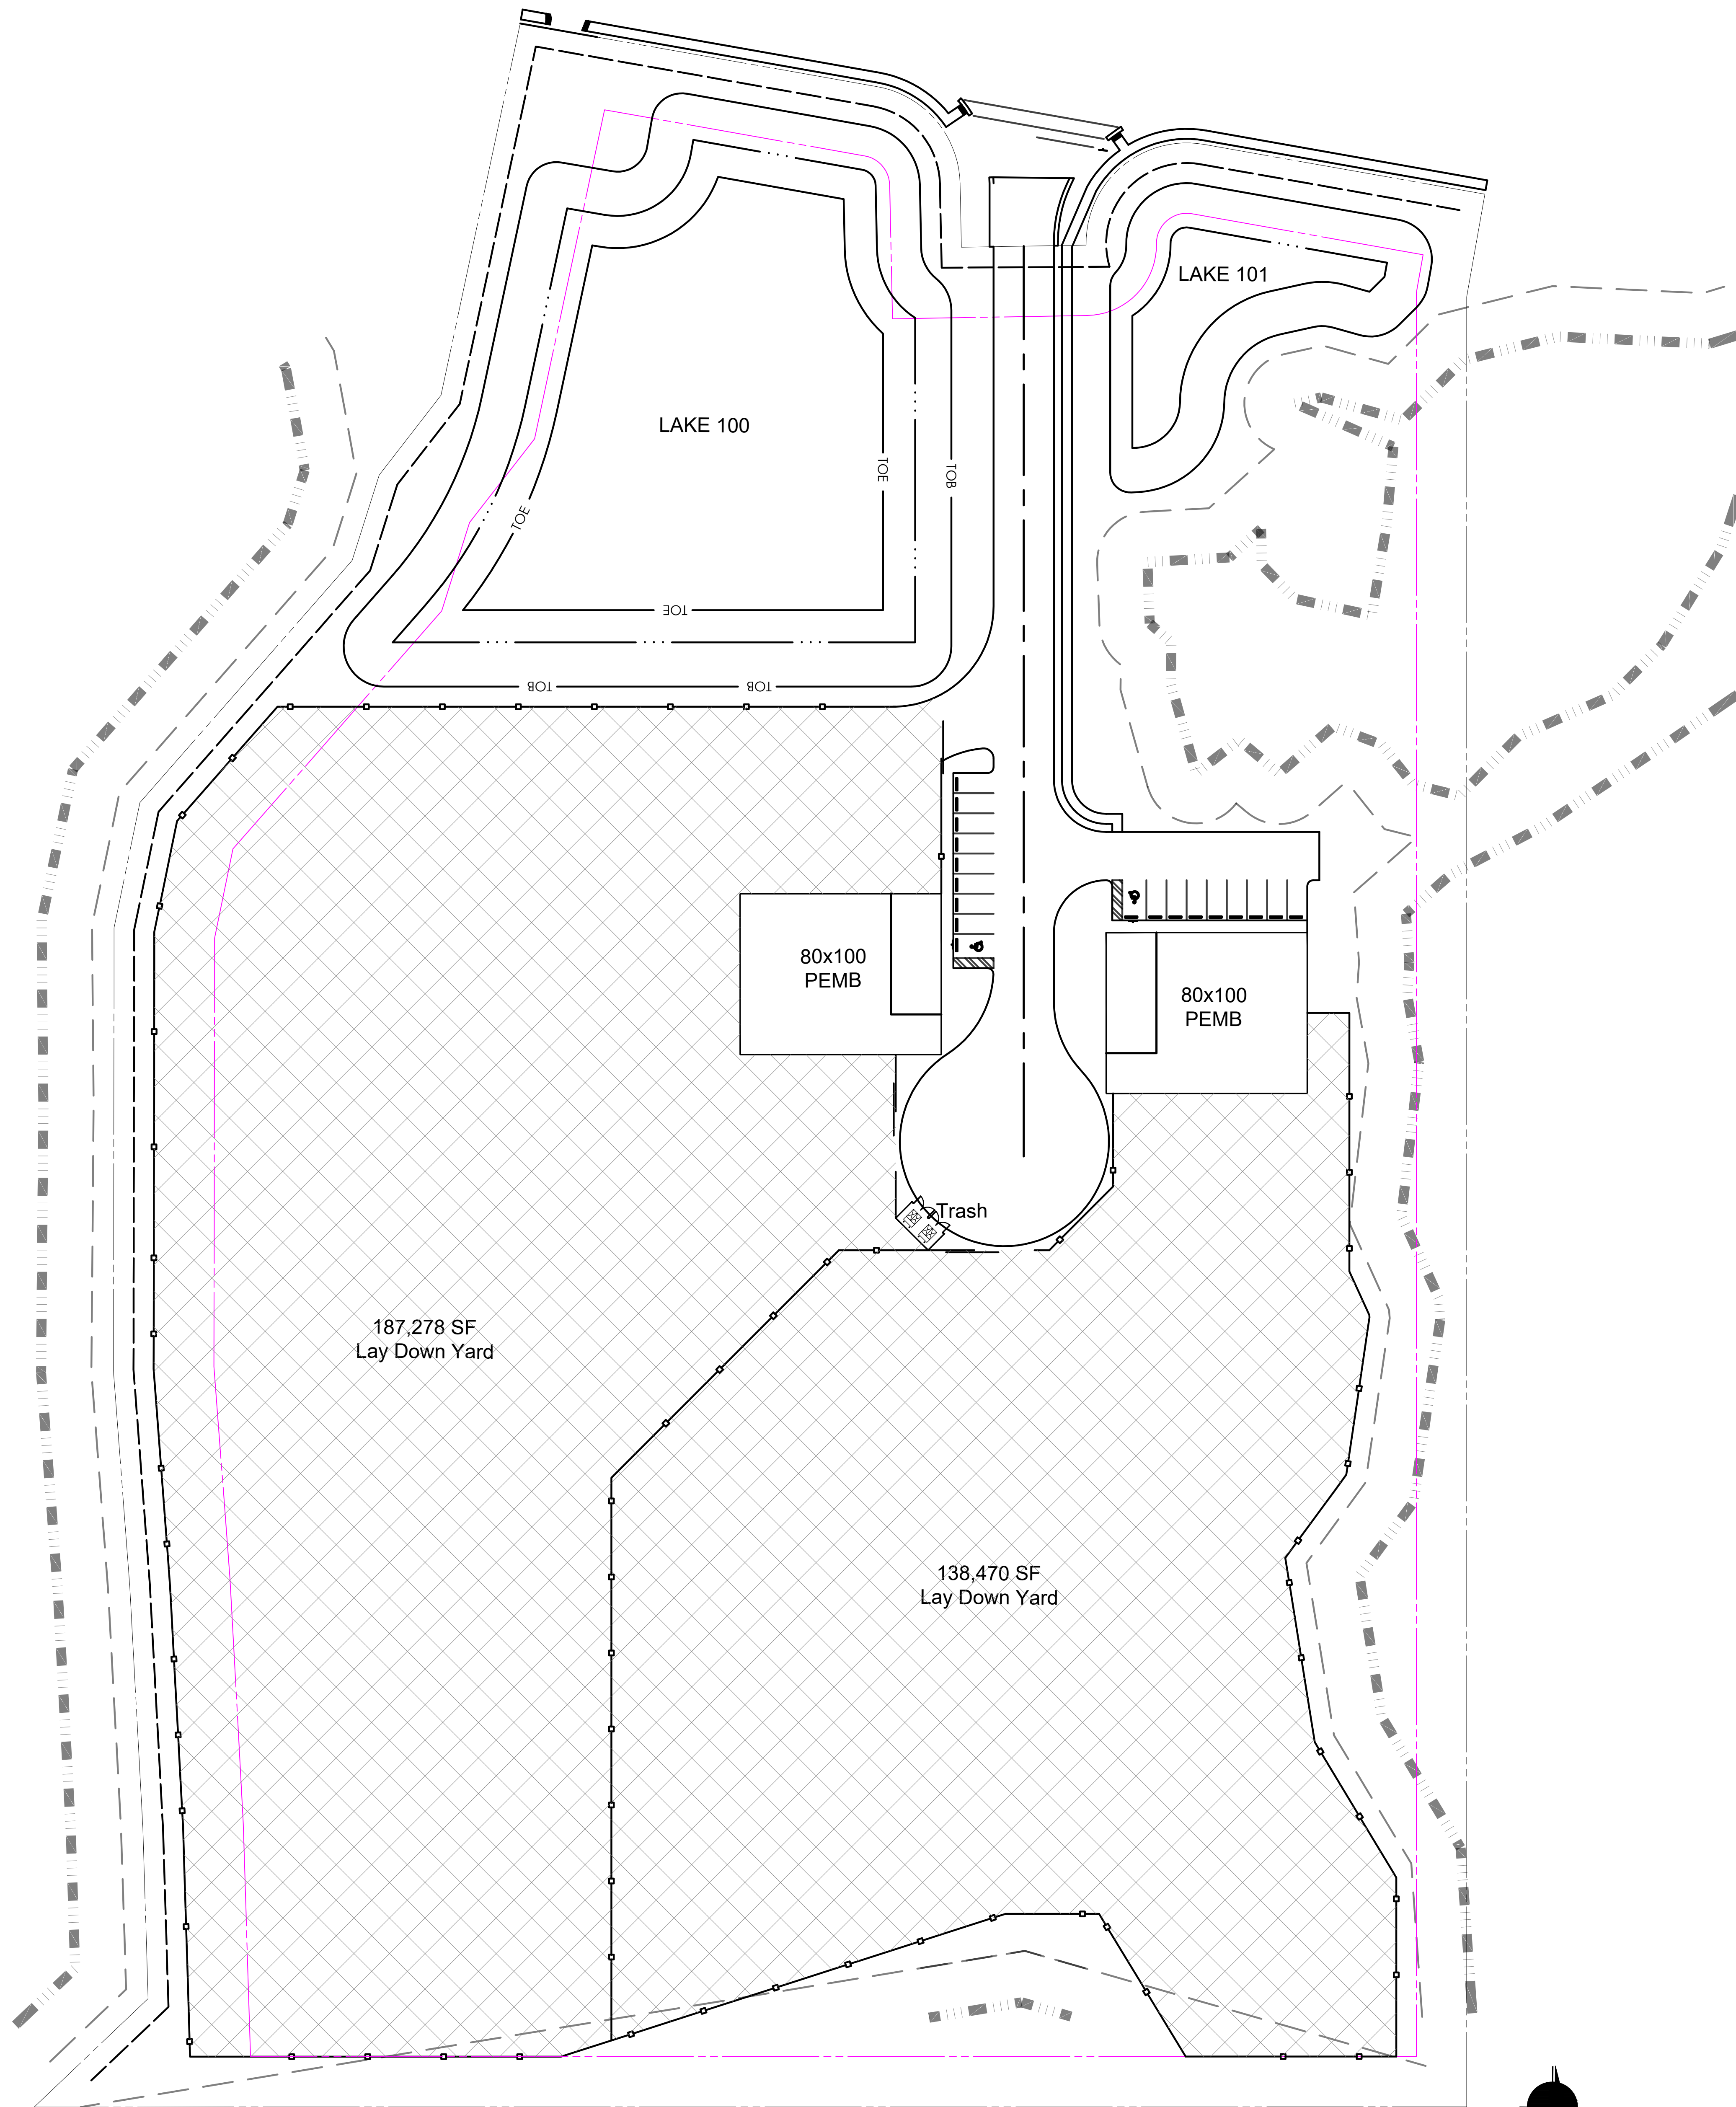


K:\2026 Jobs\26-D-317 Montcreek - Plant City, FL\Siteplan 4.dwg Thu, Jul 02, 2026, 10:28am

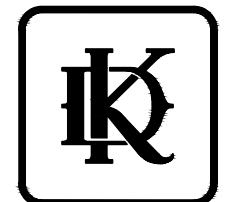

1 | Proposed Site Plan

Scale: 1" = 40'-0"

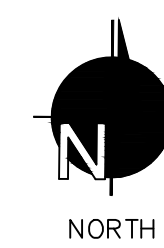

KATUS
DESIGN GROUP

166 Hargraves Drive,
Suite C-400
Austin, Texas 78737
Voice: 512/407/8380

Industrial Outdoor Storage for Montcreek
Henderson Way,
Plant City, Florida 33563

Date:
07/02/2026
Revisions:

Project No:
26-D-317
Sheet Title:
Proposed
Site Plan

Sheet No:

A0.1