















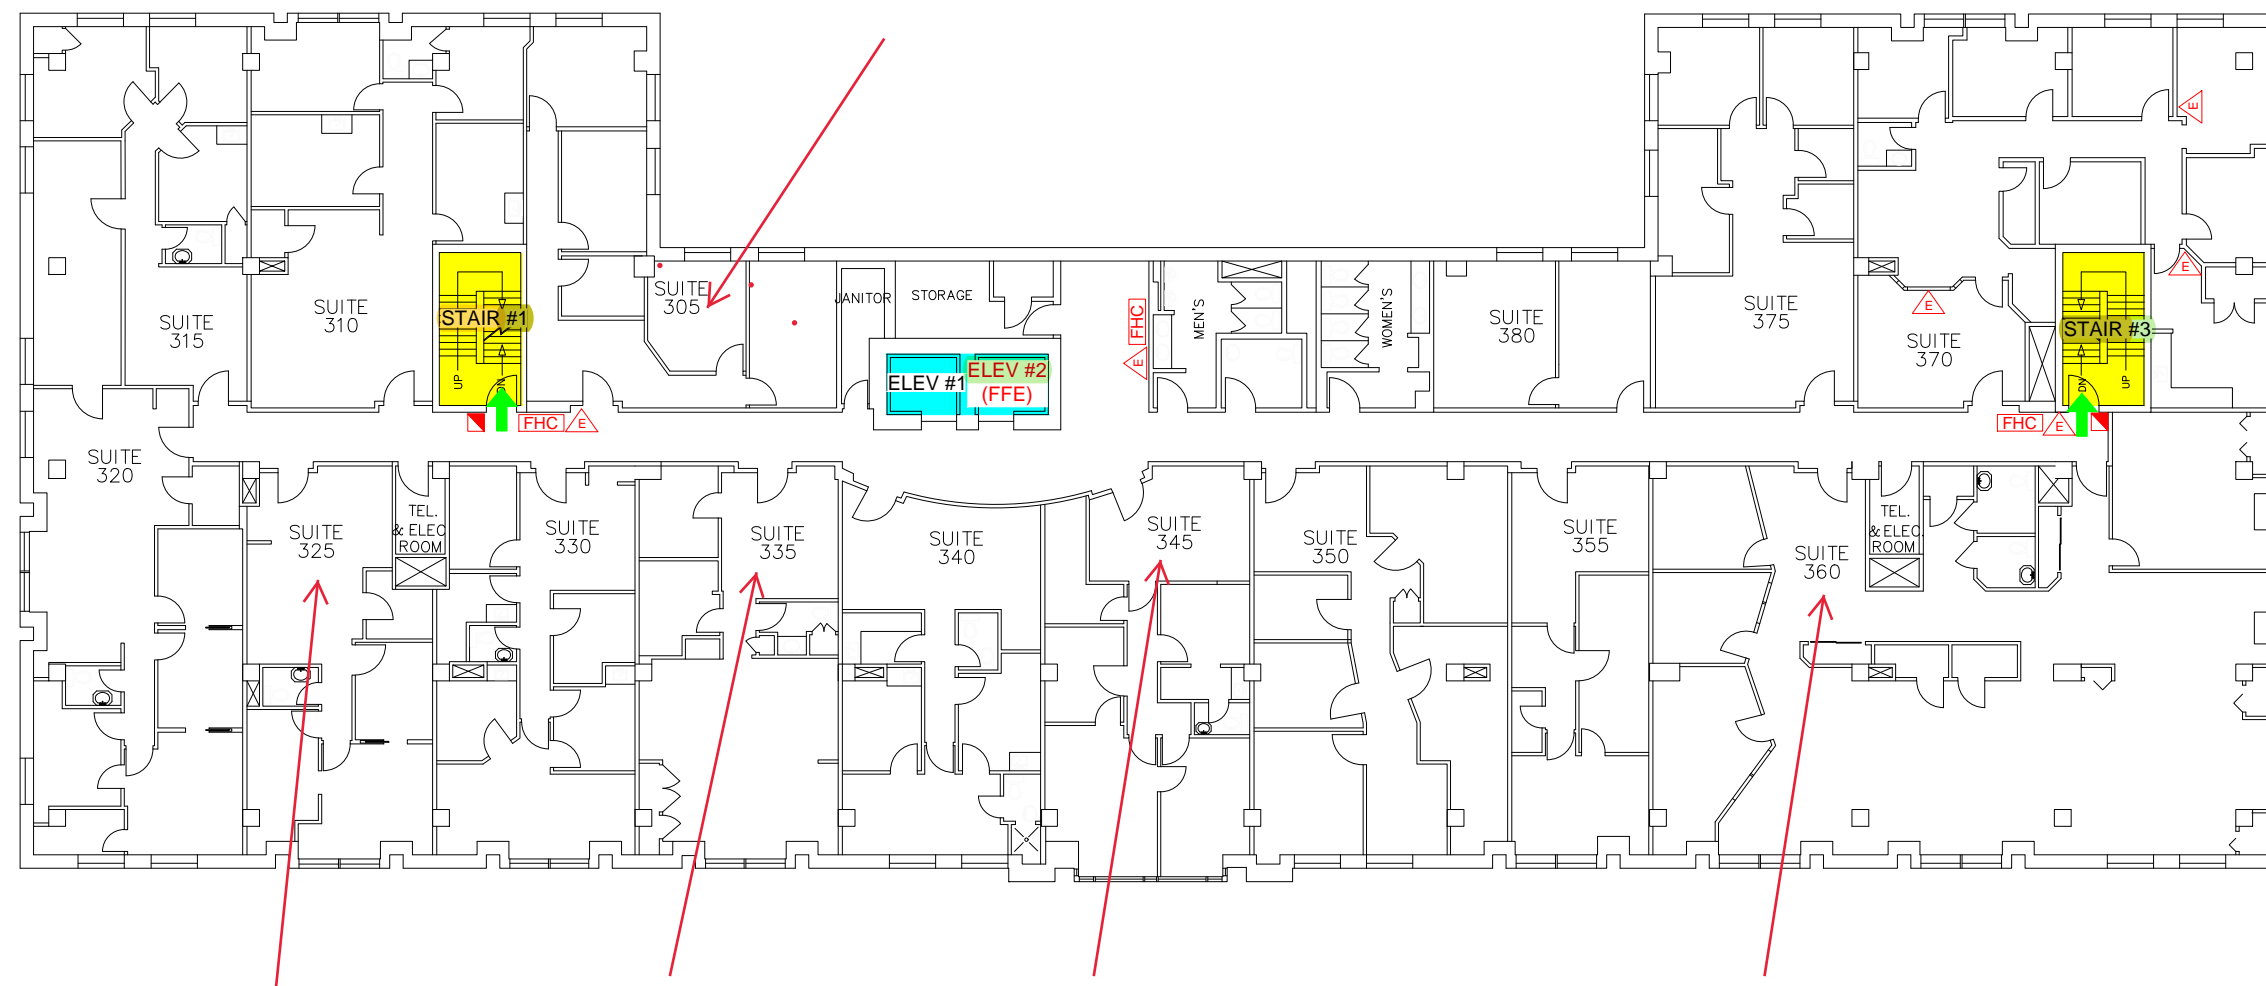


**LEGEND**

-  MANUAL PULL STATION
-  ELECTROMAGNETIC LOCKING DEVICE
-  SMOKE DETECTOR
-  HEAT DETECTOR
-  FIRE PUMP
-  FIRE EXTINGUISHER
-  FIRE HOSE CABINET
-  SP STANDPIPE SYSTEM RISER
-  DRY SPRINKLER RISER
-  WET SPRINKLER RISER
-  FIRE SAFETY PLAN BOX
-  AP FIRE ALARM ANNUNCIATOR PANEL
-  CP FIRE ALARM CONTROL PANEL
-  BUILDING / FLOOR EXIT
-  EXIT STAIR SHAFT
-  ELEVATOR SHAFT



PROJECT  
**340 COLLEGE STREET**  
 340 COLLEGE STREET  
 TORONTO ONTARIO

TITLE  
**THIRD FLOOR**

**FIRE SAFETY PLAN**

DRAWN BY S.Z.	CHECKED BY B.L.	SHEET 07 of 11
OCT 2021	DWG NO. <b>FSP-7</b>	
4T1911530		
NTS		

REV/DATE: FILE NAME: Y:\Shared\Legacy\CAM\TOR\Proj\2019\Design\Drawings\4T1911530\_340\_College\_SL\_FSP\_Update\00\_Working\_Docs\Drawings\4T1911530\_RB\_340\_College\_SL\_FSP\_Dwg.dwg LAYOUT NAME: FSP-7 PLOTTED: Friday, October 29, 2021 - 11:37pm