



Copyright © Pemco Group Inc. 2015
 All Rights Reserved. No part of this
 Drawing may be reproduced or used
 without Pemco Group Inc.'s express
 written consent.

PEMCO

GROUP
 217 MONTGOMERY ST.
 SYRACUSE, NEW YORK 13202
 PHONE: 315-476-1273
 FAX: 315-476-1283

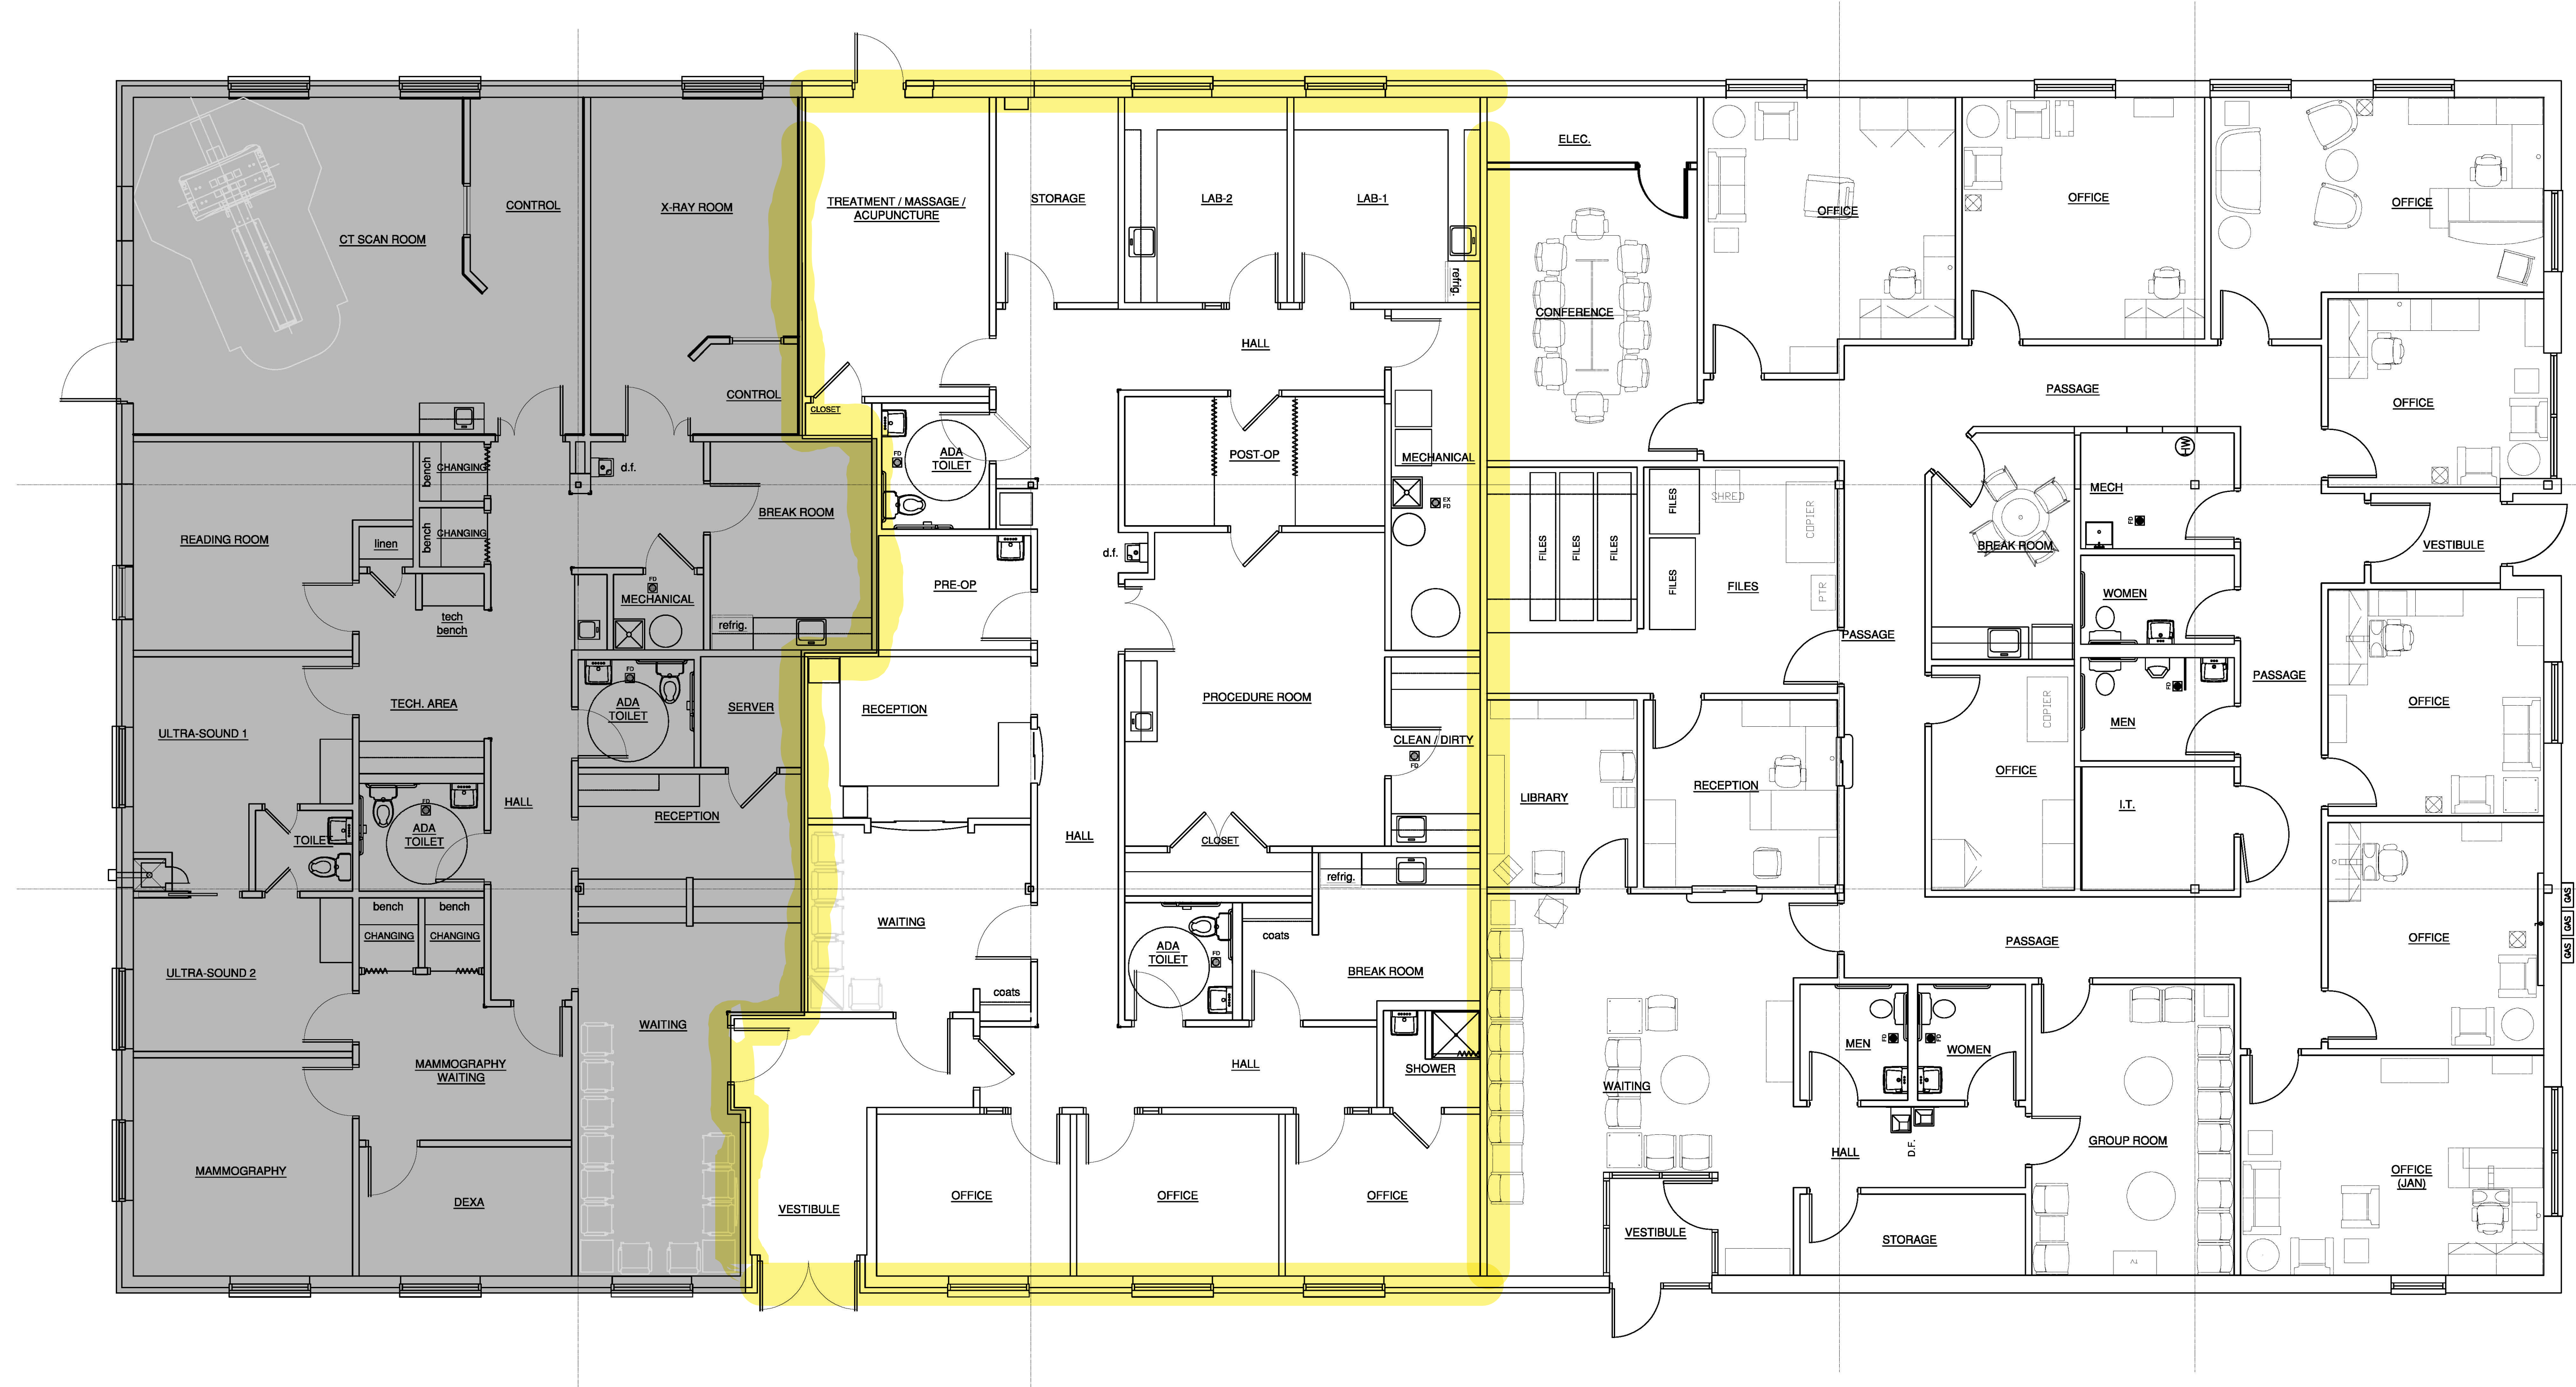

TENANT IMPROVEMENT FOR:
 109 PINE STREET
 SYRACUSE, NEW YORK 13210

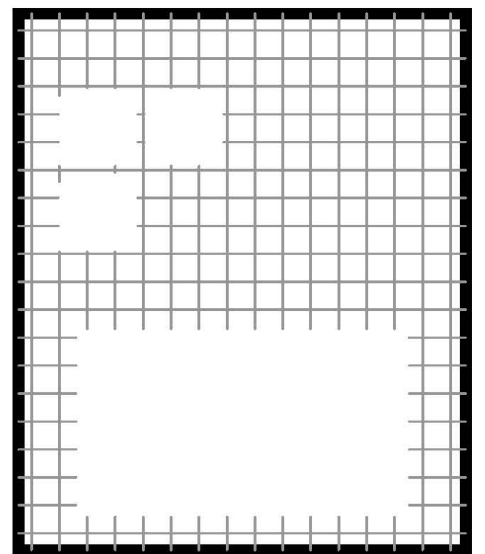

JOB NUM:	15117
DRAWN BY:	RR
CHECKED:	PC
DATE:	08-20-15
REVISIONS:	08-25-15

DRAWING TITLE
 FLOOR PLAN
 SHEET NUMBER
A-2
 A:2 FLOOR PLAN

FLOOR PLAN SCALE: 3/16" = 1'-0"