


1 Partial Reflective Ceiling Plan - B2 (EC), 1/8" = 1'-0"

	Sprinkler System - Schematic Layout. Confirm Existing Sprinkler Heads, Lines, and Equipment in the Field.
	Dropped Sprinkler System - Schematic Layout. Confirm Existing Sprinkler Heads, Lines, and Equipment in the Field.
	96" - 2 Bulb Surface Mount Fluorescent Lighting Fixture w/ Acrylic Lense
	24" - HVAC Supply Register
	24" - HVAC Return Register
	24" x 48" Suspended Acoustic Ceiling System
	24" x 48" Recessed Fluorescent Lighting Fixture w/ Parabolic Lense
	New & Relocated Fixtures are Hatched & Designated as New


2 Ceiling Legend, nts

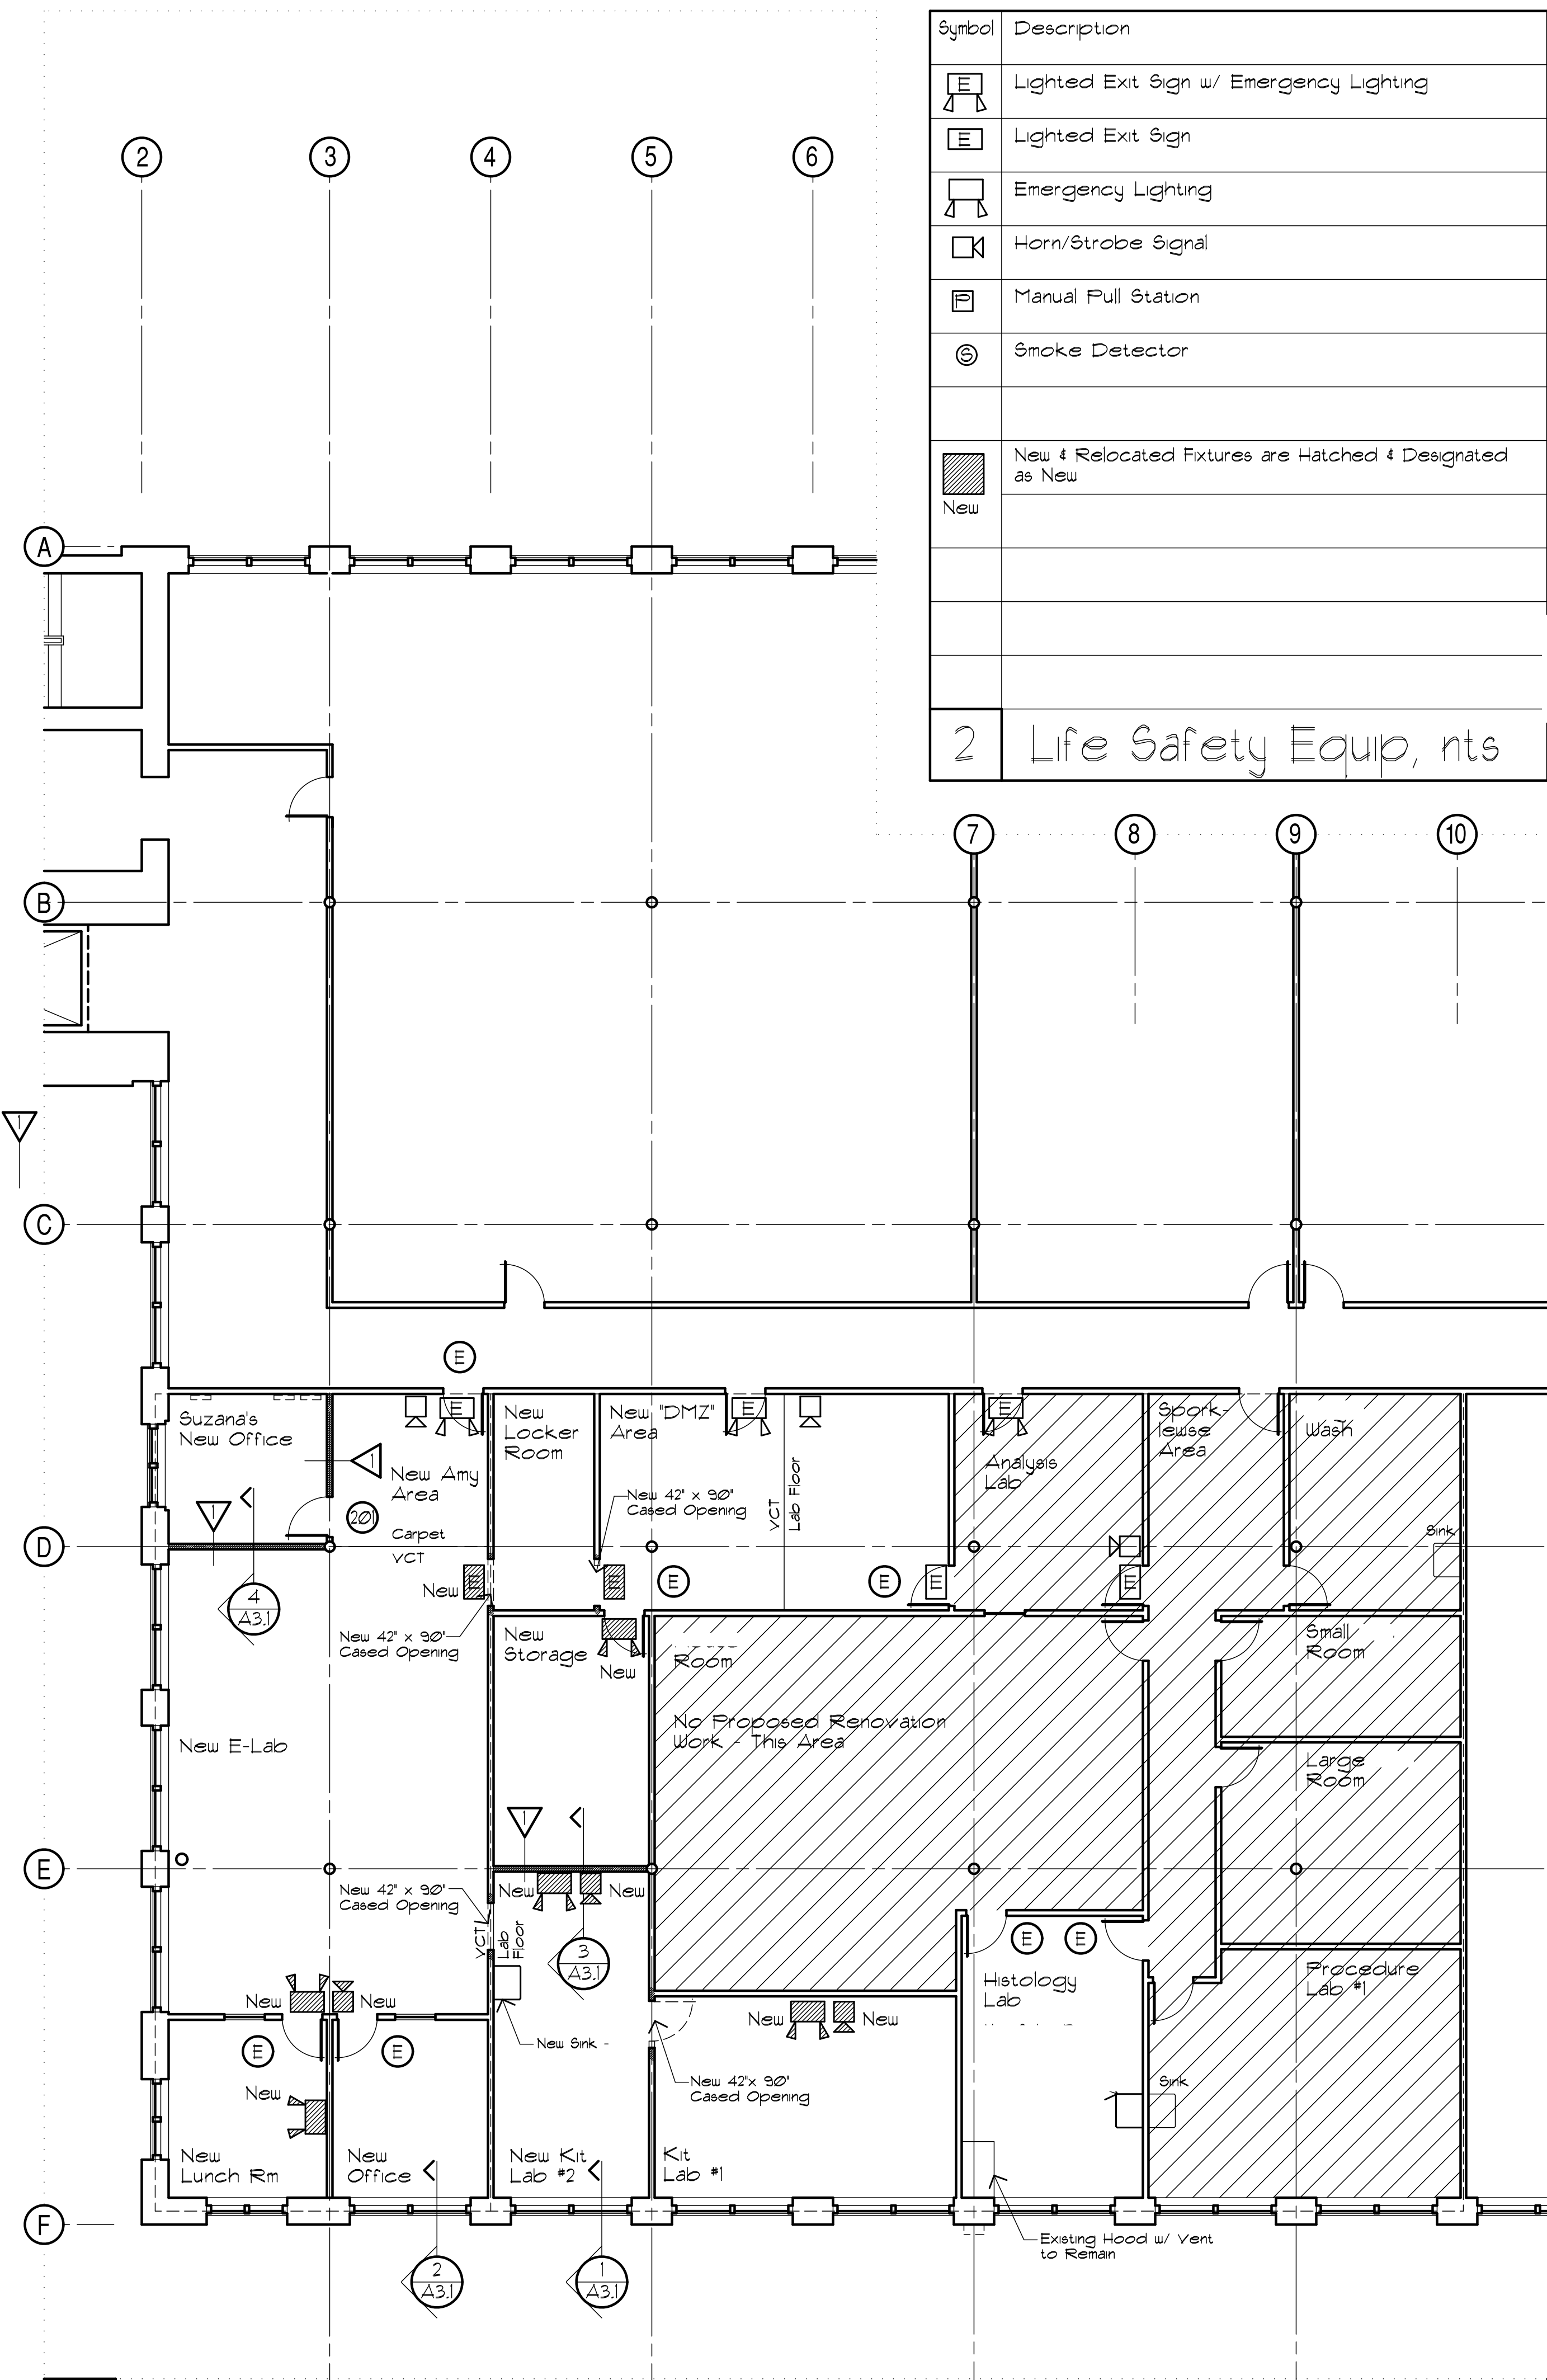

1 Partial Second Floor Plan - B2 (EC), 1/8" = 1'-0"

Symbol	Description
	Lighted Exit Sign w/ Emergency Lighting
	Lighted Exit Sign
	Emergency Lighting
	Horn/Strobe Signal
	Manual Pull Station
	Smoke Detector
	New & Relocated Fixtures are Hatched & Designated as New

2 Life Safety Equip, nts

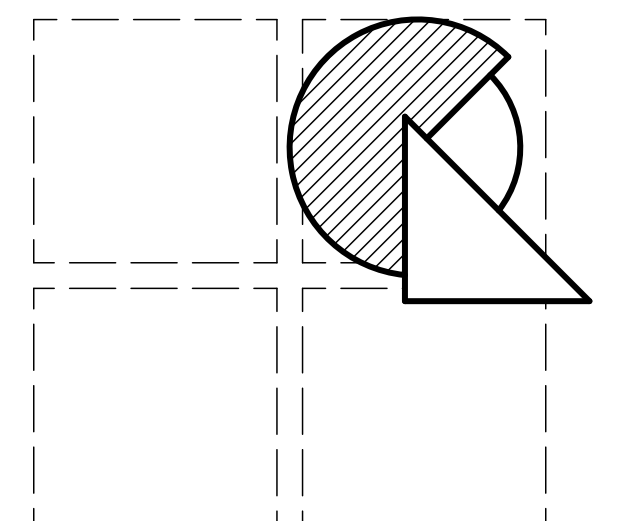

R. Rumpf & Associates, Inc.  
 Engineering & Architecture  
 P.O. Box 4483  
 75 North Street  
 Salem, Massachusetts 01970-4483

(978) 740-5025  
 (978) 740-5026 fax

Consultants:



Job Number:  
 rra 15-095


Date:  
 12/07/15

No.	Date	Revision	By:

Project:

Second Floor  
 Suite 210  
 7,338 RSF

Heritage Place - B2-F2  
 439 South Union Street  
 Lawrence, MA

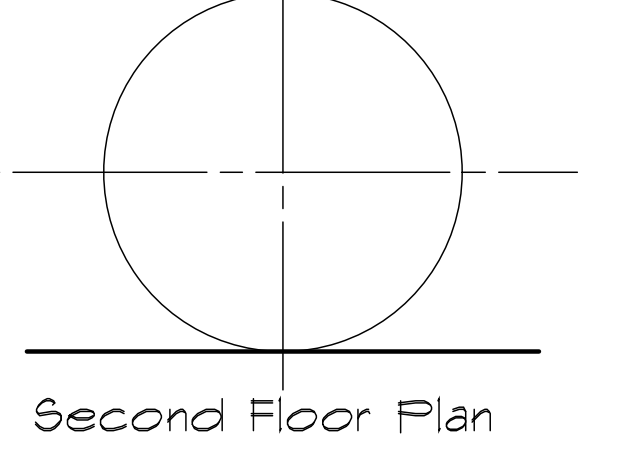

Second Floor Plan

Scale:  
 as noted

Drawing Number:

**A1.1**