



225 n 7th street
Philadelphia, pa 19122
doarch.com
67.324.3601

PROJECT ADDRESS

1222 N 2ND ST.
PHILADELPHIA, PA

CONSULTANTS:

AL:



© 1999 HARMAN DEUTSCH OHLER ARCHITECTURE.
ALL RIGHTS RESERVED.

CONSULTANTS:

[illegible]

MAN DEUTSCH CHILER ARCHITECTURE HEREBY
SERVES ITS COMMON LAW COPYRIGHT AND ALL
PROPERTY RIGHTS IN THESE DRAWINGS, IDEAS AND
DESIGNS. THE INFORMATION ON THIS SHEET IS NOT
TO BE REPRODUCED, MODIFIED OR COPIED IN ANY
MANNER. THE INFORMATION ON THIS SHEET IS NOT
TO BE ASSIGNED TO ANY THIRD PARTY WITHOUT THE
EXPRESSED WRITTEN CONSENT OF HARMAN
MAN DEUTSCH CHILER ARCHITECTURE.

DRAWINGS PREPARED BY: _____


 DRAWINGS CHECKED BY: _____

 DRAWING TITLE: _____

RST FLOOR PLAN

DRAWING NUMBER:

A1.01

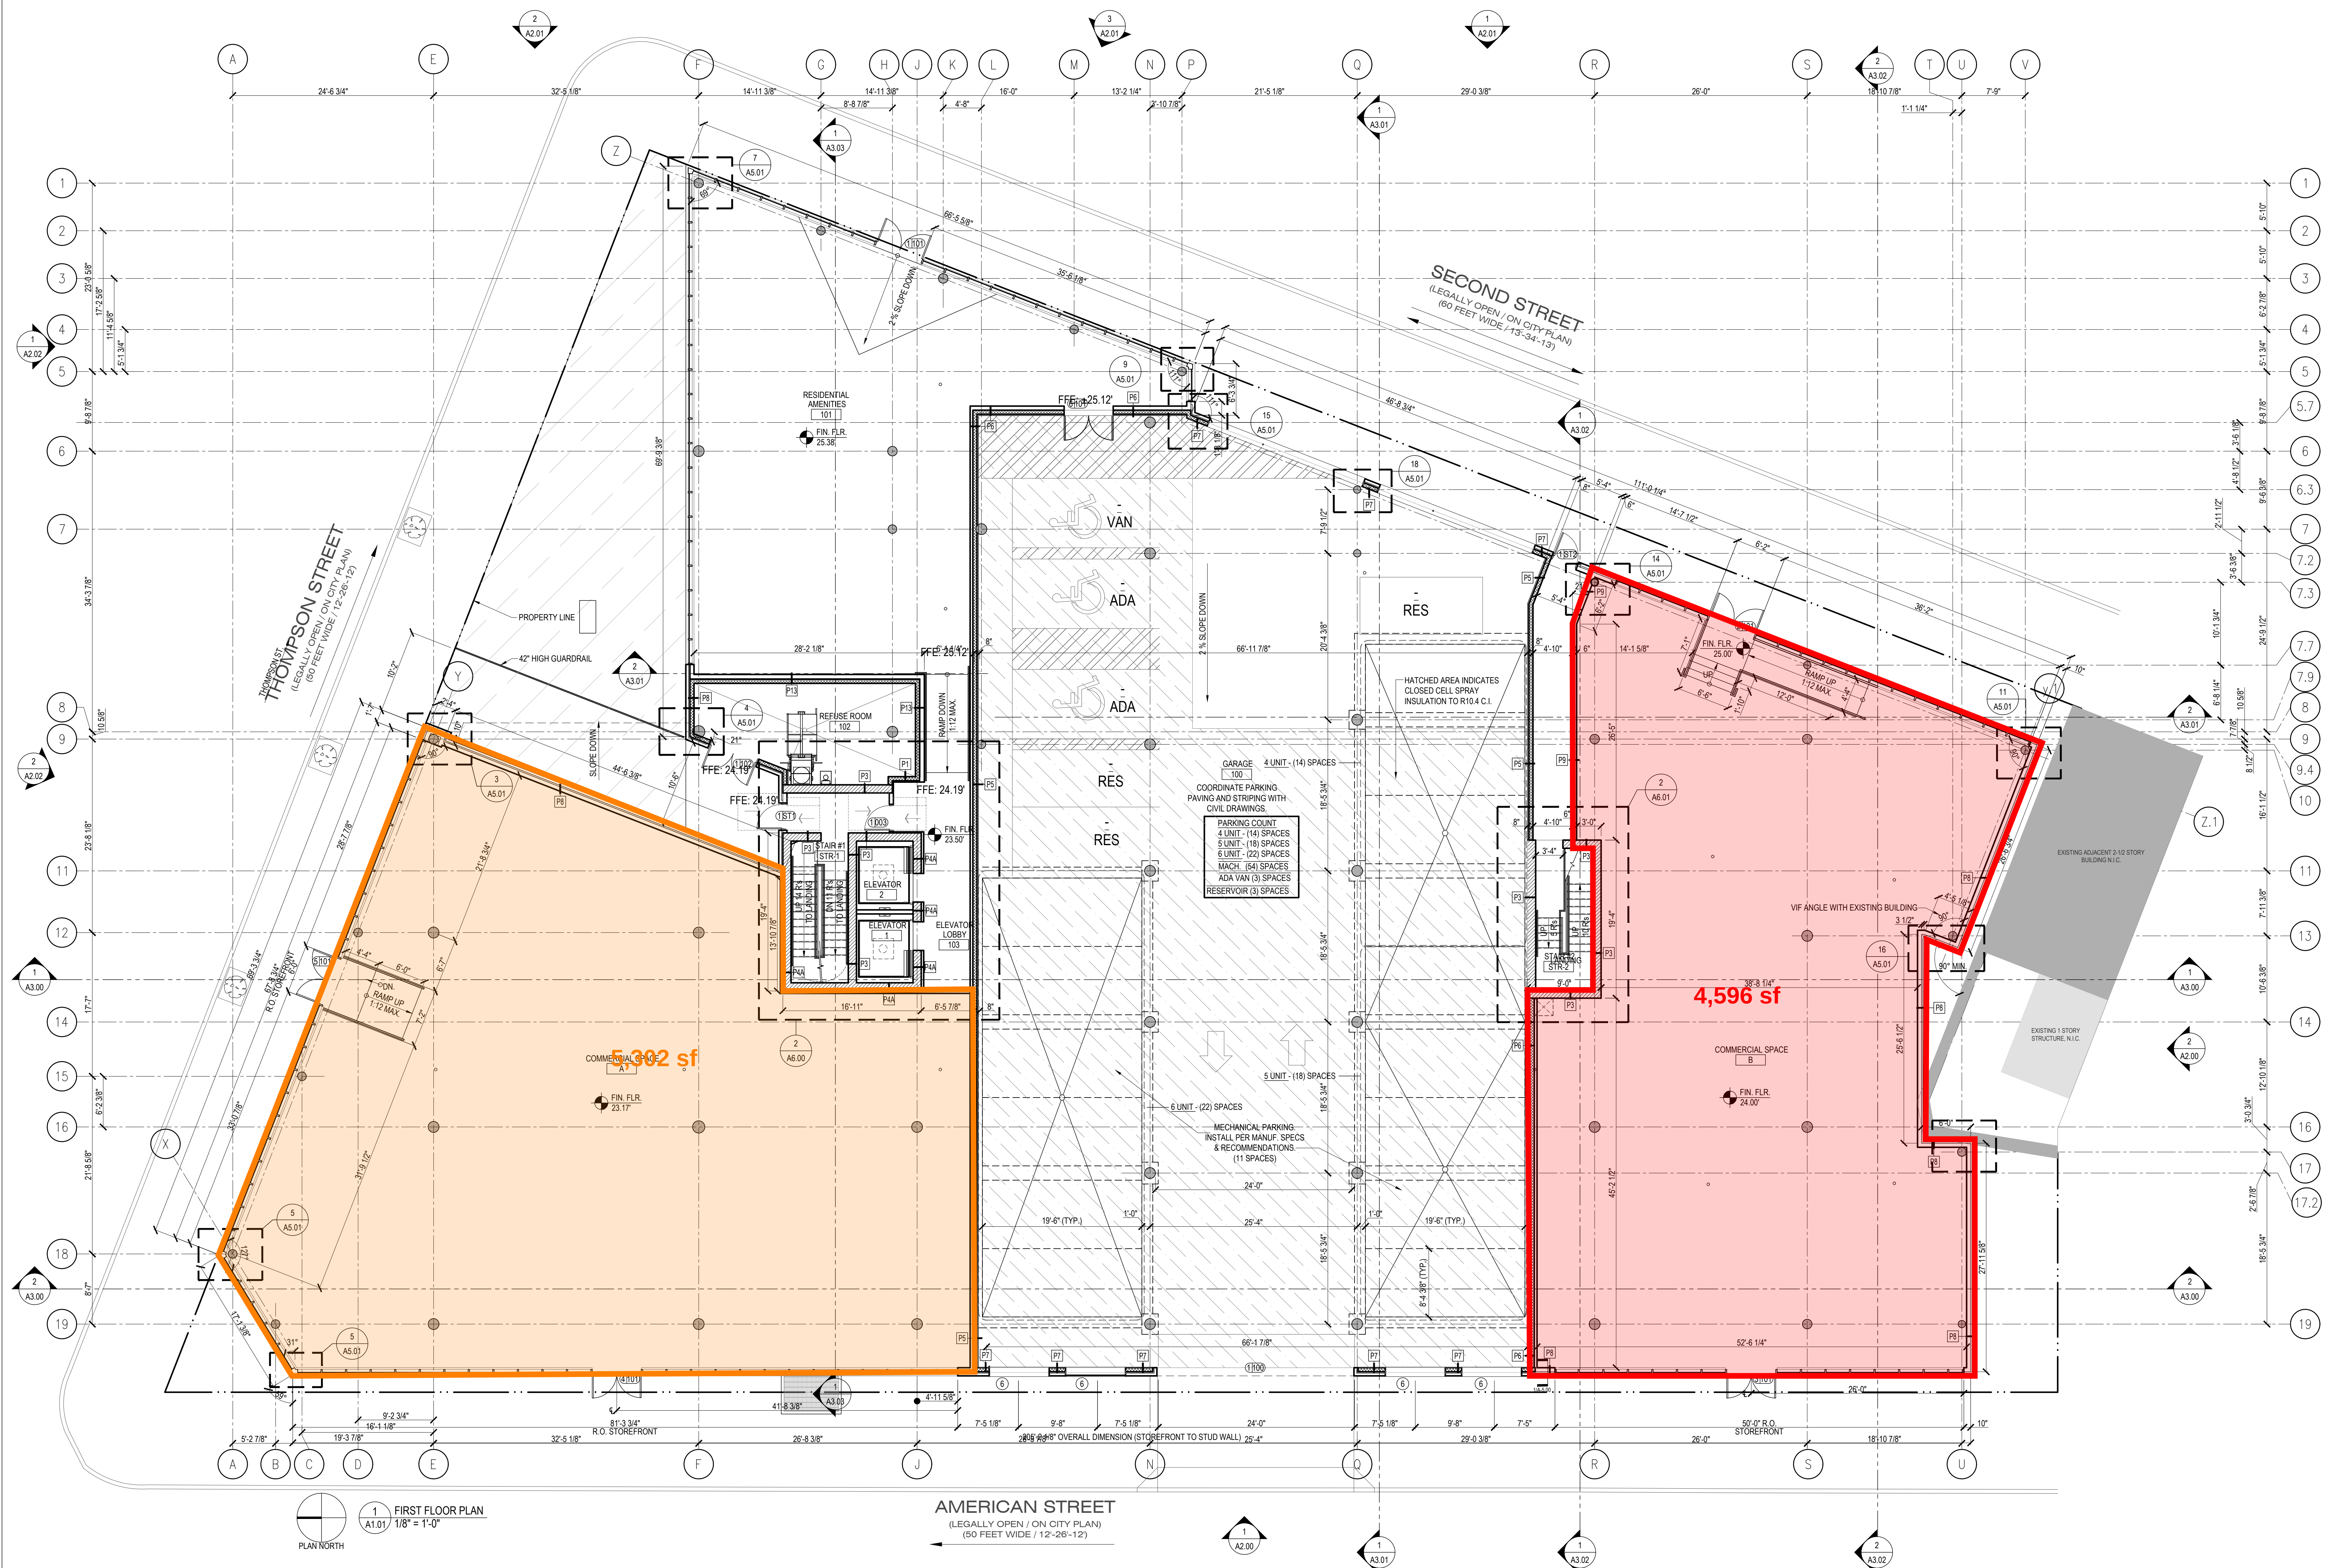

KEYED PLAN NOTES

- | | |
|---|--|
| <p>① FLOOR DRAIN. SLOPE CONC. SLAB TO DRAIN & TIE TO STORM SEWER.</p> <p>② TRENCH/STORM DRAIN, TIE TO STORM SEWER. SEE CIVIL.</p> <p>③ PRE-MANUFACTURED METAL EGRESS LADDER, INSTALL PER MANUF. SPECS.</p> <p>④ 6" Ø 4'-0" WALKABLE / OPERABLE STEEL GRATE FLUSH W/ FINISHED SIDEWALK.</p> <p>⑤ TRASH COMPACTOR EQUIPMENT, INSTALL PER MANUF. SPECS AND RECOMMENDATIONS.</p> <p>⑥ MECHANICAL LOUVER VENT. REFER TO EXTERIOR ELEVATIONS SHEET A2.XX</p> <p>⑦ PROVIDE MECHANICAL CURB. SEE DETAIL X1A.XX</p> <p>⑧ TRASH CHUTE VENT. SEE DETAIL X1A.XX</p> <p>⑨ PROVIDE GUTTER EXTENT OF ROOF & 4" DOWNSPOUT.</p> <p>⑩ 12" WIDE GREEN ROOF GRAVEL AT PERIMETER OF BUILDING. COORDINATE WITH GREEN ROOF SUPPLIER.</p> | <p>⑪ HATCH AREA REPRESENTS AREA OF GREEN ROOF. COORDINATE WITH CIVIL DRAWINGS. SEE SHEET X1A.XX FOR SYSTEM DETAIL.</p> |
|---|--|

SYMBOL LEGEND

- | | | |
|--|--|---|
| 
 | <p>SEE WINDOW SCHEDULE ON A0.03. COORDINATE WITH PLANS & ELEVATIONS.</p> <p>SEE PARTITION SCHEDULE ON A0.02.</p> |  <p>ROOF EXHAUST ACTIVE VENT. B.O.D. - ACTIVE VENTILATION PRODUCTS W/ MECH CURB</p> |
| 
 | <p>SEE DOOR SCHEDULE ON A0.03. COORDINATE WITH PLANS & ELEVATIONS.</p> <p>1" DIA. WIND POWER EXHAUST VENT. TO BE CURB MOUNTED. SEE CURB DETAIL A5.02</p> |  <p>RESIDENTIAL CONDENSING UNIT</p> <ul style="list-style-type: none"> - PROVIDE ROOF ISOLATION PAD - PROVIDE TRAP/FIT PADS FOR SERVICE - COORD PLACEMENT AND PENETRATIONS W/ MEP |
|  | <p>1" DIA. ROOF INTAKE VENT. TO BE CURB MOUNTED. SEE CURB DETAIL A5.02</p> <p>1/2" - 1 1/4" ROOF CRICKET</p> |  <p>14"1"1/4" ROOF CRICKET</p> |
|  | <p>ROOF INTAKE POP VENT. B.O.D. - ACTIVE VENTILATION PRODUCTS W/ MECH CURB</p> | <p>R.D.</p> <p>ROOF DRAIN</p> |