


NEW UNION SQUARE

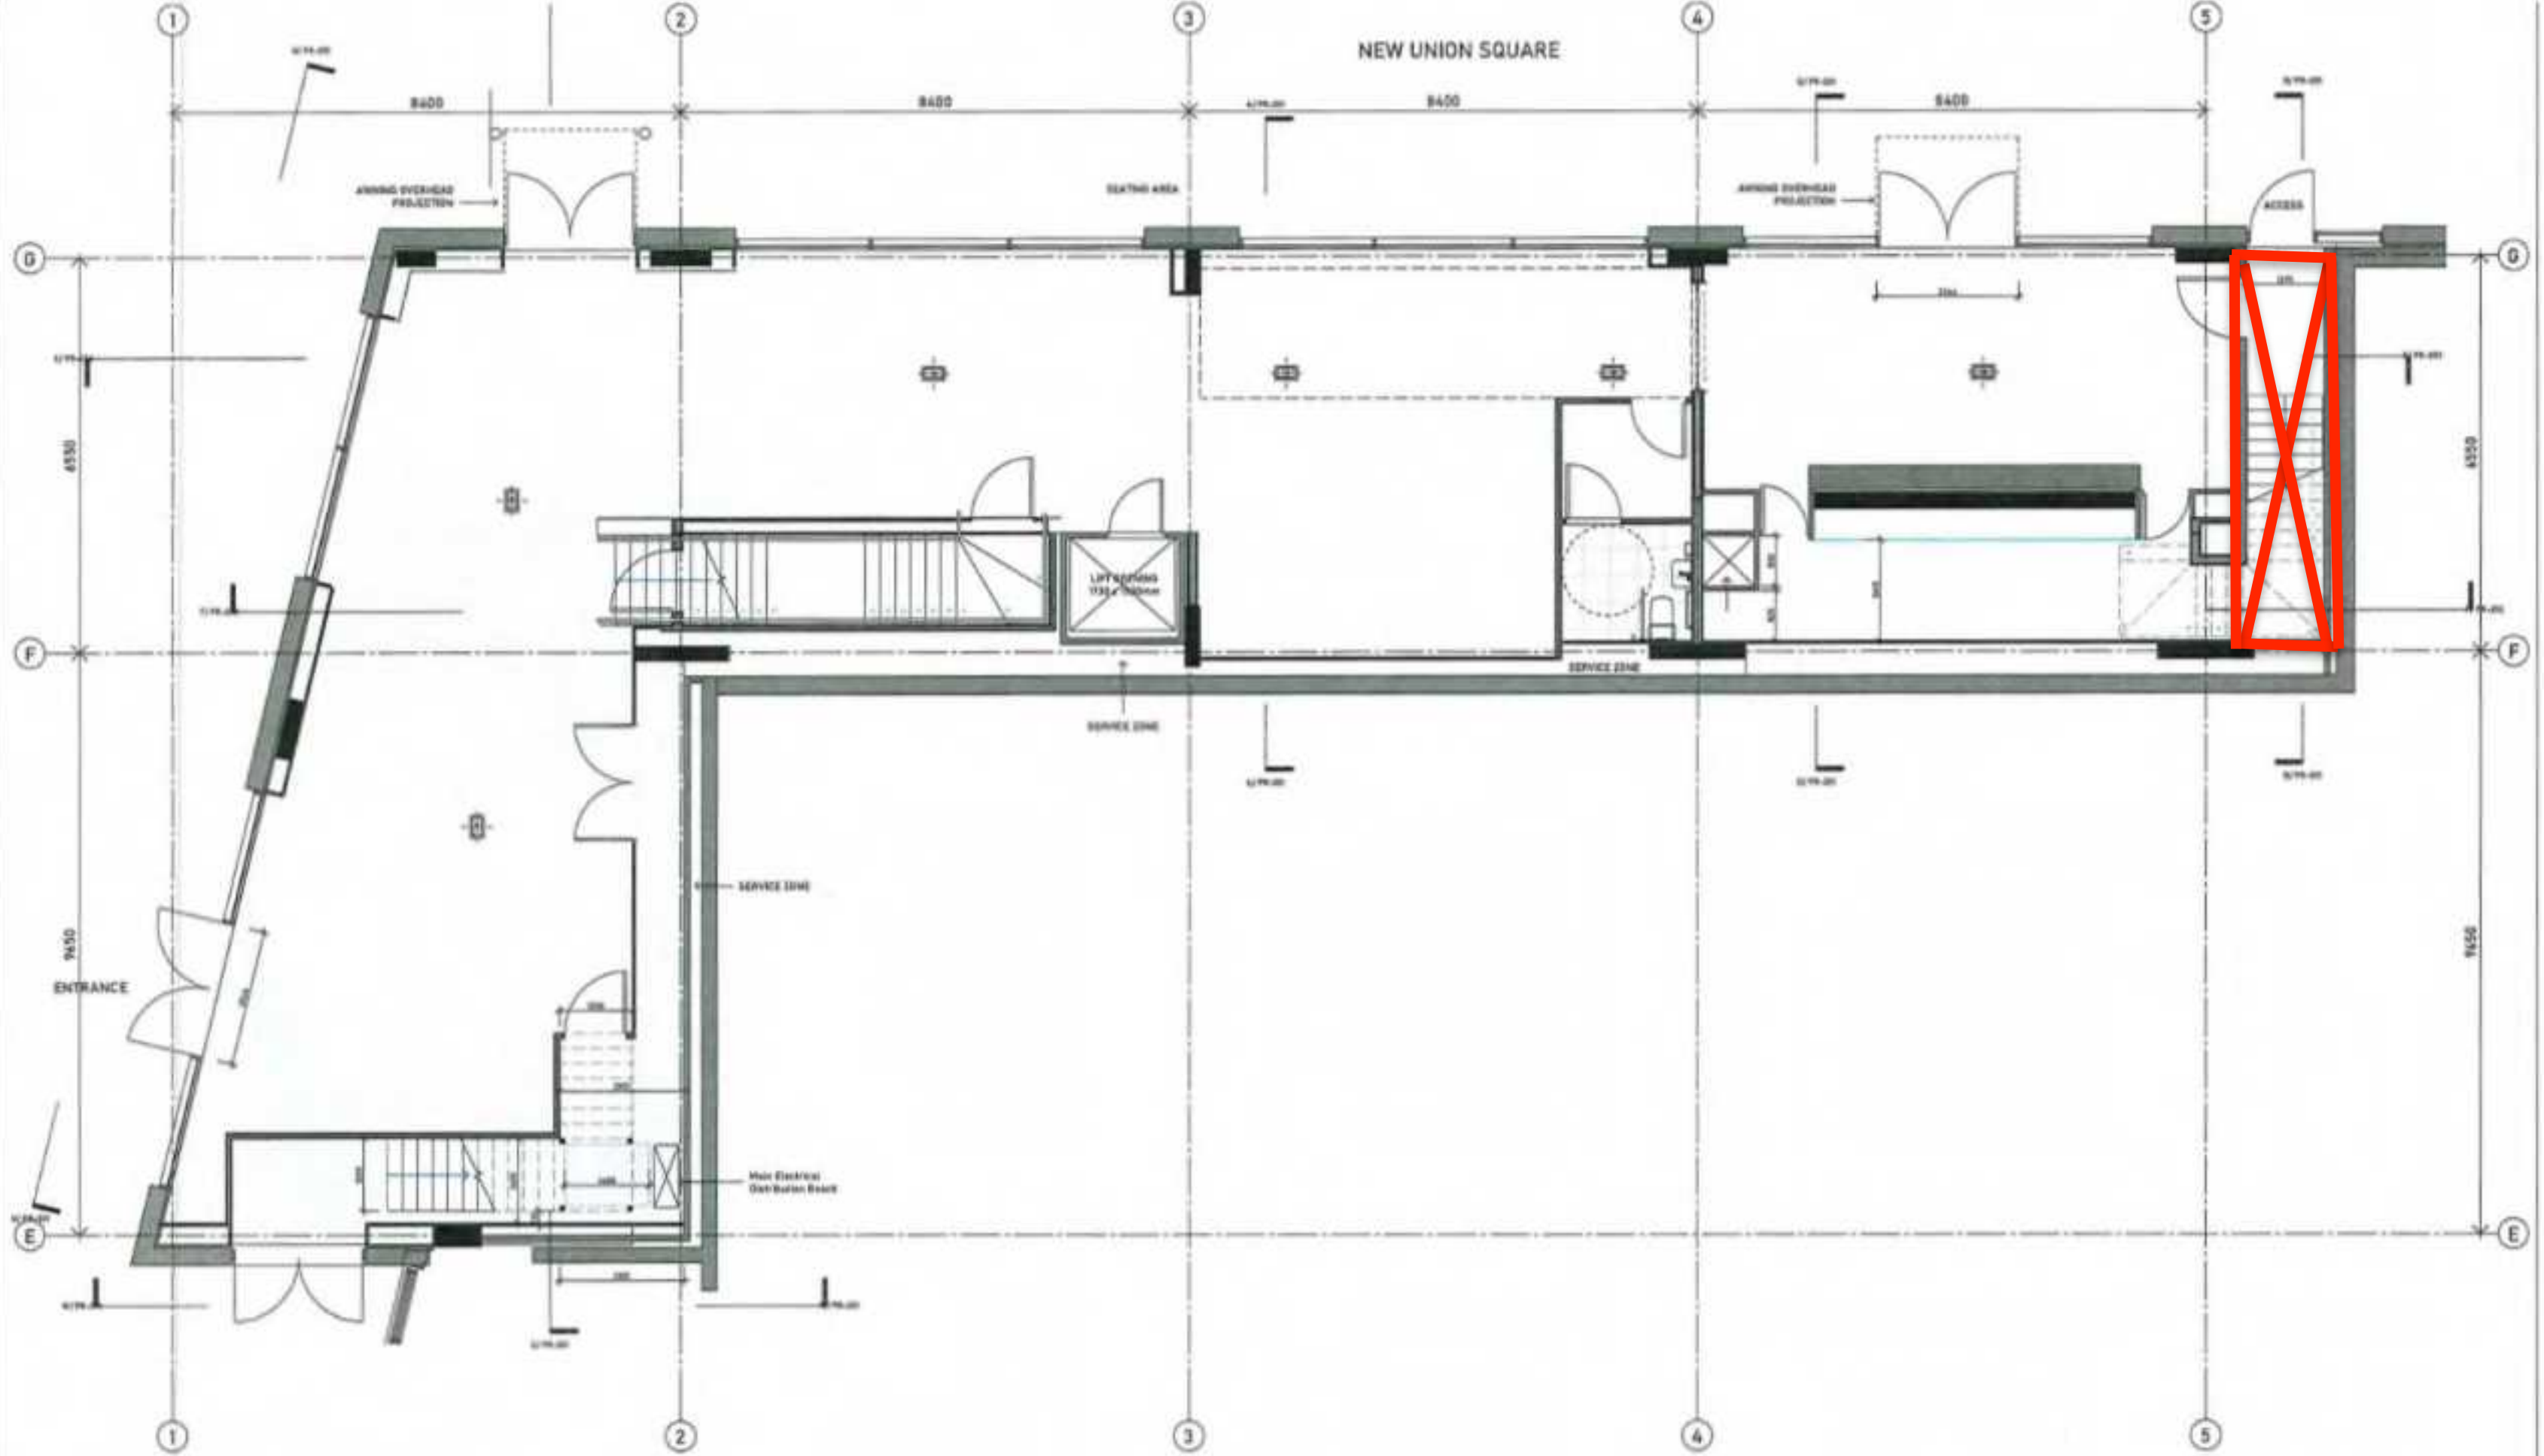


GA PLAN - LEVEL 0F

- 1. All work shall be done in accordance with the approved contract documents.
- 2. The contractor shall be responsible for obtaining all necessary permits and approvals.
- 3. The contractor shall maintain access to all existing services and utilities.
- 4. The contractor shall protect all existing work and materials.
- 5. The contractor shall maintain a clean and safe work site.
- 6. The contractor shall comply with all applicable laws and regulations.
- 7. The contractor shall provide a detailed schedule of work.
- 8. The contractor shall provide a detailed cost estimate.
- 9. The contractor shall provide a detailed risk assessment.
- 10. The contractor shall provide a detailed quality control plan.

- 11. The contractor shall provide a detailed safety plan.
- 12. The contractor shall provide a detailed environmental protection plan.
- 13. The contractor shall provide a detailed communication plan.
- 14. The contractor shall provide a detailed stakeholder engagement plan.
- 15. The contractor shall provide a detailed risk management plan.
- 16. The contractor shall provide a detailed quality assurance plan.
- 17. The contractor shall provide a detailed project management plan.
- 18. The contractor shall provide a detailed financial management plan.
- 19. The contractor shall provide a detailed human resources management plan.
- 20. The contractor shall provide a detailed information management plan.

Notes:
 1. The drawing is for information only and is not to be used for construction.
 2. The contractor shall be responsible for obtaining all necessary permits and approvals.
 3. The contractor shall maintain access to all existing services and utilities.

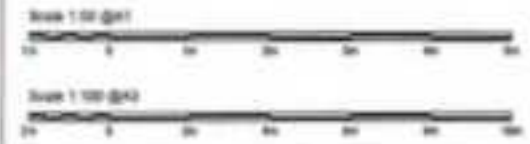

<p>EPA Small Scale Architects - Partners</p> <p>11 West 10th Street Suite 100 New York, NY 10011</p> <p>Phone: (212) 512-1234 Fax: (212) 512-1235 Email: info@epa.com</p>	Date: 10/15/2023 Scale: 1:50 @ 1/8" = 1'-0" Title: GA PLAN - LEVEL 0F Project: PR-101
	Author: [Name] Designer: [Name]
	Checker: [Name] Approver: [Name]
	Date: 10/15/2023

