 
 
 






DRAWING LEGEND


-  NEW PARTITION WALL
2 HOUR FIRE RATED.
(SEE DETAIL A)
-  NEW PARTITION WALL
1 HOUR FIRE RATED.
(SEE DETAIL B)
-  EXISTG WALL
-  EXISTG DOORS
-  PROPERTY LINE (AS SHOWN)
-  100 CFM
(AS SHOWN)
-  NEW EXIT SIGN WITH 2 LAMP
EMERGENCY LIGHT

REVISIONS

 BIS JOB NUMBER:

No.	DATE

Anthony Gurbal PE
NY State License
074142

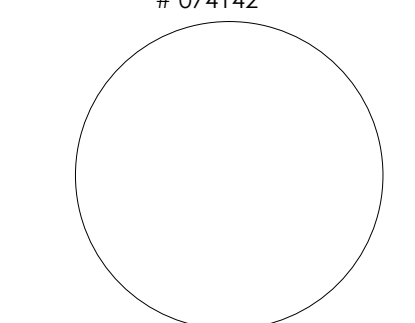

**DRAFT MASTER
ENGINEERING P.C**

35-28 41st STREET
LONG ISLAND CITY NY 11101
TEL : 718-433-2550
FAX: 718-706-6119

PROJECT :

**REFURBISH
EXISTING STORE AND
INSTALLATION OF
PLUMBING FIXTURES**
1320 LOUIS NINE BLVD.
BRONX NY 10459

WORK FLOOR :

FIRST FLOOR

DRAWING TITLE :


PROPOSE
- PARTIAL FIRST FLOOR PLAN

DATE	11/30/2018
PROJECT NO.	1301
DRAWING BY	Z.A
CHECK BY	A.G.
DRAWING NO.	

A-003.00



3 OF 3

APPROVAL PLANS

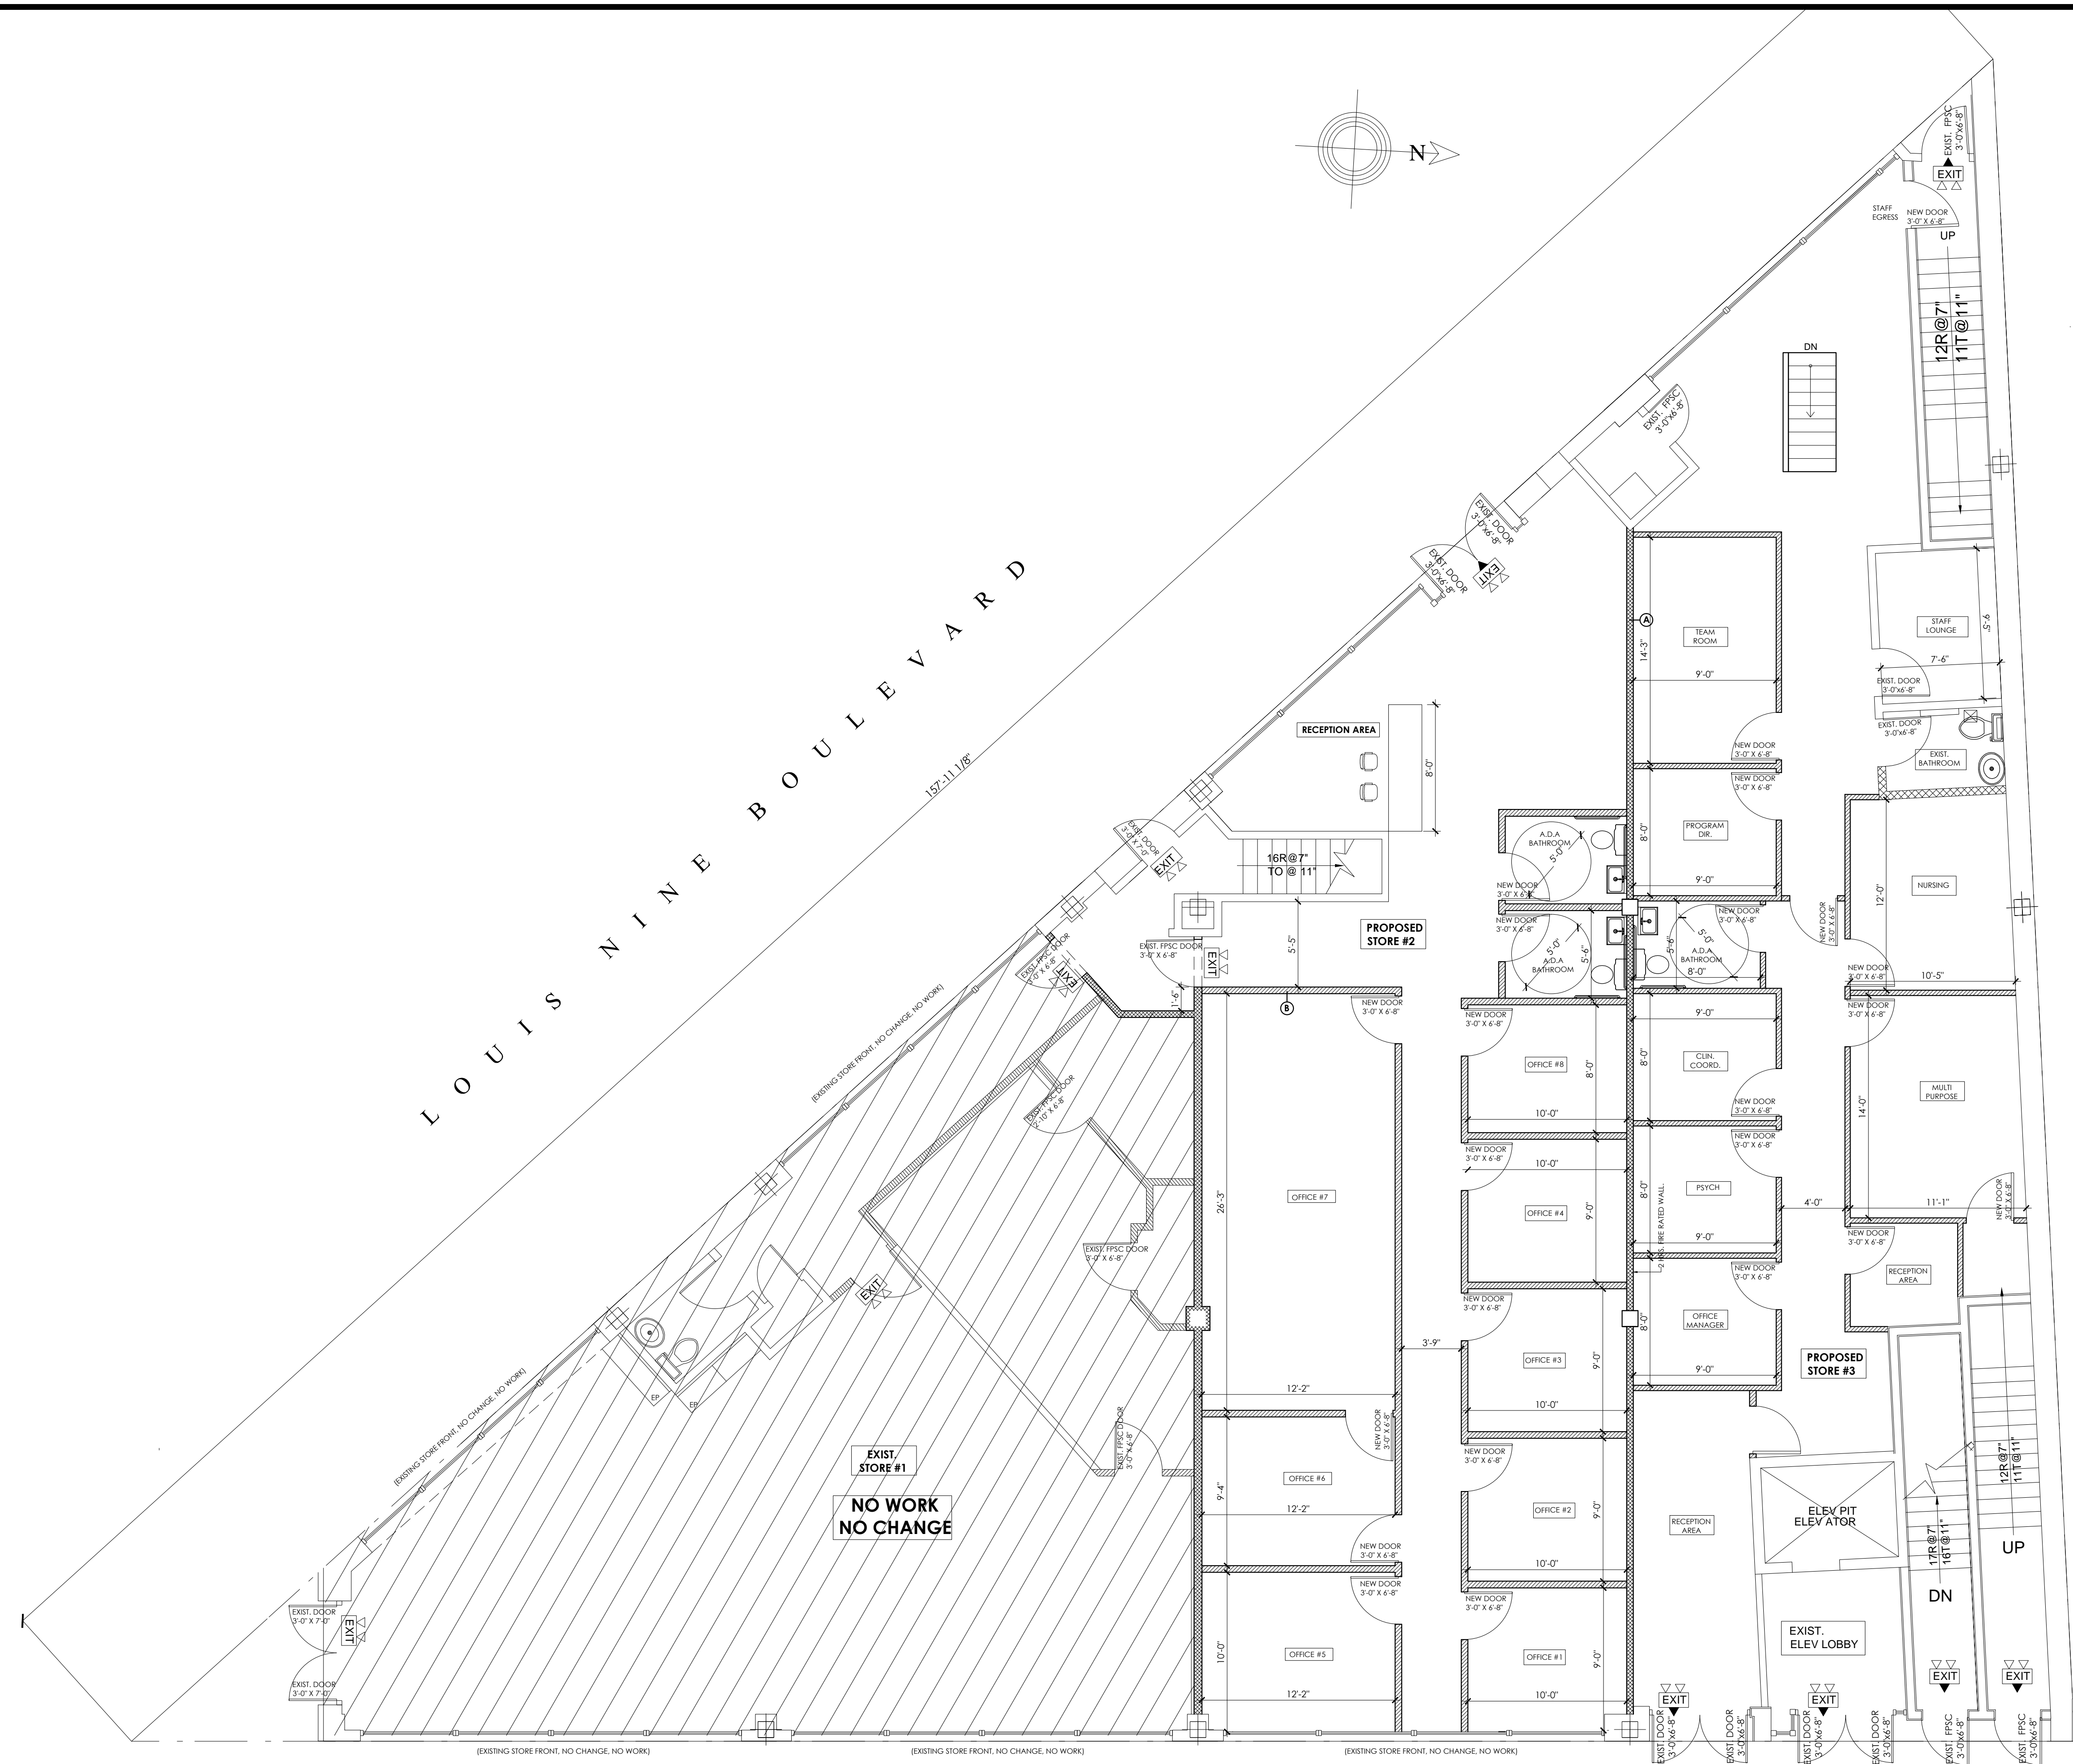

FIRST FLOOR PLAN
SCALE : 3/16"=1'-0"

THE PLAN IS APPROVED ONLY FOR THE WORK INDICATED ON THE APPLICATION. ALL OTHER MATTERS SHOWN ARE NOT TO BE RELIED UPON OR TO BE CONSIDERED AS EITHER BEING APPROVED OR IN ACCORDANCE WITH APPLICABLE CODE.

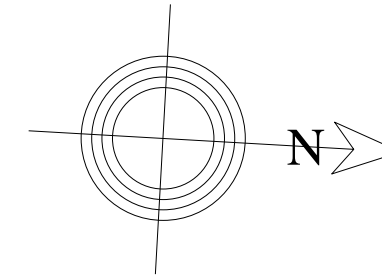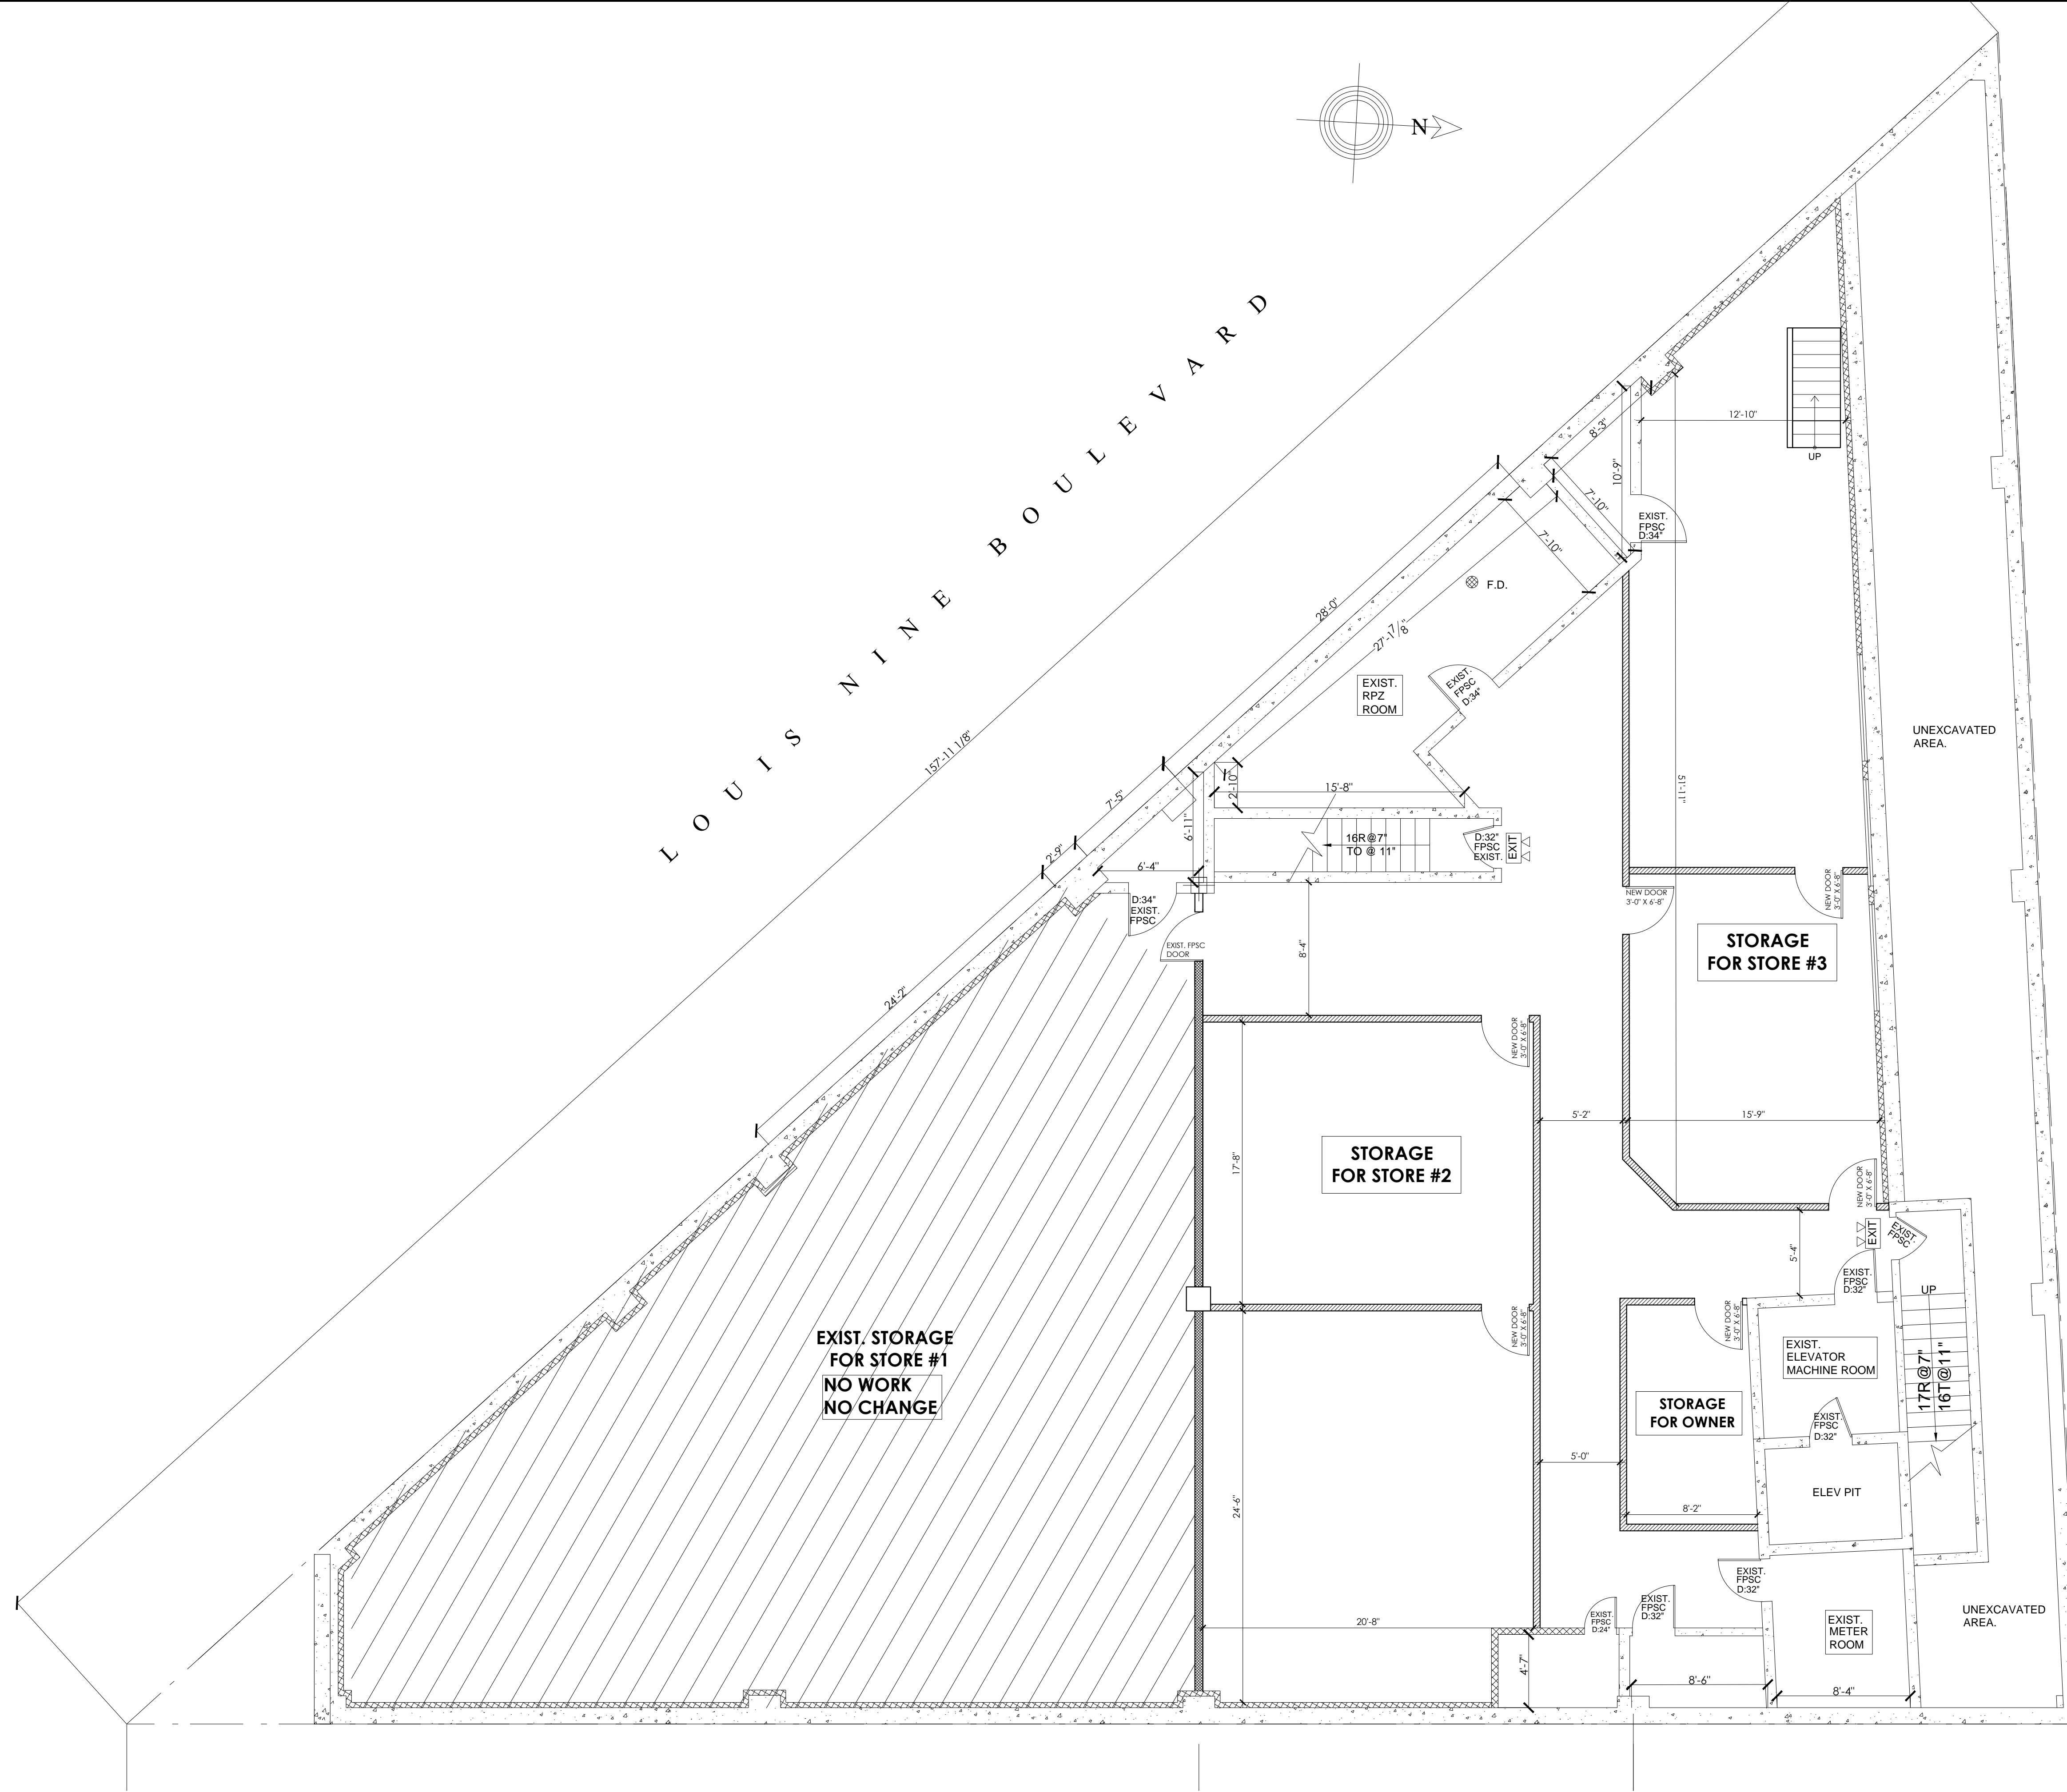

CELLAR PLAN
SCALE: 3/16"=1'-0"

DRAWING LEGEND


- NEW PARTITION WALL 2 HOUR FIRE RATED. (SEE DETAIL A)
- NEW PARTITION WALL 1 HOUR FIRE RATED. (SEE DETAIL B)
- EXIST'G WALL
- EXIST'G DOORS
- PROPERTY LINE (AS SHOWN)
- 100 CFM (AS SHOWN)
- NEW EXIT SIGN WITH 2 LAMP EMERGENCY LIGHT

REVISIONS

BIS JOB NUMBER:

No.	DATE

Anthony Gurball PE
NY State License # 074142

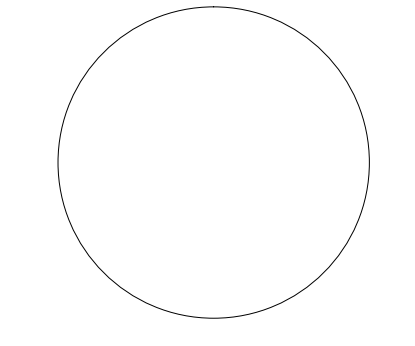

DRAFT MASTER ENGINEERING P.C.

35-28 41st STREET
LONG ISLAND CITY NY 11101
TEL : 718-433-2550
FAX: 718-706-6119

PROJECT :
REFURBISH EXISTING STORE AND INSTALLATION OF PLUMBING FIXTURES
1320 LOUIS NINE BLVD.
BRONX NY 10459

WORK FLOOR :
CELLAR

DRAWING TITLE :
PROPOSE - CELLAR FLOOR PLAN

DATE	11/30/2018
PROJECT NO.	1301
DRAWING BY	Z.A.
CHECK BY	A.G.
DRAWING NO.	A-002.01

A-002.01
2 OF 3

APPROVAL PLANS

THE PLAN IS APPROVED ONLY FOR THE WORK INDICATED ON THE APPLICATION. ALL OTHER MATTERS SHOWN ARE NOT TO BE RELIED UPON OR TO BE CONSIDERED AS EITHER BEING APPROVED OR IN ACCORDANCE WITH APPLICABLE CODE.